

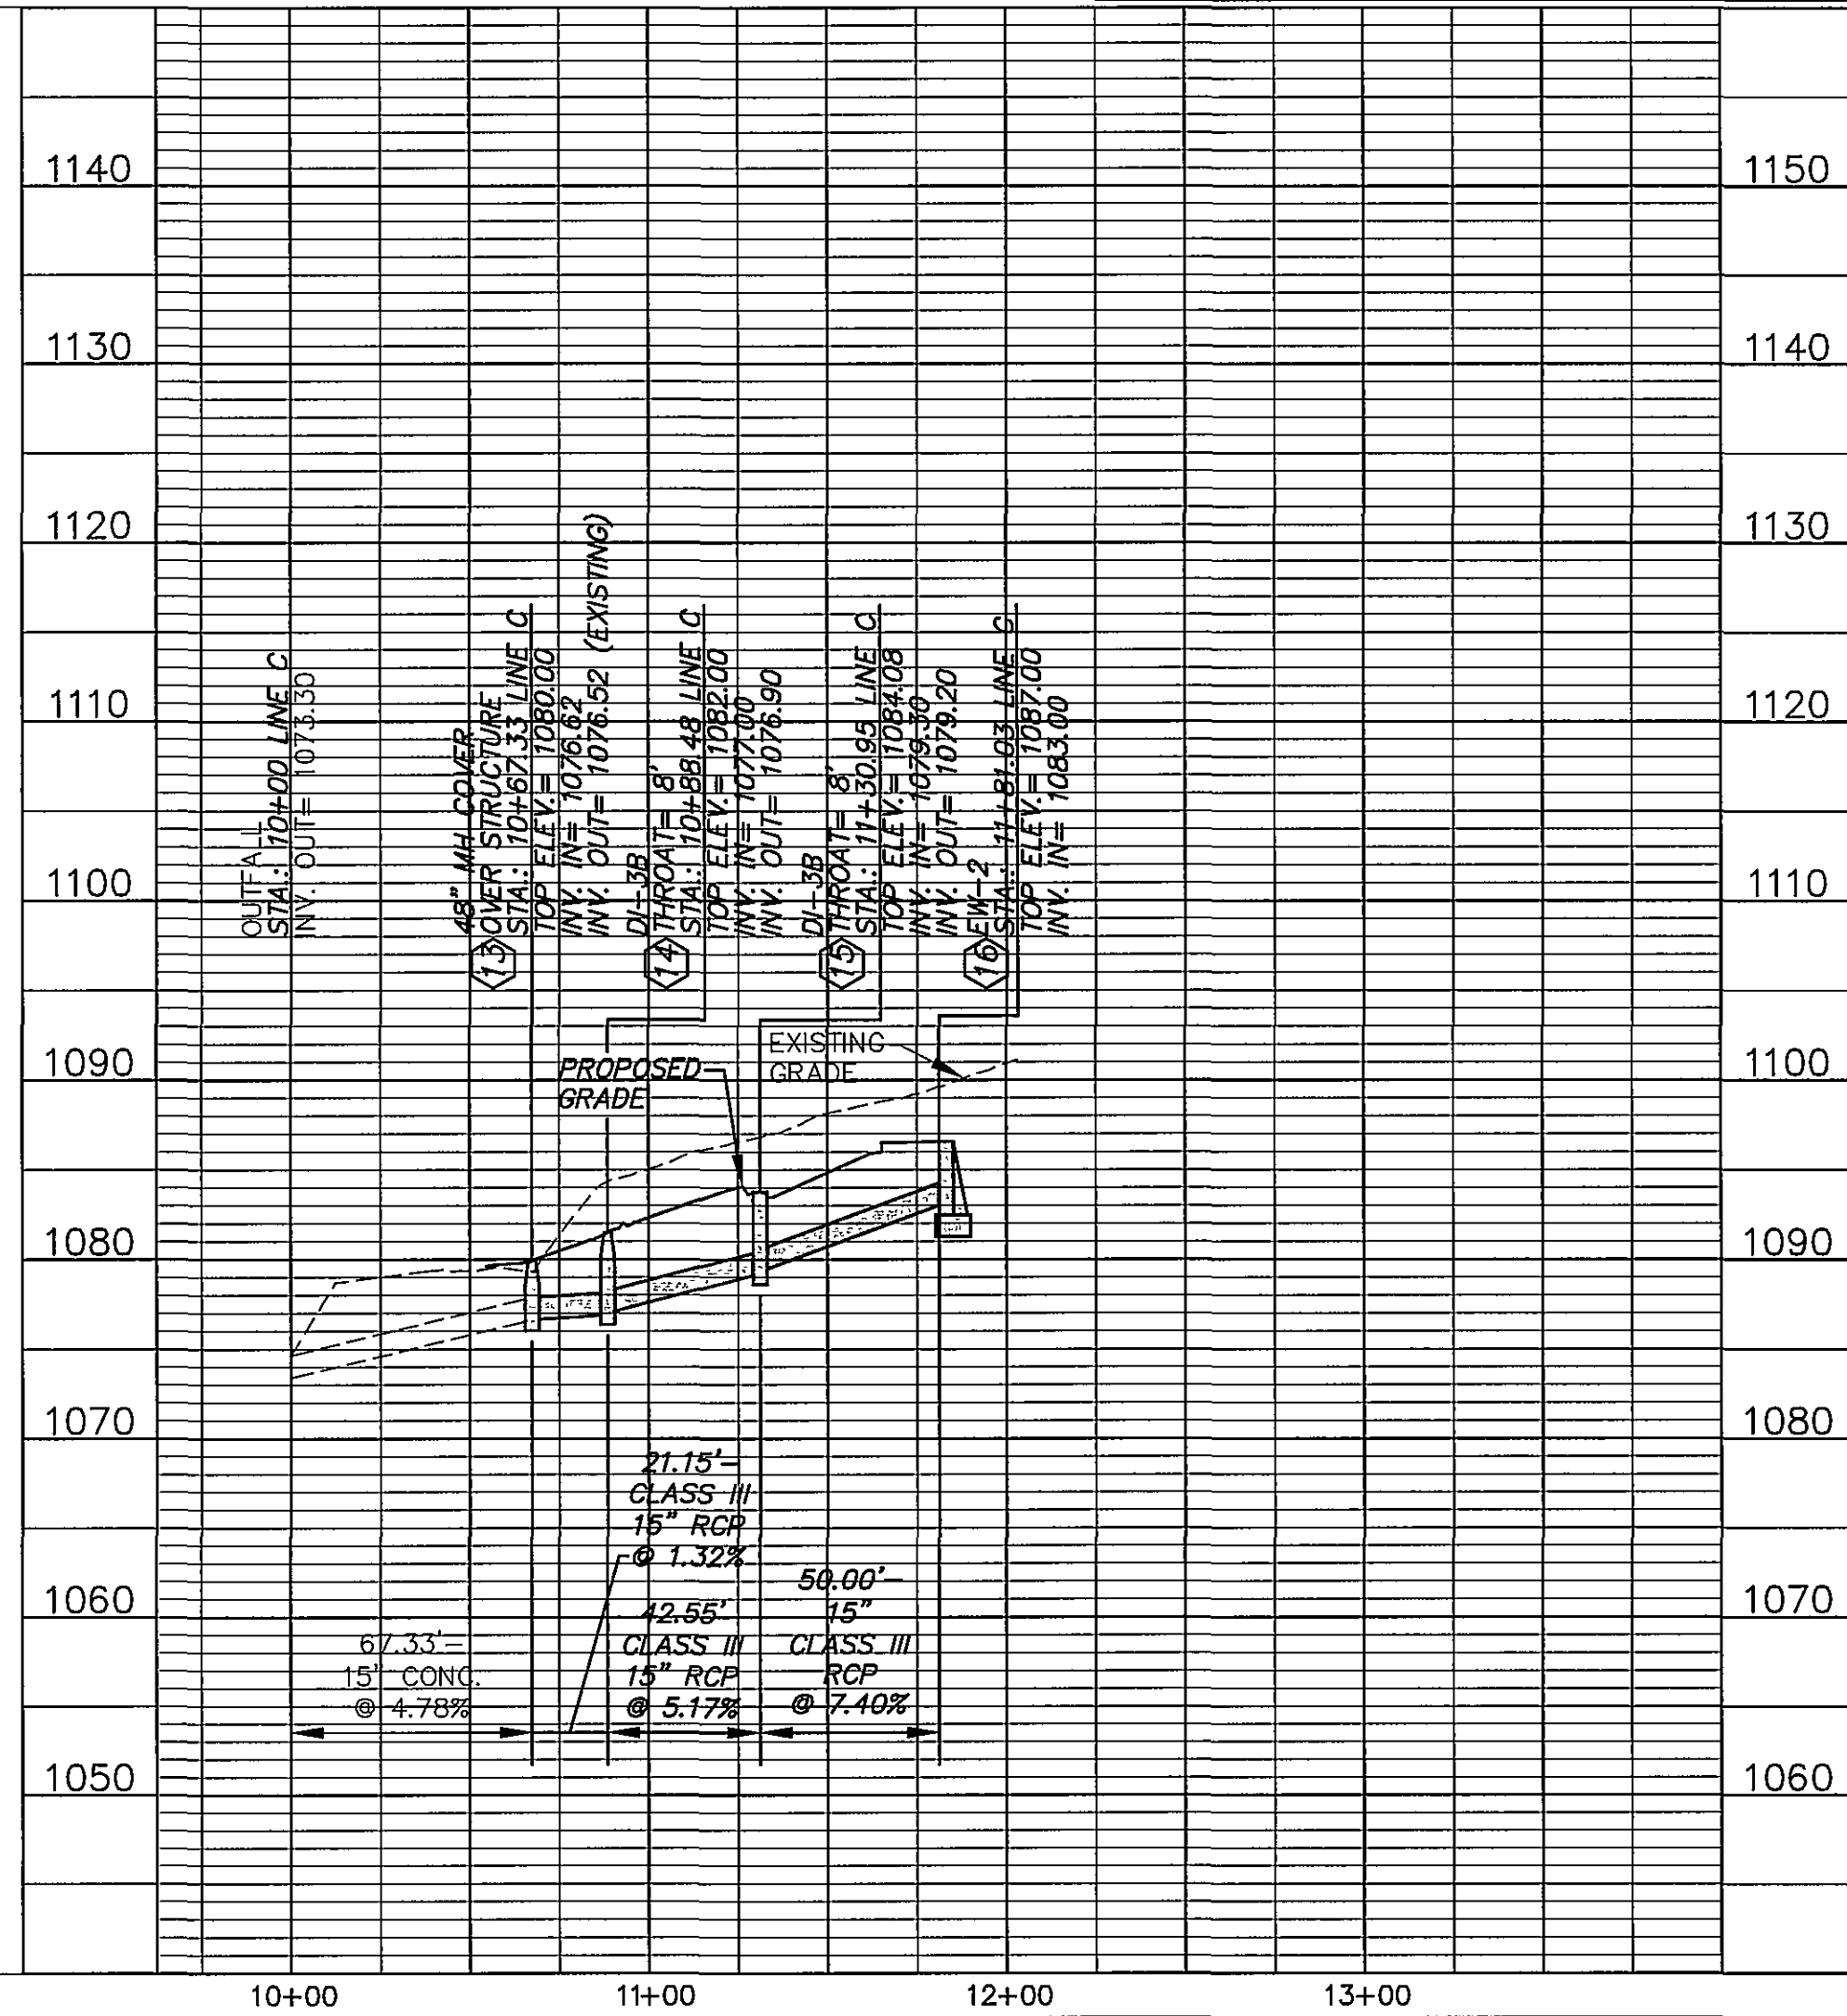


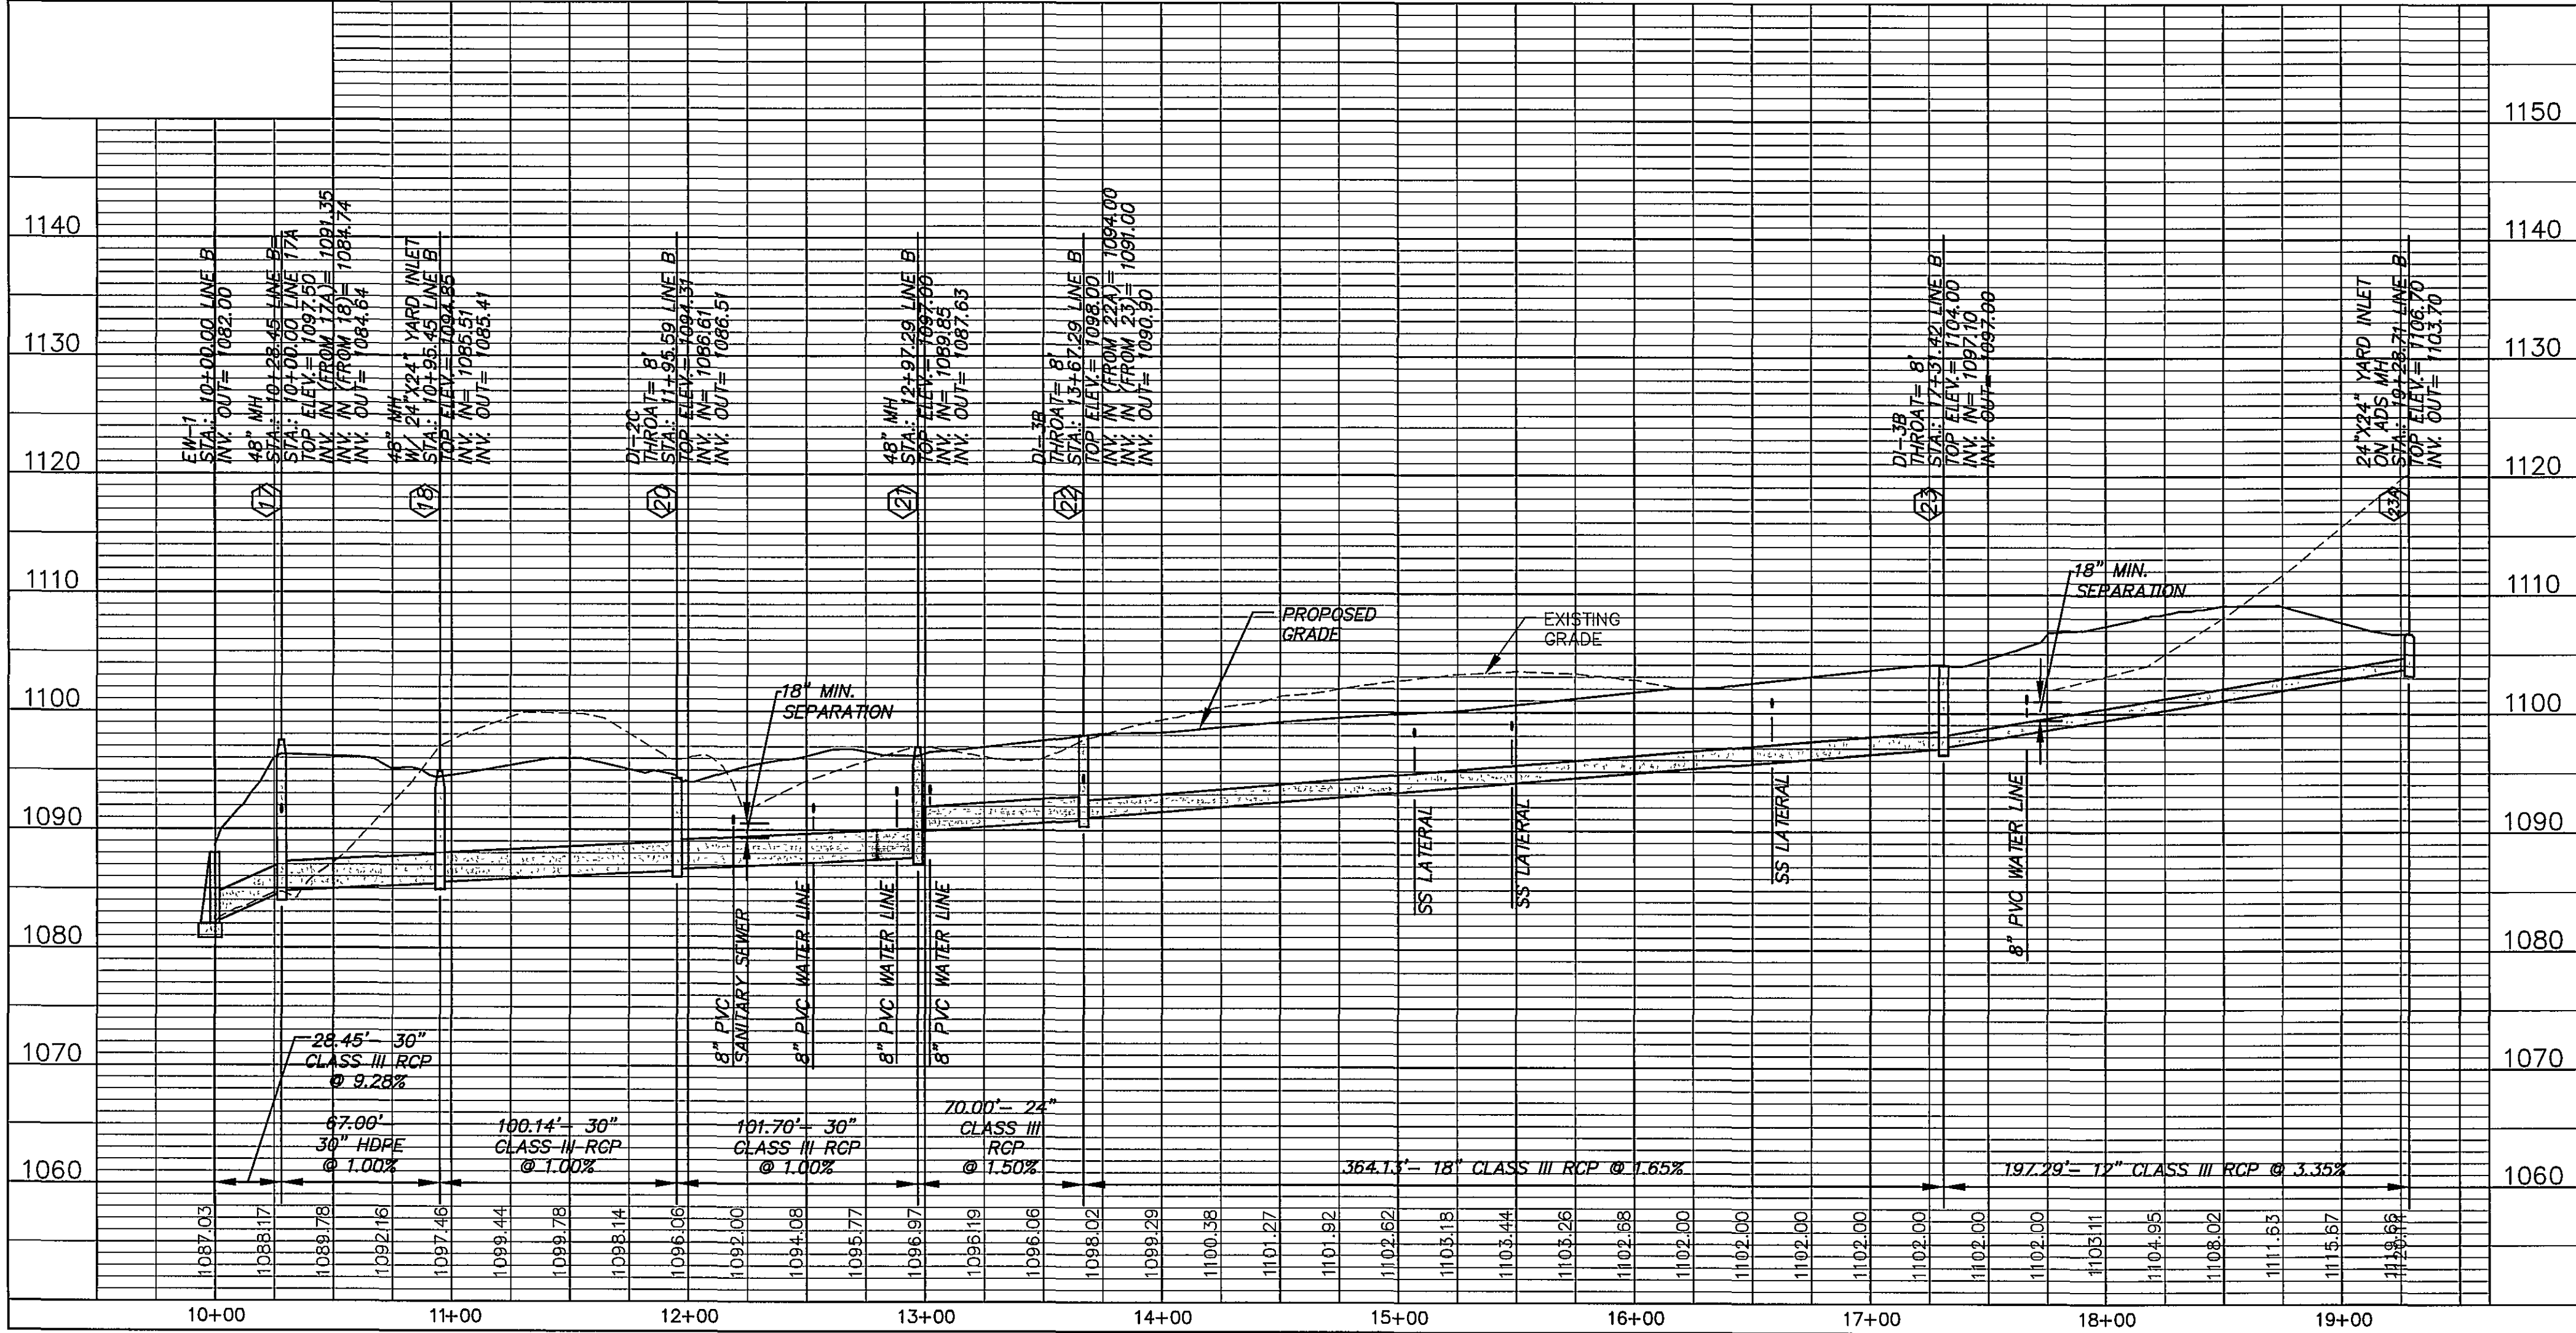

STORM SEWER PLAN AND PROFILE
FOR
ORCHARD VILLAS
ROANOKE COUNTY, VIRGINIA

PROJECT NO. 20040345
G.L. NO. 260-04-C4.7
FILE NO. LS-11039
DATE: 09/06/05
DRAWN BY: DLC/MCB
CHECKED BY: MDM

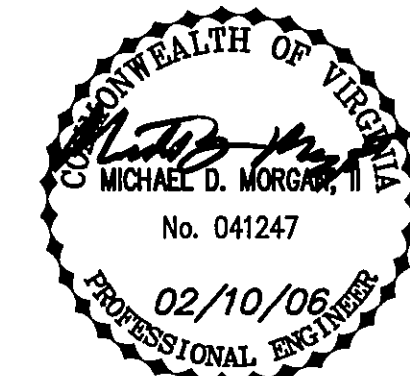

HURT & PROFFITT

SHEET NO.
26 OF 33

HURT & PROFFITT
INCORPORATED
2524 LANGHORNE ROAD
LYNCHBURG VA 24501
800.242.4906 TOLL FREE
434.847.7796 MAIN
434.847.0047 FAX

*ENGINEERING >> SURVEYING >> PLANNING