
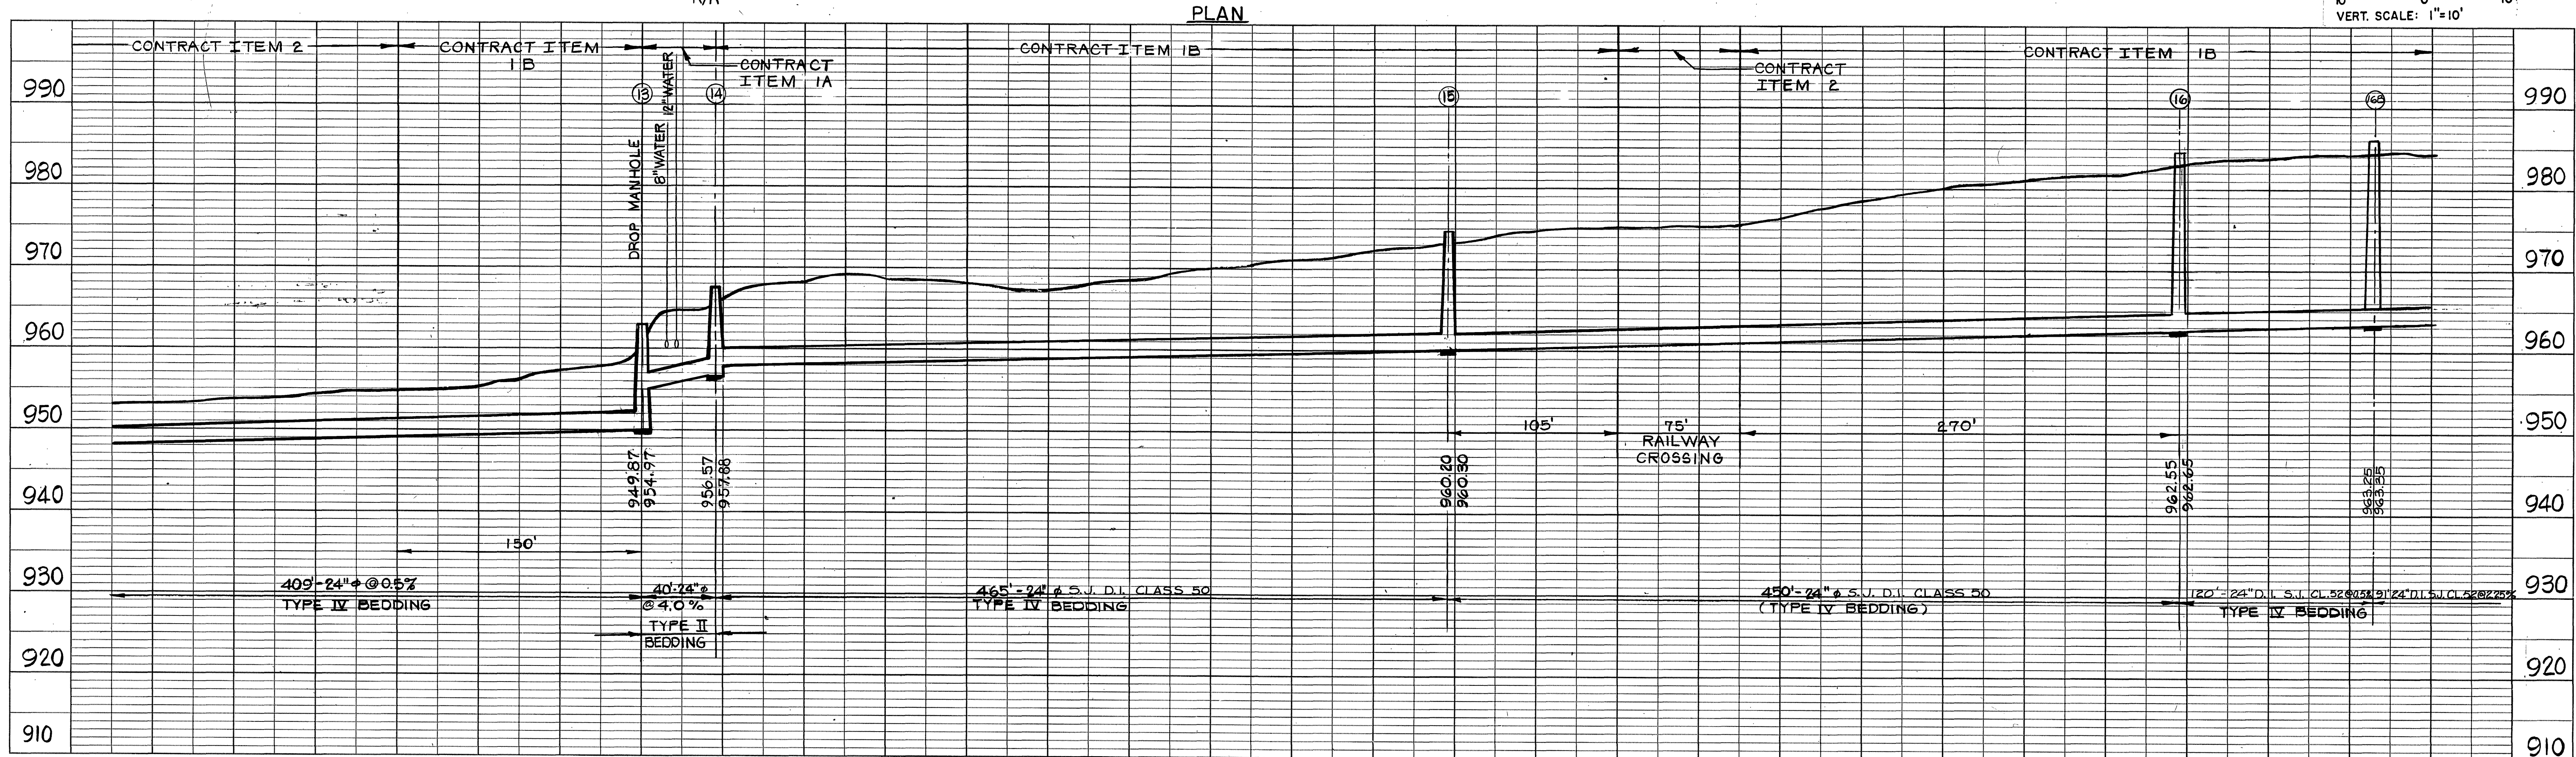


PLAN		BY	DATE
NOTE BOOK			
NO.			

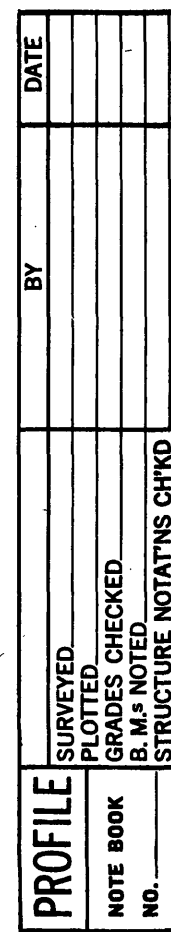

ORE BRANCH SANITARY SEWER CITY OF ROANOKE, VIRGINIA		CHECKED	DATE	CLIENT APPROVALS	DATE		LOWER SEGMENT PLAN AND PROFILE			
		DES. ENG.								
		PROJ. ENG.	<i>Rmy</i>	<i>11/22/80</i>						
		PROJ. MGR.	<i>WCS</i>	<i>11/24/80</i>						
		APPROVED								
 RICHMOND VIRGINIA		APPROVED		ISSUED FOR CONSTRUCTION	DATE <i>2.19.81</i>		DRAWN D. PHILLIPS	DATE JUNE 1980	PLAN NO. 4924	REV. NO.
							SCALE AS SHOWN	W.O. NO. 0384-05-01	SHT. 4 OF 6	