

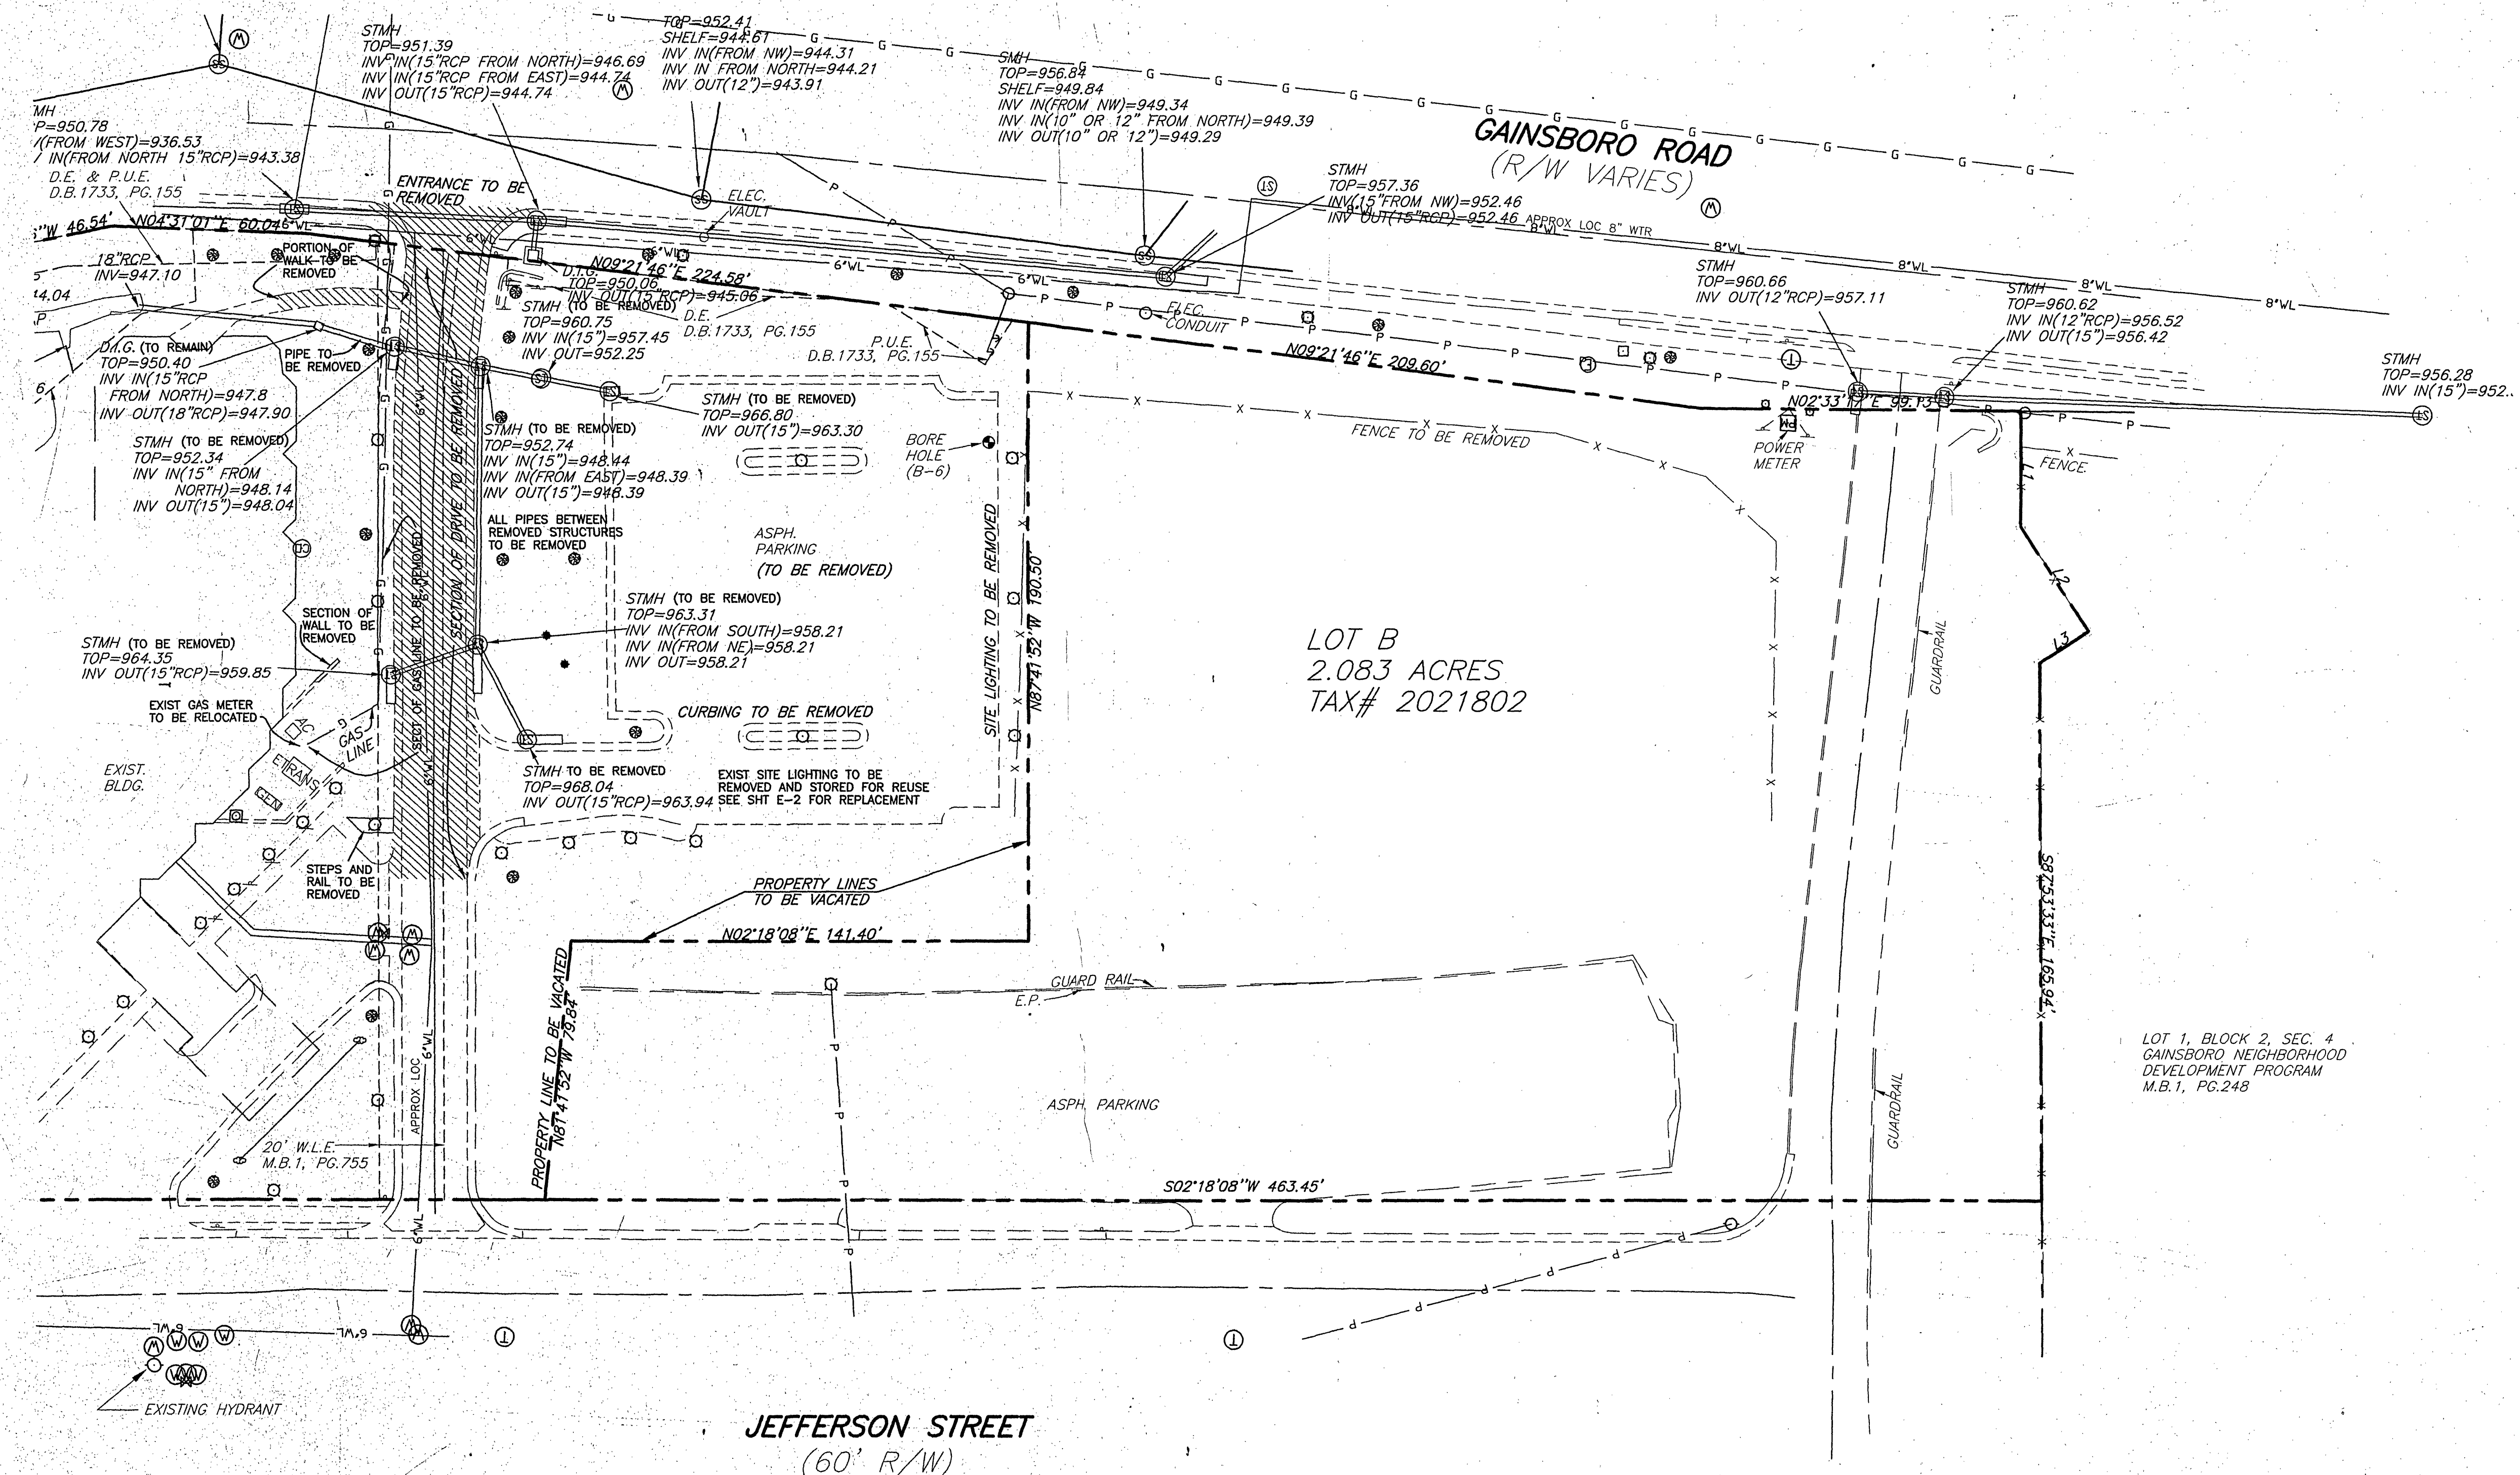


DEMOLITION NOTES
1. COORDINATE RELOCATION OF GAS METER WITH ROANOKE GAS CO. SEE PLUMBING PLANS
2. CAREFULLY REMOVE EXISTING SITE LIGHTING WITHIN THE WORK AREA. STORE IN A PROTECTED PLACE AWAY FROM CONSTRUCTION ACTIVITY. REFER TO ELECTRICAL PLAN FOR REPLACEMENT
3. PLANT MATERIAL TO BE SAVED WILL BE TAGGED BY DEVELOPER. CAREFULLY REMOVE TAGGED PLANT MATERIAL AND STORE, HELED IN, IN A SHADED AND PROTECTED AREA AWAY FROM CONSTRUCTION ACTIVITY. REPLACE AT THE DIRECTION OF THE DEVELOPER.

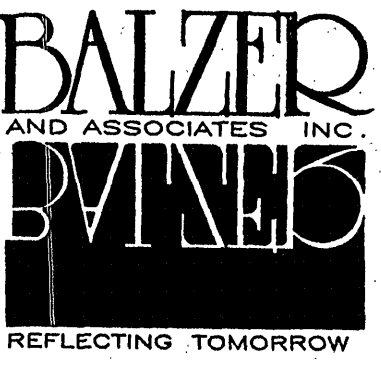

SITE DEMOLITIONS PLAN
SCALE: 1"=30'

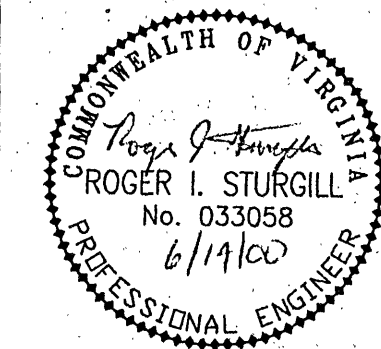

PLANNERS ARCHITECTS
ENGINEERS SURVEYORS

1208 Corporate Circle
Roanoke, Virginia 24018
Phone: 540/772-9550
FAX: 540/772-8050

501 Branchway Road
Suite 100
Richmond, Virginia 23236
Phone: 804/794-0571
FAX: 804/794-2635

11038 Lakeridge Parkway
Suite 1
Ashland, Virginia 23005
Phone: 804/650-2888
FAX: 804/650-2057

OUR LADY OF THE VALLEY
SITE DEMOLITION PLAN
ROANOKE, VIRGINIA

DRAWN BY: KDK
DESIGNED BY: KDK
CHECKED BY: RIS
DATE: APRIL 19, 2000
REVISIONS:

1 - JUNE 13, 2000

SCALE: 1"=30'
SHEET NO.
C-3
JOB NO.
R00032