
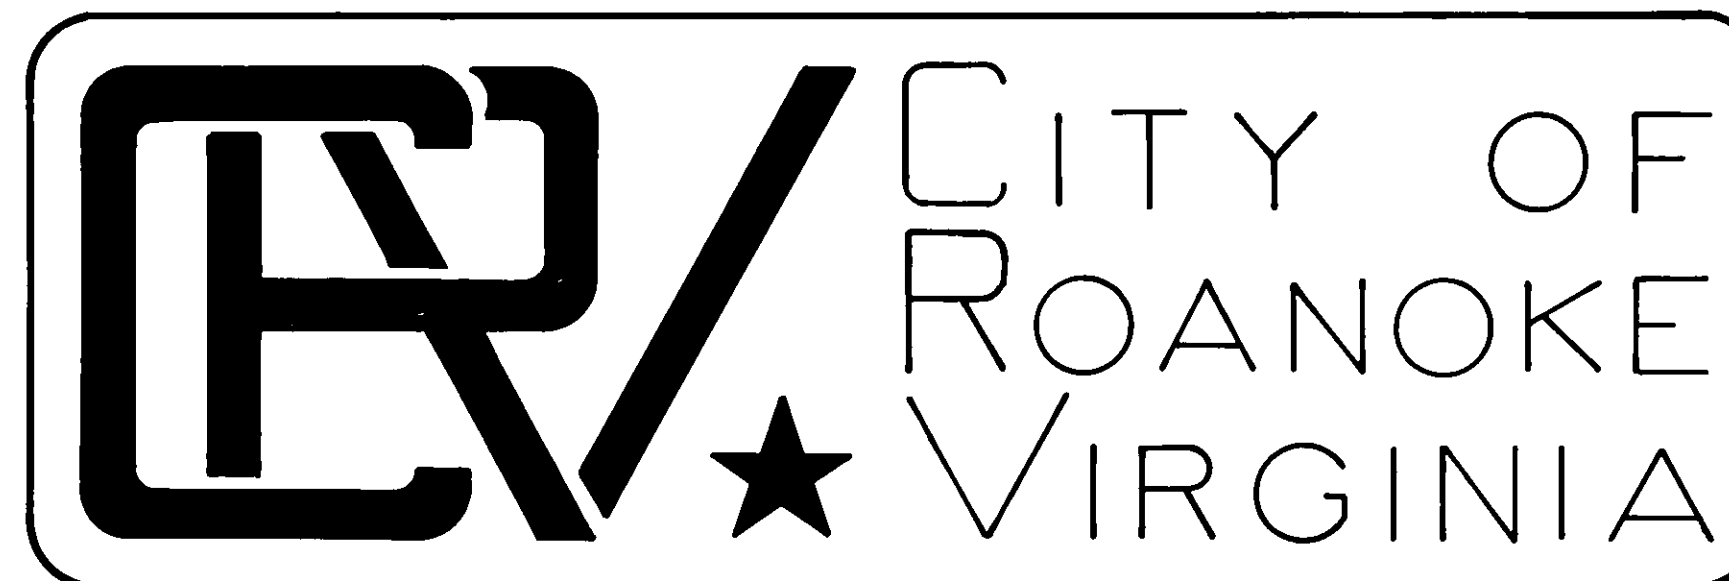


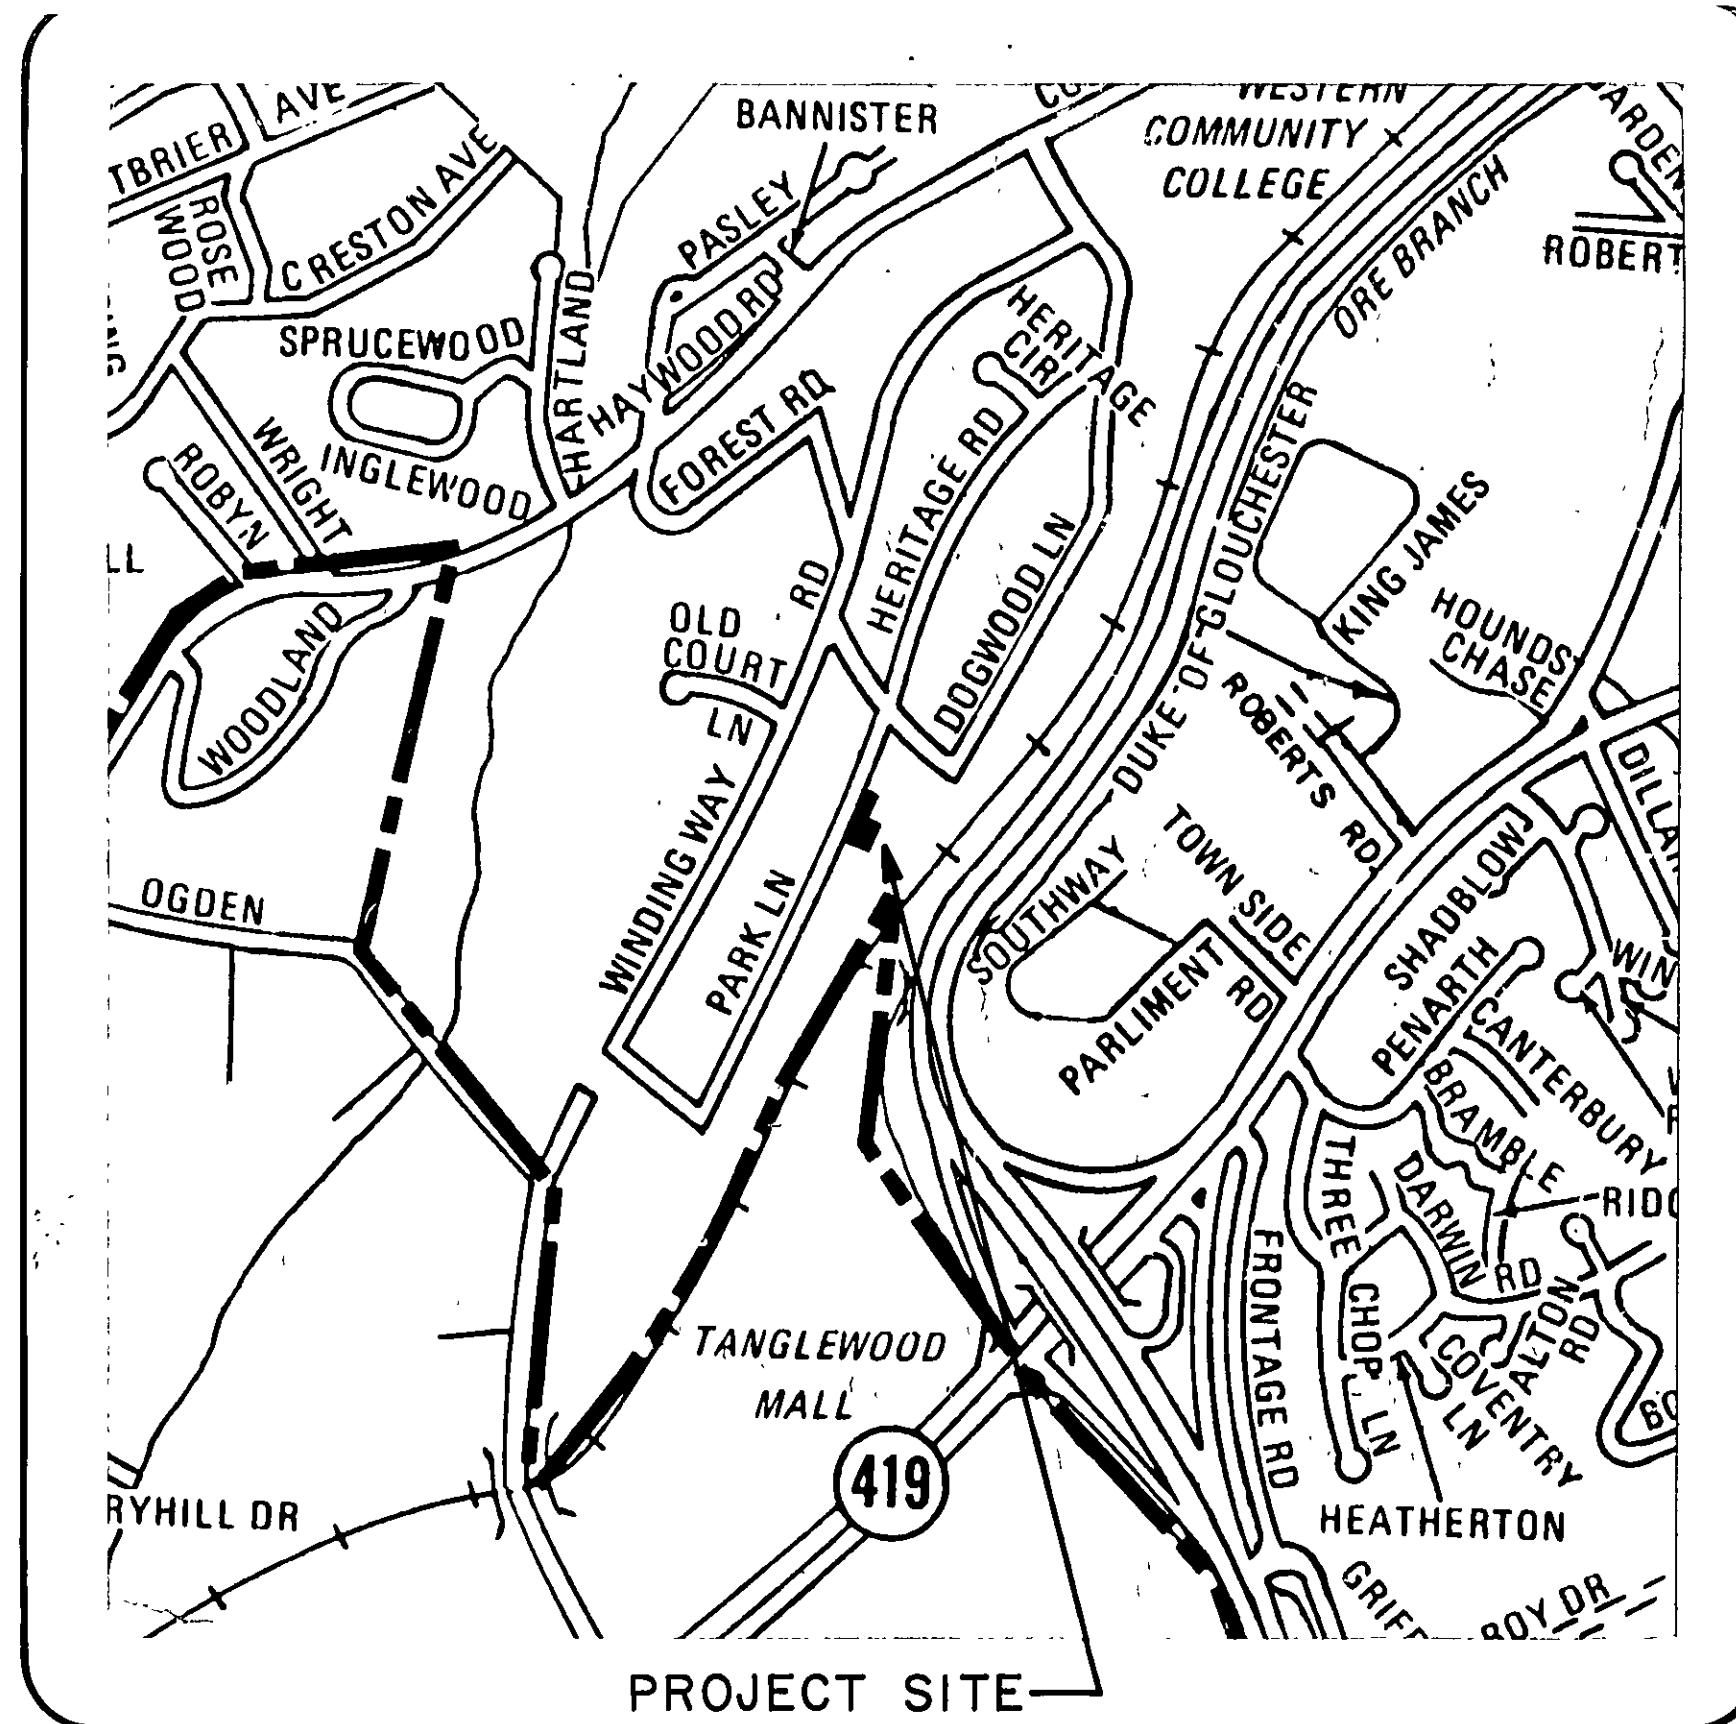

OFFICE OF CITY ENGINEER
ROOM 350
MUNICIPAL BUILDING
215 CHURCH AVENUE, S.W.
ROANOKE, VIRGINIA 24011

INDEX OF SHEETS

TITLE SHEET	1
PROFILES & SITE PLAN	2
LIFT STATION DETAILS	3

CONSULTING ENGINEERS

CITY OF ROANOKE
ENGINEERING DEPARTMENT

COMMISSION NUMBER: _____

PROJECT NAME

PARK LANE
SEWAGE LIFT STATION
AND
FORCE MAIN

PROJECT NUMBER: S-86-10 (6018)

REVISION	BY	DESCRIPTION:	DATE
REVISION	BY	DESCRIPTION:	DATE
REVISION	BY	DESCRIPTION:	DATE
REVISION	BY	DESCRIPTION:	DATE

APPROVED FOR CONSTRUCTION

<u>Charles M. Huffine</u> ROANOKE CITY ENGINEER	<u>1-28-87</u> DATE
<u>William J. Clark</u> DIRECTOR OF PUBLIC WORKS	<u>1-29-87</u> DATE
<u>Pat B. Lee</u> DIRECTOR OF UTILITIES AND OPERATIONS	<u>1/29/87</u> DATE
_____	DATE
_____	DATE

ADVERTISED DATE: _____

SET NUMBER: _____

SHEET NUMBER: 1 OF 3