




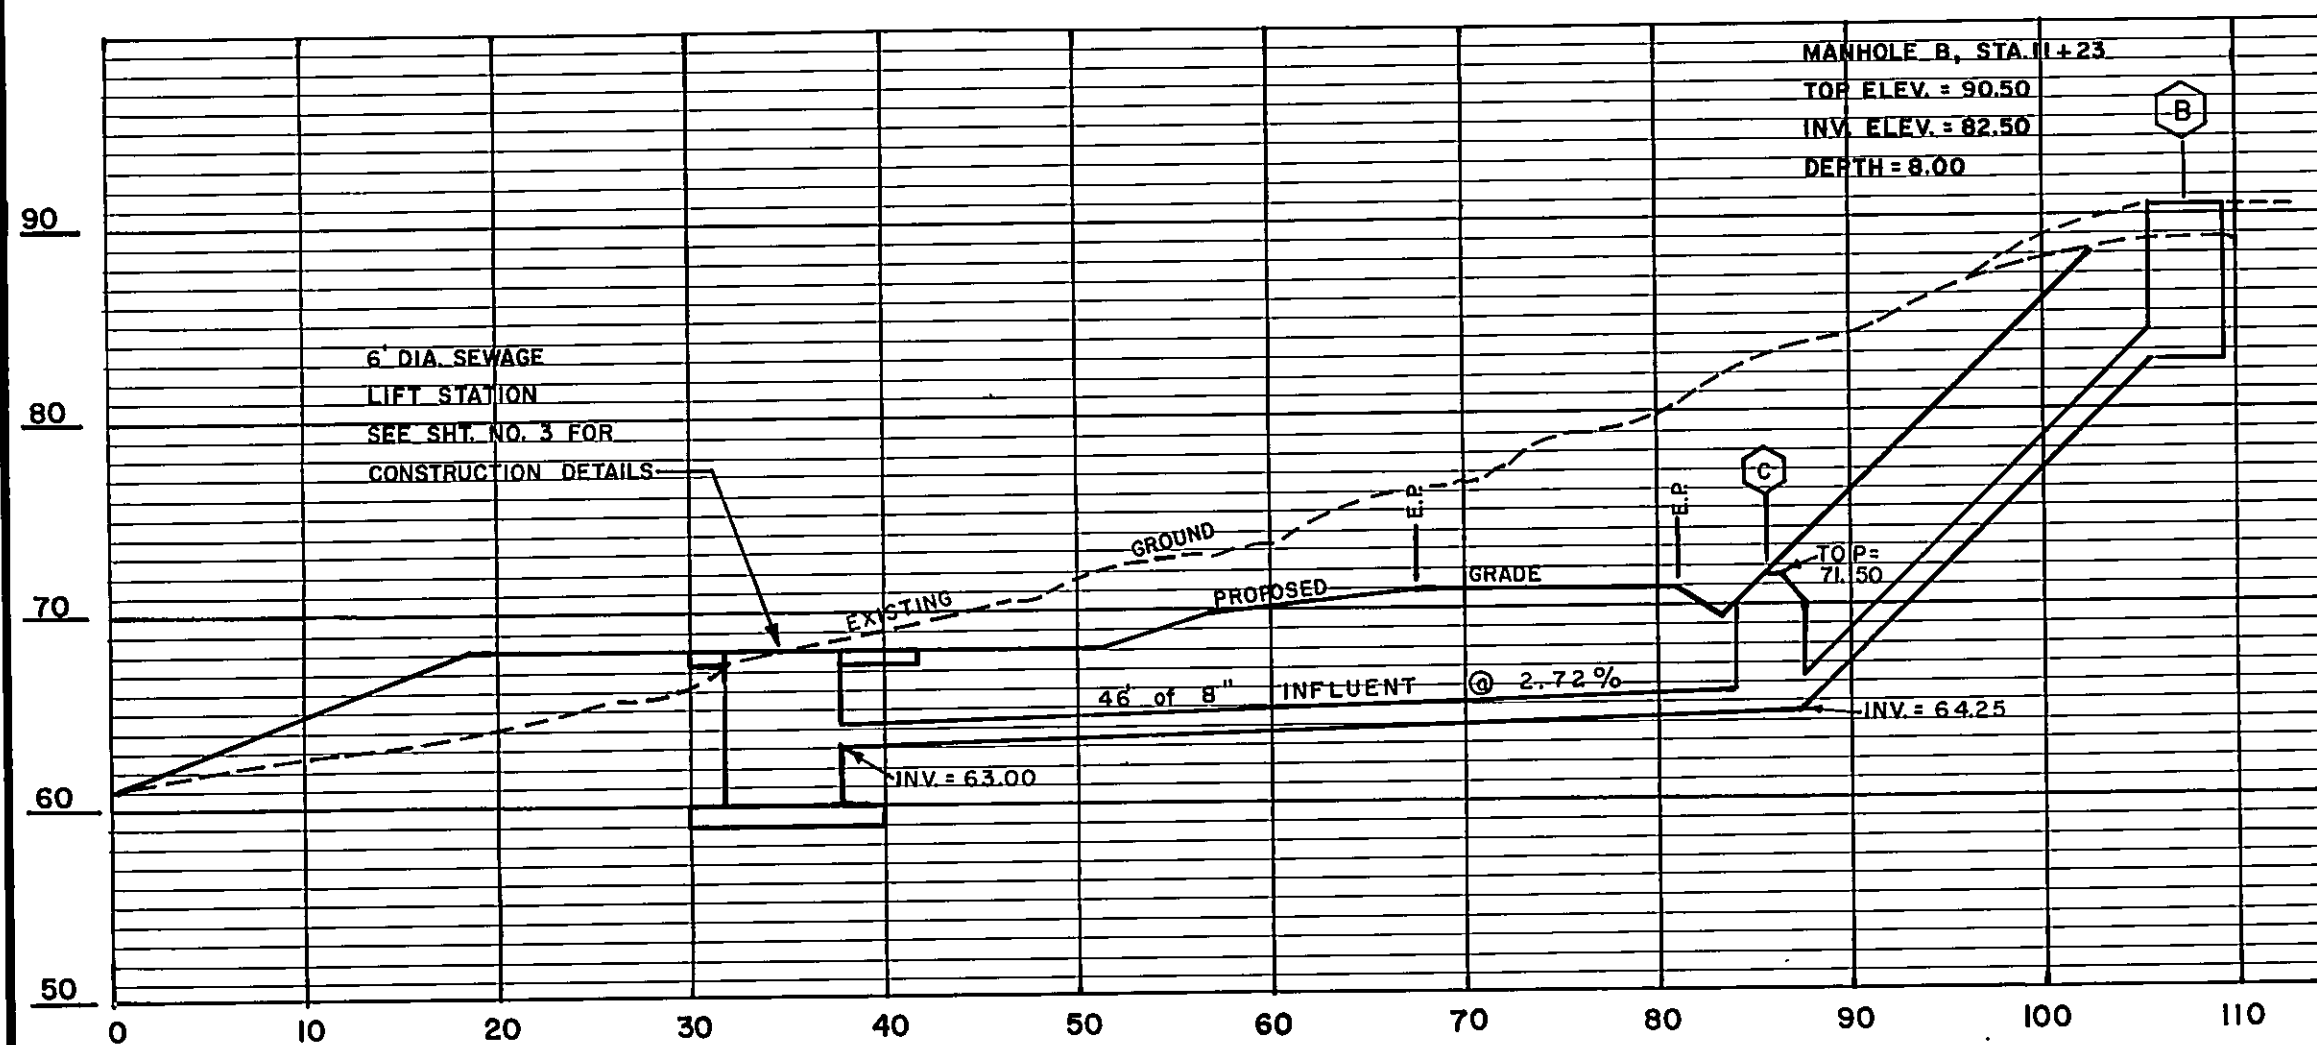


**SECTION X-X
ELEVATION THRU STATION SITE**
SCALE: 1" = 10' HORIZONTAL
1" = 10' VERTICAL

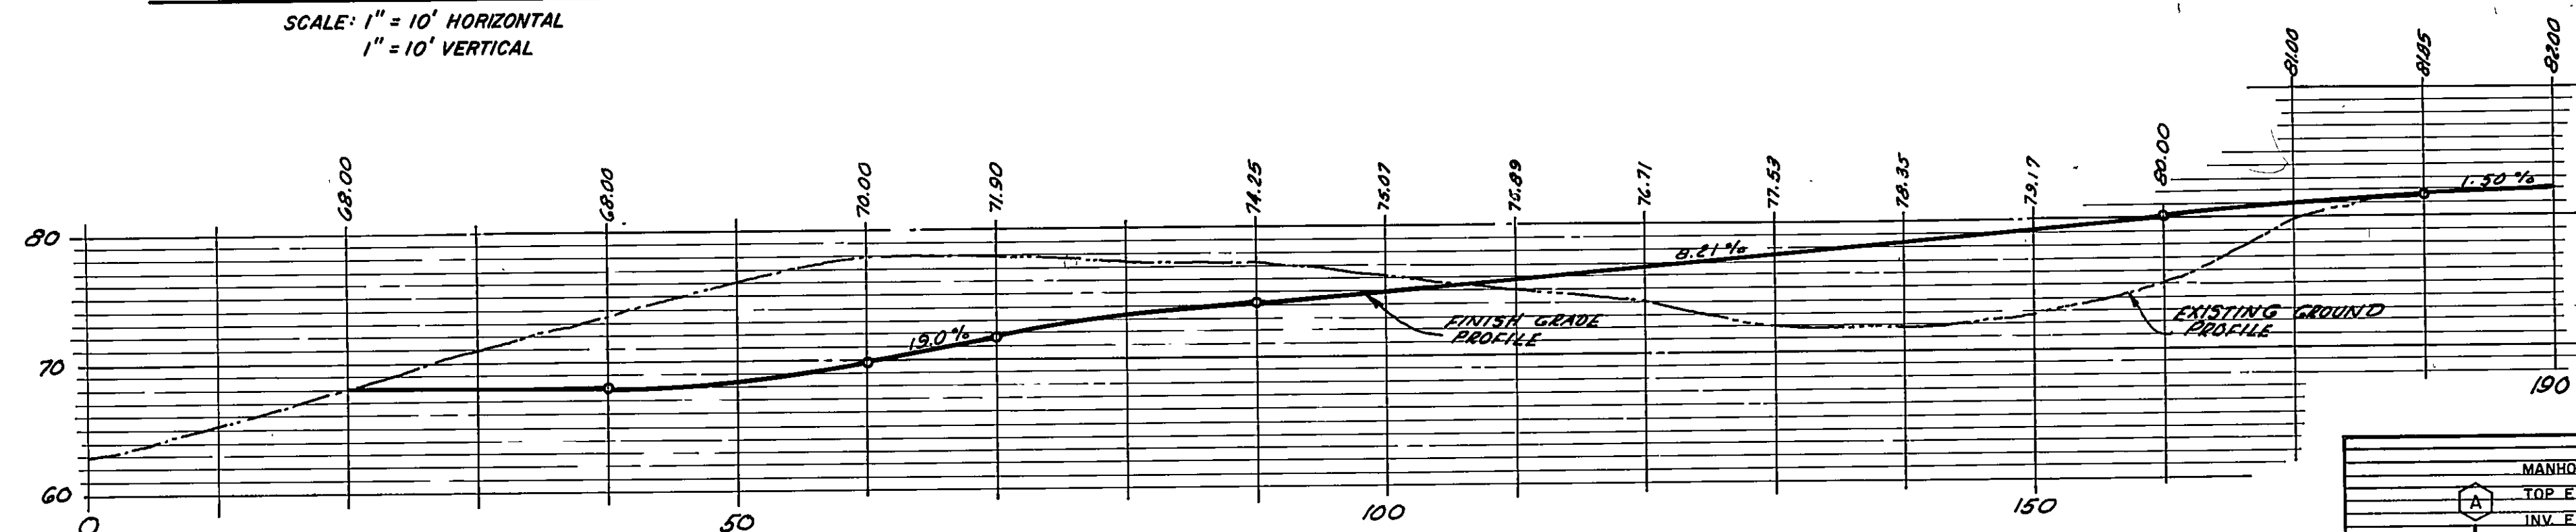


PROFILE- STATION ACCESS ROAD
SCALE: 1" = 10' HORIZONTAL
1" = 10' VERTICAL

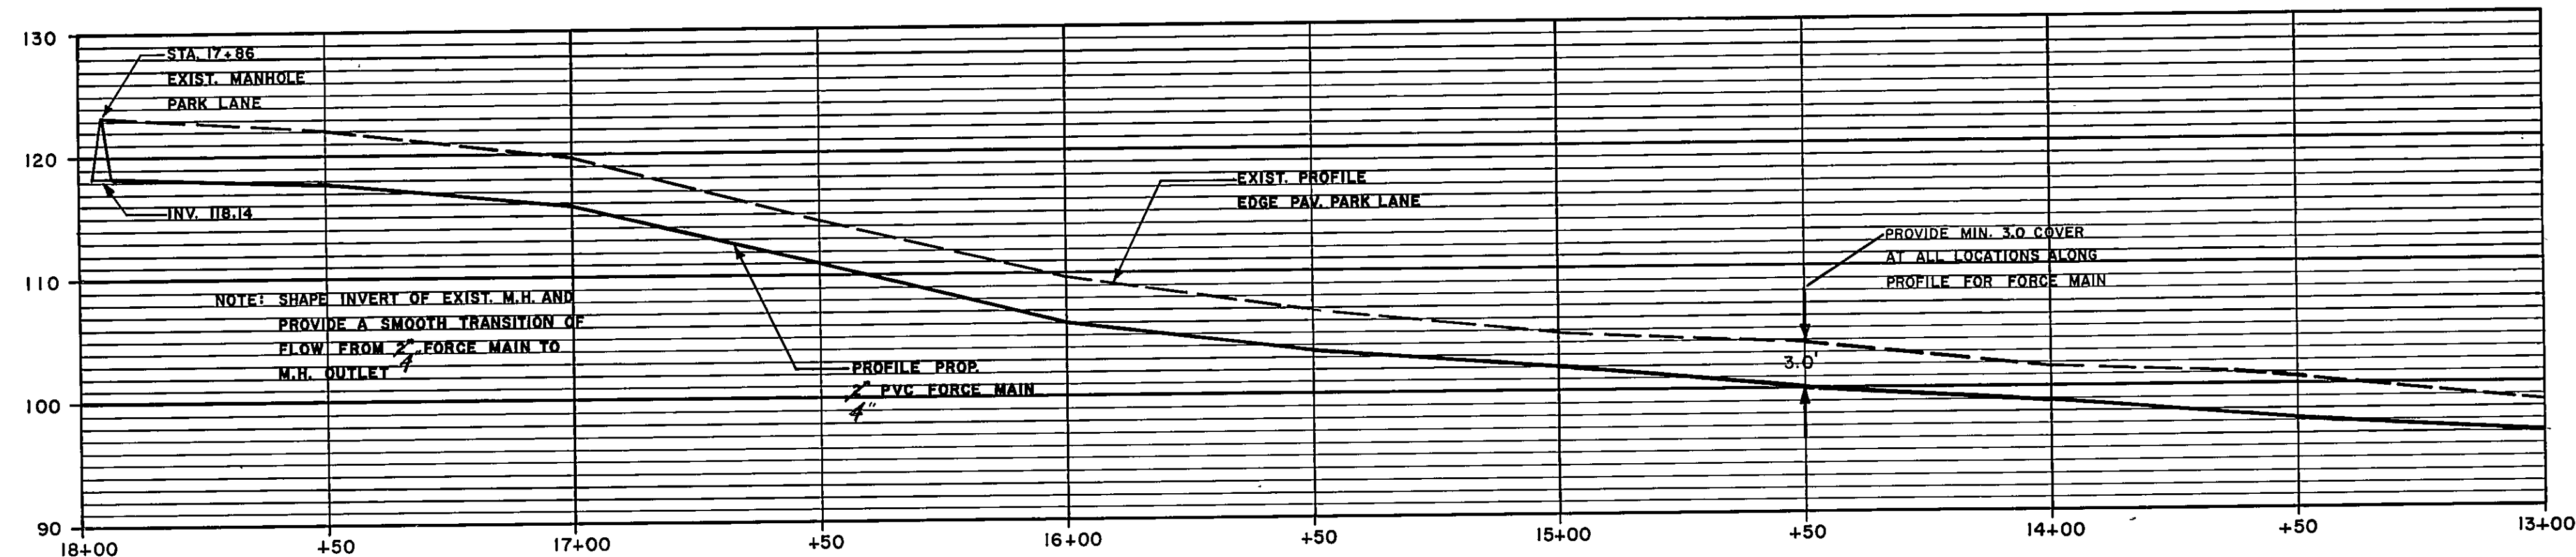

SEWER FORCE MAIN PROFILE
SCALE: 1" = 25' HORIZONTAL
1" = 10' VERTICAL

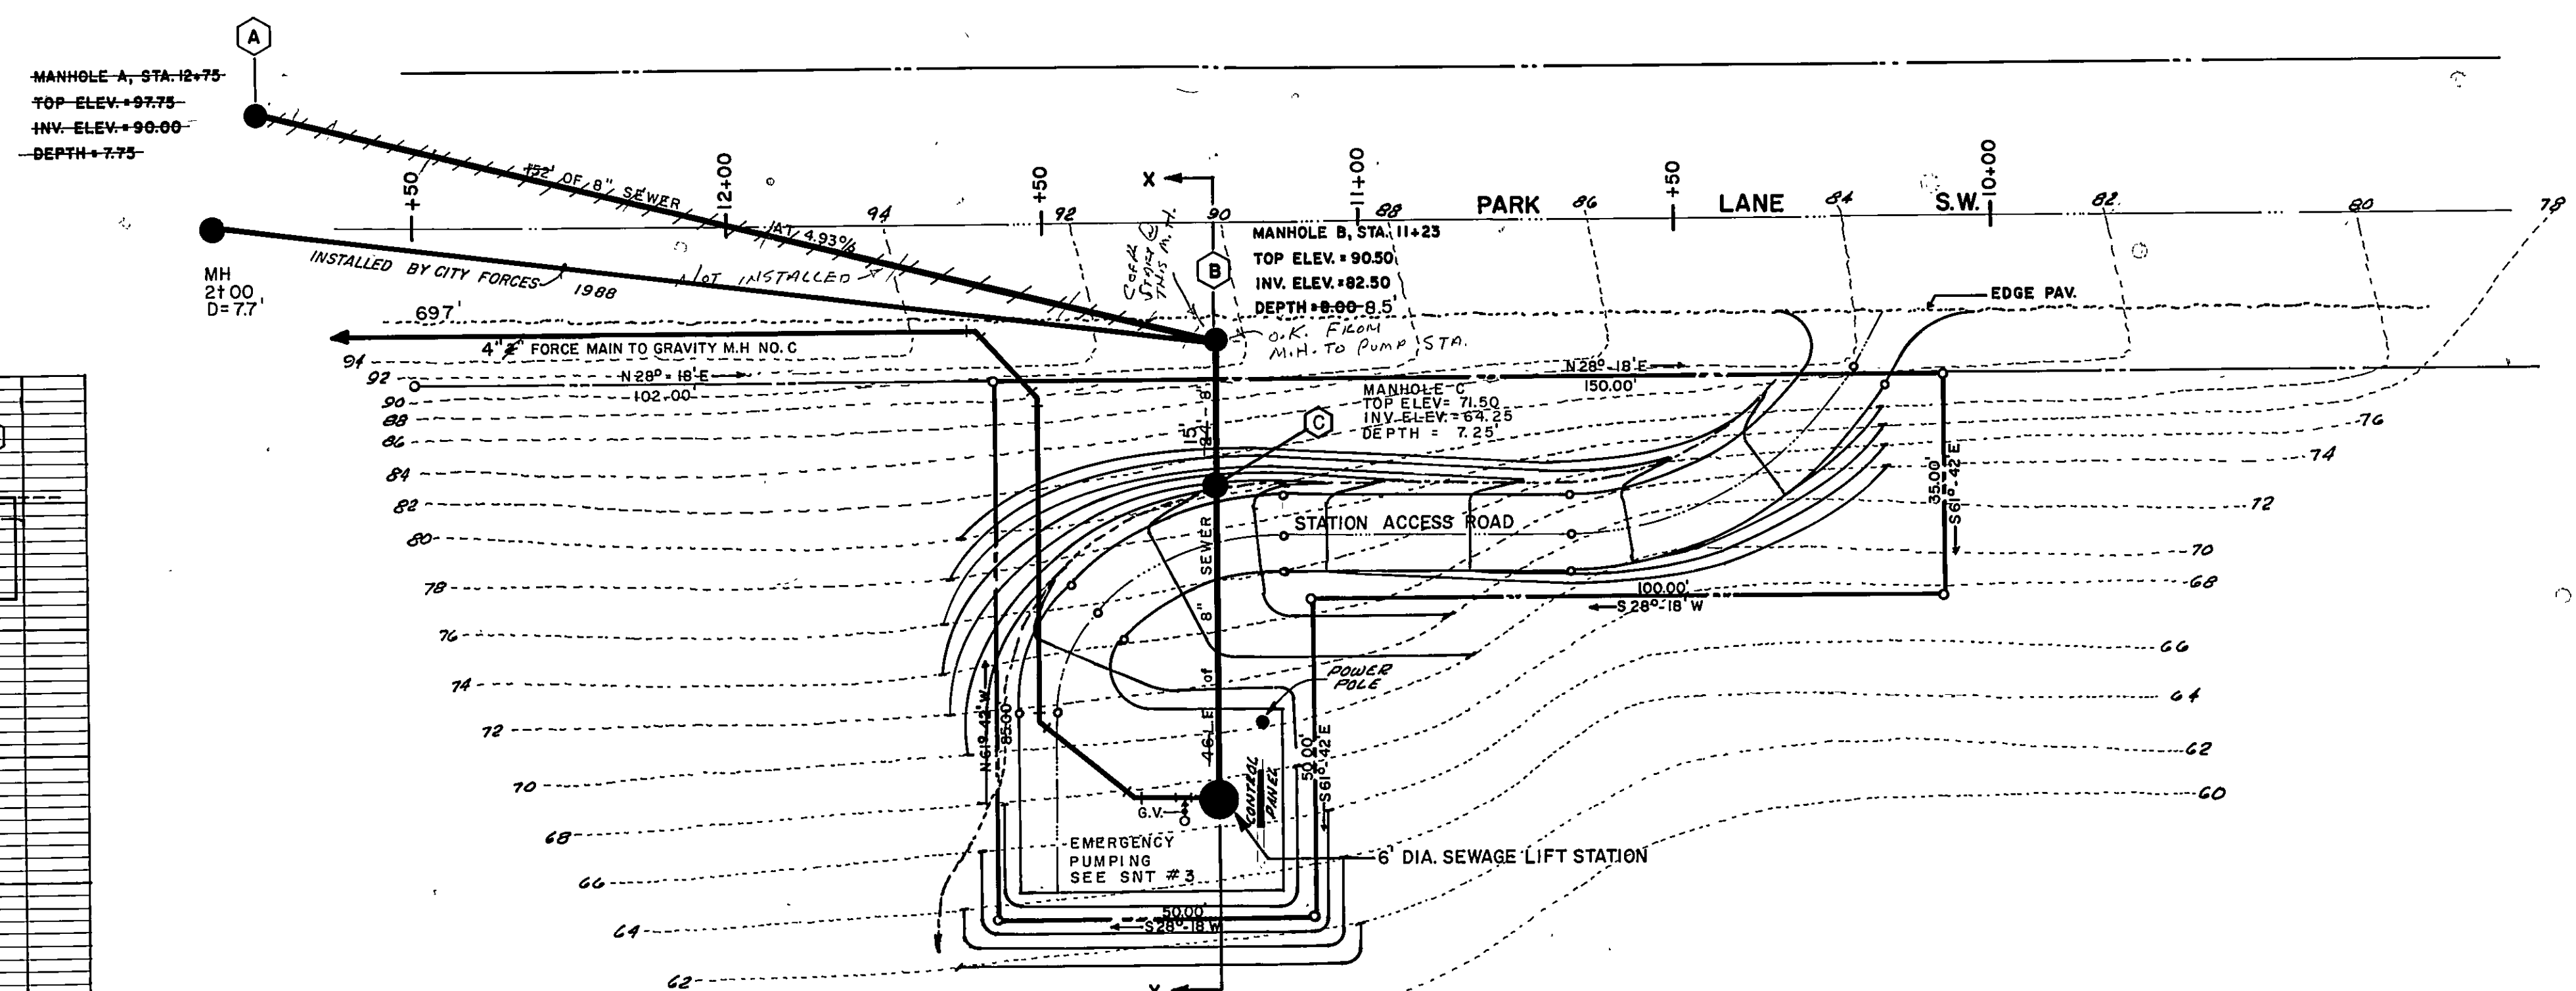

SEWAGE LIFT STATION SITE PLAN
SCALE: 1" = 20'

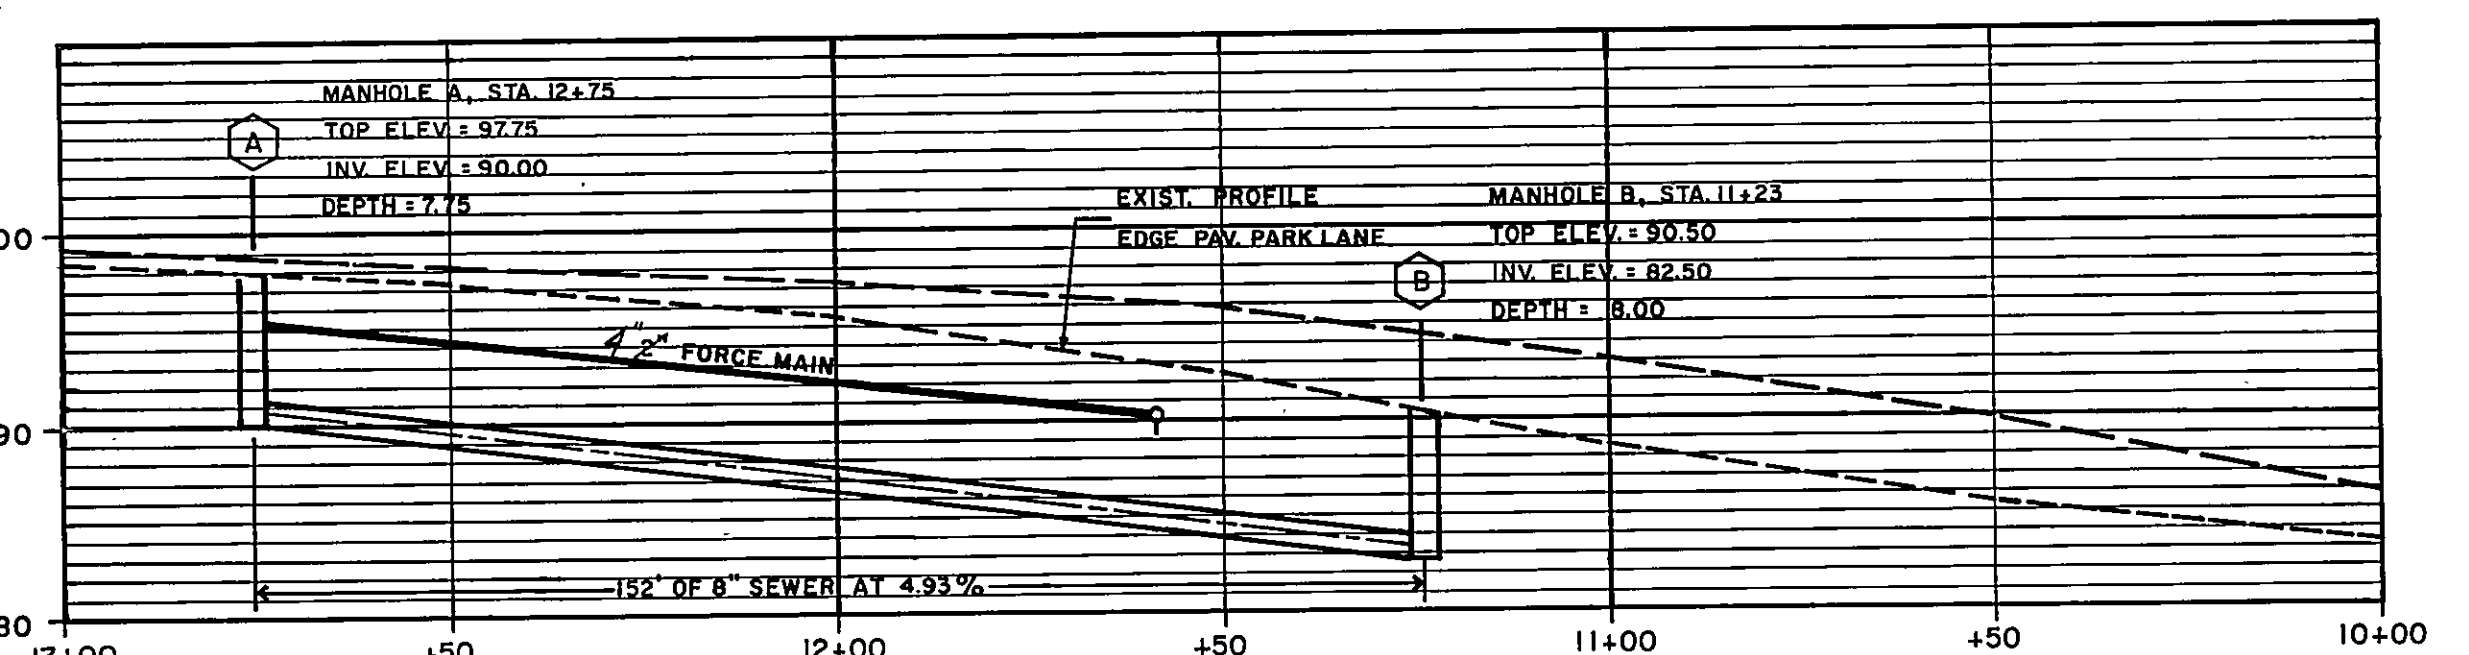

DATE	REV.	DESCRIPTION	BY

CITY ENGINEER			
DRAWN	J.R.		
CHECKED	E.S.		
APPROVED	C.M.H.		
DATE			
PLAN NO.	6018		
SHEET	2		
OF	3		

OFFICE OF CITY ENGINEER
MUNICIPAL BUILDING, ROOM 350
215 CHURCH AVENUE, S.W.
ROANOKE, VIRGINIA 24011