



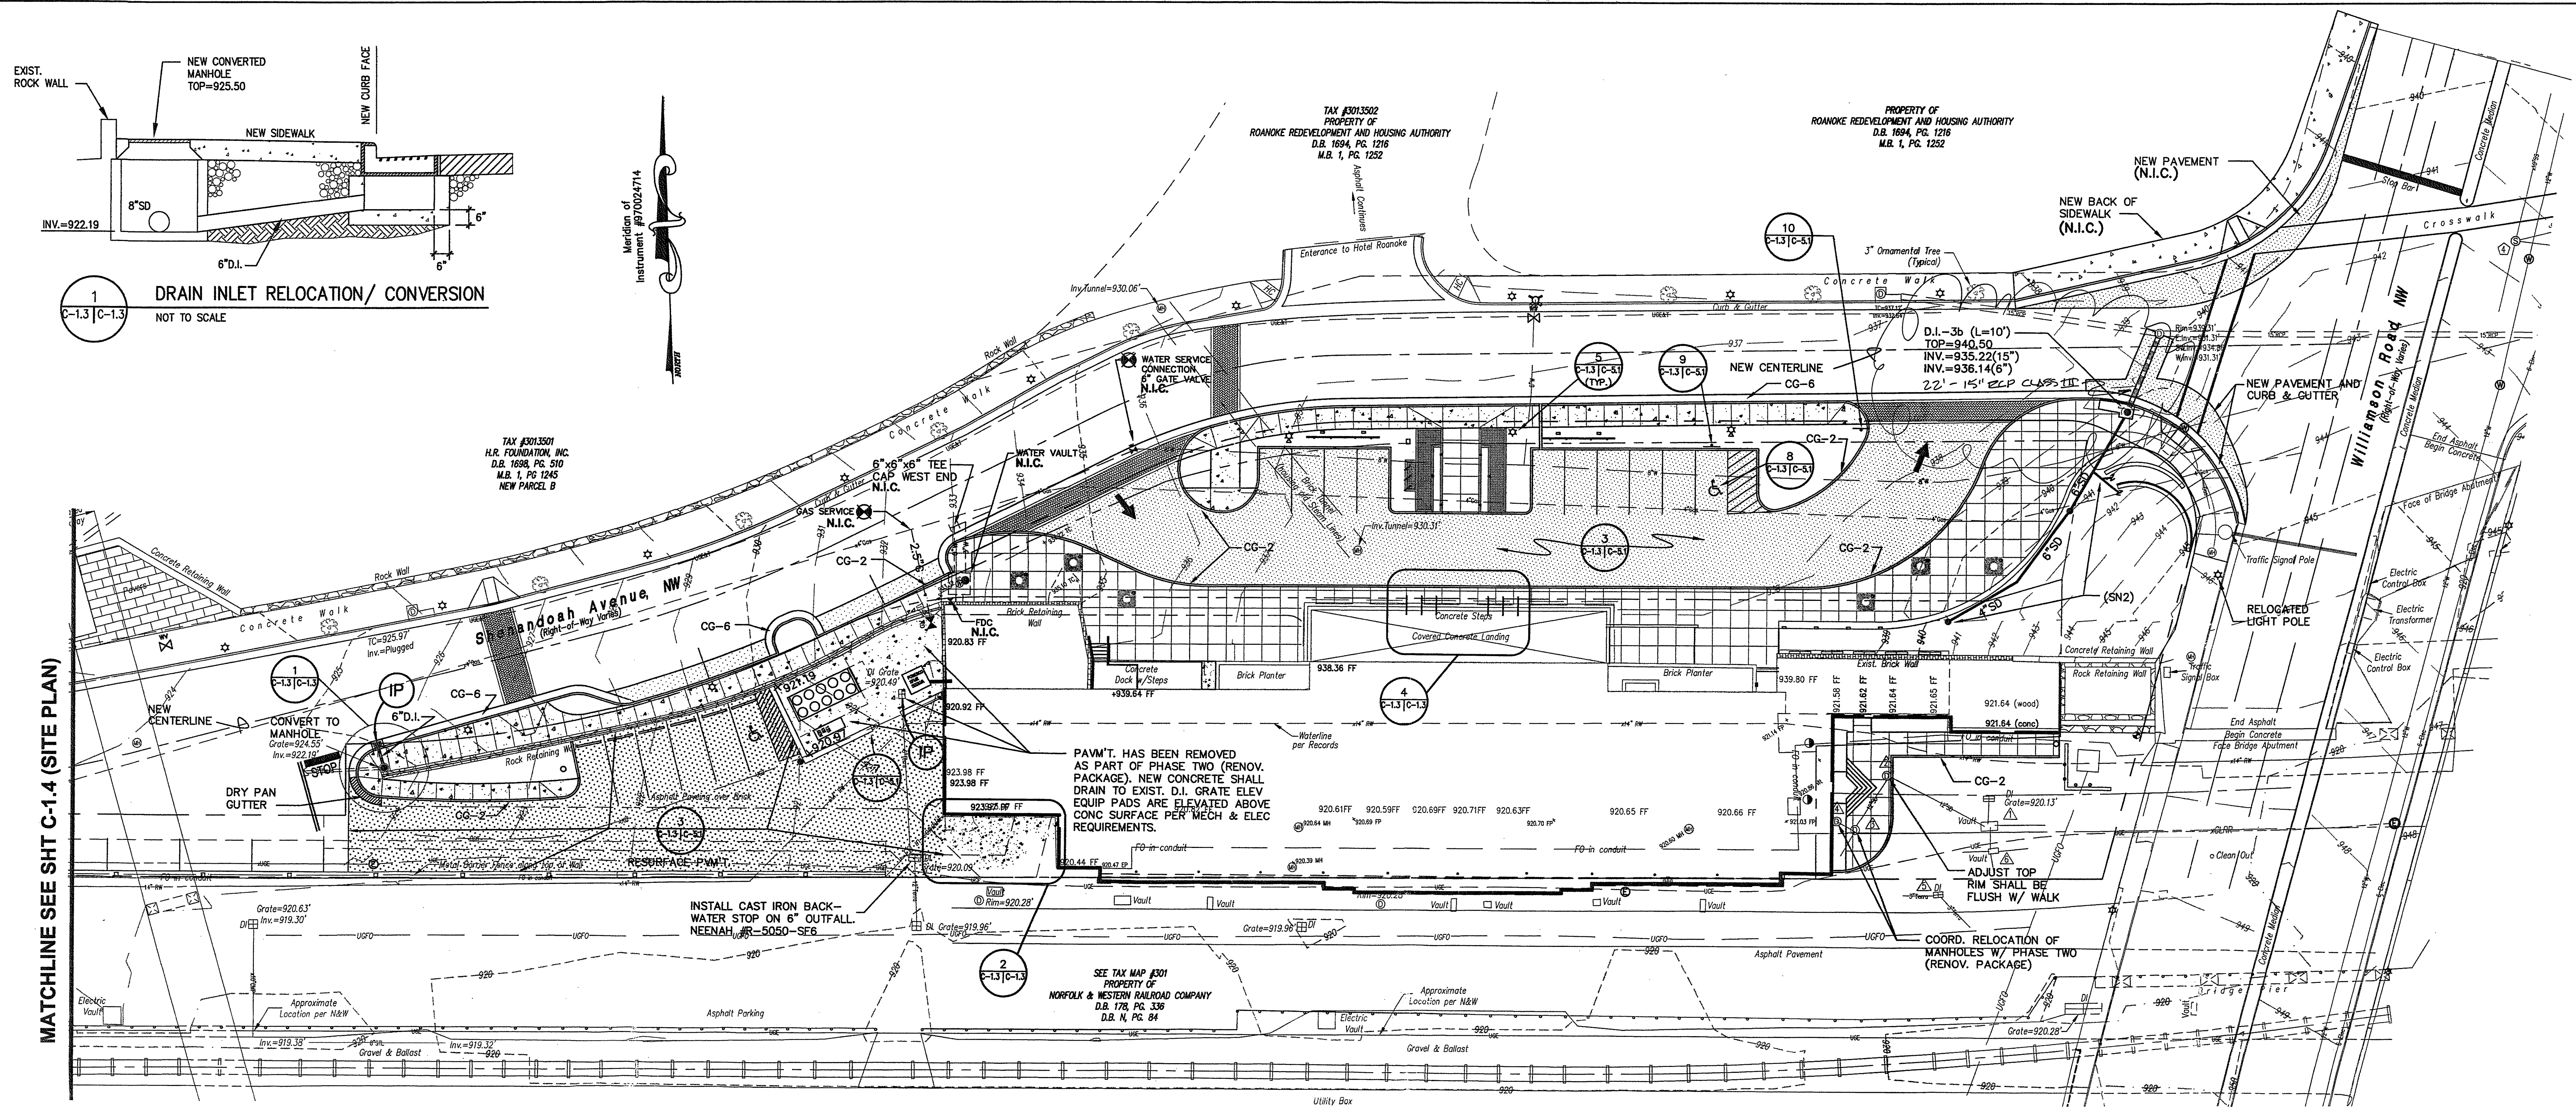

MATCHLINE SEE SHT C-1.4 (SITE PLAN)

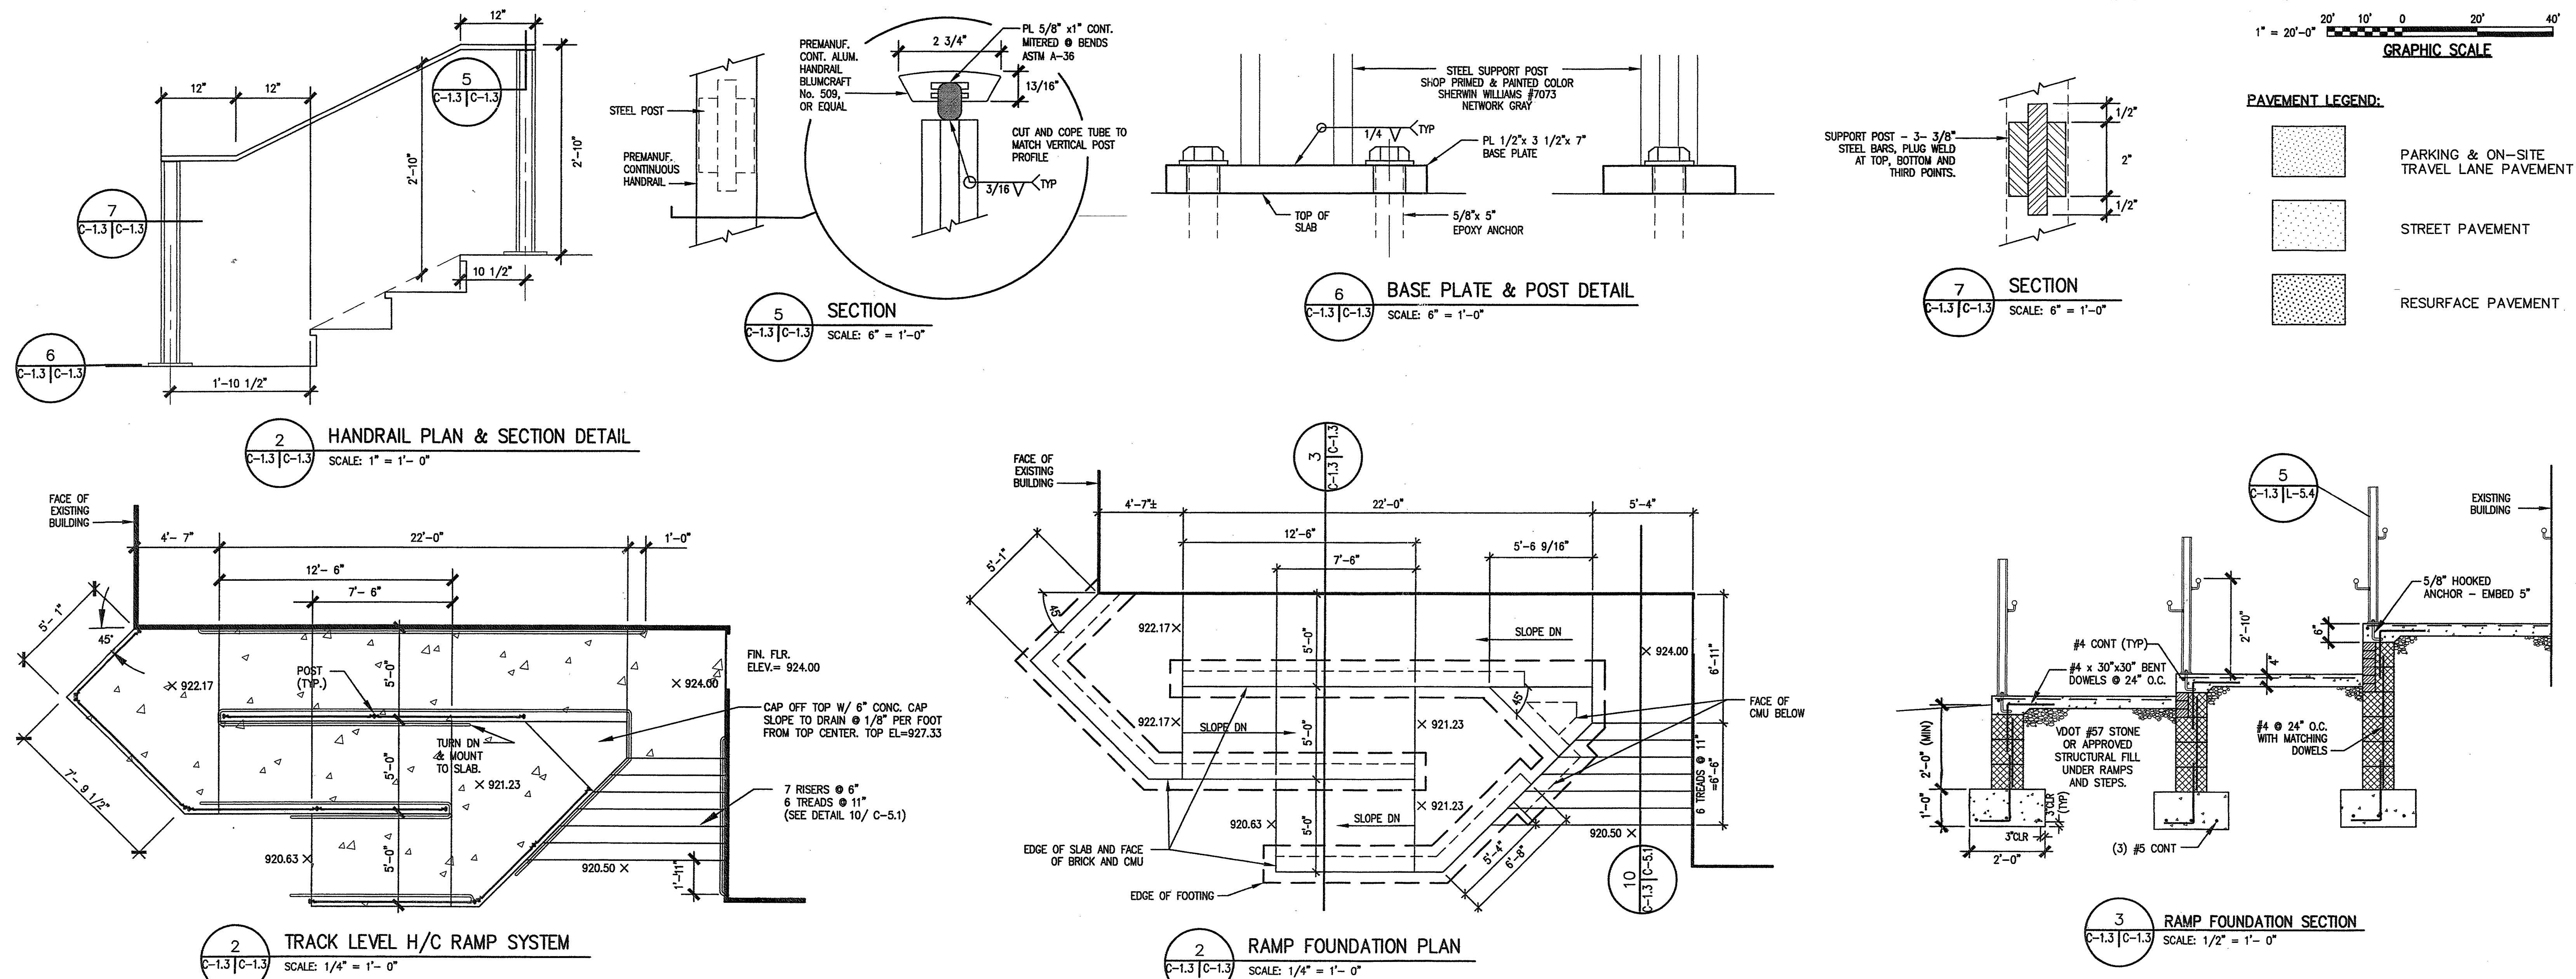

ROANOKE PASSENGER STATION **PHASE THREE-SITE WORK** **ROANOKE, VIRGINIA**

SPECTRUM DESIGN PROJECT NO. 00124

DATE: 31 January 2003
DESIGN ARCHITECT: MICHAEL A. RAKES
PROJECT ENGINEER: MICHAEL A. RAKES
CHECKED BY: MICHAEL A. RAKES
DRAWN BY: MICHAEL A. RAKES
REVISIONS: NUMBER DATE

**CIVIL-
SITE PLAN**

C-1.3