


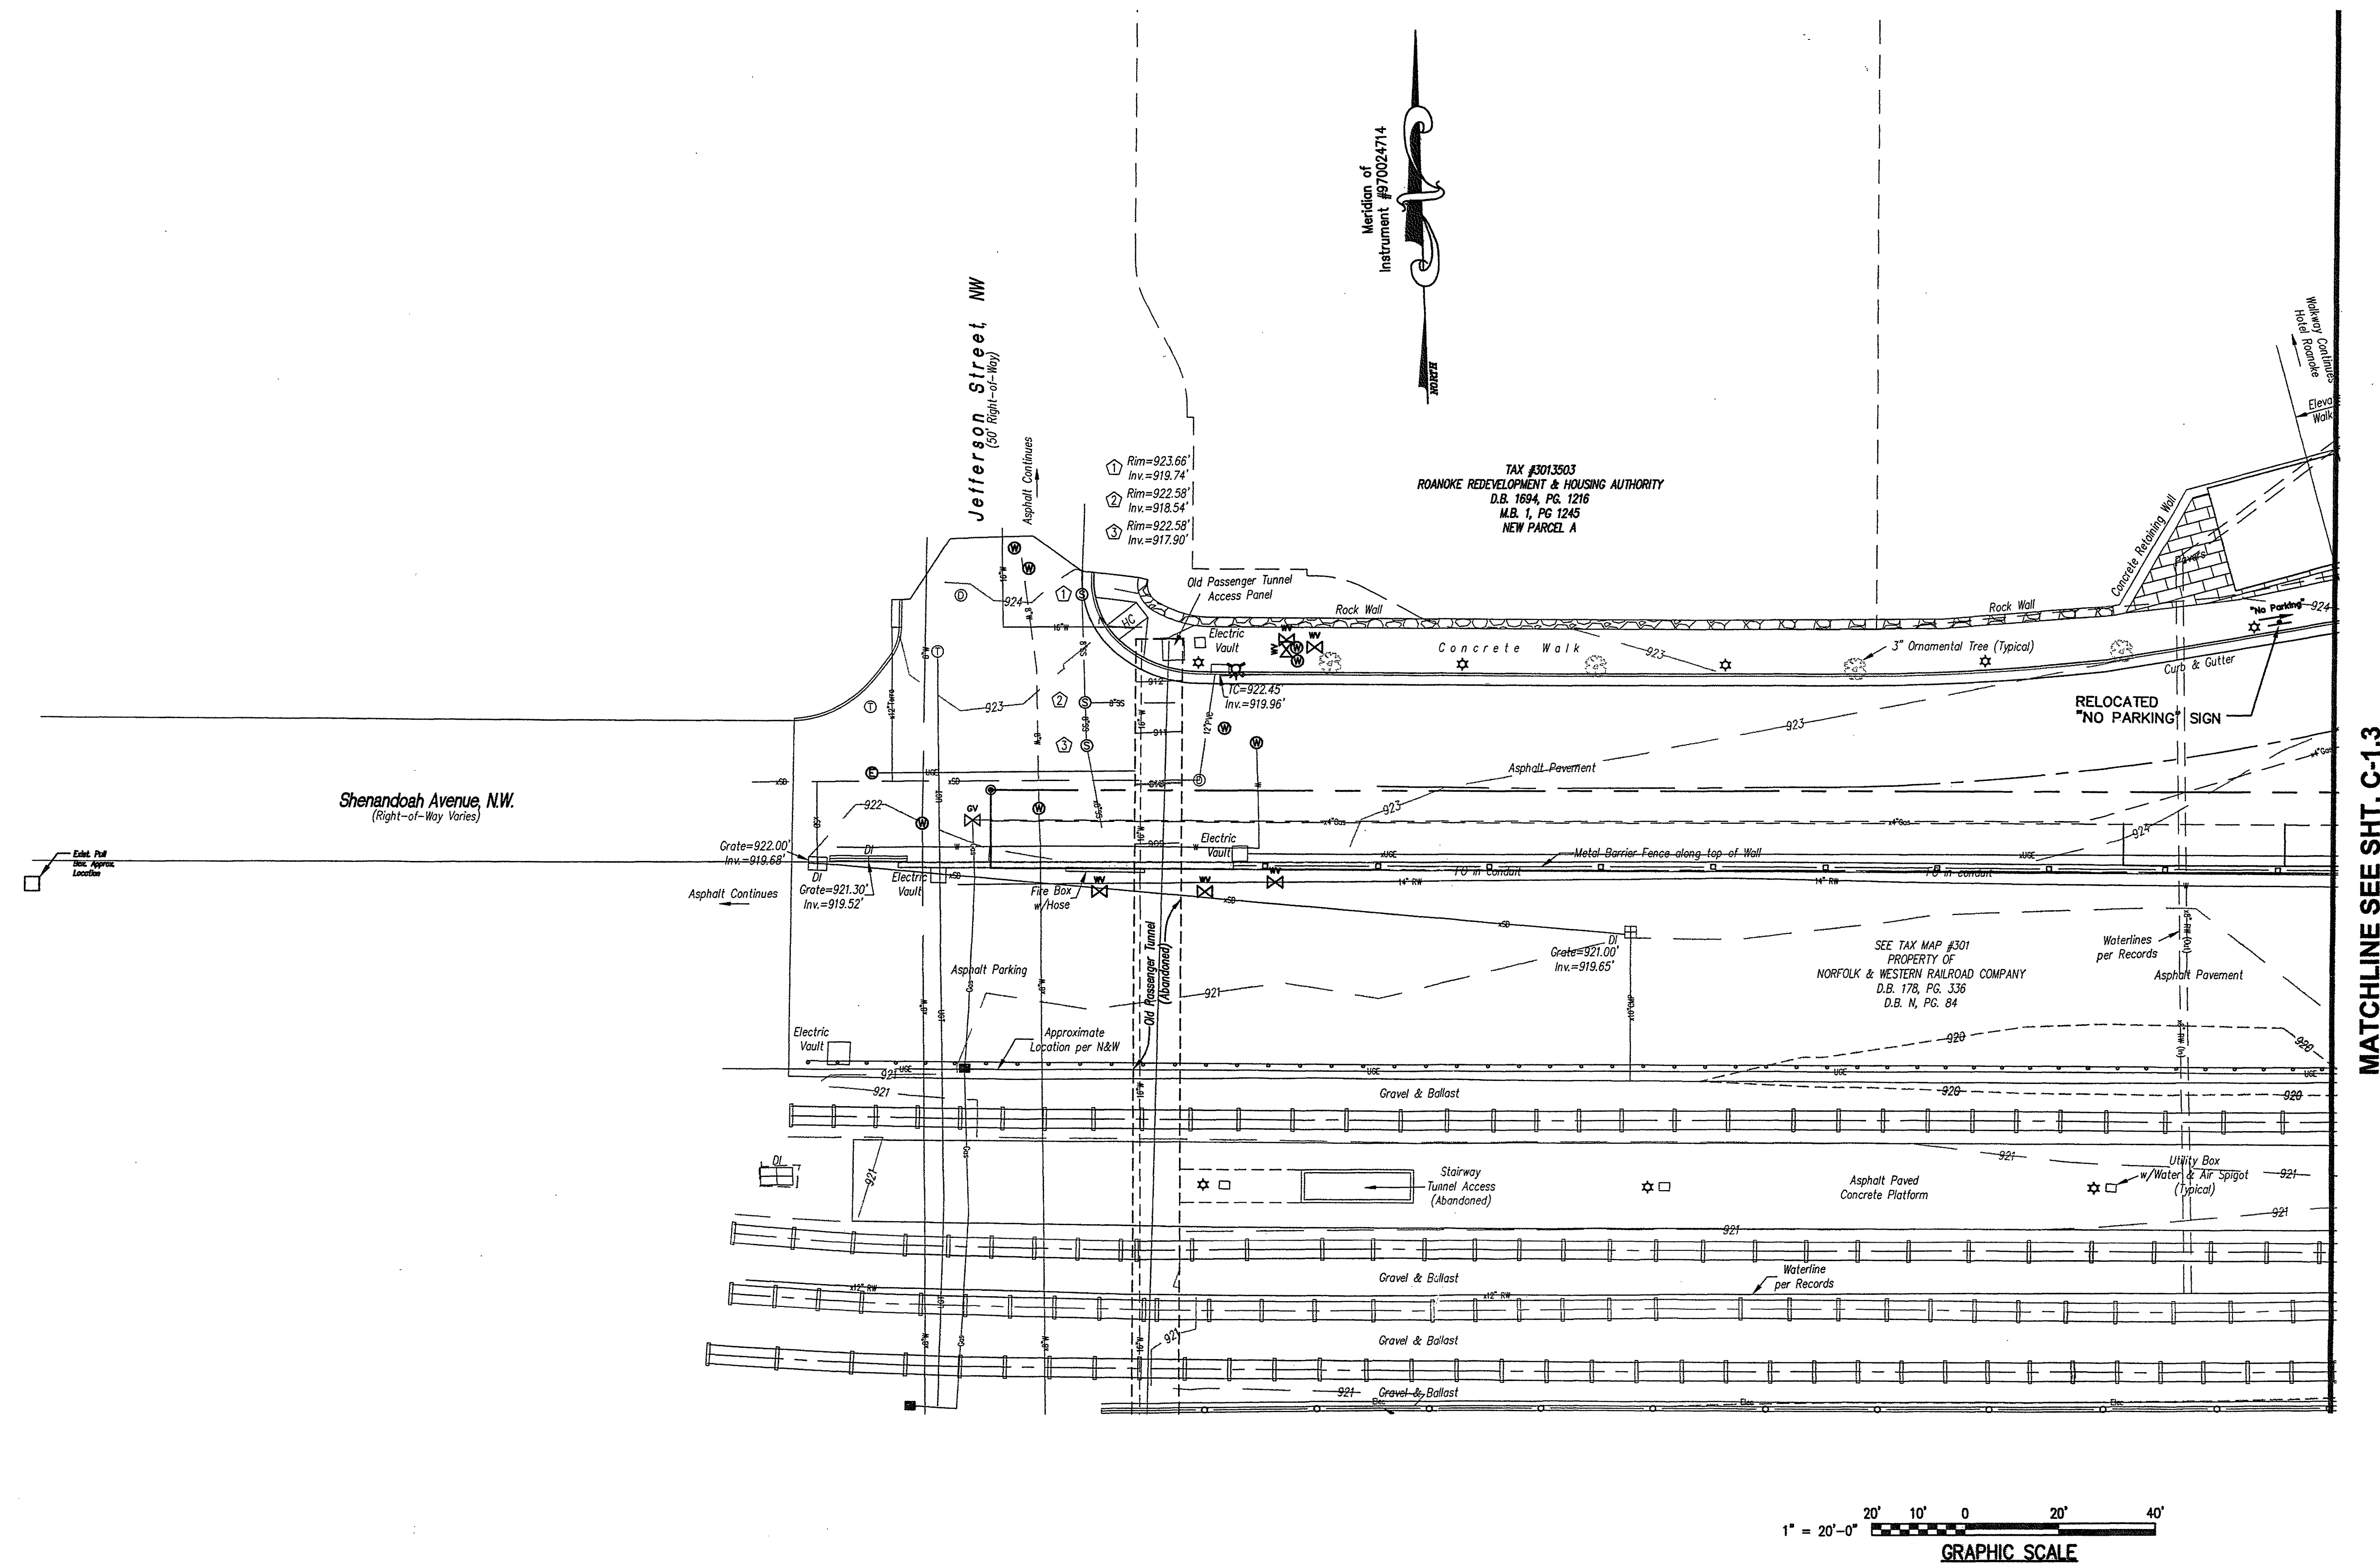


MATCHLINE SEE SHT. C-1.3

1" = 20'-0"



GRAPHIC SCALE

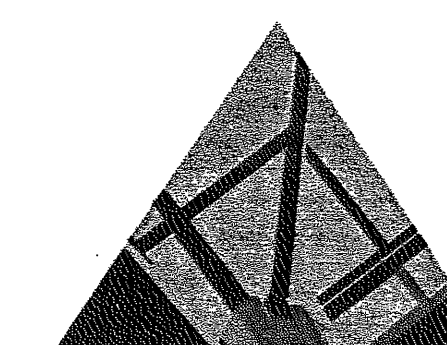


10 CHURCH AVE SE, PLAZA SUITE 1 ROANOKE, VIRGINIA 24011 540.342.6001
ROANOKE • MARION

ROANOKE PASSENGER STATION

PHASE THREE-SITE WORK

ROANOKE, VIRGINIA

SPECTRUM DESIGN PROJECT NO. 00124

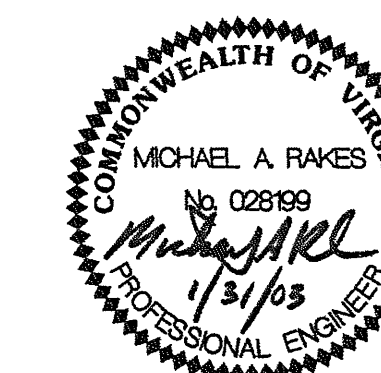

DATE 31 January 2003
DESIGN ARCHITECT
PROJECT ARCHITECT
PROJECT ENGINEER
CHECKED BY
DRAWN BY
REVISIONS
NUMBER
DATE

	SHEET TITLE
--	-------------

SHEET TITLE
CIVIL- SITE PLAN

C-1.4