


**JACK ST. CLAIR
INC.**
**PIPE LINE
CONTRACTORS**

P. O. Box 12961
Roanoke, Va. 24030
Office 344-1657
Fax 344-0285

(COOL TOWER) As-Built Page
A-142

JOB PATRICK HENRY HIGH SCHOOL
SHEET NO 1 OF 3
CALCULATED BY CHRIS HURD DATE 8-10-05
CHECKED BY _____ DATE _____
SCALE NTS

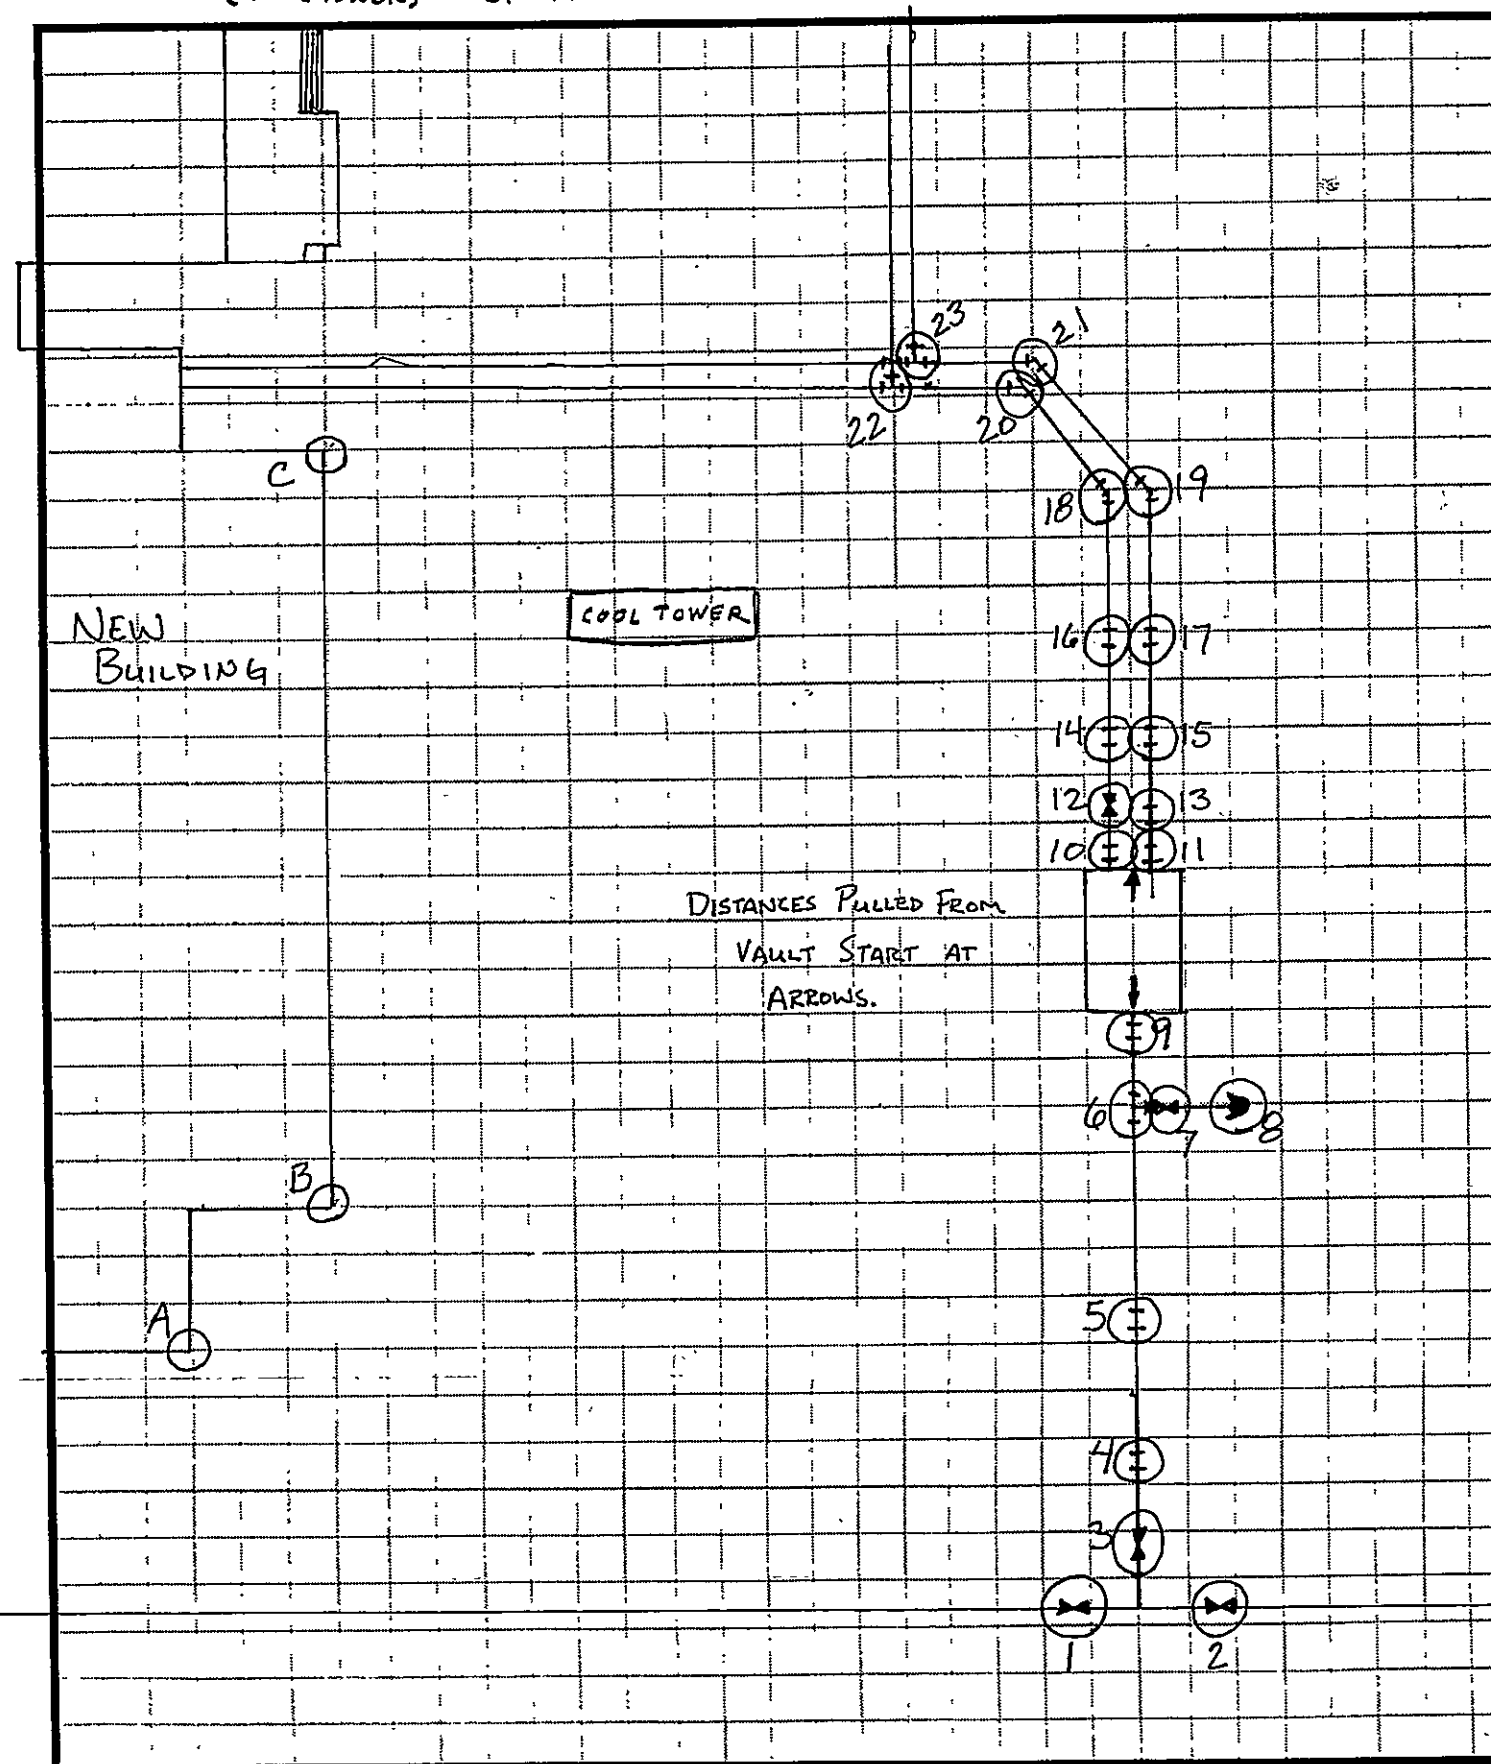

**JACK ST. CLAIR
INC.
PIPE LINE
CONTRACTORS**

P. O. Box 12961
Roanoke, Va. 24030
Office 344-1657
Fax 344-0285

(COAL TOWER) As-Built Page

JOB PATRICK HENRY HIGH SCHOOL
SHEET NO 2 OF 3
CALCULATED BY CHRIS HURD DATE 8-10-05
CHECKED BY _____ DATE _____
SCALE NTS

FROM	To	DESCRIPTION	DISTANCE	DIST. FROM VALVE
A	1	8" GV	84'	55'
B	1		93'	
A	2	8" GV	91.3	54.6
B	2		98.6	
A	3	8" GV	87'	51.5'
B	3		95'	
A	4	8" 22½"	83'	42'
B	4		94'	
A	5	8" 22½"	78.4	14'
B	5		93.5'	
A	6	8" 6" TEE	78.3'	9'
B	6		94'	
A	7	6" GV	82'	9.7'
B	7		97.8'	
A	8	FIRE HYDRANT	87.3'	12'
B	8		102.9'	
A	9	8" SLEEVE	97.6	2'
B	9		81.1'	
A	10	8" SLEEVE	83'	2.9'
B	10		100.8'	
A	11	3" 6" INCREASER	84.3	2.6'
B	11		103.6'	
C	11			
B	12	POST INDICATE VALVE	85.3'	7.7'
C	12		98.4'	
B	13	6" SLEEVE	87.2	4.9'
C	13		102.6'	
A	14	8" 22½"	87.5'	12.4'
C	14		95.8'	
B	15	6" 22½"	90.7	14.4'
C	15		97.7'	
B	16	8" 22½"	92.5'	22.1'
C	16		92.5'	
B	17	6" 22½"	93.7'	21.7'
C	17		94.2	

**JACK ST. CLAIR
INC.**
**PIPE LINE
CONTRACTORS**


P. O. Box 12961
Roanoke, Va. 24030
Office 344-1657
Fax 344-0285

As-Built Page
C1-142

(cool tower)

JOB PATRICK HENRY HIGH SCHOOL
SHEET NO 3 OF 3
CALCULATED BY CHRIS HURD DATE 8-10-05
CHECKED BY _____ DATE _____
SCALE NTS

From	To	DESCRIPTION	DISTANCE	DISTANCE FROM VAULT
B	18	8" 45°	114'	56.7'
C	18		85.8'	
B	19	6" 45°	115.7'	58'
C	19		87'	
B	20	8" 45°	116.4'	70.1'
C	20		75.9'	
B	21	6" 45°	117.9'	71.6'
C	21		76.4'	
B	22	8" 45°	108.4'	72.9'
C	22		73.6'	
B	23	6" 45°	110.6'	73.8'
C	23		65'	

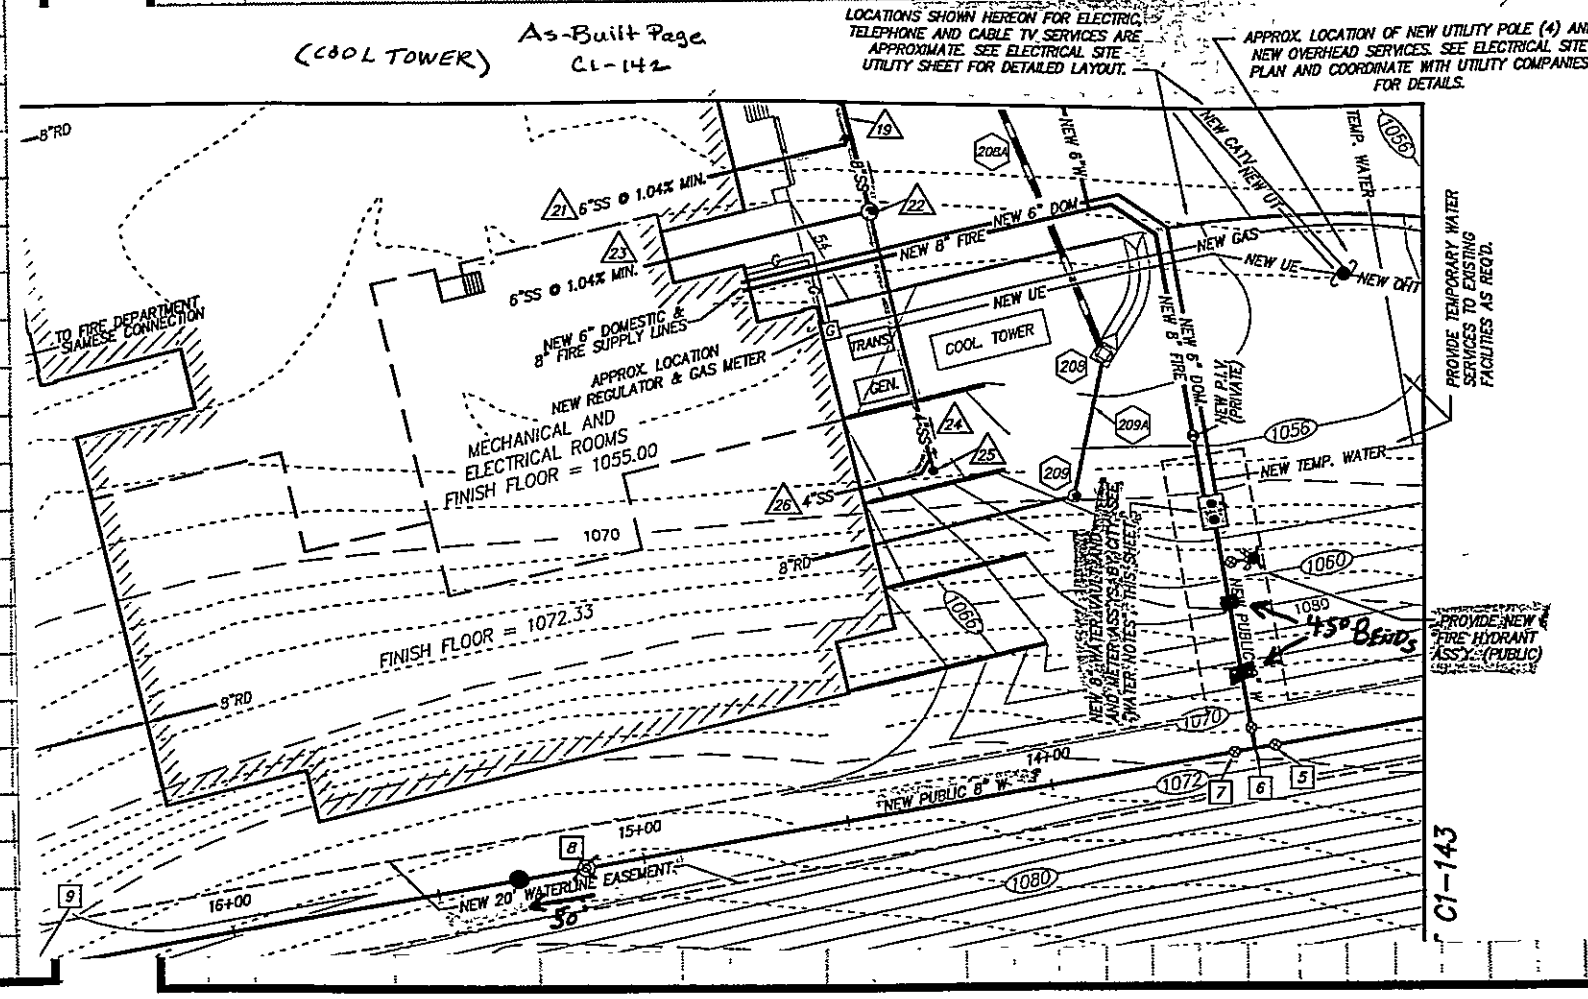

This architectural site plan illustrates the proposed expansion of the Gibbesey Hall. Key features include:

- Orientation and Reference:** A north arrow points towards the upper right. Match lines at the top indicate connections to sheets CI-140 and CI-142.
- Structural Details:** The plan shows the layout of columns, beams, and roof profiles for both the existing hall and the new addition. Annotations specify materials and construction methods, such as "PROPOSED 8\"


**JACK ST. CLAIR
INC.**
**PIPE LINE
CONTRACTORS**

P. O. Box 12961
Reno, NV. 89403
Office 344-1657
Fax 344-0285

As-Built Page
01-145

(Gibsony Hall)

JOB NO. 100 PATRICK HENRY H.S.
SHEET NO. _____ OF 2
CALCULATED BY CHRIS HURD DATE 8-10-05
CHECKED BY _____ DATE _____
SCALE NTS

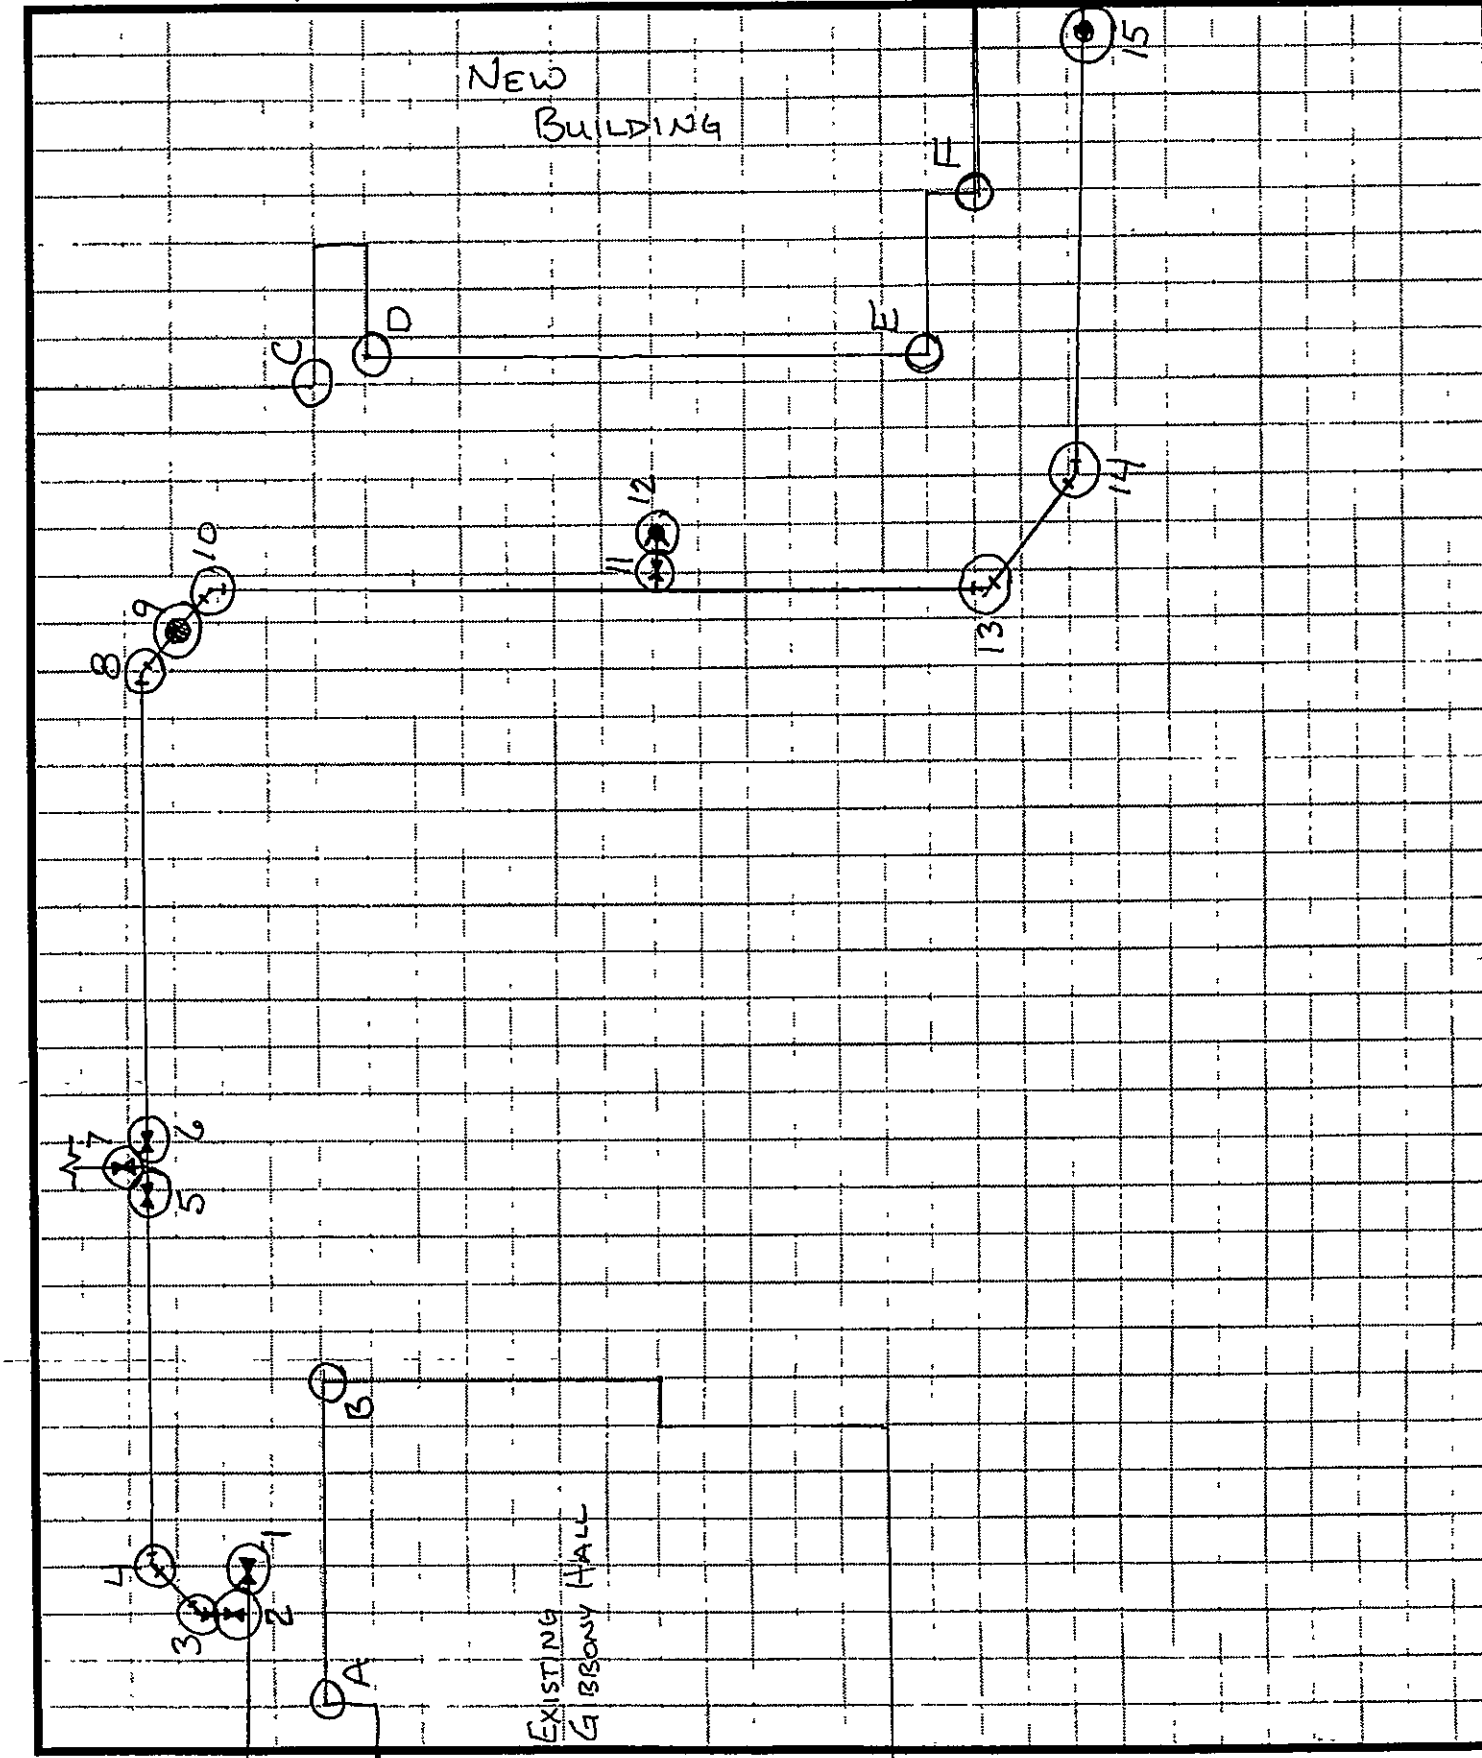

**JACKSON'S CLAIM
INC.
PIPE LINE
CONTRACTORS**

P. O. Box 12961
Roanoke, Va. 24030
Office 344-1657
Fax 344-0285

(Gibboney Hall)
As-Built Page
01-142

JOB PATRICK HENRY HIGH SCHOOL
SHEET NO. 2 OF 2
CALCULATED BY CHAS HUND DATE 8-10-05
CHECKED BY _____ DATE _____
SCALE NTS

FROM	TO	DESCRIPTION	DISTANCE
A	1	END OF LINE VALVE	37.2'
B	1		40.7'
A	2	8" TAPPING VALVE	37.3'
B	2		43.1'
A	3	8" 45°	38.5'
B	3		44.5'
A	4	8" 45°	51'
B	4		42'
A	5	8" G.V.	109'
B	5		49'
A	6	8" G.V.	123'
B	6		62'
A	7	6" G.V.	119.3'
B	7		61'
C	8	8" 45°	78.2'
D	8		90'
C	9	IN LINE BLOW OFF	70.0'
D	9		81'
C	10	8" 45°	60.7'
D	10		72'
D	11	6" G.V.	73.8'
E	11		73'
E	12	FIRE HYDRANT	73.2'
F	12		72.2'
E	13	8" 45°	54.5'
F	13		89'
E	14	8" 22 1/2°	46'
F	14		75.7'
F	15	AIR RELEASE	43.5'
G	15		99.5'


2

(Parsons Hall) As-Built Page C-140

REMOVE TEMPORARY WATER CONNECTIONS TO EXISTING FACILITIES AS REQUIRED.


(Parsons Hall) As-Built Page: C1-140


JOB: PATRICK HENRY HIGH SCHOOL
SHEET NO. 1 OF 1
CALCULATED BY: CHRIS HURD DATE: 8-15-08
CHECKED BY: _____ DATE: _____
SCALE: NTS

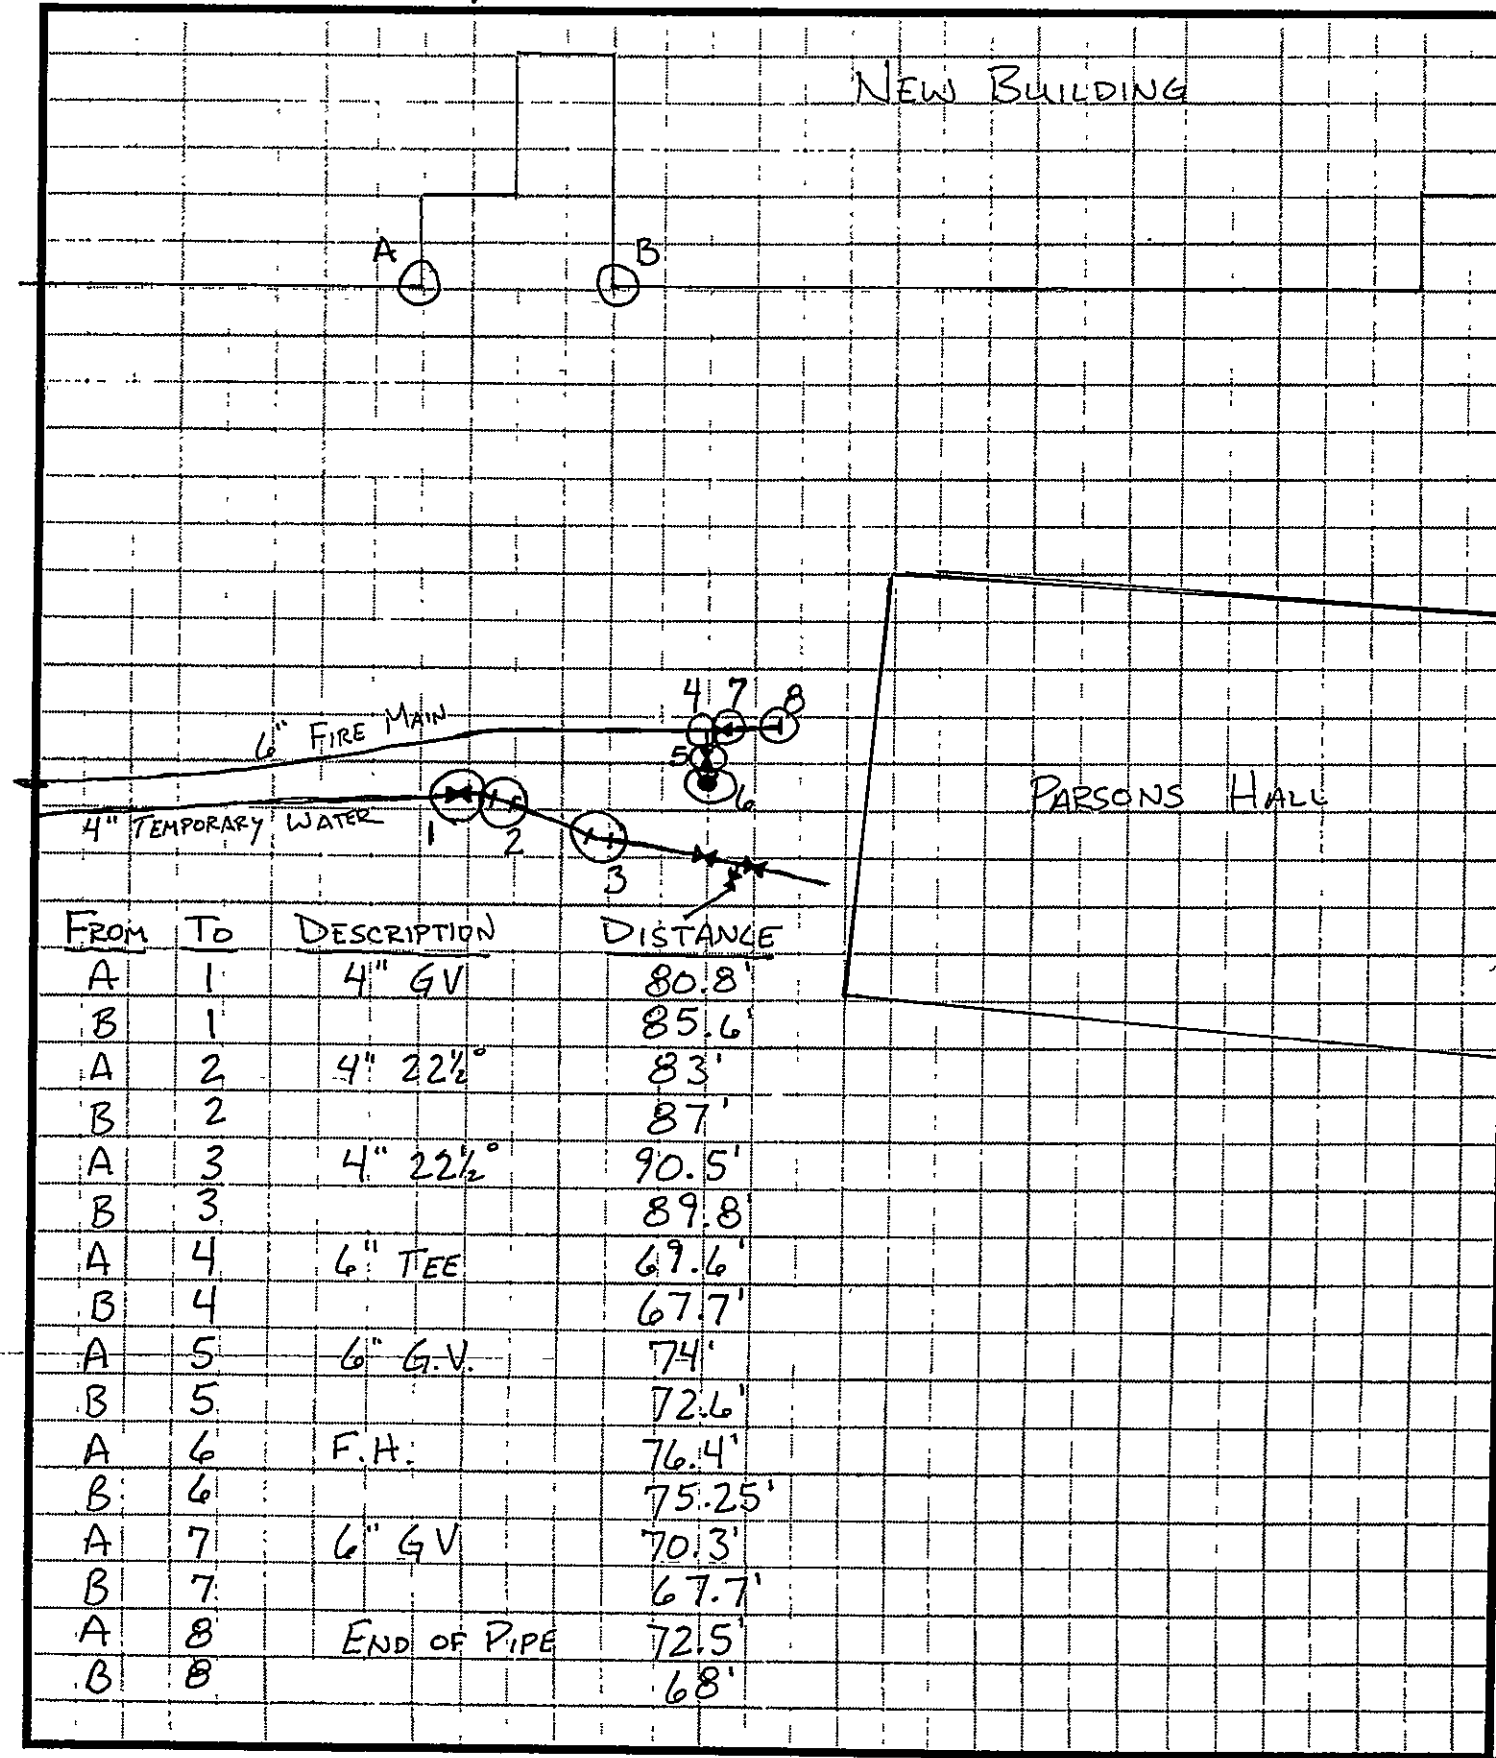

As-Built Pave
EXISTING GIBBONEY HALL
As-Built Veg

 Job: Patrick Henry High School
 SHEET NO. 1 OF 1
 CALCULATED BY: Erik Wright DATE: 6-5-05
 CHECKED BY: _____ DATE: _____
 SCALE: NTS

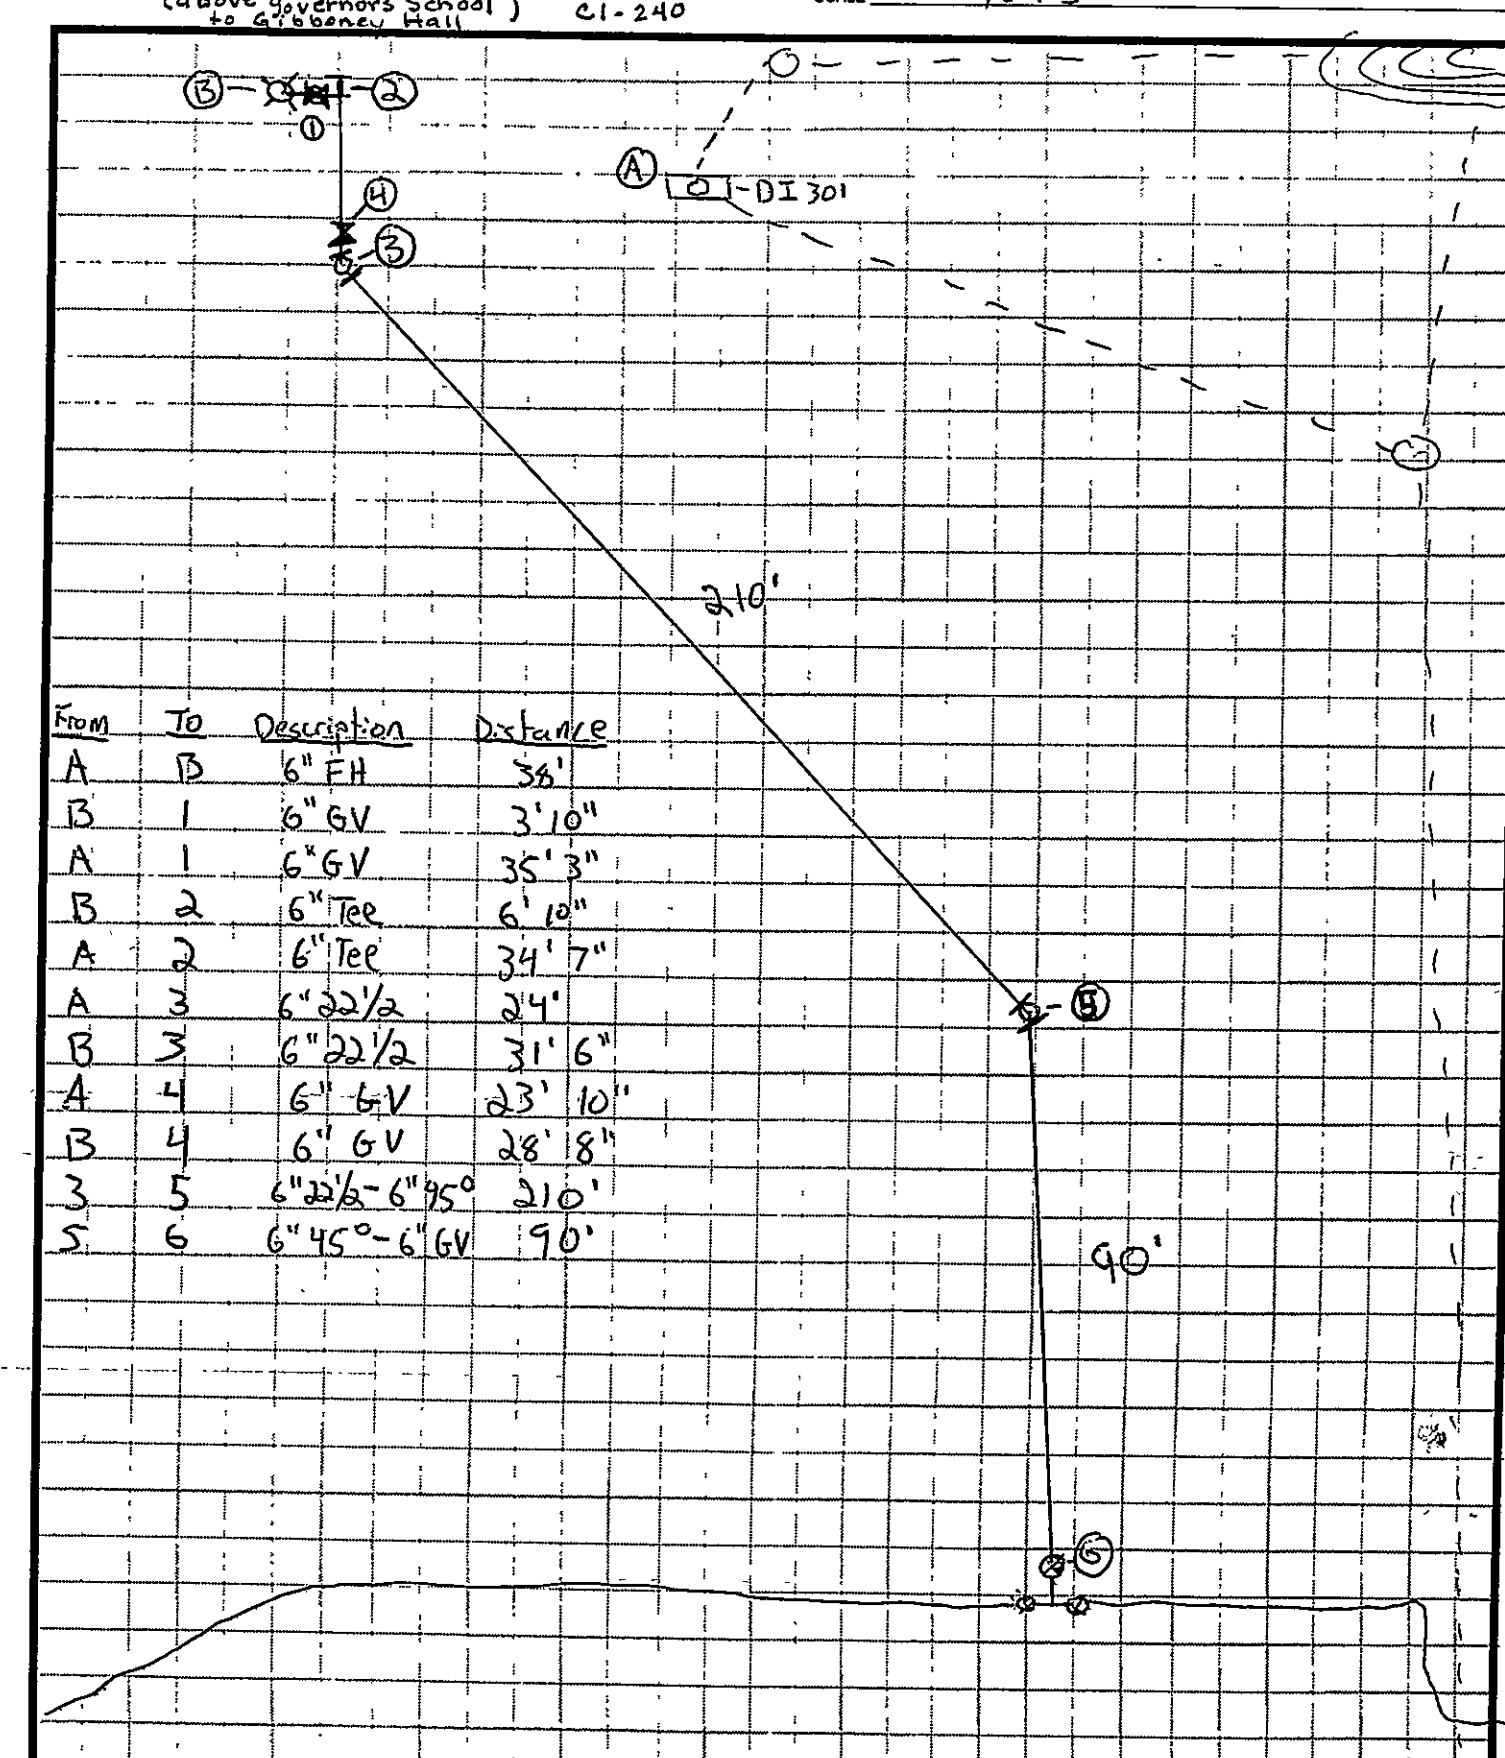



LABOR FINDERS

ALEXANDRIA, VA
(703) 367-5628

ARLINGTON, VA
(703) 524-3204


FAIRFAX, VA
(703) 278-5307

FREDERICKSBURG, VA
(840) 878-4707

MANASSAS, VA
(703) 360-1953

RICHMOND, VA
(804) 254-8397

ROANOKE, VA
(540) 342-4442

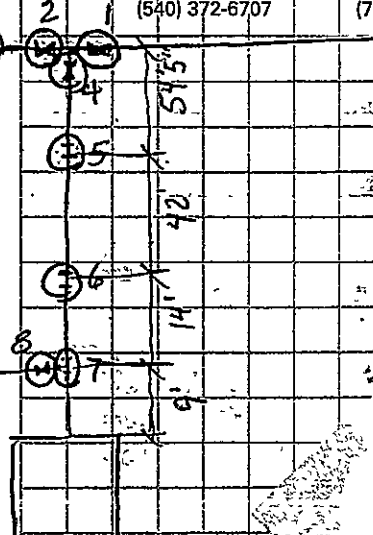

To	Desc	Dist	
A	1	8' GN	86'
A	1	8' GN	86'
A	2	8' GN	91.5'
A	2	8' GN	93.6'
A	3	EGP	97.2'
B	3		107'
A	4	8' GN	81'
A	5		95'
A	5	22'	83'
B	5		94'
A	6	22'	78.9'
B	6		93.5'
A	7	8' GN	78.3'
B	7		94'
A	8	6' GN	62'
B	8		97.8'
A	9	F.H	87.3'
B	9		102.9'
B			
B			

Staffing Solutions For Today's Business!

www.laborfinders.com

**PATRICK HENRY
HIGH SCHOOL**

PHASE I
School Site Project No. 124-39A
Literary Loan No. 11187

	ISSUED FOR CONSTRUCTION	04/02/04
NUMBER	ISSUE	DATE
Sheet Information		
Date	02/01/2007	
Job Number	800200.000	
Scale		
Drawn		
Checked		
Approved		

VALVE SHEETS

Sheet

AS - BUILT C1-143A