

Caldwell White – Civil Engineers
4203 Melrose Avenue
Roanoke, Virginia 24017
540-366-3400 (p) 540-366-8702 (f)


The Fitch Studio
1740 20th Street, NW
Washington, DC 20009
202-588-0148 (p) 202-588-0149 (f)

Kinsey Shane & Associates – Architects
and Structural Engineers
201 West Main Street
Salem, Virginia 24153
540-389-8655 (p) 540-389-9130 (f)

Lawrence Perry & Associates, Inc
Mechanical & Electrical Engineers
30A West Church Avenue
Roanoke, Virginia 24011
540-342-1816 (p) 540-344-3410 (f)

Faassen & Associates – Food Service
8526 Sunflower Drive
Charlotte, North Carolina
204-536-9234 (f)

vanBlaricom & Frantz - Interior Designers
112 West Kirk Avenue
Roanoke, Virginia 24015
540-344-4098 (p) 540-344-4295 (f)

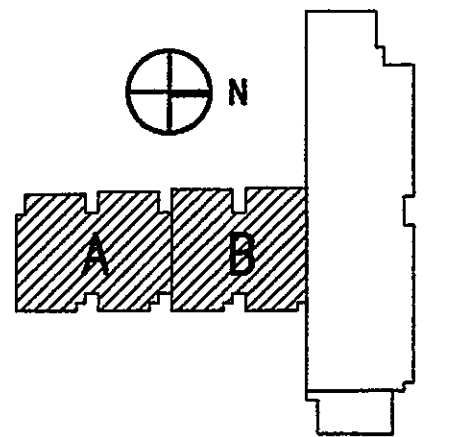

PHASE I
School Site Project No. 124-39A
Literary Loan No. 11187


[illegible]

Copyright © 2004 PERKINS & WILL

Date	04/02/04
Job Number	800200.000
Scale	1" = 30'
Drawn	NAC
Checked	WDC
Approved	LPA
	Title

Sheet


E1-100

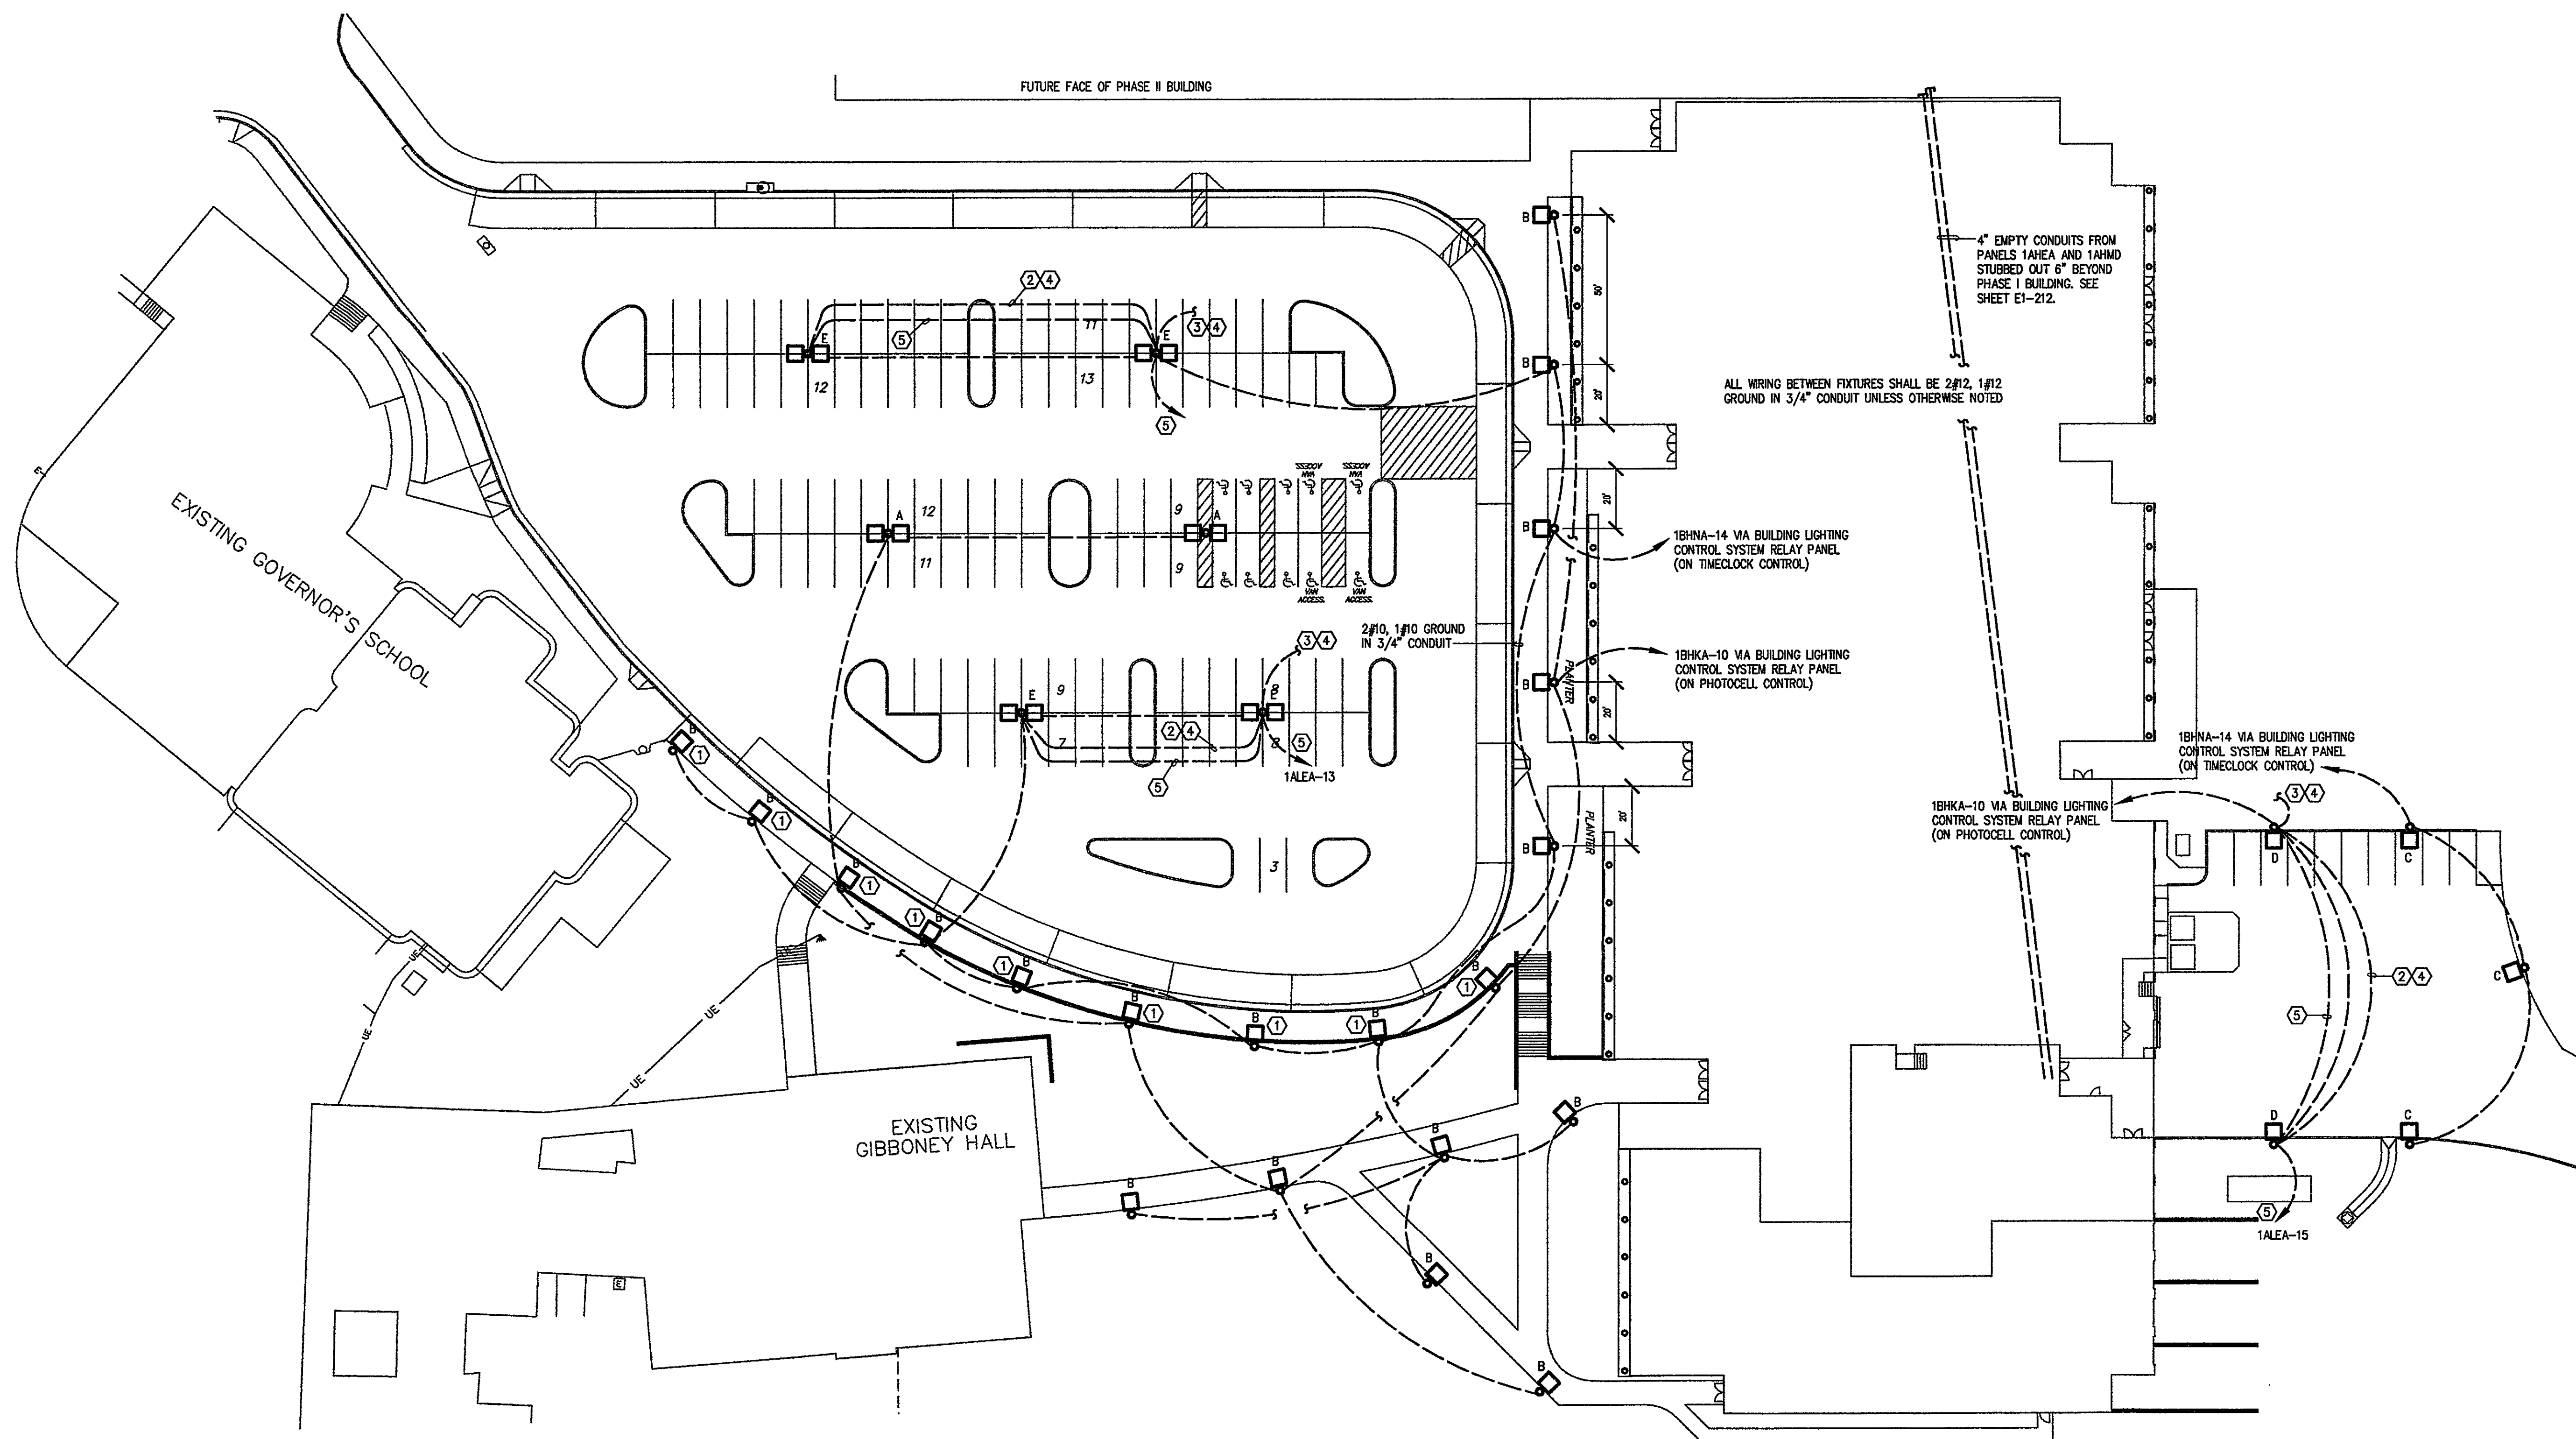


SCALE: 1" = 30'-0"

1. COORDINATE LOCATION OF LIGHT WITH TREE GRATES IN FIELD WITH ARCHITECT.
2. 1" CONDUIT FOR CAMERA CONTROL WIRING.
3. 1 1/4" CONDUIT TO SECURITY OFFICE 171 SHEET E1-400.
4. CAMERA CONTROL WIRING BY OTHERS.
5. CIRCUIT FOR CAMERA HEATERS. CONNECT HEATERS AS DIRECTED BY CAMERA INSTALLER.

SITE LIGHTING FIXTURE SCHEDULE				
TYPE	MOUNTING	LAMP	DESCRIPTION	REMARKS
A	POLE	2-400W METAL HALIDE	LITHENIA KAD400MR4480SPD04DBL (2 HEADS PER POLE) PROVIDE SSS 29 4C DM28 DBL POLE	POLE AND FIXTURE SHALL BE BLACK. PROVIDE FULL BASE COVER
B	POLE	1-175 W METAL HALIDE	LITHENIA KAD175MR4480SPD04DBL PROVIDE SSS 15 4C DM19 DBL POLE	POLE AND FIXTURE SHALL BE BLACK. PROVIDE FULL BASE COVER
C	POLE	1-250W METAL HALIDE	LITHENIA KAD250MR4480SPD04DBL PROVIDE SSS 18 4C DM19 DBL POLE	POLE AND FIXTURE SHALL BE BLACK. PROVIDE FULL BASE COVER
D	POLE	1-250W METAL HALIDE	LITHENIA KAD250MR4480SPD04DBL PROVIDE SSS 18 4C DM19 DBL POLE	POLE AND FIXTURE SHALL BE BLACK. PROVIDE FULL BASE COVER PROVIDE 4" MOUNTING ARM TO MATCH FIXTURE ARM FOR SECURITY CAMERA MOUNTING B OTHERS.
E	POLE	2-400W METAL HALIDE	LITHENIA KAD400MR4480SPD04DBL (2 HEADS PER POLE) PROVIDE SSS 29 4G DM28 DBL POLE	POLE AND FIXTURE SHALL BE BLACK. PROVIDE FULL BASE COVER PROVIDE 4" MOUNTING ARM TO MATCH FIXTURE ARM FOR SECURITY CAMERA MOUNTING B OTHERS.

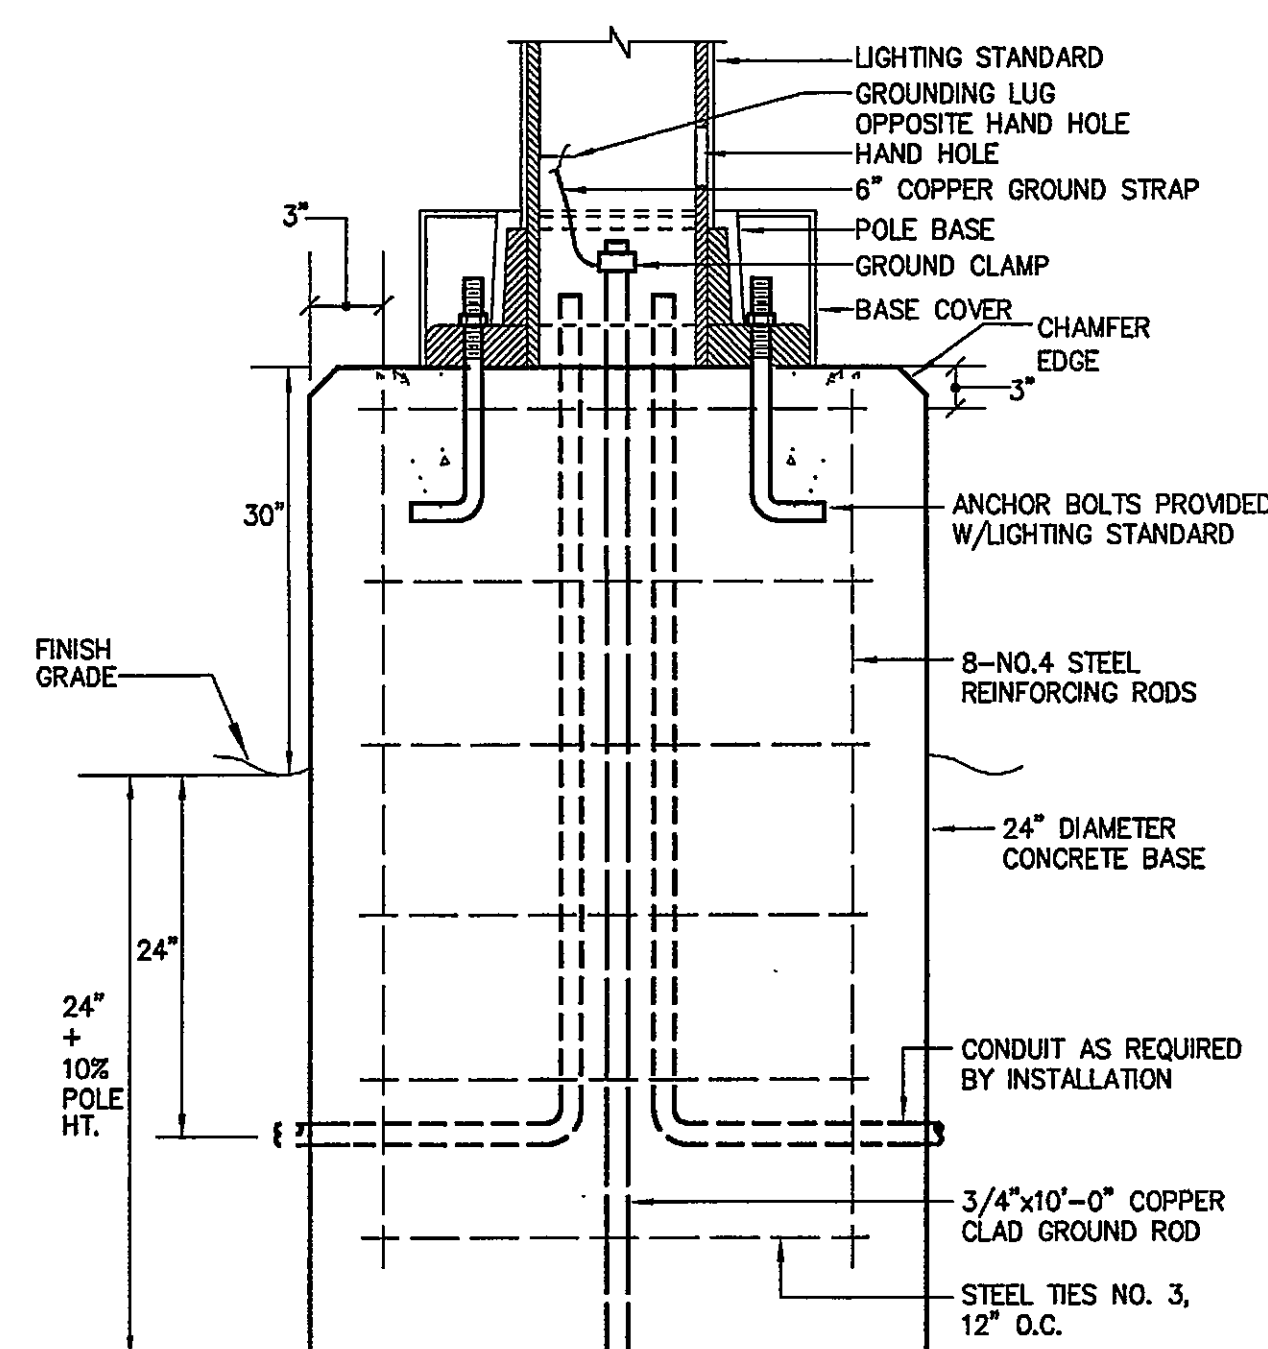

POLE BASE DETAIL FIXTURE
TYPES A, C, D AND E
NO SCALE

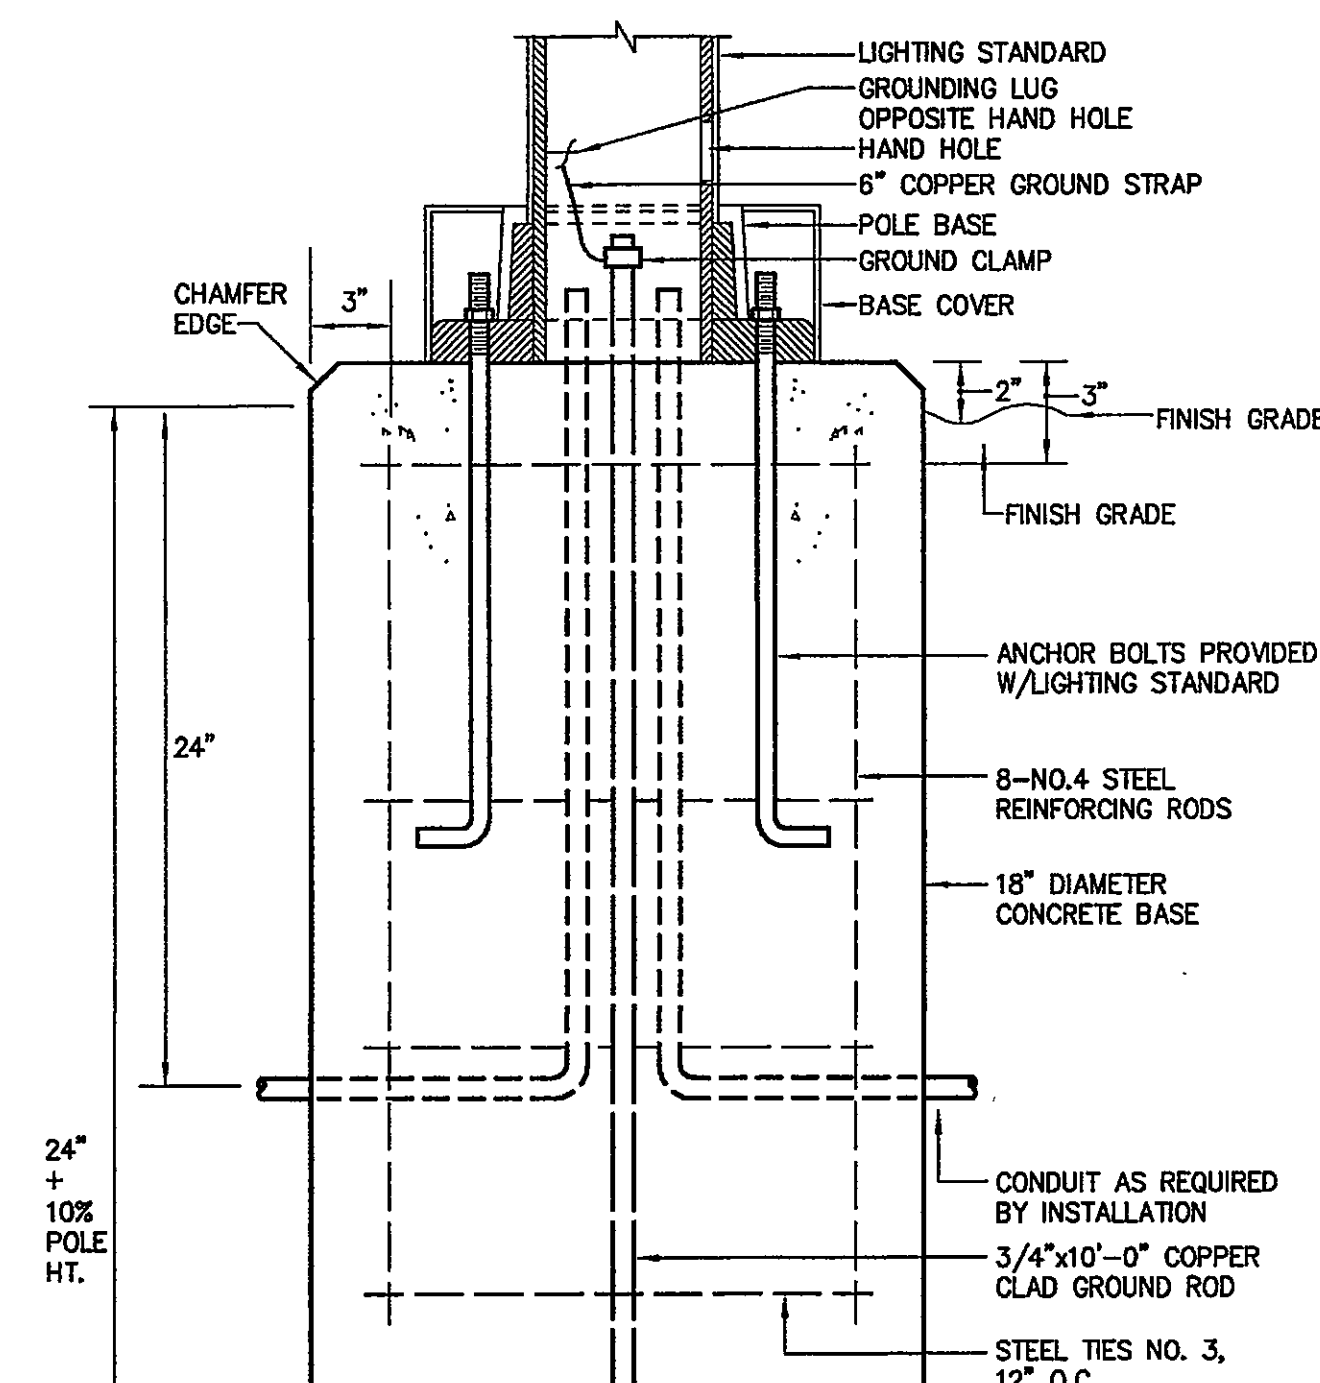

POLE BASE DETAIL
FIXTURE TYPE B
NO SCALE

