
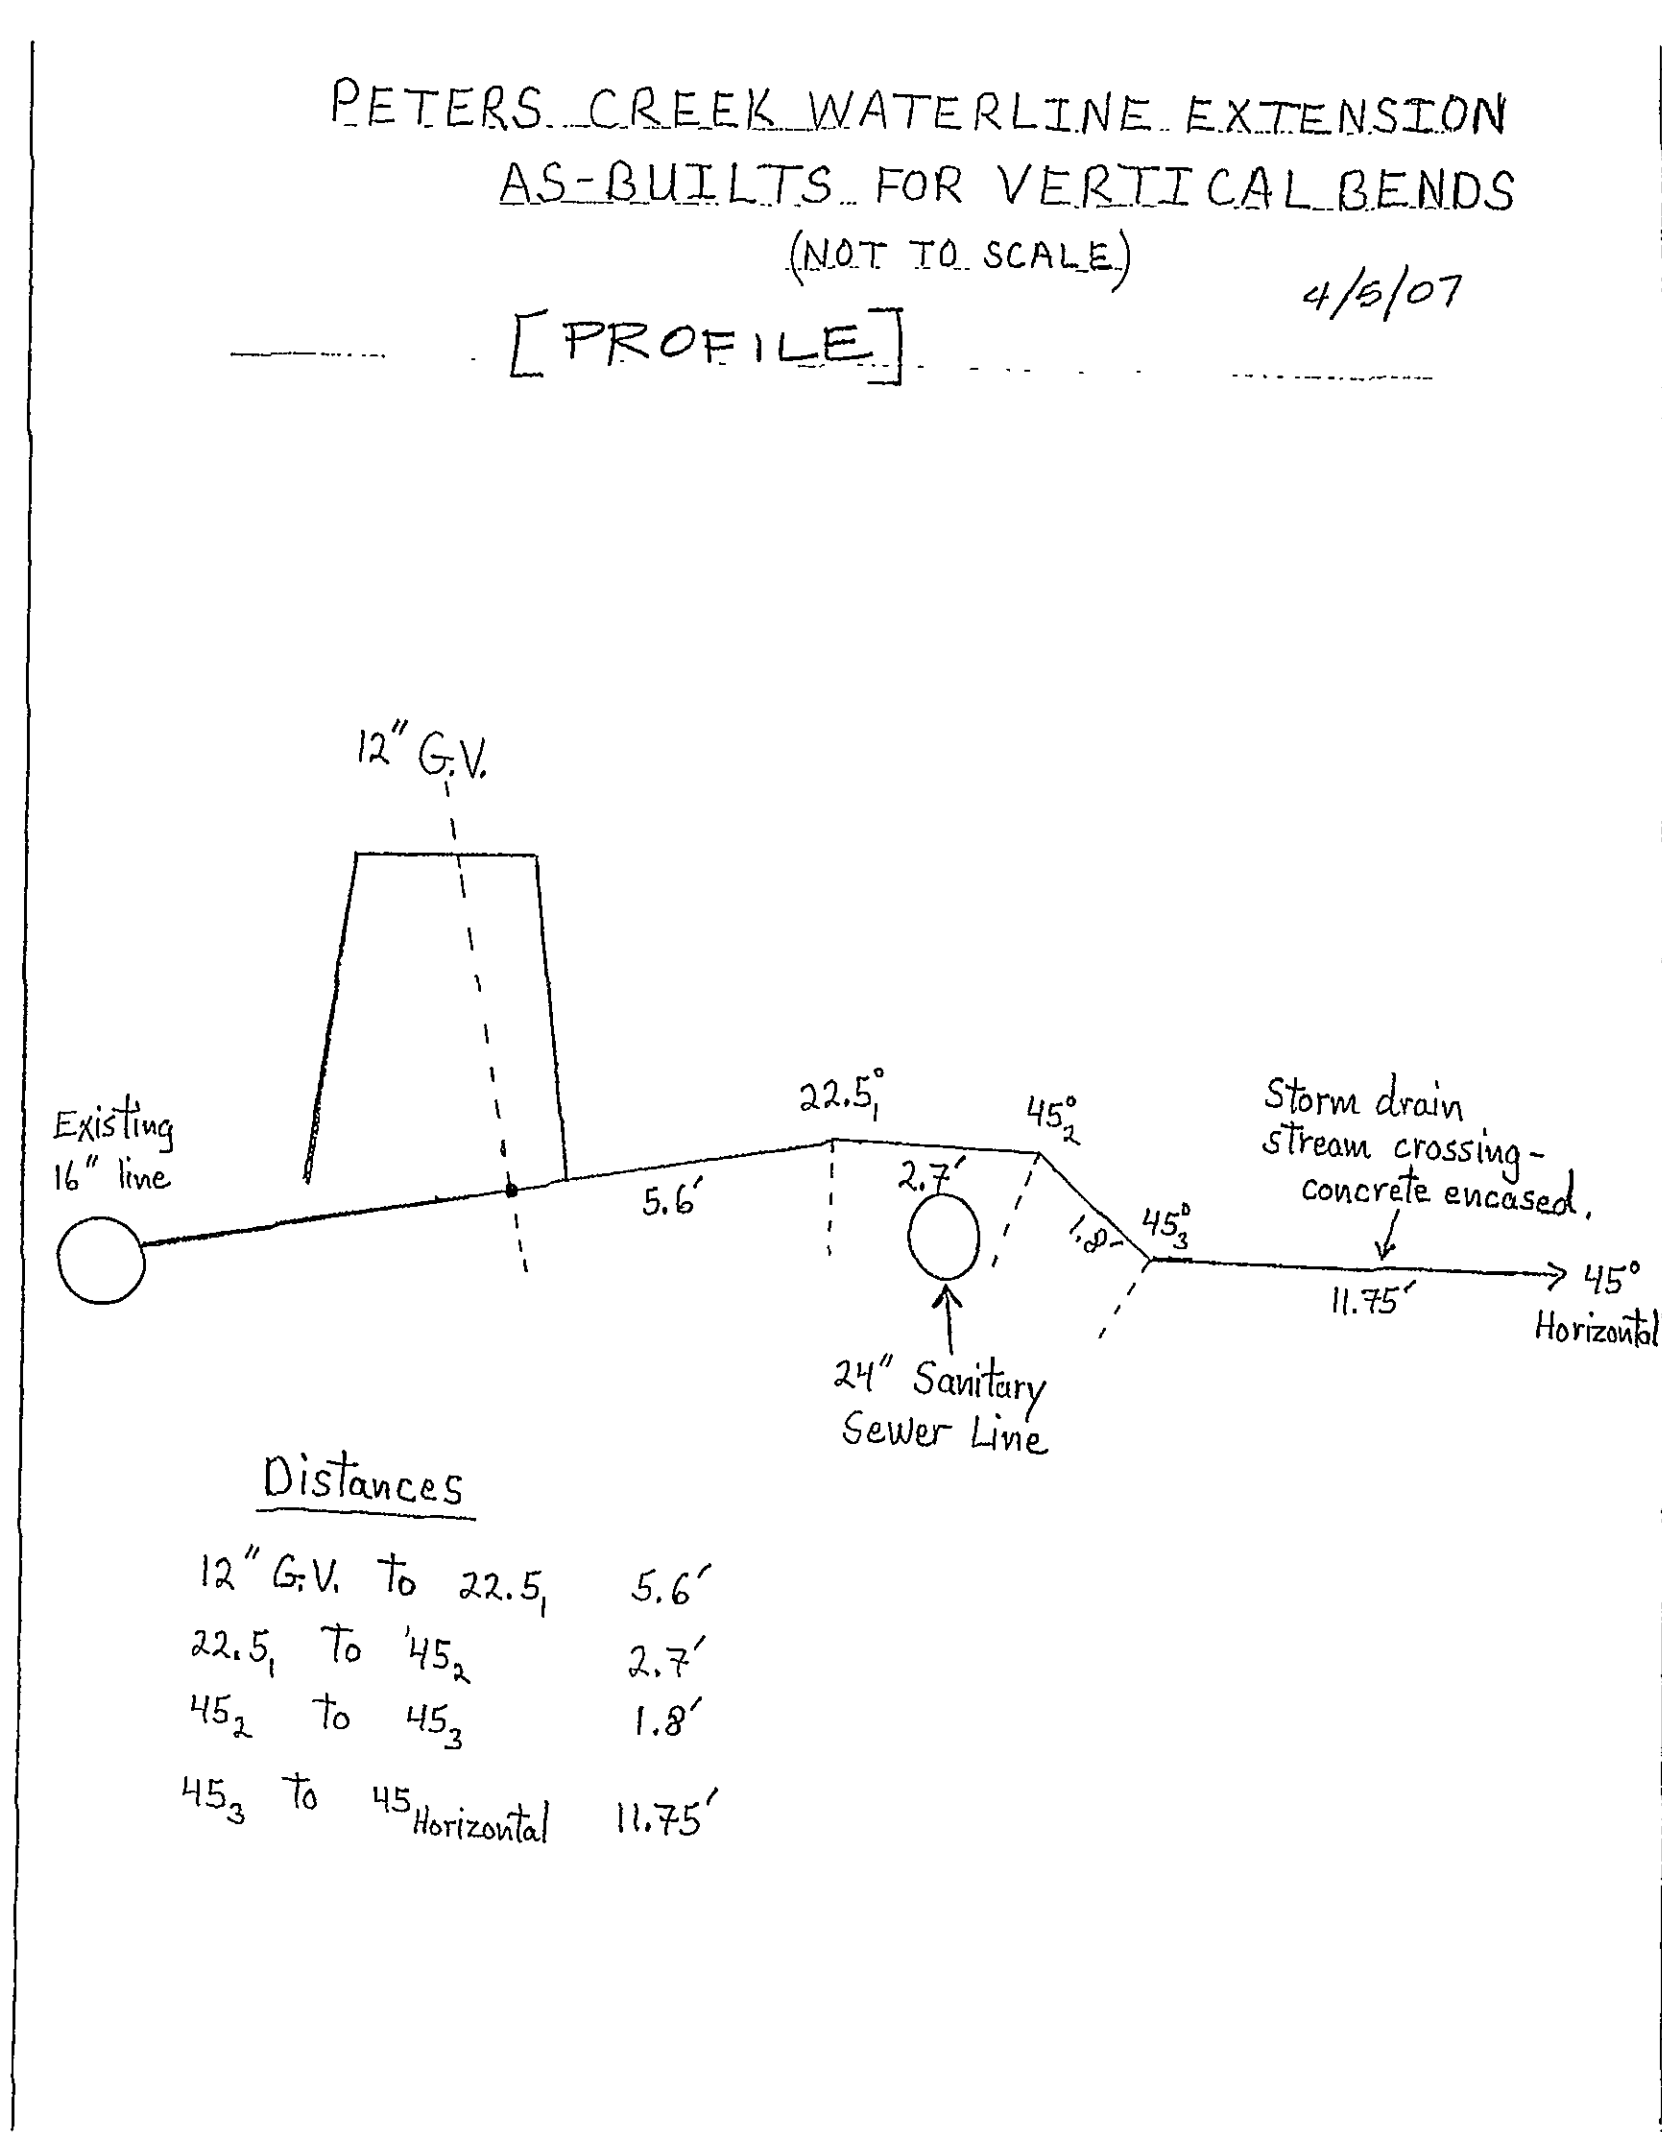
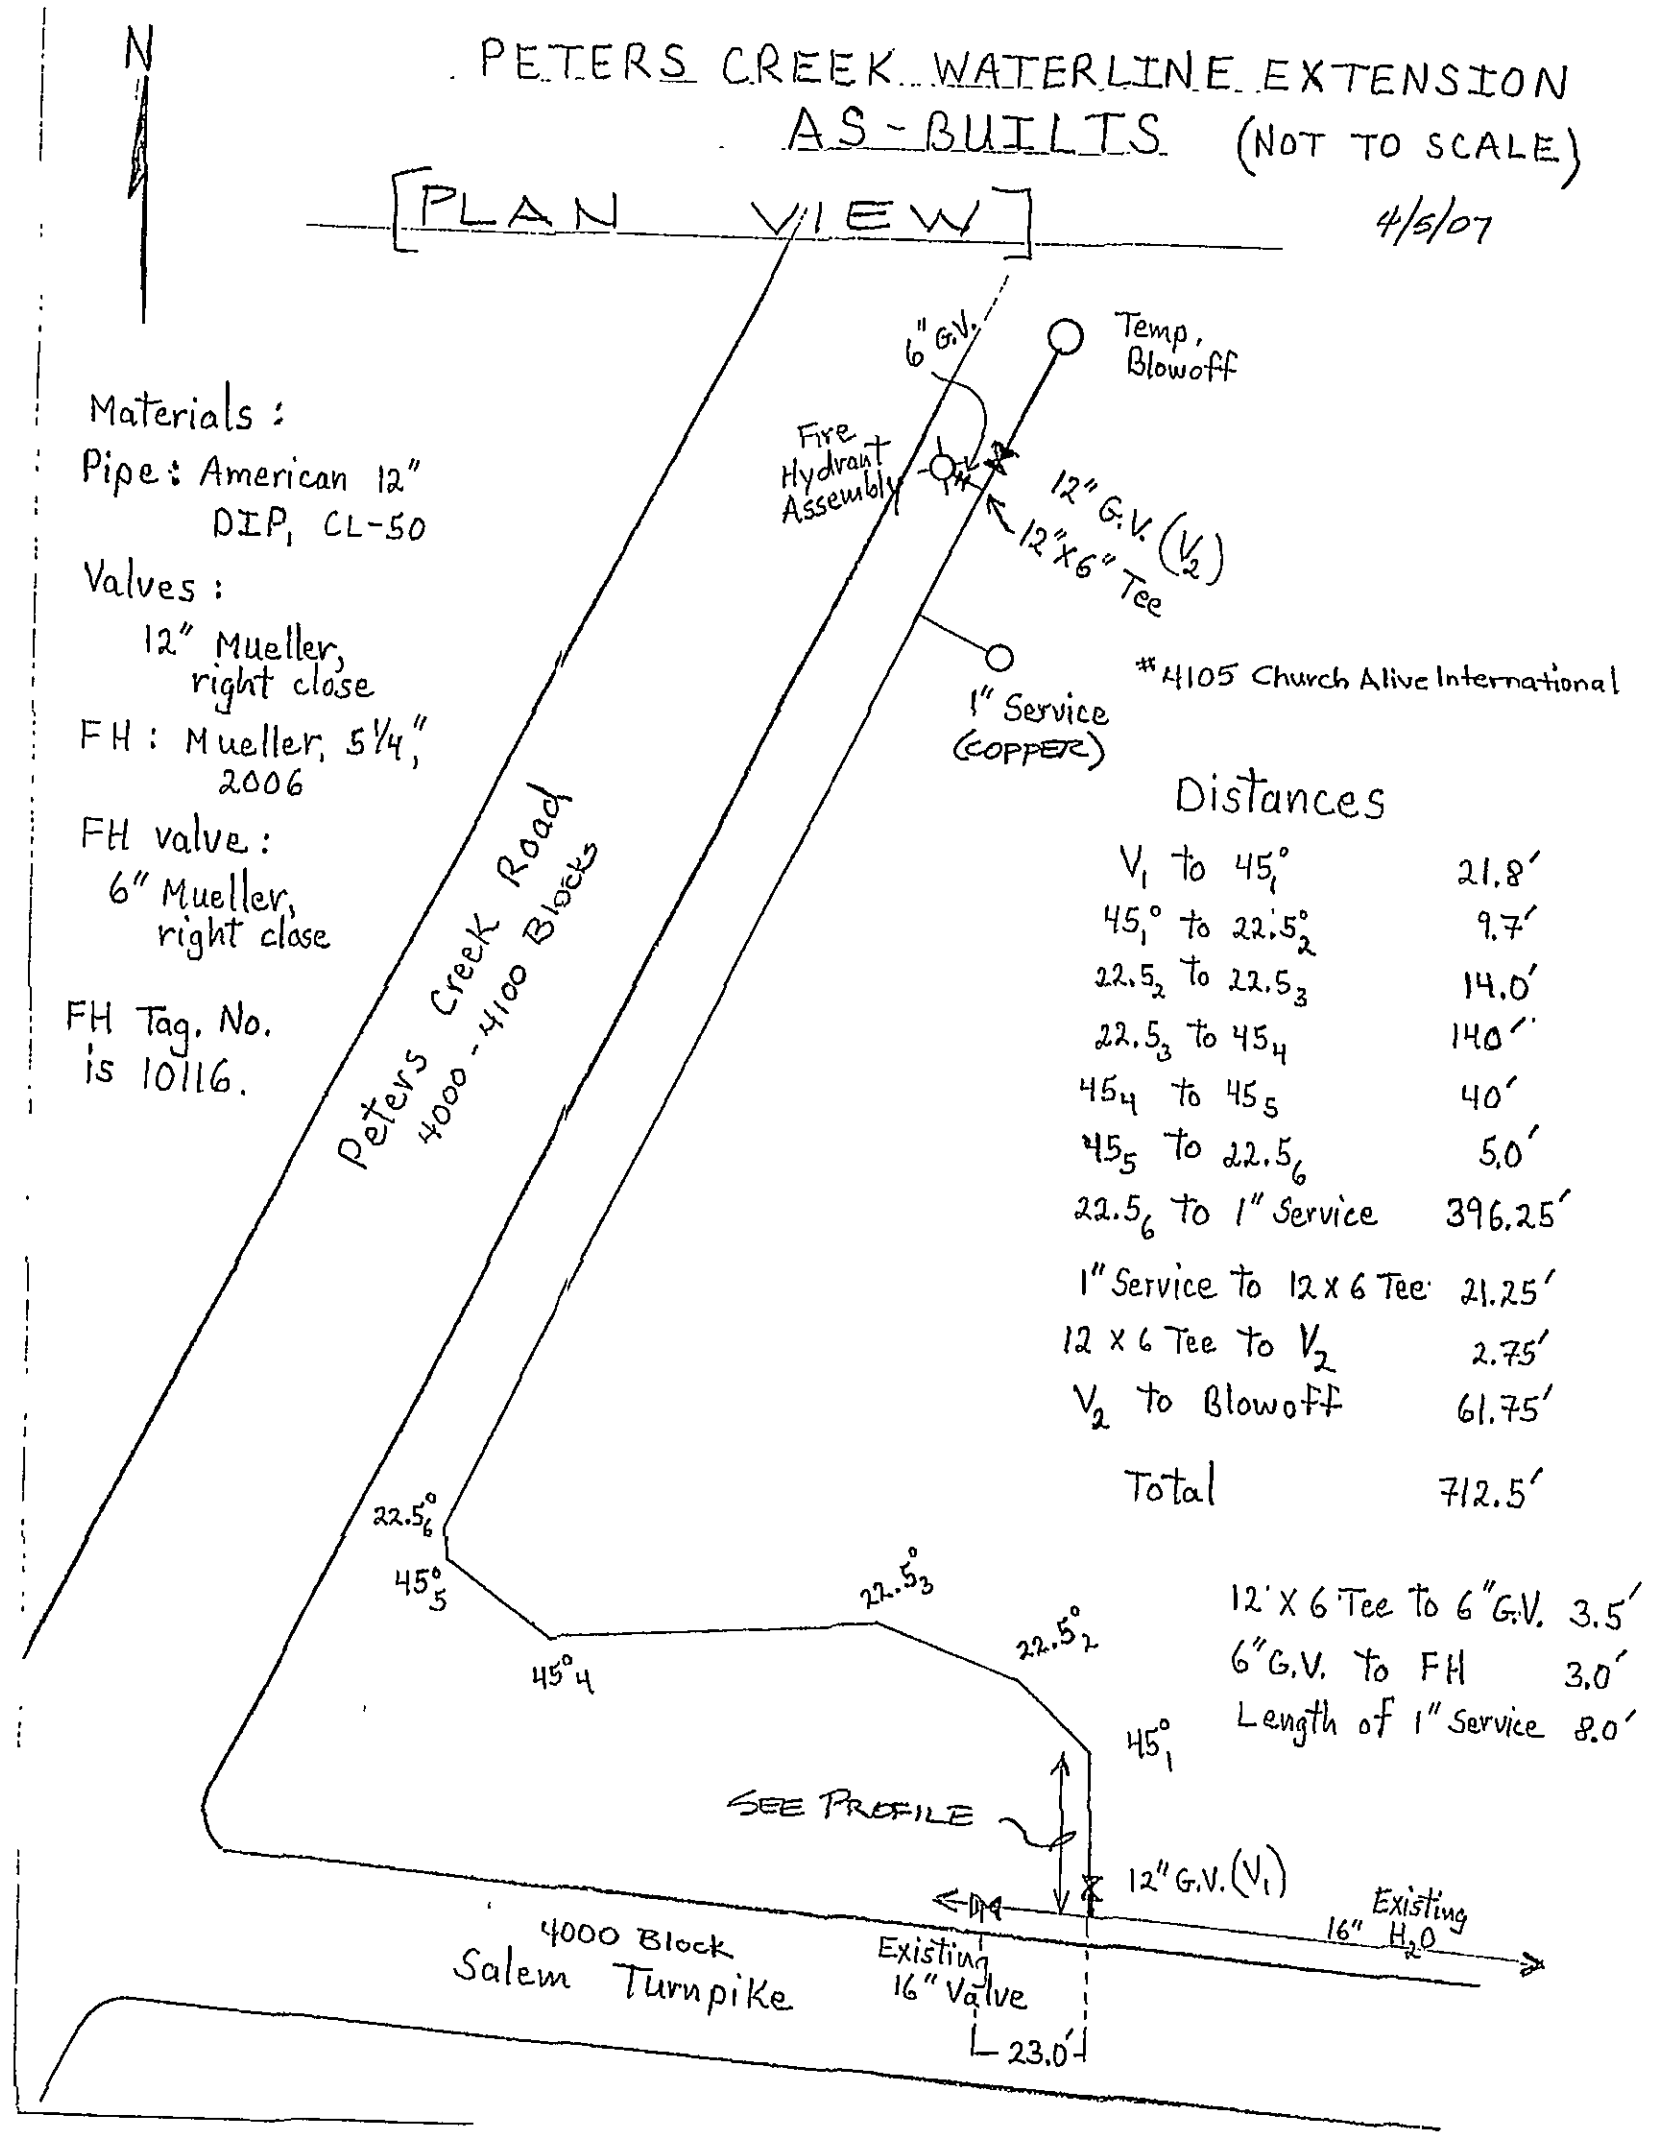


540' 6" W
460' 2 1/2" W
50' ROAD X 12" G.V.
6" x 2 1/2" VENT
16" x 6" TRAPPING GLEVE
6" VALVE
1" HYD
1" 6" VALVE

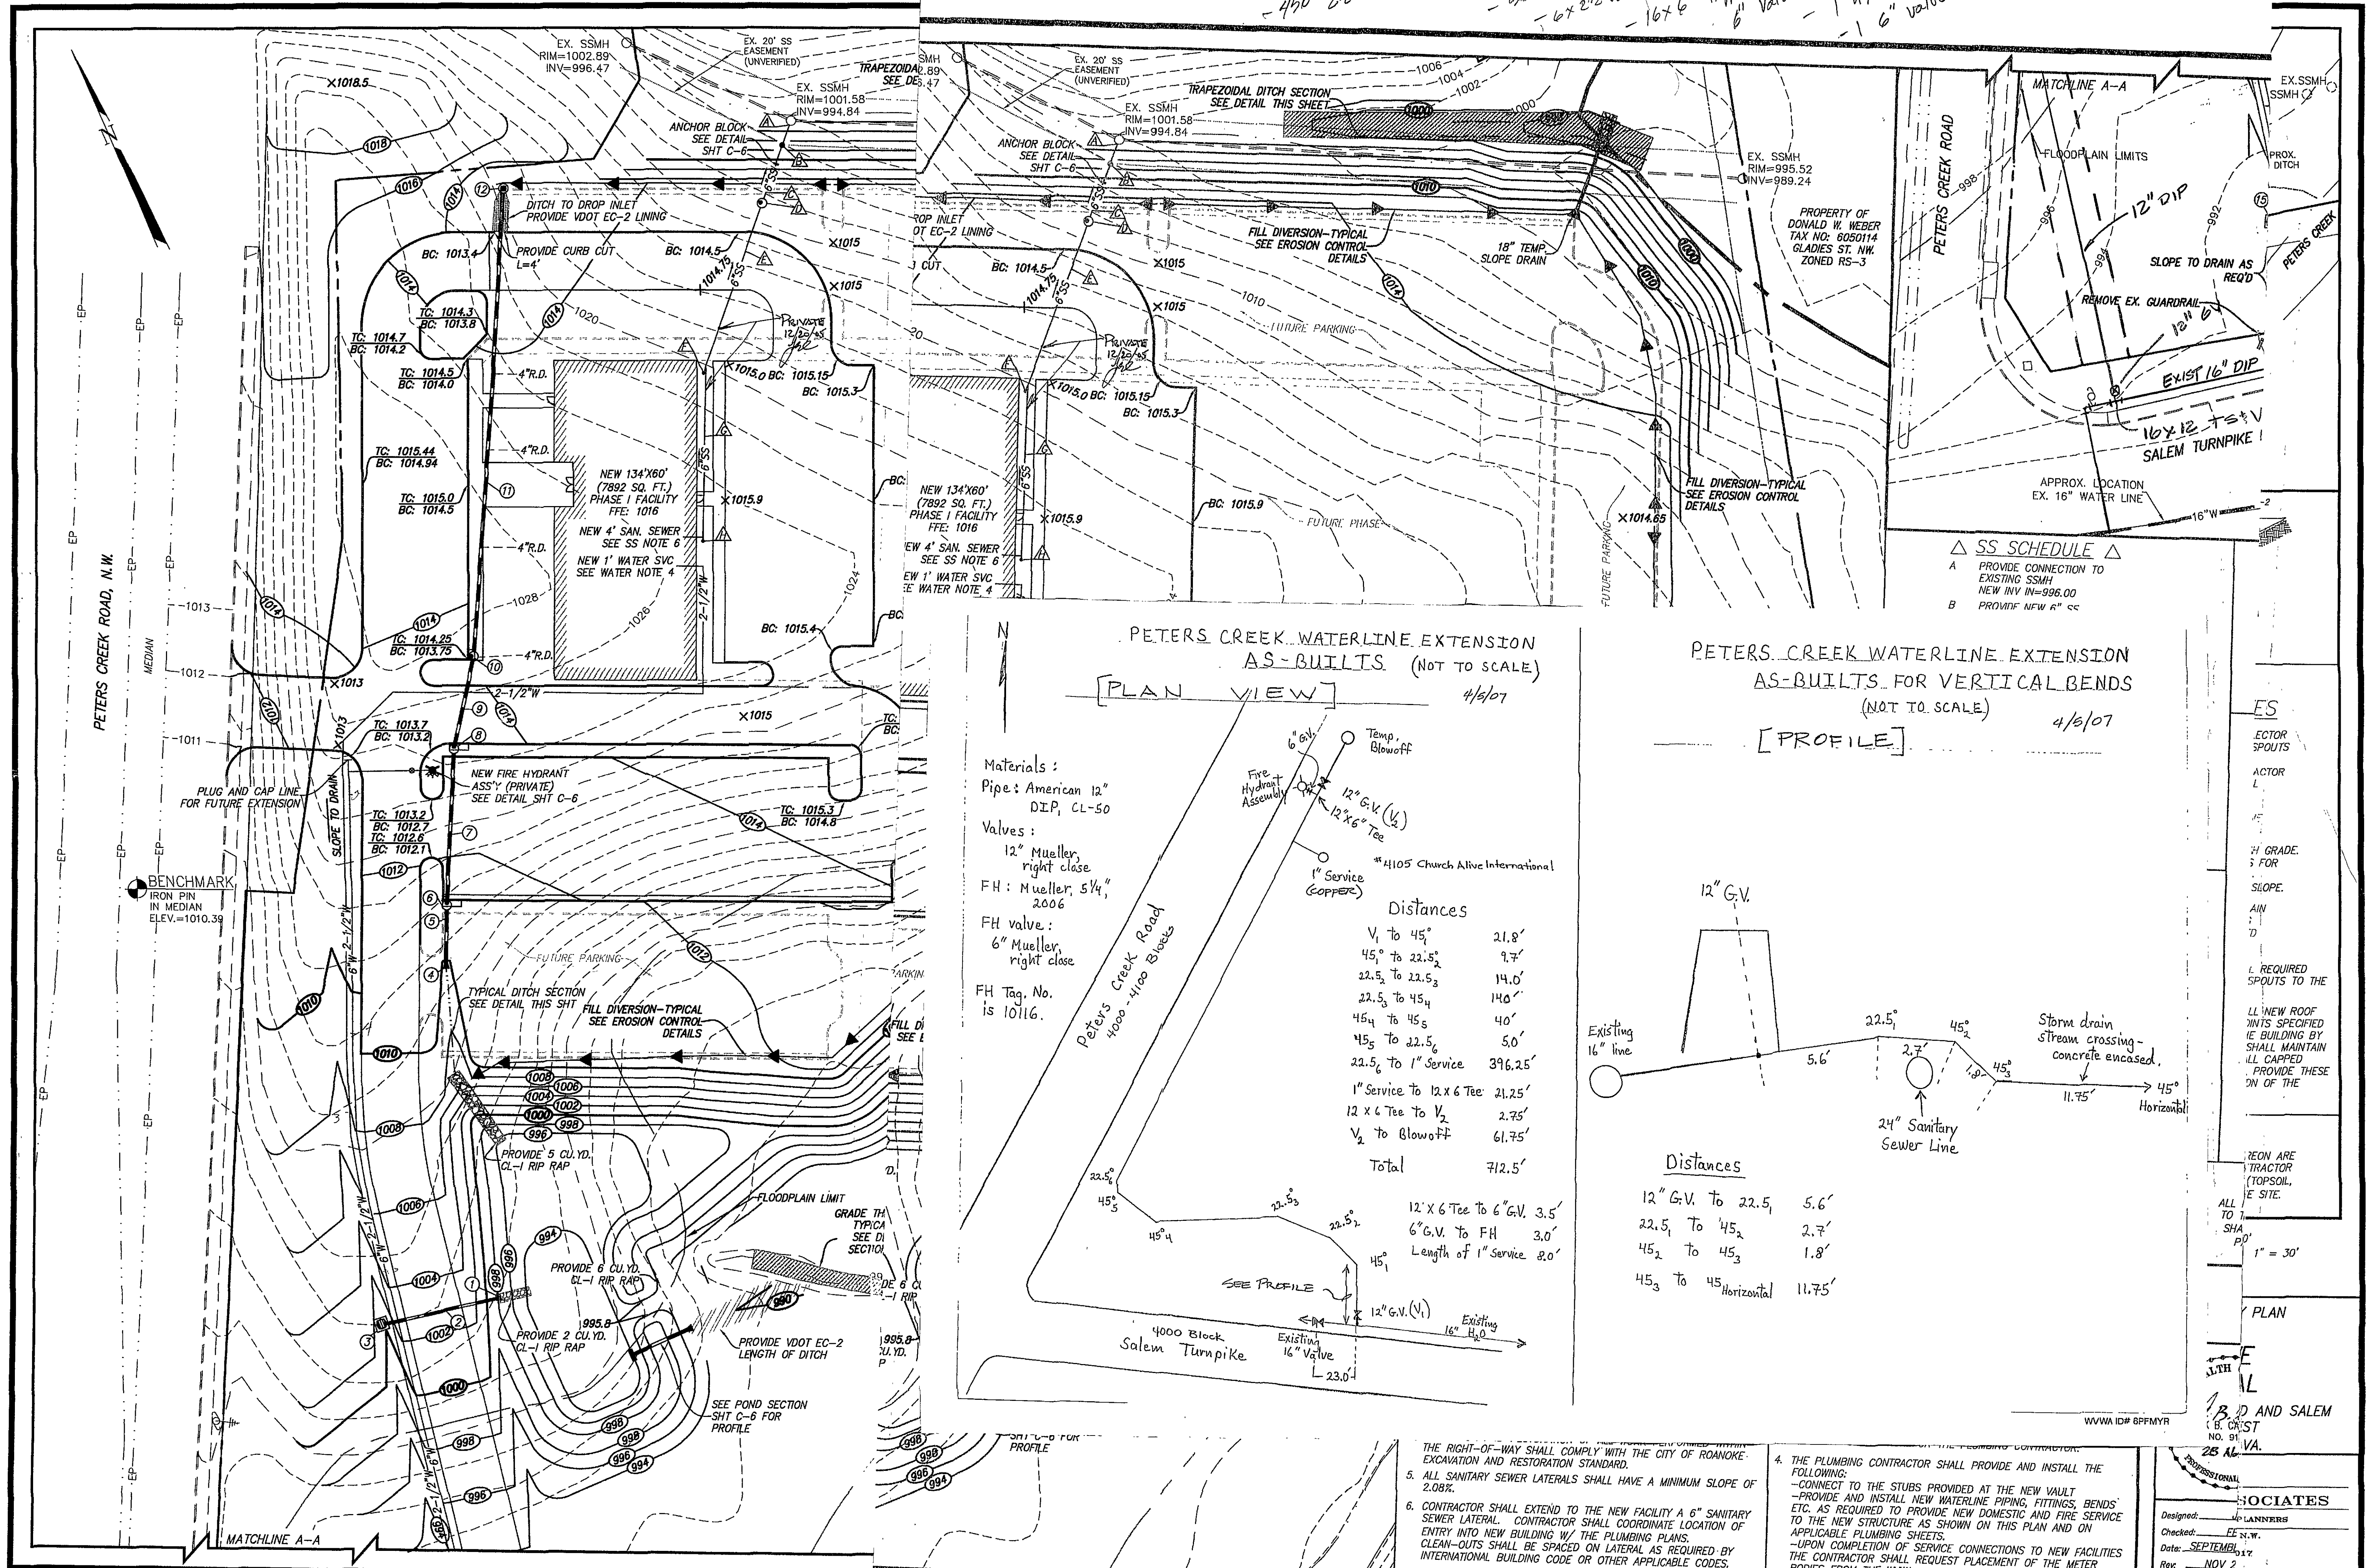

ES
ECTOR SPOUTS
ACTOR L
H GRADE
S FOR
SLOPE
AIN
D
L REQUIRED
SPOUTS TO THE
LL NEW ROOF
JINTS SPECIFIED
IE BUILDING BY
SHALL MAINTAIN
ILL CAPPED
PROVIDE THESE
ON OF THE
REON ARE
TRACTOR
(TOPSOIL,
E SITE.
ALL TO
SHA
PO
1" = 30'
PLAN
E
L
B D AND SALEM
B. CRIST
NO. 91
25 AL
VA.
PROFESSIONAL
SOCIATES
Designed: J. LANNERS
Checked: E. N.W.
Date: SEPTEMBER
Rev: NOV 2
Scale: 1" = 30'
Tax Parcel: 602ET C-4 OF 8
W.O. No.: 05-

THE RIGHT-OF-WAY SHALL COMPLY WITH THE CITY OF ROANOKE EXCAVATION AND RESTORATION STANDARD.
5. ALL SANITARY SEWER LATERALS SHALL HAVE A MINIMUM SLOPE OF 2.08%.
6. CONTRACTOR SHALL EXTEND TO THE NEW FACILITY A 6" SANITARY SEWER LATERAL. CONTRACTOR SHALL COORDINATE LOCATION OF ENTRY INTO NEW BUILDING W/ THE PLUMBING PLANS. CLEAN-OUTS SHALL BE SPACED ON LATERAL AS REQUIRED BY INTERNATIONAL BUILDING CODE OR OTHER APPLICABLE CODES.
7. THE PLUMBING CONTRACTOR SHALL PROVIDE AND INSTALL THE FOLLOWING:
-CONNECT TO THE STUBS PROVIDED AT THE NEW VAULT
-PROVIDE AND INSTALL NEW WATERLINE PIPING, FITTINGS, BENDS ETC. AS REQUIRED TO PROVIDE NEW DOMESTIC AND FIRE SERVICE TO THE NEW STRUCTURE AS SHOWN ON THIS PLAN AND ON APPLICABLE PLUMBING SHEETS.
-UPON COMPLETION OF SERVICE CONNECTIONS TO NEW FACILITIES THE CONTRACTOR SHALL REQUEST PLACEMENT OF THE METER BODIES FROM THE WWA.