
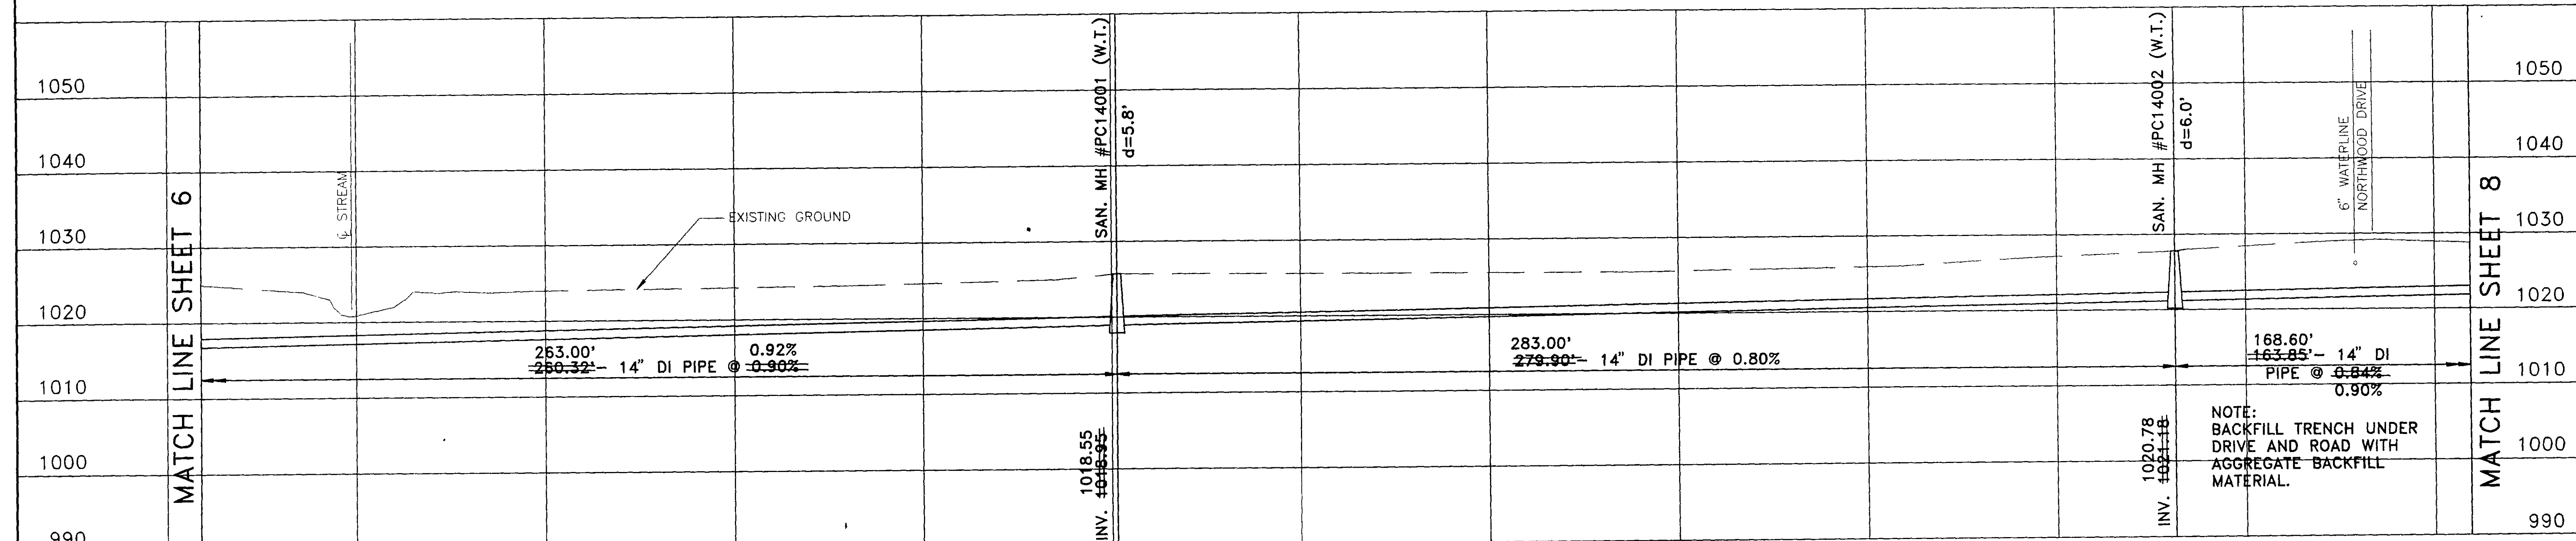


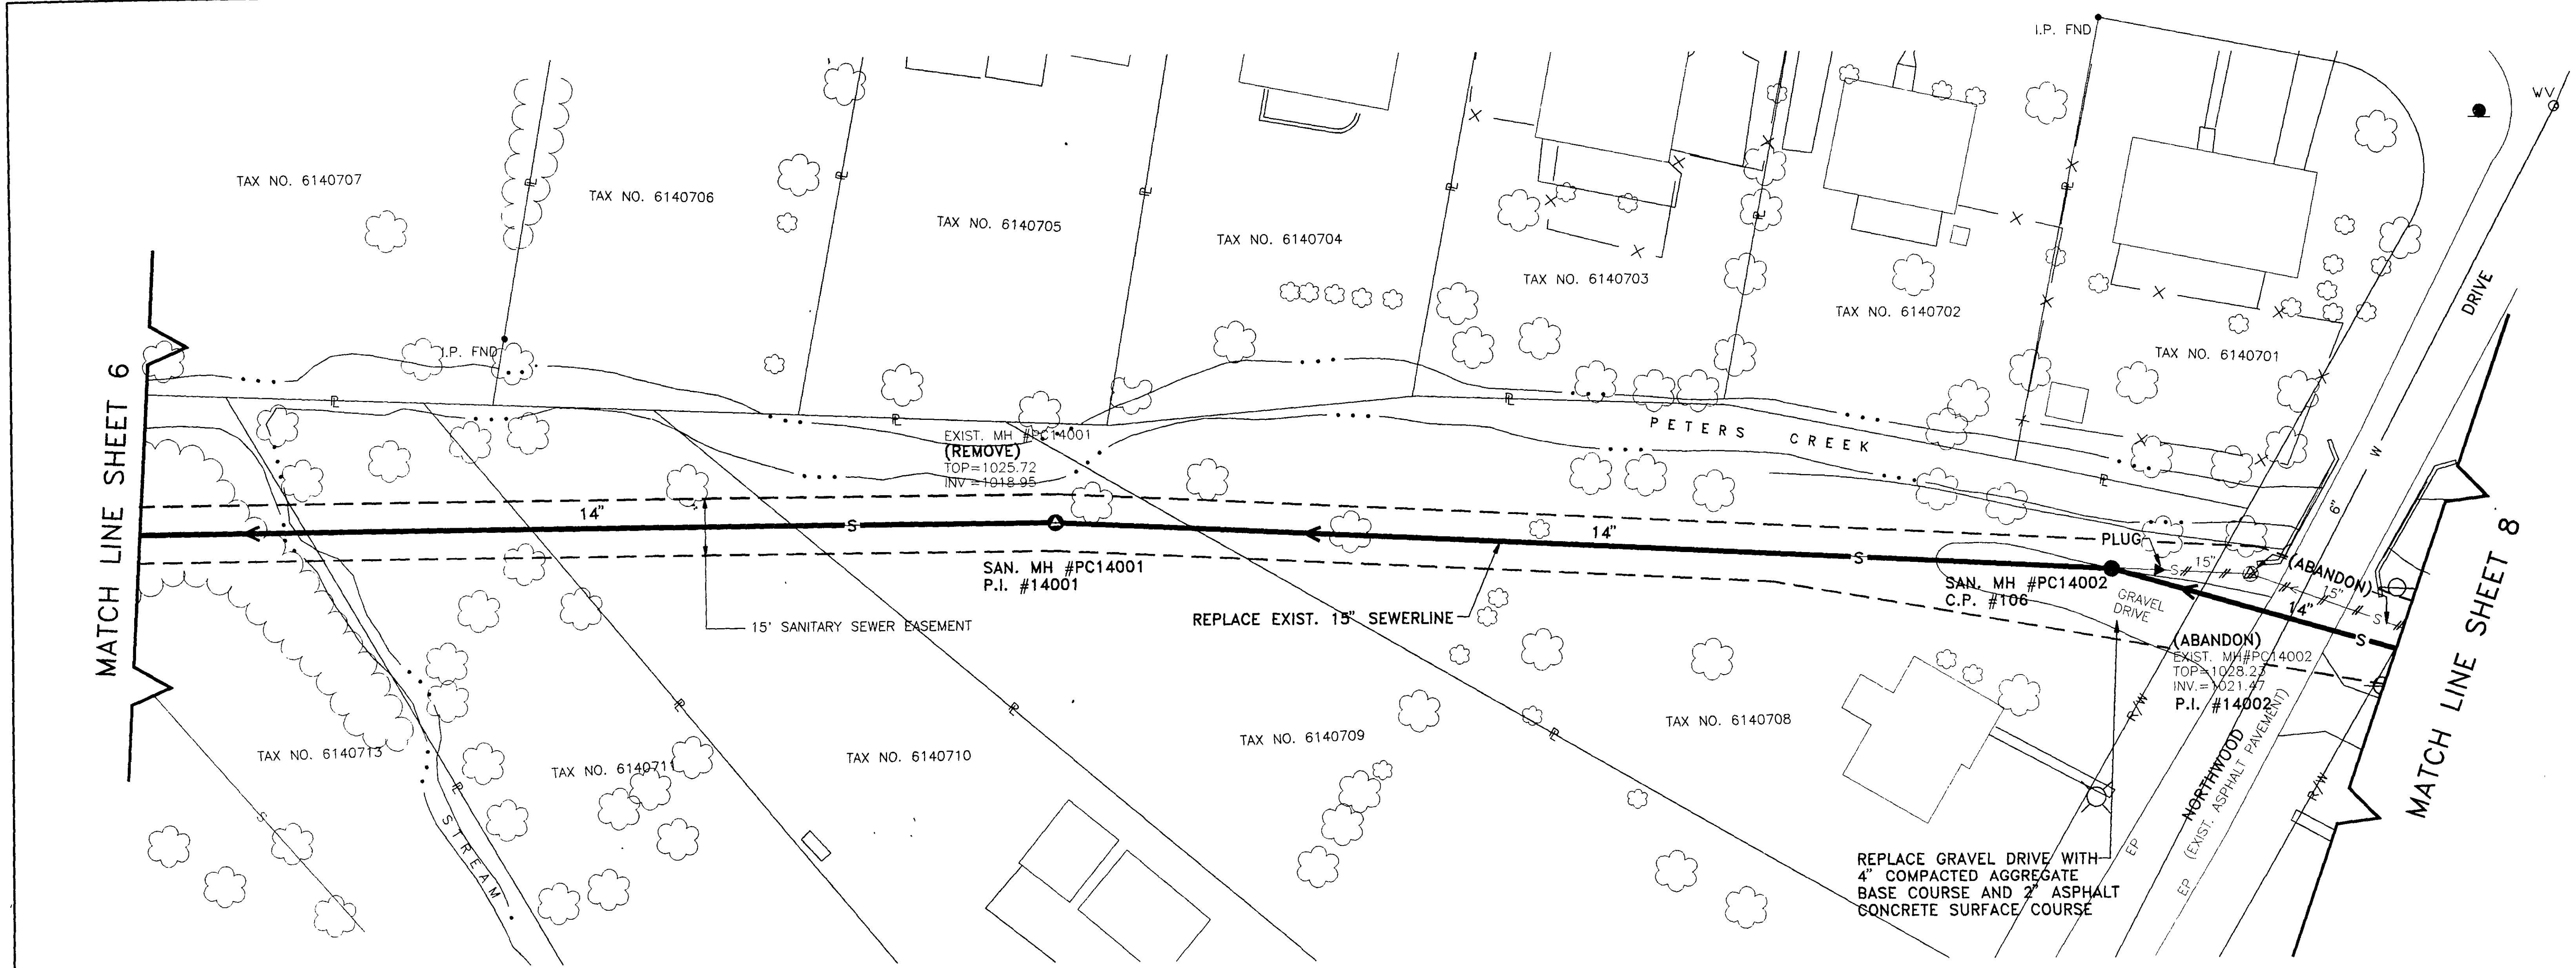

RECORD DRAWINGS
1-11-94

Mattern & Craig CONSULTING ENGINEERS - SURVEYORS	DESIGNED: TAM			REV.	DATE	DESCRIPTION	BY	APP.	DATE	SEWER REPLACEMENT PROJECT PC-1 PETERS CREEK SEWERSHED PLAN AND PROFILE CITY OF ROANOKE, VIRGINIA SCALE: 1"=20' HORIZ. 1"=10' VERT.	SHEET 7
	DRAWN: TAM			1	1/11/94	RECORD DRAWINGS	TAM	SWH	MAY 1993		
	CHECKED: SWH								COMM. NO. 1245		