
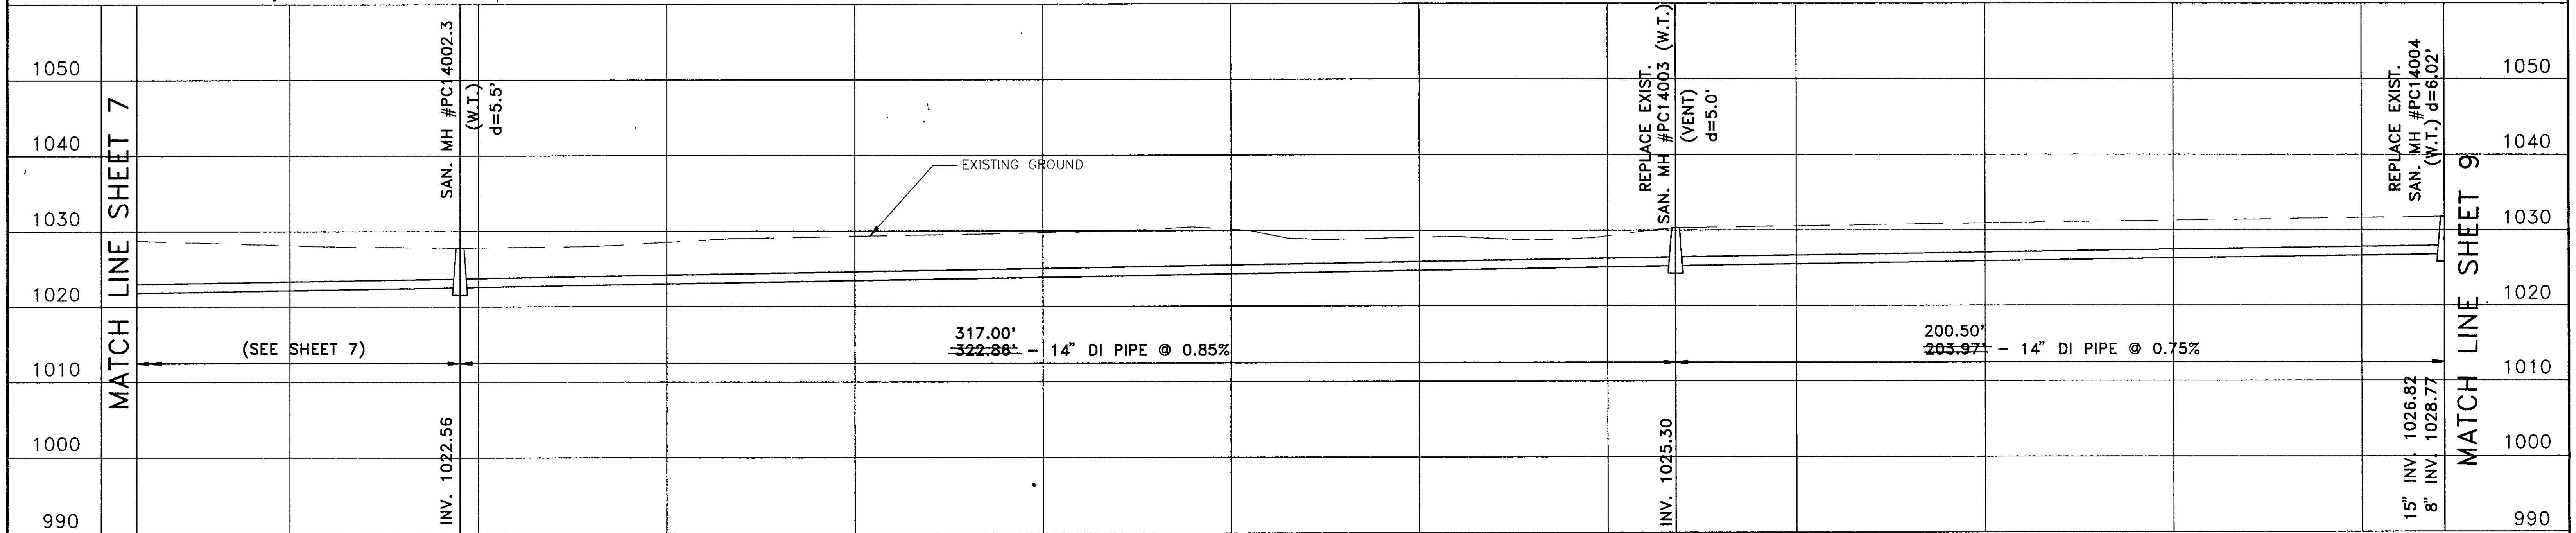


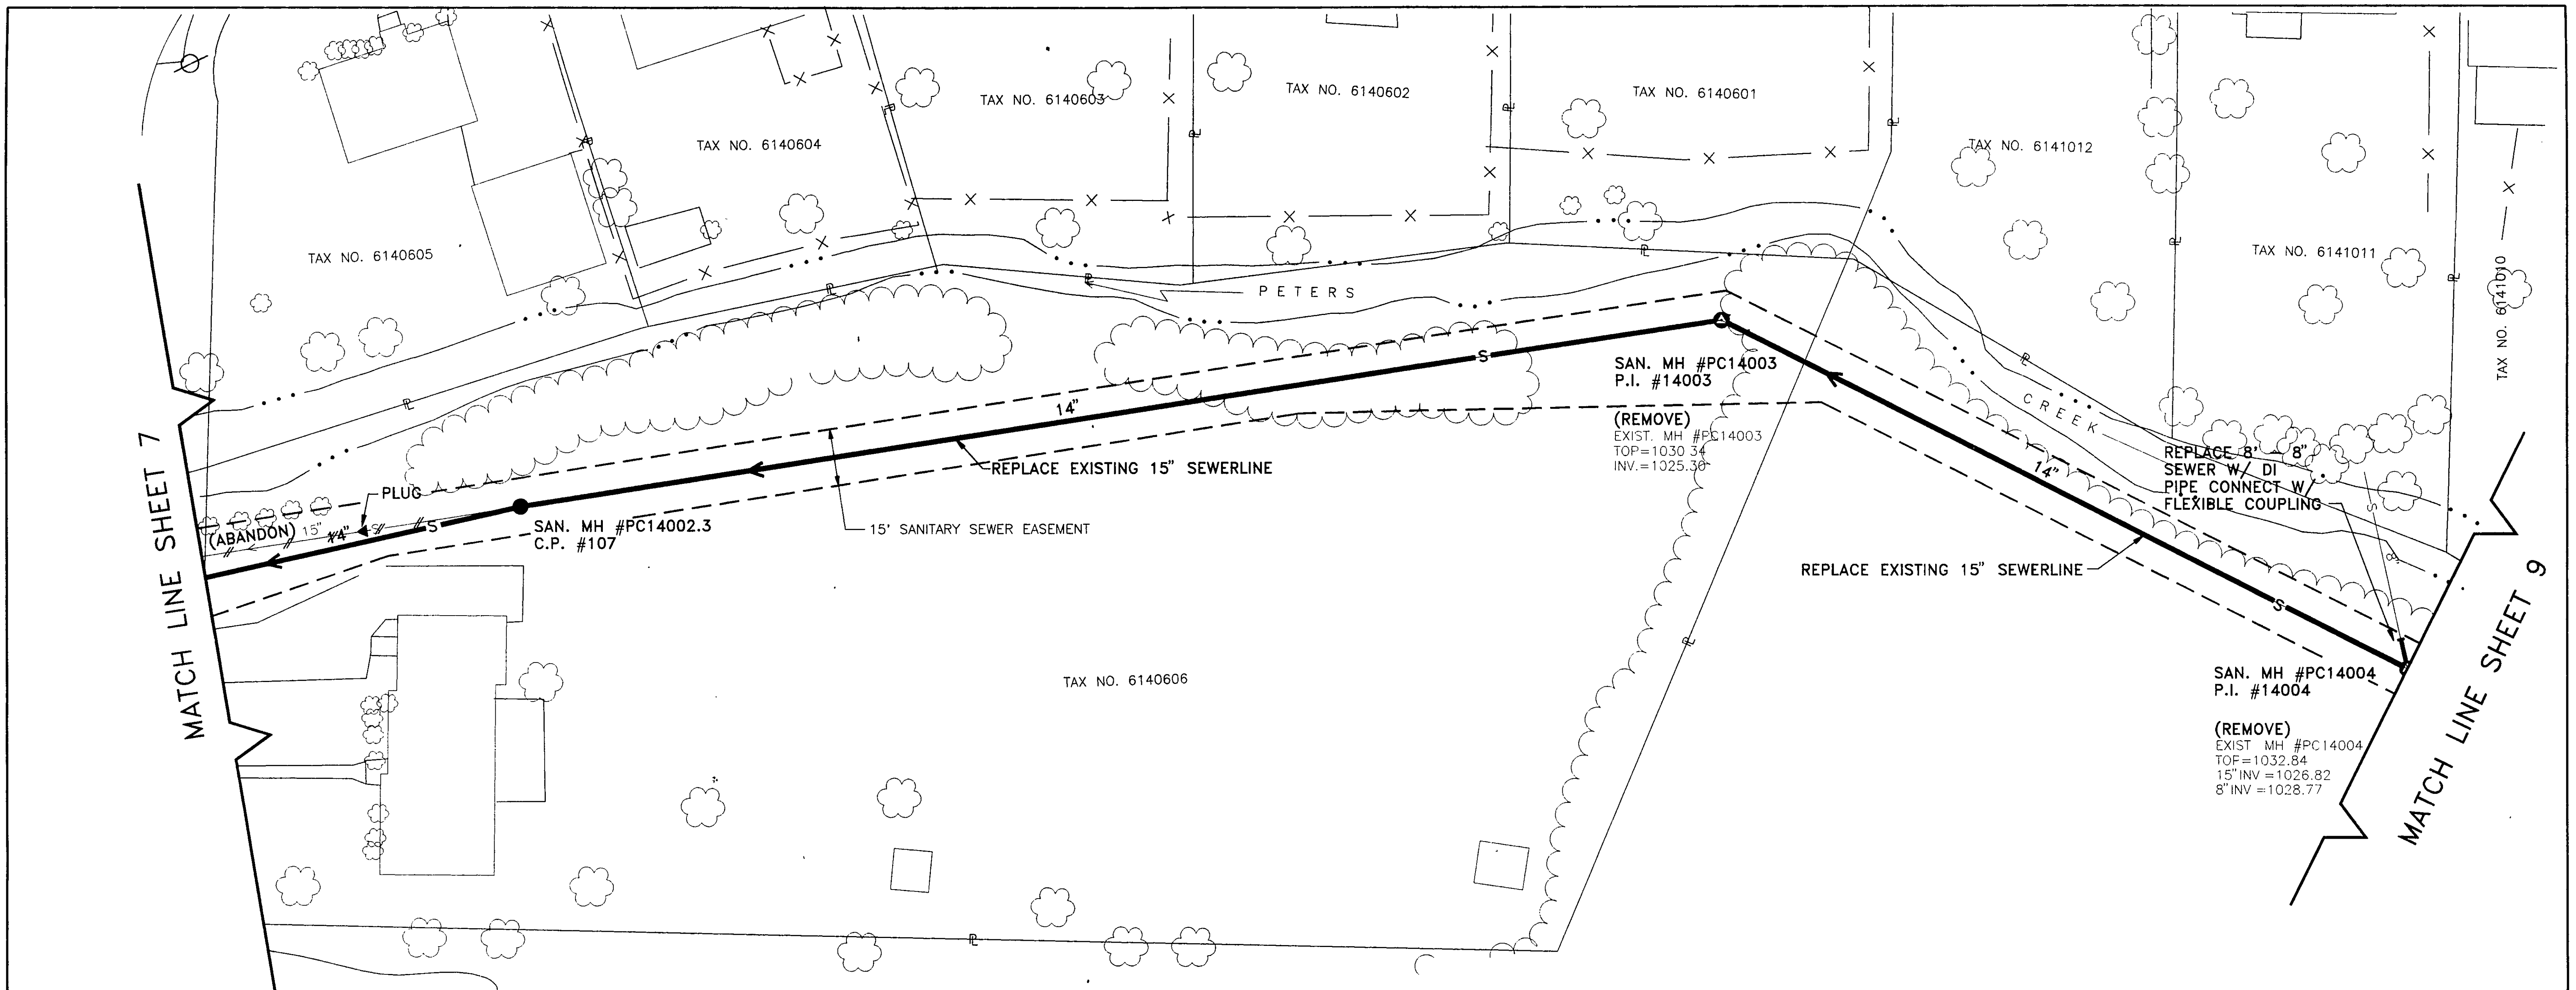

RECORD DRAWINGS										
1-11-94										
Mattern & Craig CONSULTING ENGINEERS - SURVEYORS	DESIGNED:	TAM			REV.	DATE	DESCRIPTION	BY	APP.	
	DRAWN:	TAM			1	1/11/94	RECORD DRAWINGS	TAM	SWH	
	CHECKED:	SWH								
					DATE	MAY 1993				
					COMM. NO.	1245				
					SEWER REPLACEMENT PROJECT PC-1 PETERS CREEK SEWERSHED PLAN AND PROFILE CITY OF ROANOKE, VIRGINIA					SHEET 8
					SCALE: 1"=20' HORIZ. 1"=10' VERT.					