
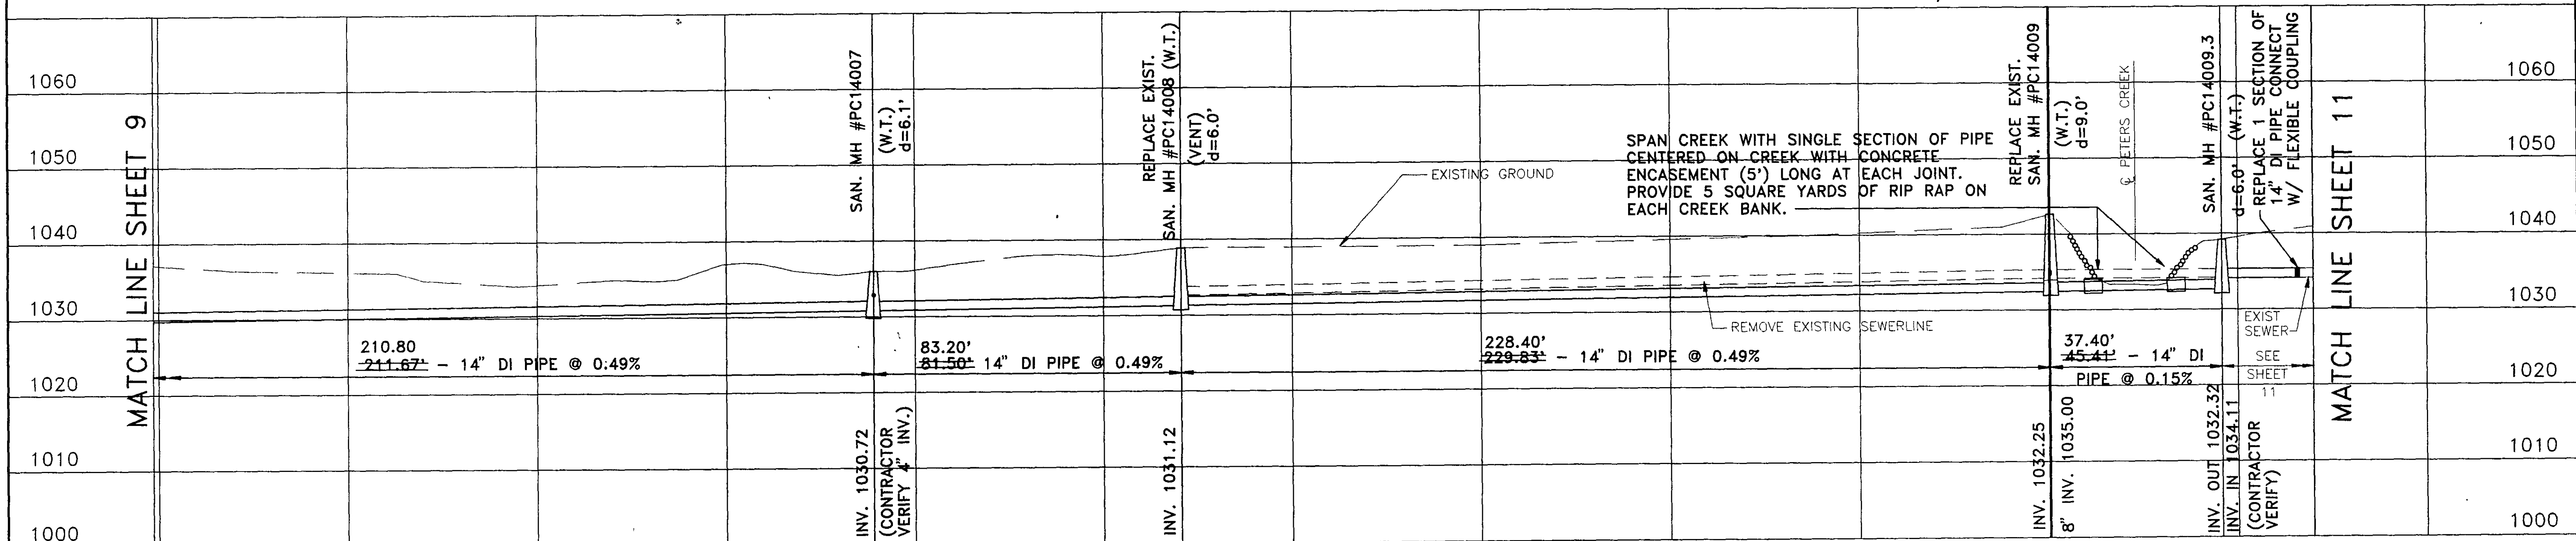


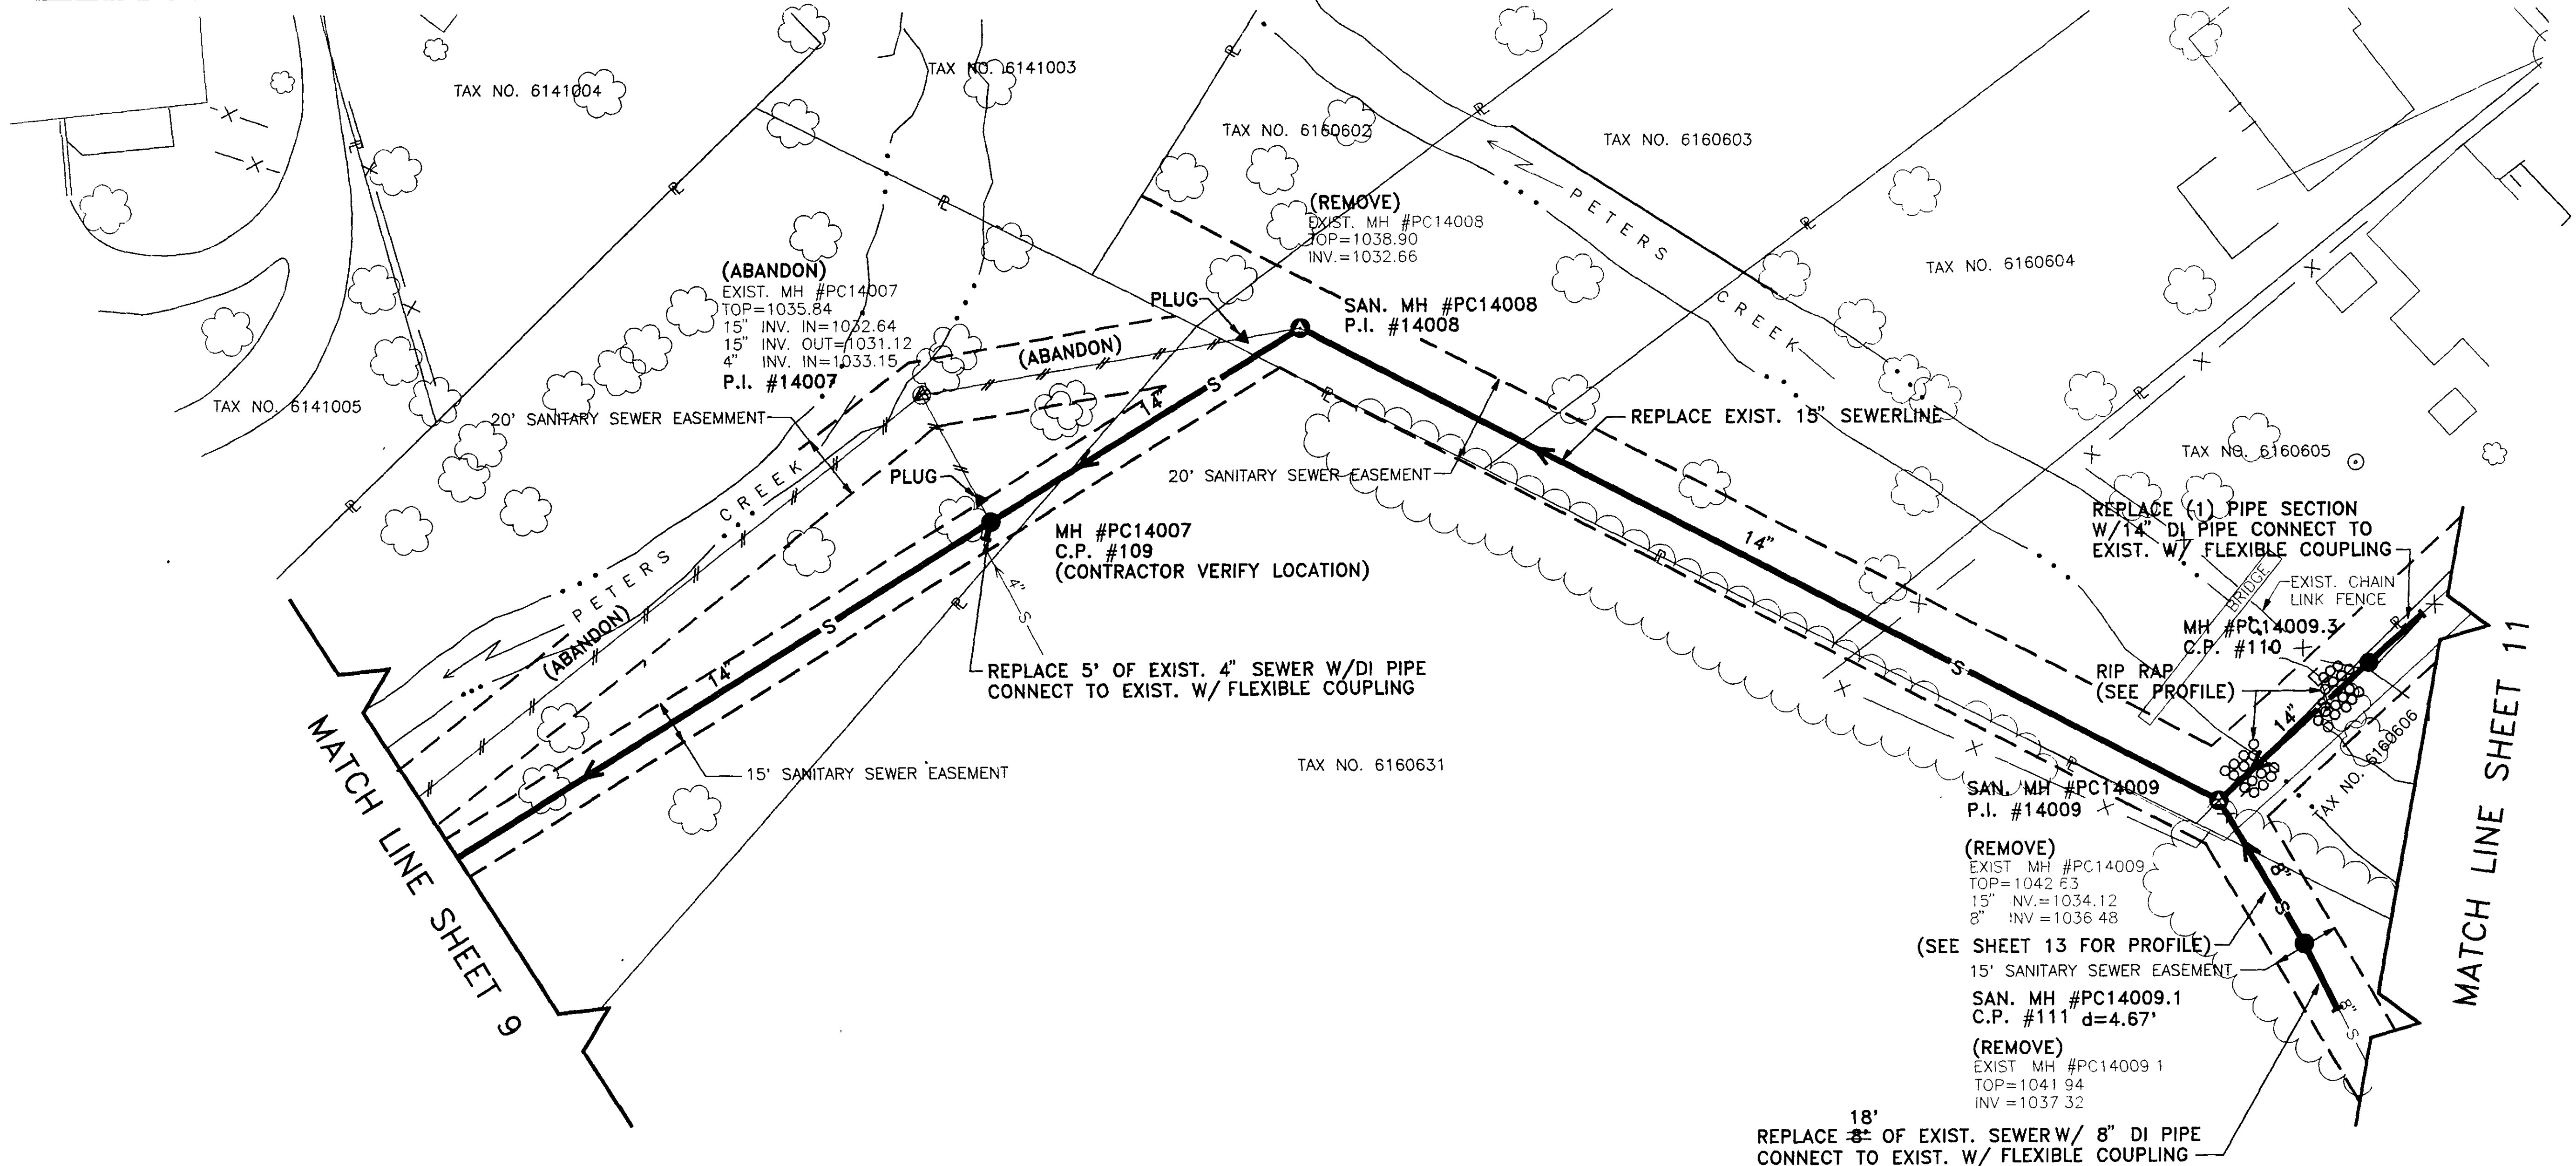

Mattern & Craig
CONSULTING ENGINEERS - SURVEYORS

DESIGNED: TAM

DRAWN: TAM

CHECKED: SWH

REV.	DATE	DESCRIPTION	BY	APP.
1	1/11/94	RECORD DRAWINGS	TAM	SWH

DATE
MAY 1993

COMM. NO.
1245

RECORD DRAWINGS 1-11-94

SEWER REPLACEMENT PROJECT PC-1
PETERS CREEK SEWERSHED
PLAN AND PROFILE
CITY OF ROANOKE, VIRGINIA

SCALE: 1"=20' HORIZ.
1"=10' VERT.

SHEET
10

PROJECT NO. 6245