


PROJECT LOCATION MAP

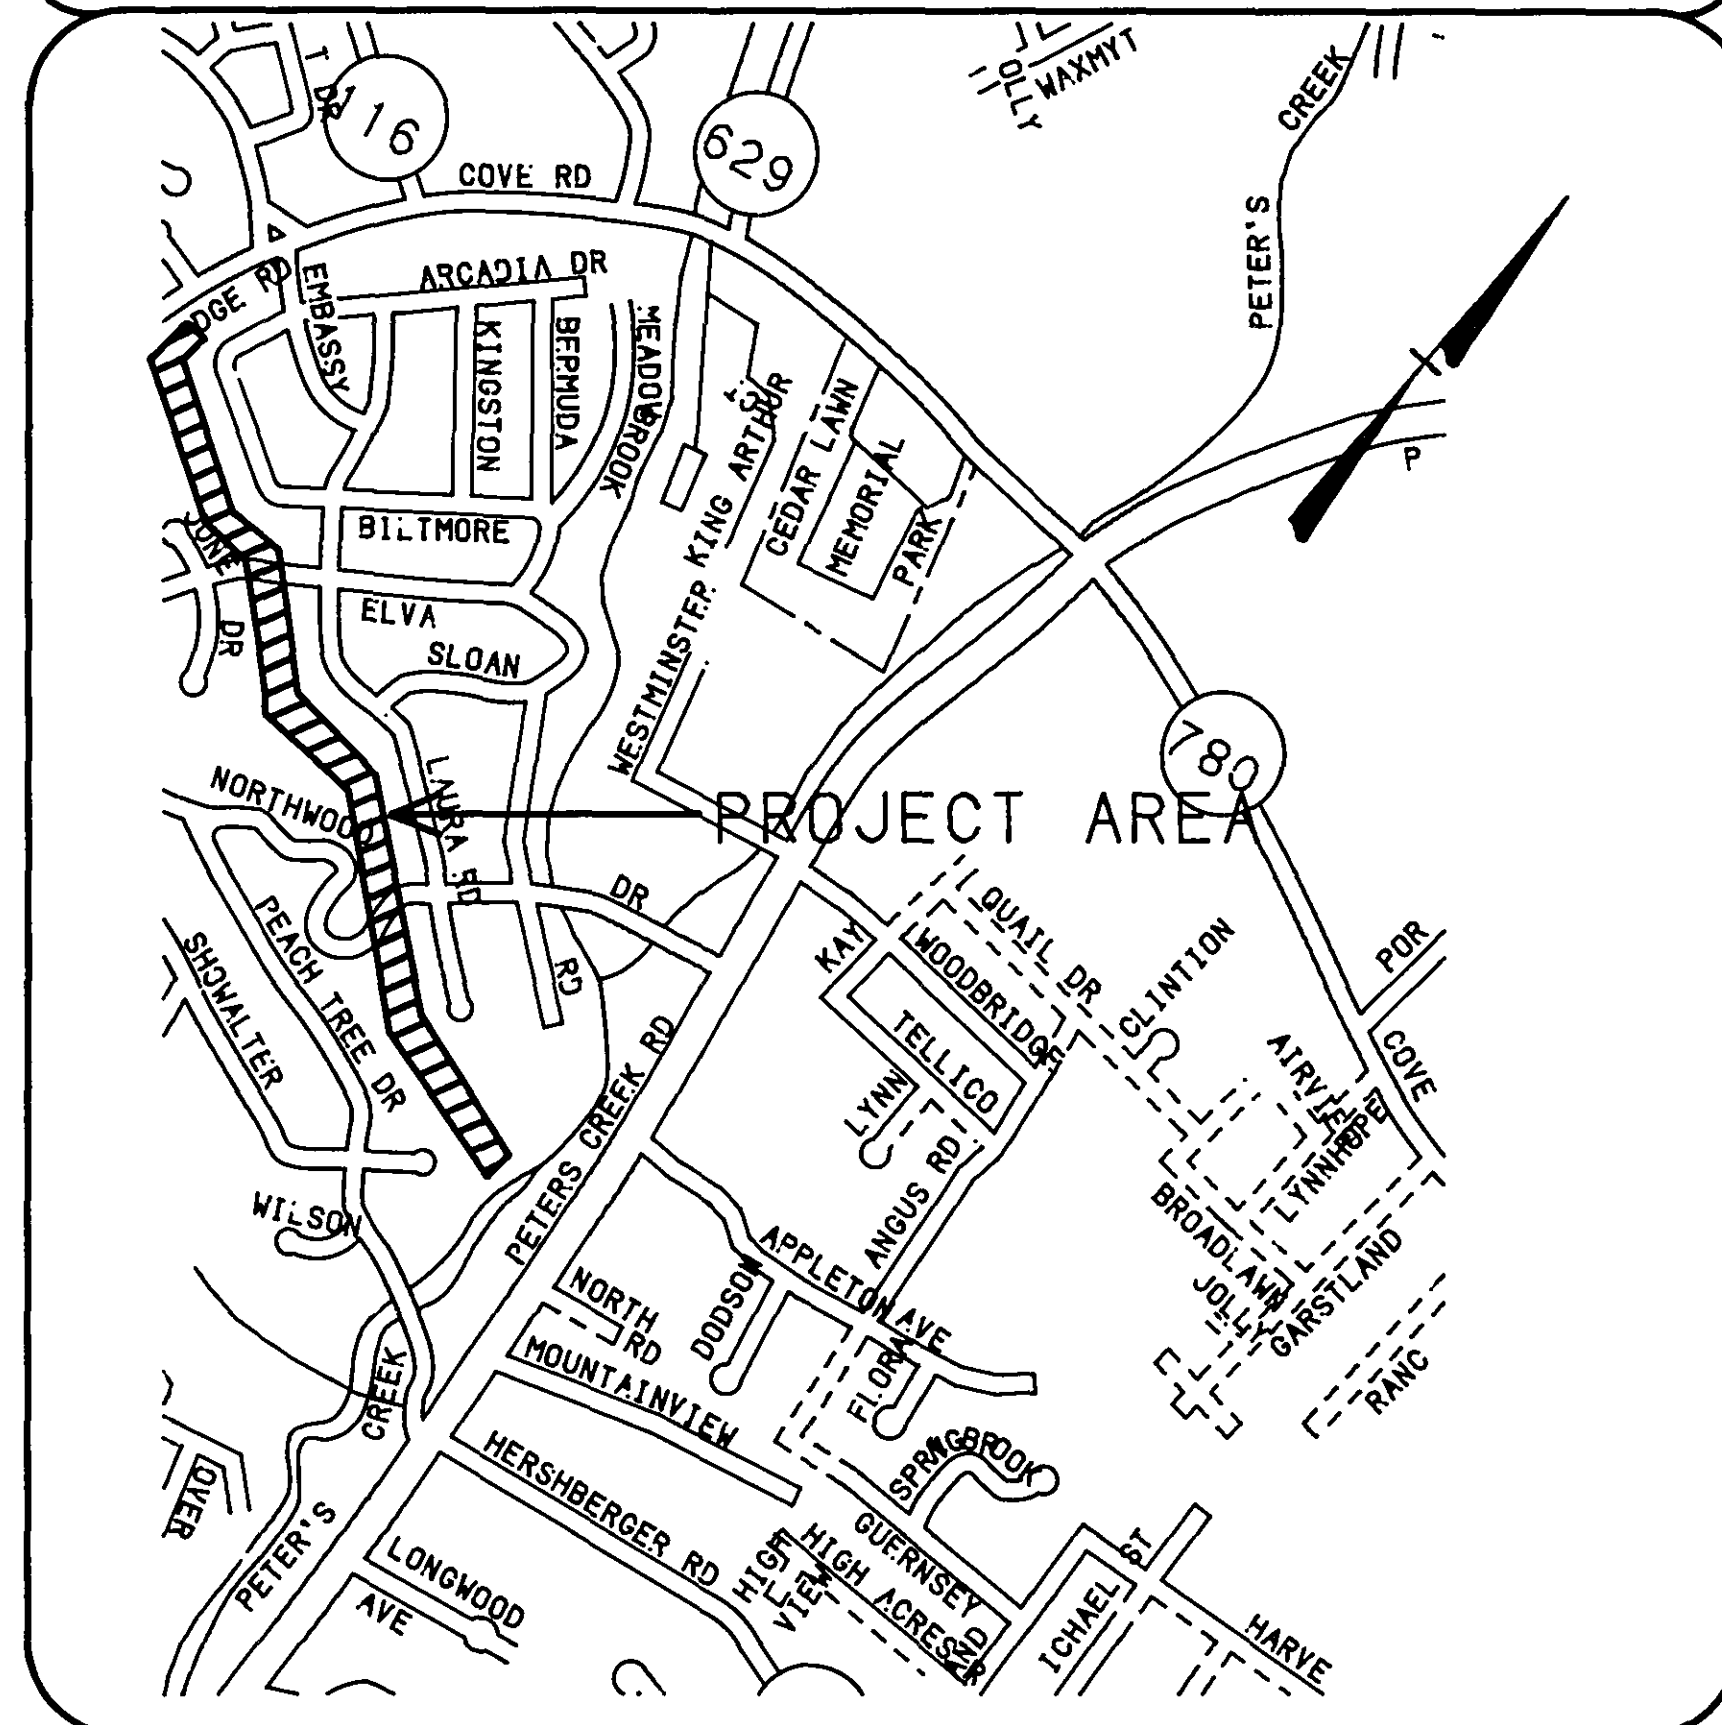

OFFICE OF CITY ENGINEER
ROOM 350
MUNICIPAL BUILDING
215 CHURCH AVENUE, S.W.
ROANOKE, VIRGINIA 24011

INDEX OF SHEETS

- 1 TITLE
- 2 SUMMARY OF QUANTITIES
- 3 GENERAL ABBREVIATIONS & LEGEND
- 4 SHEET INDEX & GENERAL NOTES
- 5 PLAN AND PROFILE
- 6 PLAN AND PROFILE
- 7 PLAN AND PROFILE
- 8 PLAN AND PROFILE
- 9 PLAN AND PROFILE
- 10 PLAN AND PROFILE
- 11 PLAN AND PROFILE
- 12 PROPERTY CORNER LOCATIONS


CONSULTING ENGINEERS



CONSULTING ENGINEERS
SURVEYORS

701 FIRST STREET
ROANOKE, VIRGINIA

COMMISSION NUMBER: 1245A

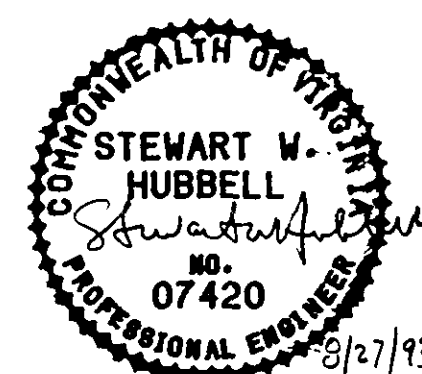

PROJECT NAME

SEWER REPLACEMENT PROJECT PC-2
PETERS CREEK SEWERSHED
CITY OF ROANOKE, VIRGINIA

PROJECT NUMBER: 6245 A

REVISION BY	DESCRIPTION	DATE
REVISION BY	DESCRIPTION	DATE
REVISION BY	DESCRIPTION	DATE
REVISION BY	DESCRIPTION	DATE

APPROVED FOR CONSTRUCTION

Robert C. ...
ROANOKE CITY ENGINEER Acting

6-14-93
DATE

William F. Clark
DIRECTOR OF PUBLIC WORKS

6-14-93
DATE

Art B. ...
DIRECTOR OF PUBLIC UTILITIES AND OPERATIONS

6/14/93
DATE

DATE

DATE

ADVERTISED DATE: _____

SET NUMBER: _____

SHEET NUMBER: 1 OF 12

RECORD DRAWINGS
JUNE 1, 1994