
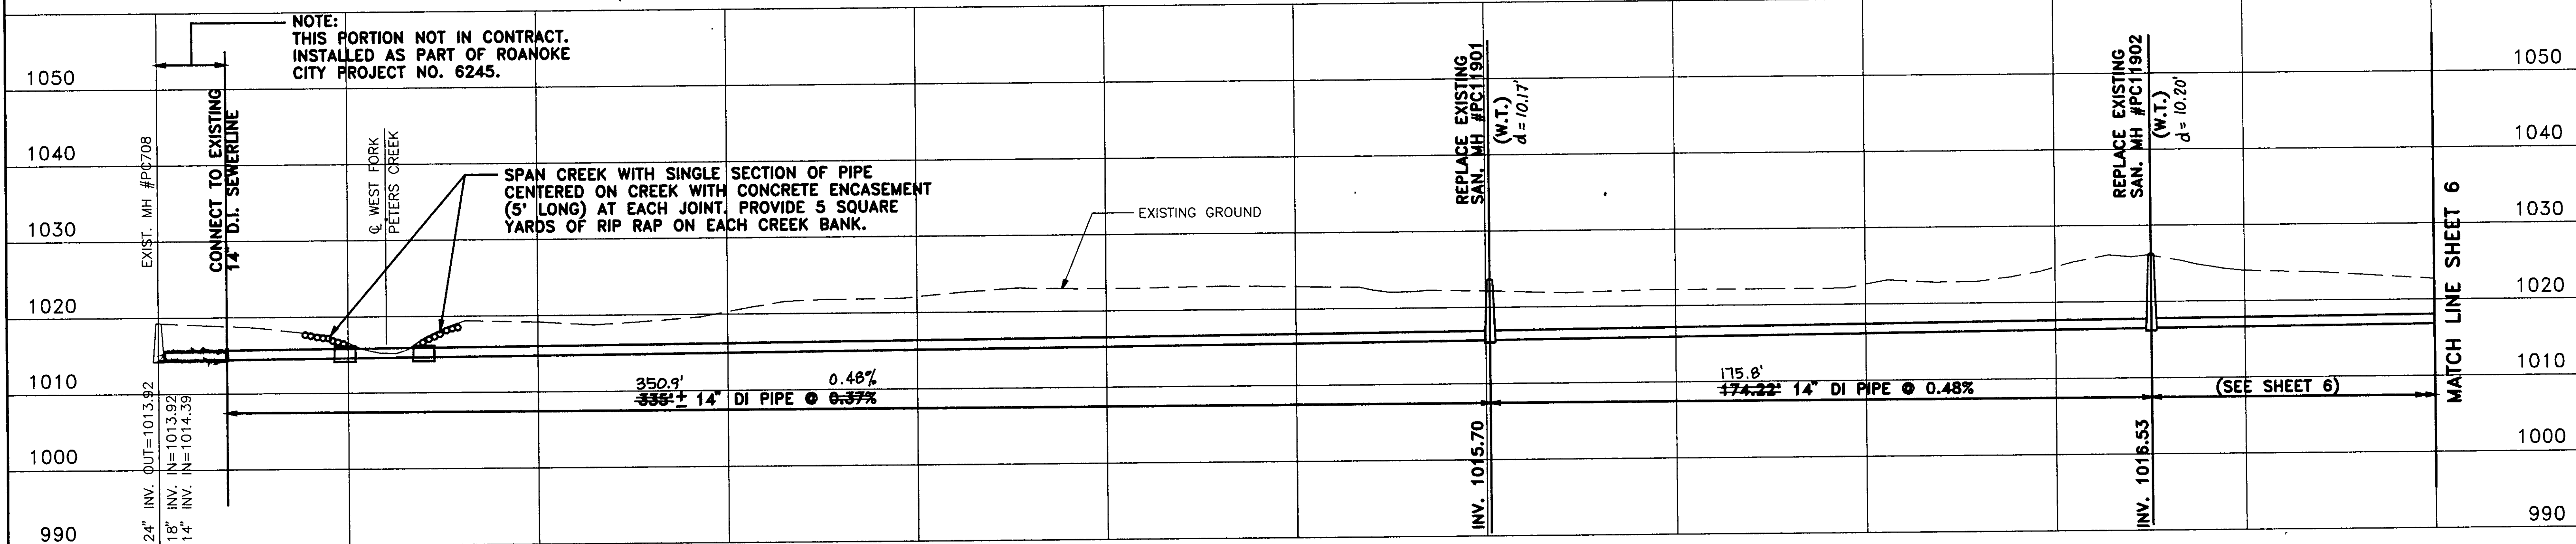


TAX NO. 6120511

TAX NO. 6120411



DICK A. COOK
D.B. 1525, PG. 930
TAX NO. 6120443

DICK A. COOK
D.B. 1616, PG. 1308
TAX NO. 6120417

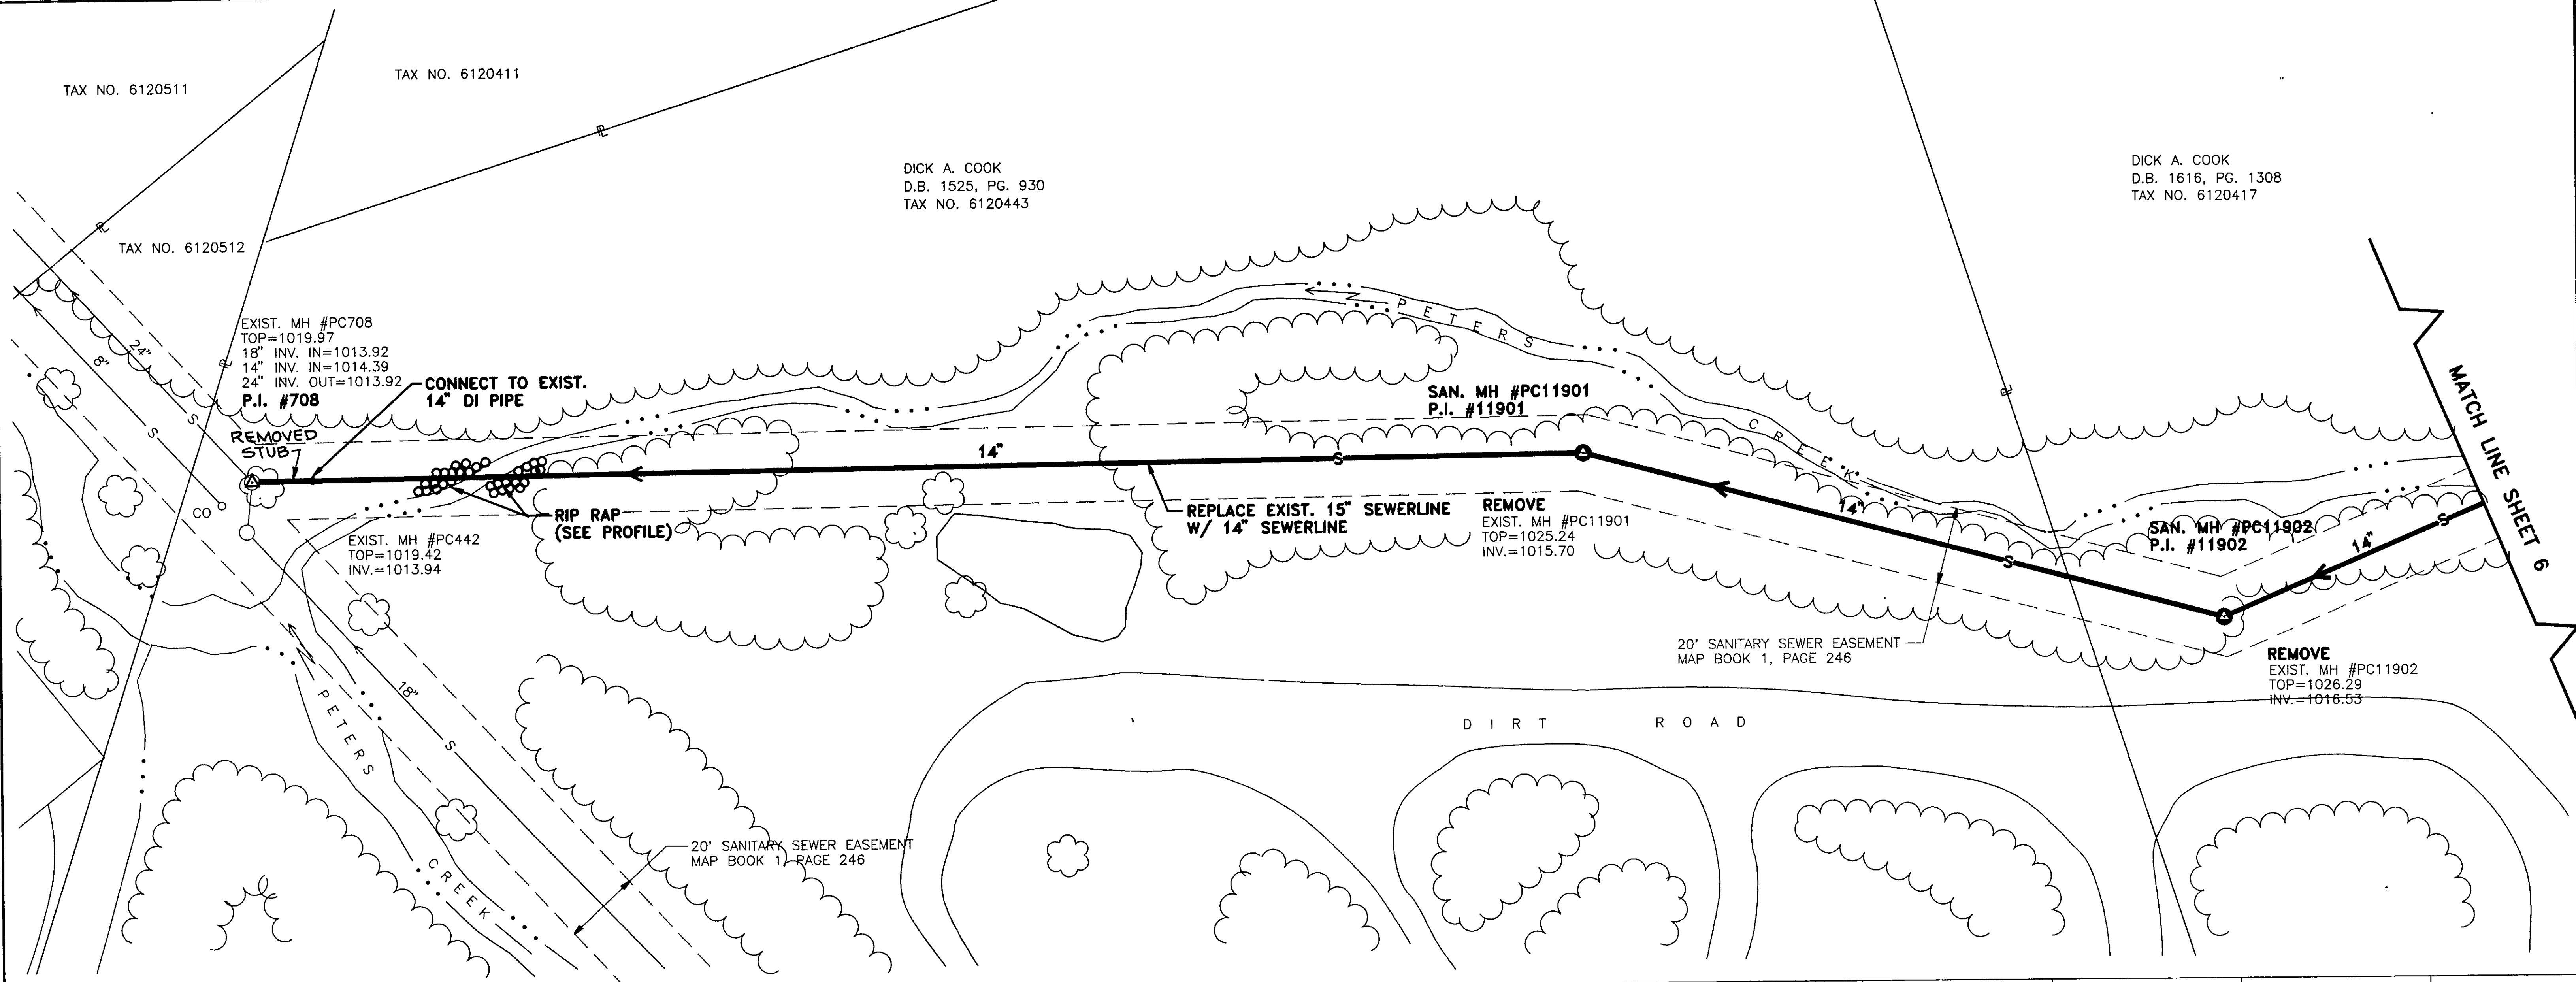

Mattern & Craig
CONSULTING ENGINEERS - SURVEYORS

DESIGNED:
TAM
DRAWN:
TAM
CHECKED:
SWH

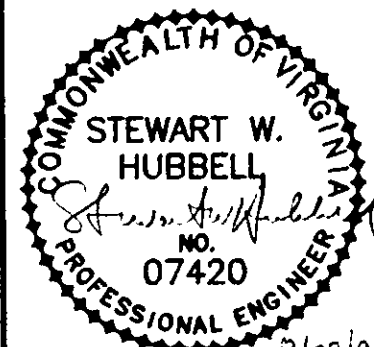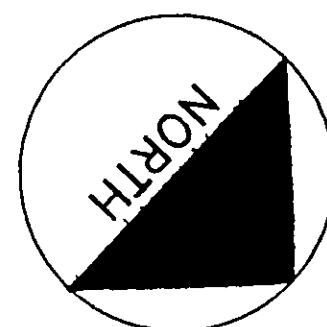

REV.	DATE	DESCRIPTION	BY	APP.
1	6-1-94	RECORD DRAWINGS	TAM	SWH

DATE
JUNE
1993
COMM. NO.
1245A

PETERS CREEK SANITARY SEWER REPLACEMENT
PROJECT PC-2
PLAN AND PROFILE
CITY OF ROANOKE, VIRGINIA

SCALE: 1"=20' HORIZ.
1"=10' VERT.

SHEET

5

PROJECT NO. 6245A