
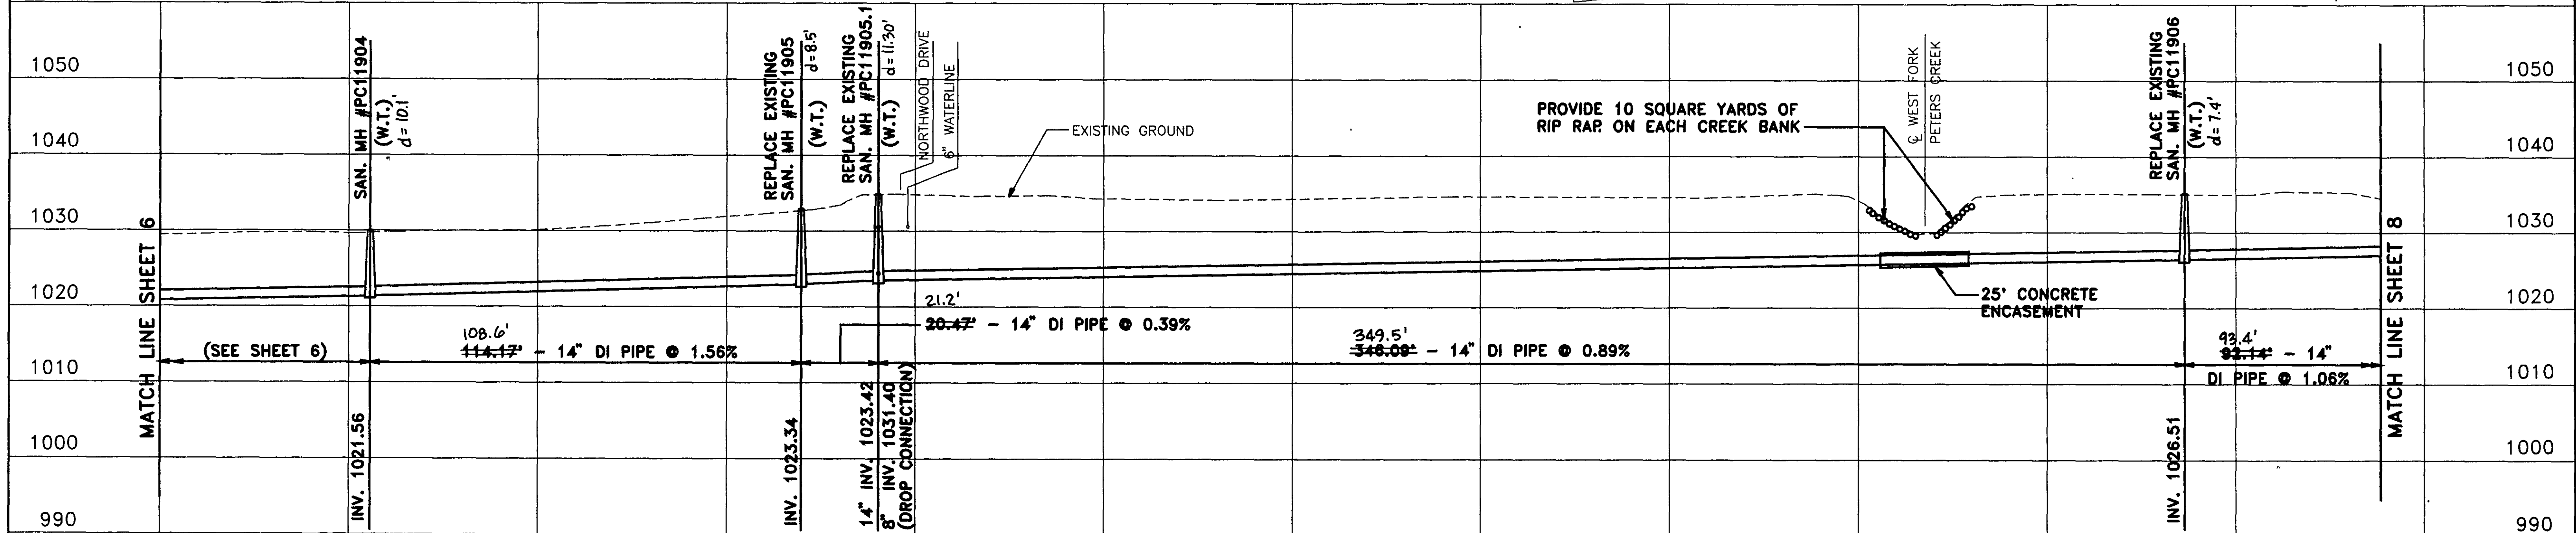


NOTE:
PROVIDE TREE PROTECTION
FOR TREES WITH THIS SYMBOL •

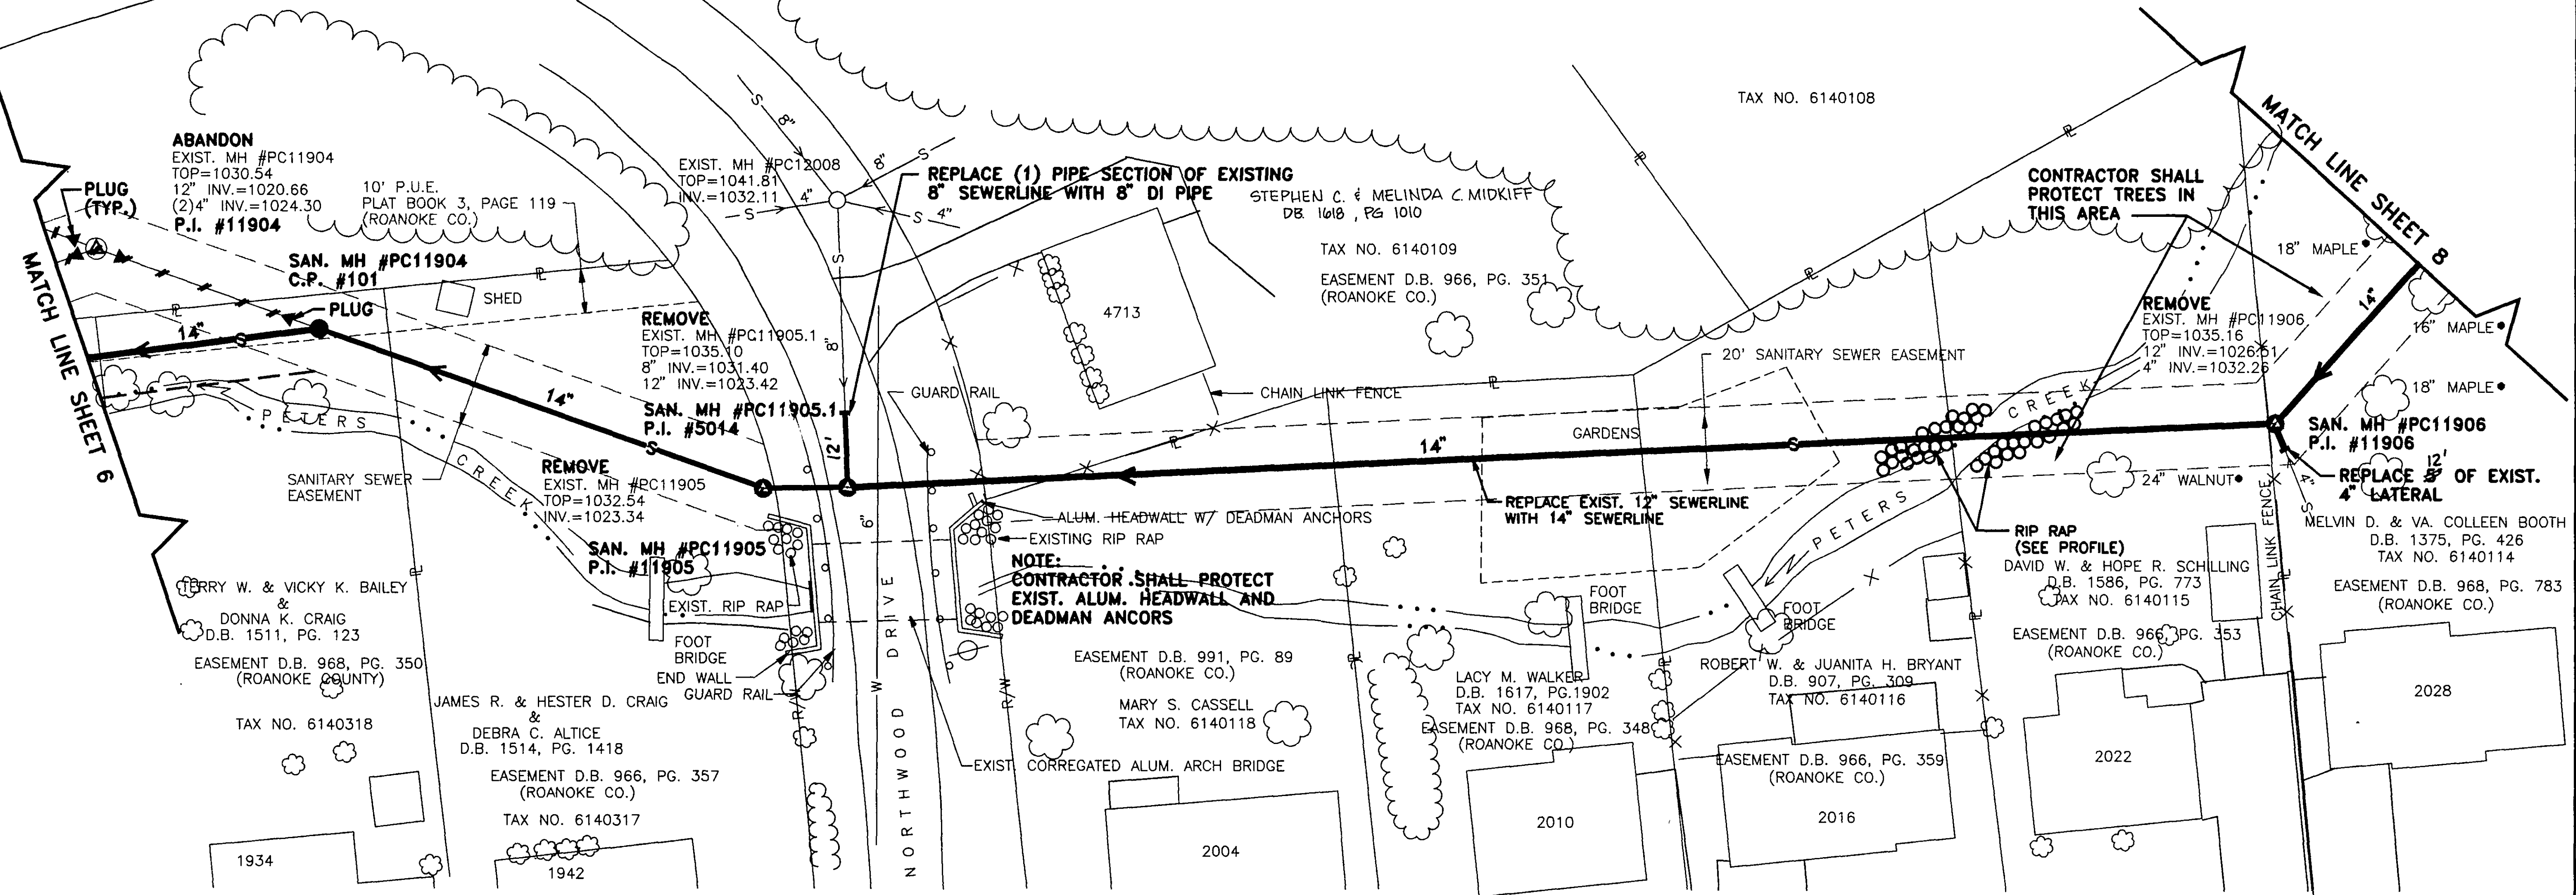

RECORD DRAWINGS JUNE 1, 1994

Mattern & Craig CONSULTING ENGINEERS - SURVEYORS	DESIGNED: TAM		REV.	DATE	DESCRIPTION	BY	APP.	DATE	PETERS CREEK SANITARY SEWER REPLACEMENT PROJECT PC-2 PLAN AND PROFILE CITY OF ROANOKE, VIRGINIA SCALE: 1"=20' HORIZ. 1"=10' VERT.	SHEET 7
	DRAWN: TAM		6-1-94	RECORD DRAWINGS	TAM	SWH	JUNE 1993			
	CHECKED: SWH									