




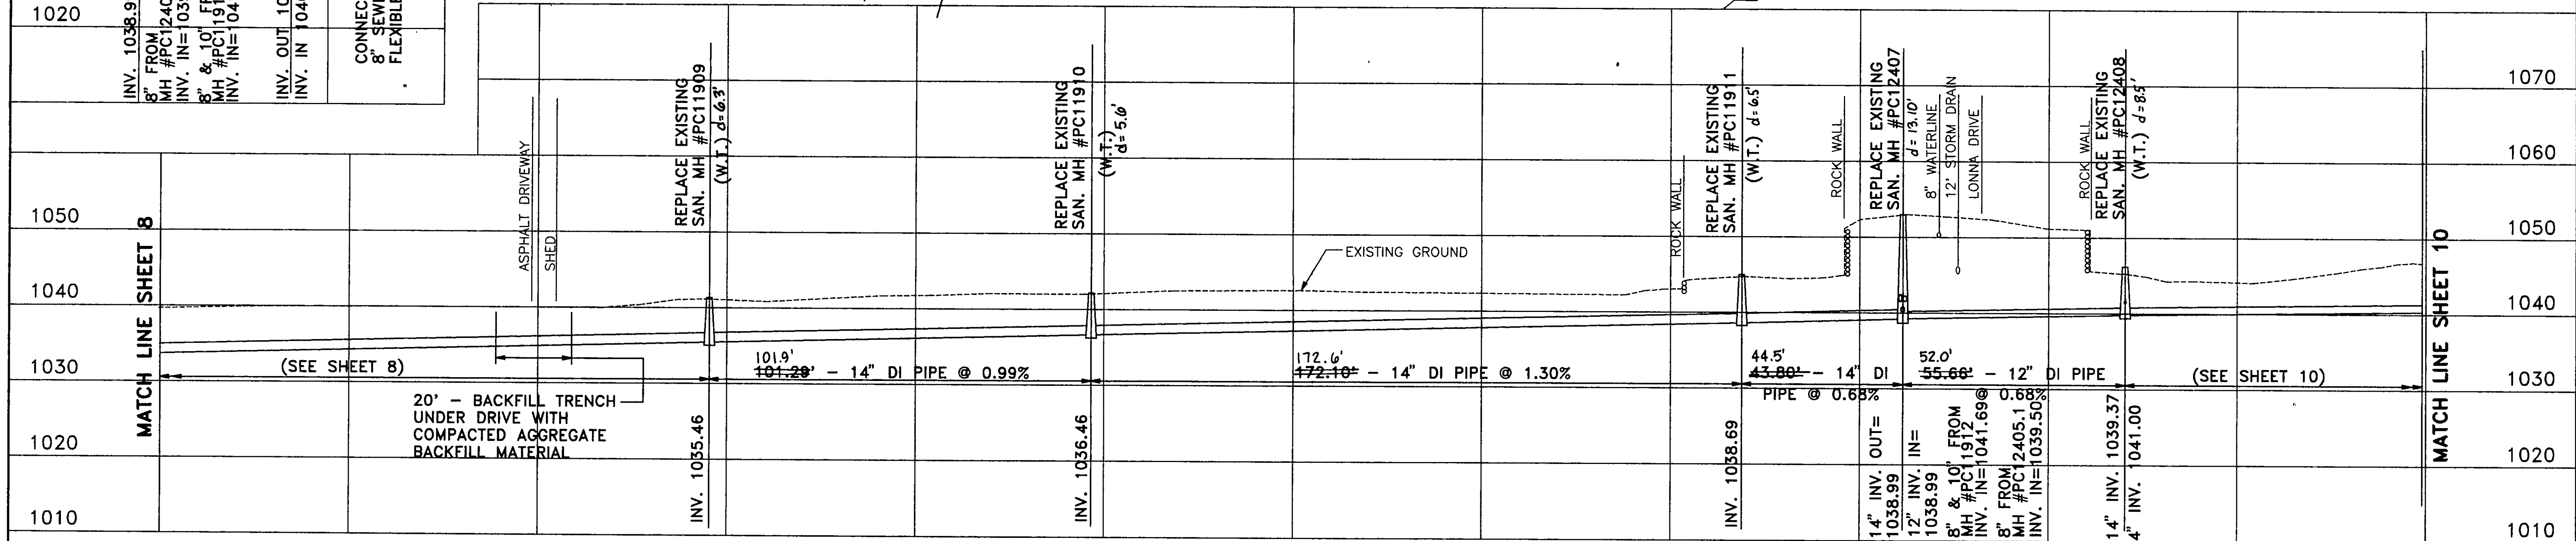


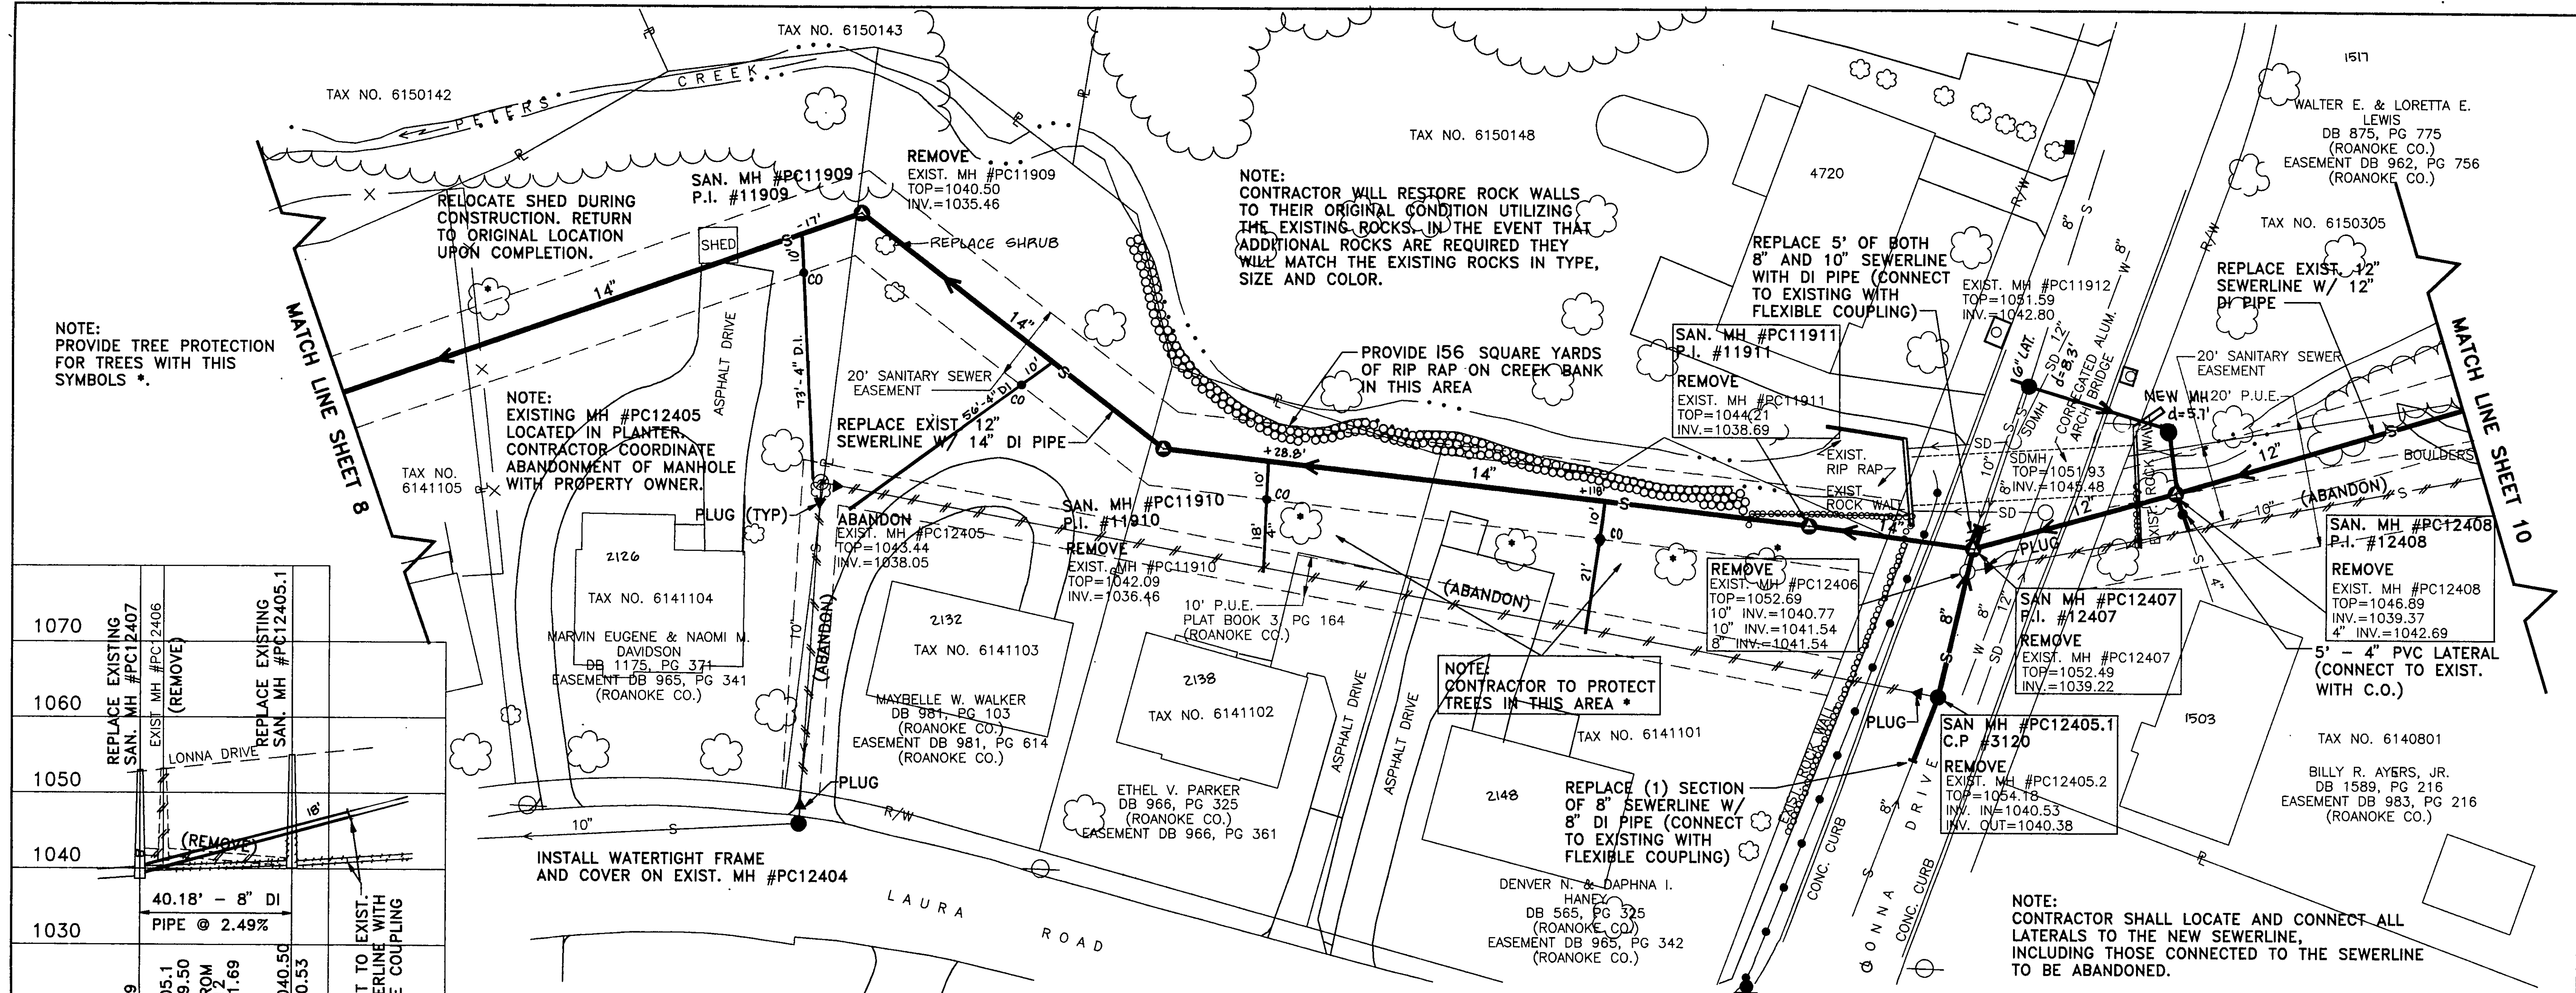

Mattern & Craig
CONSULTING ENGINEERS - SURVEYORS

DESIGNED: TAM
DRAWN: TAM
CHECKED: SWH

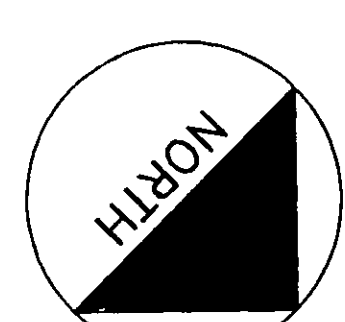

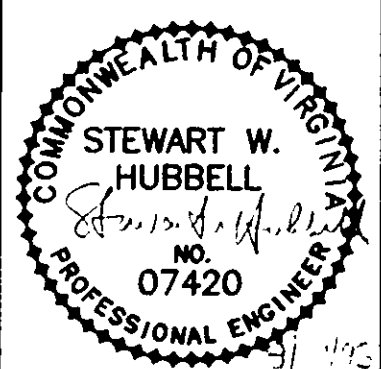

REV.	DATE	DESCRIPTION	BY	APP.
1	6-1-94	RECORD DRAWINGS	TAM	SWH

DATE
JUNE 1993

COMM. NO.
1245A

RECORD DRAWINGS
JUNE 1, 1994

PETERS CREEK SANITARY SEWER REPLACEMENT
PROJECT PC-2
PLAN AND PROFILE
CITY OF ROANOKE, VIRGINIA

SCALE: 1"=20' HORIZ.
1"=10' VERT.

SHEET
9