

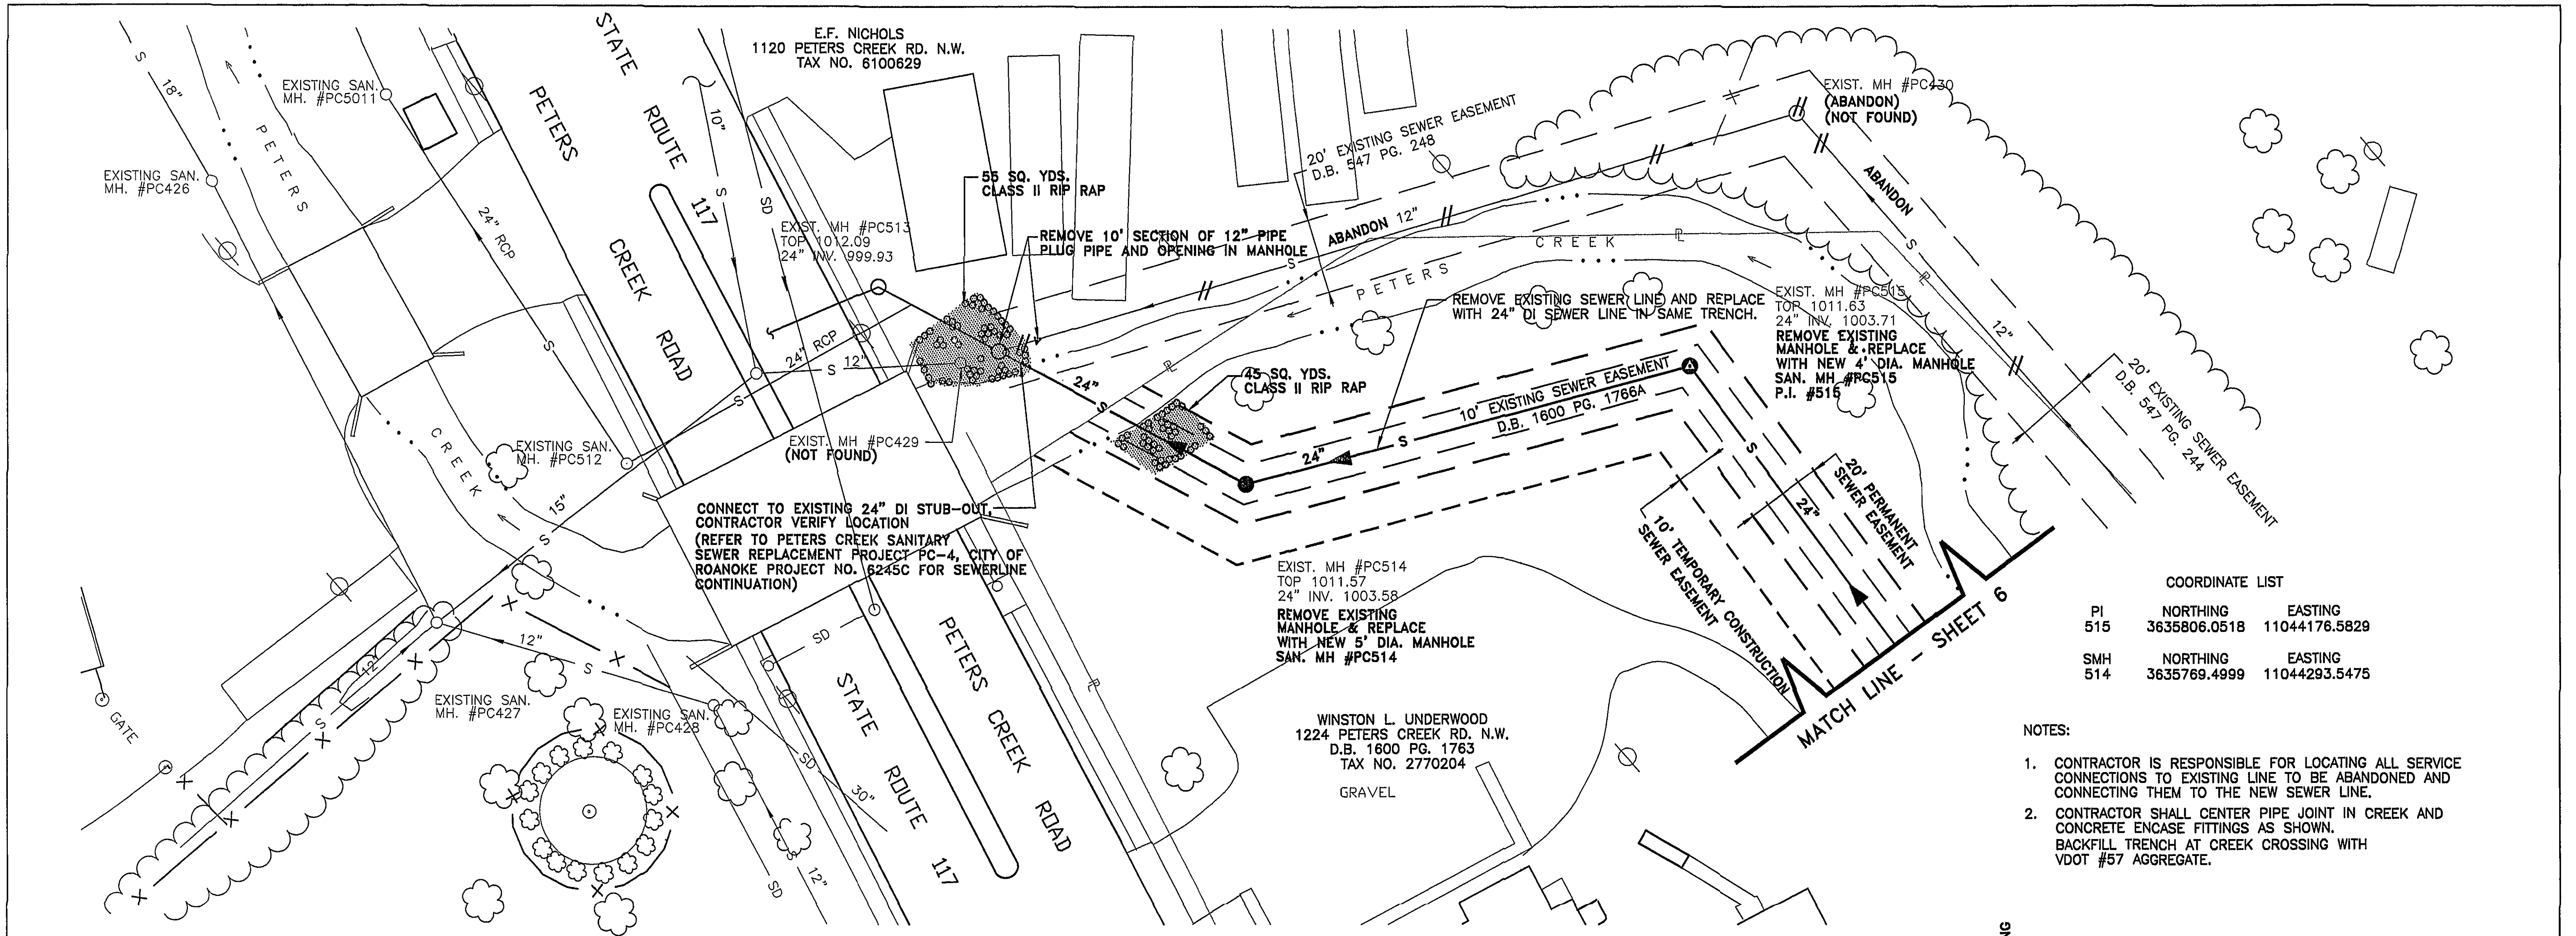
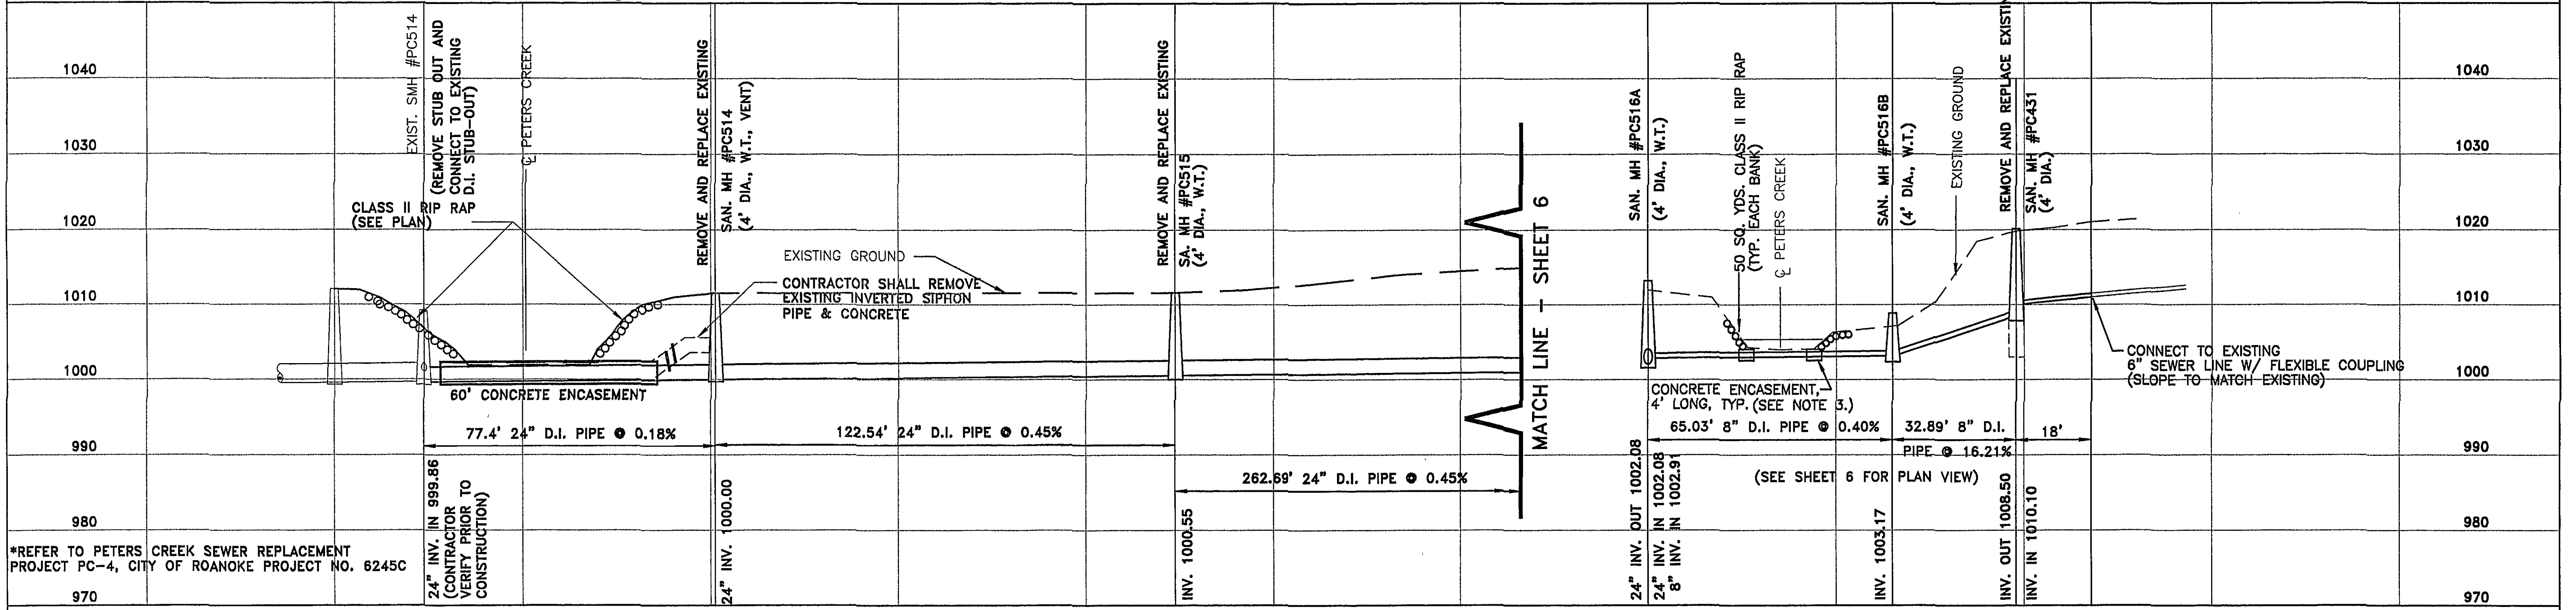
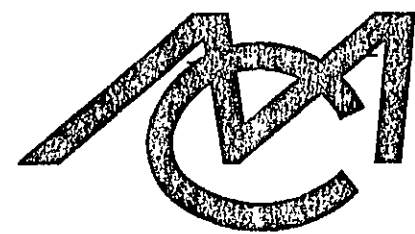


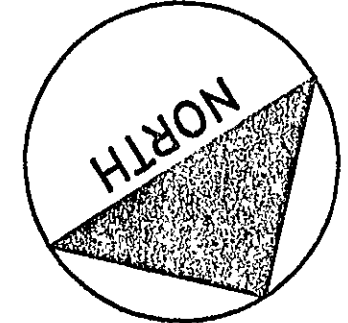

COORDINATE LIST		
PI	NORTHING	EASTING
515	3635806.0518	11044176.5829
SMH	NORTHING	EASTING
514	3635769.4999	11044293.5475

- NOTES:
- CONTRACTOR IS RESPONSIBLE FOR LOCATING ALL SERVICE CONNECTIONS TO EXISTING LINE TO BE ABANDONED AND CONNECTING THEM TO THE NEW SEWER LINE.
 - CONTRACTOR SHALL CENTER PIPE JOINT IN CREEK AND CONCRETE ENCASE FITTINGS AS SHOWN. BACKFILL TRENCH AT CREEK CROSSING WITH VDOT #57 AGGREGATE.

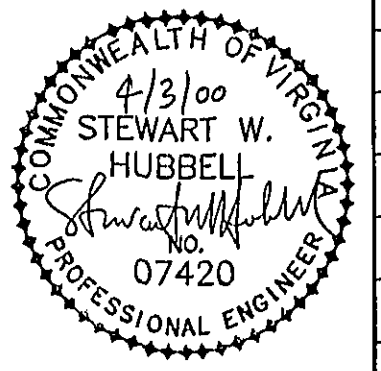

 Mattern & Craig CONSULTING ENGINEERS - SURVEYORS	DESIGNED: TAM	 	REV.	DATE	DESCRIPTION	BY	APP.	DATE	PETERS CREEK SANITARY SEWER REPLACEMENT PROJECT PC-3 PLAN AND PROFILE CITY OF ROANOKE, VIRGINIA	SHEET 5
	DRAWN: ASB							MARCH 2000		
	CHECKED: SWH							COMM. NO. 1245B		

SCALE: 1"=20' HORIZONTAL
1"=10' VERTICAL

WWW ID# 6M7HLJ
ADAD/1245B/5

PROJECT NO. 6245B