

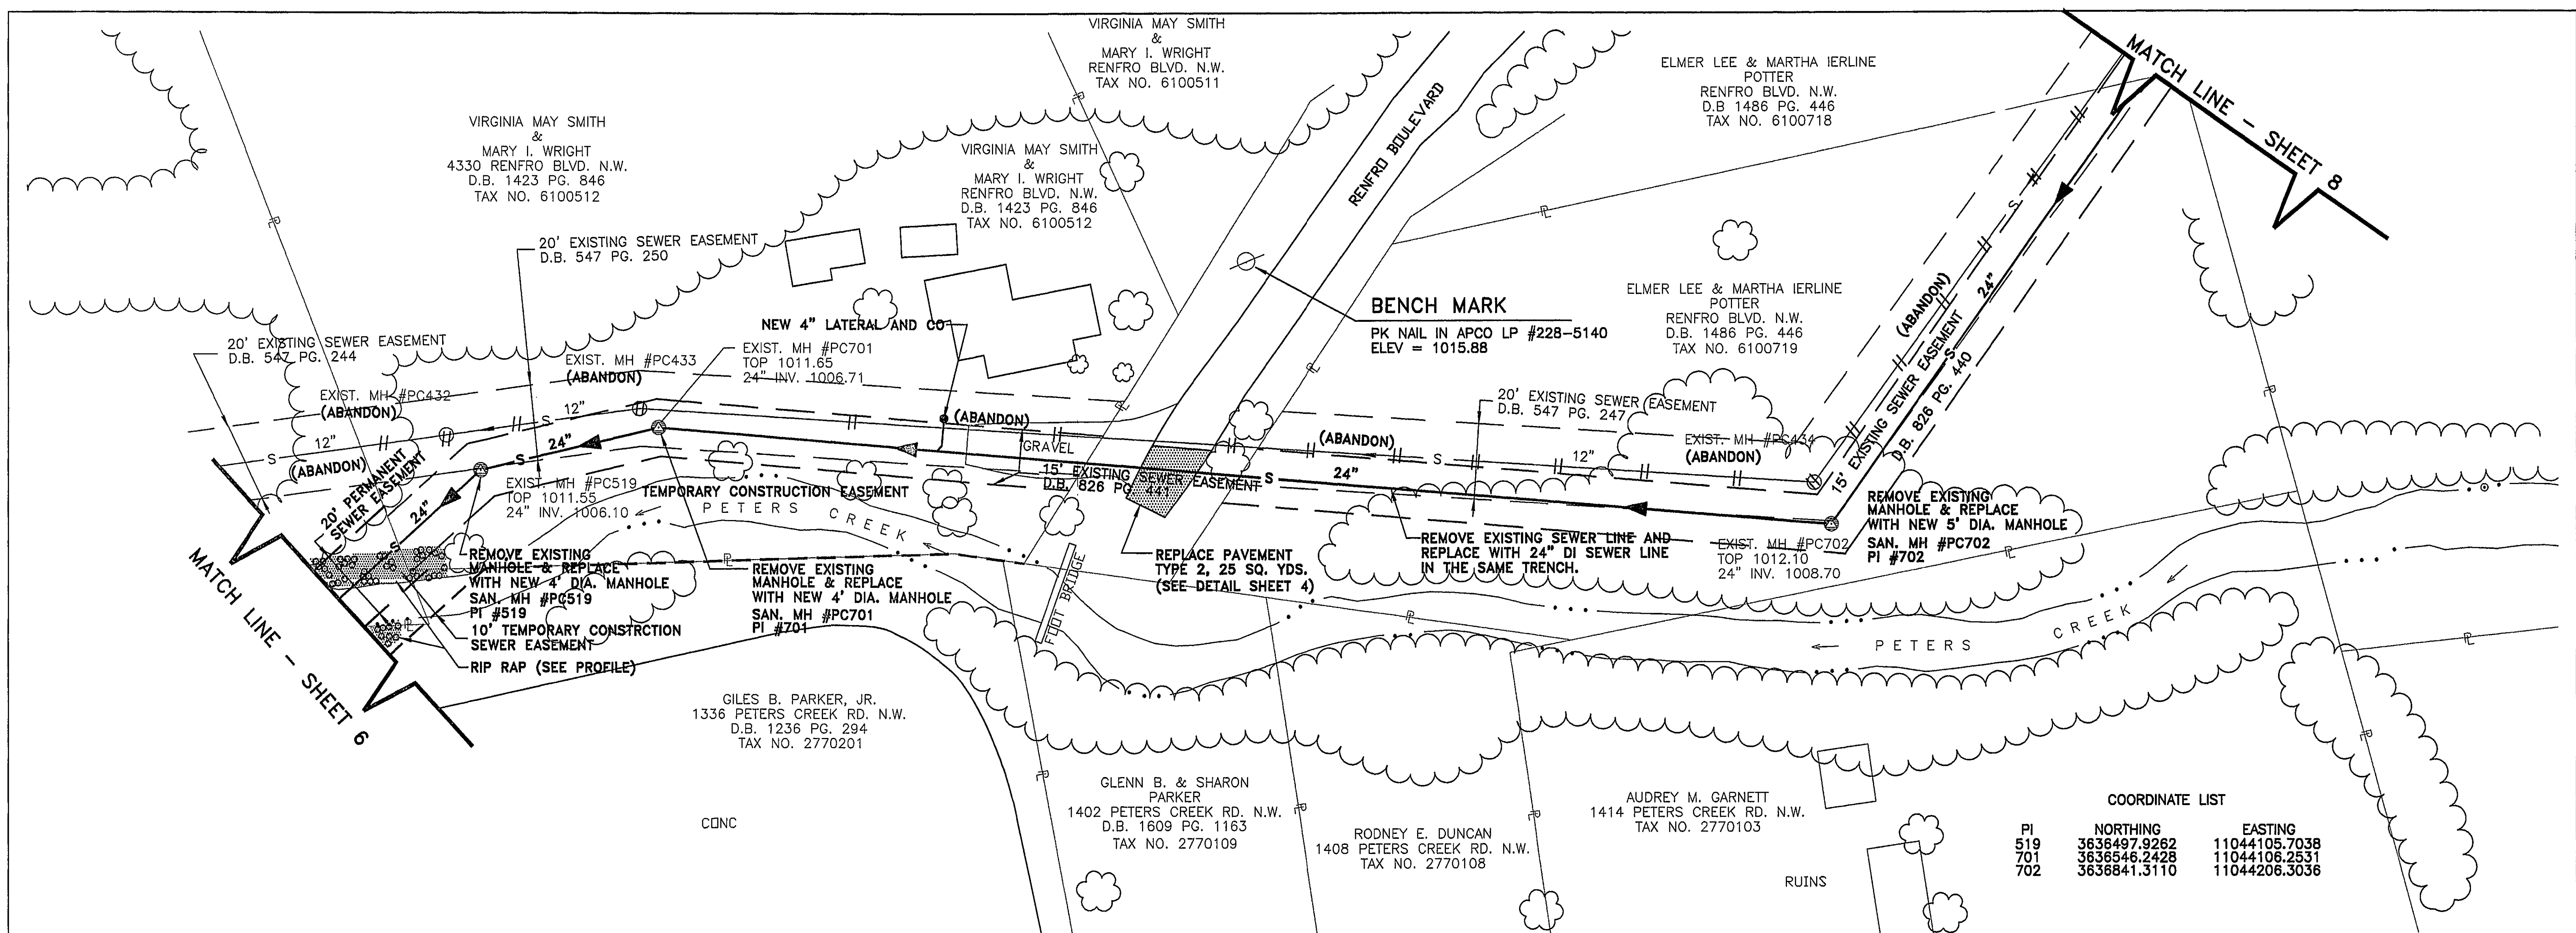
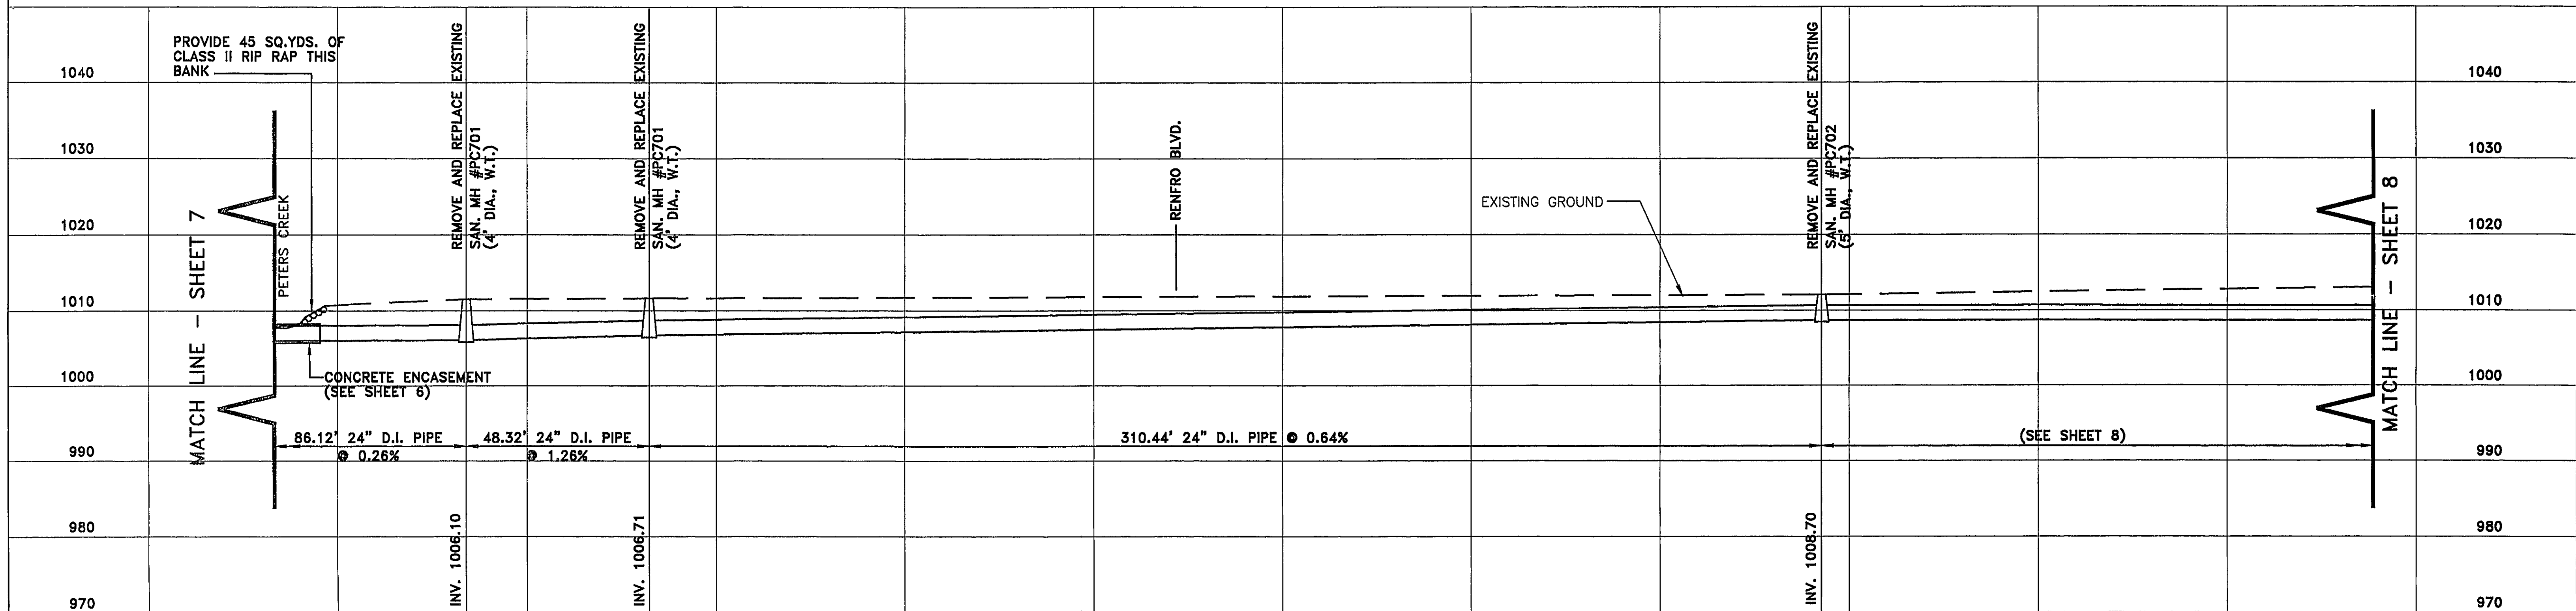
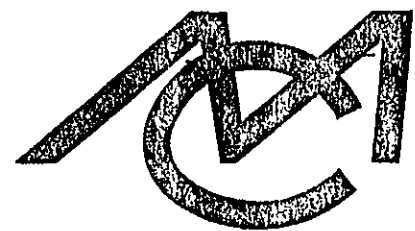


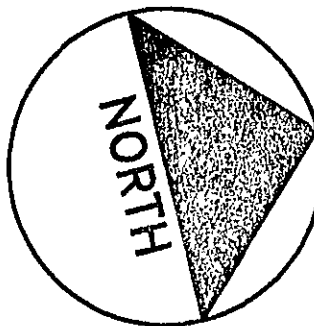

COORDINATE LIST		
PI	NORTHING	EASTING
519	3636497.9262	11044105.7038
701	3636546.2428	11044106.2531
702	3636841.3110	11044206.3036

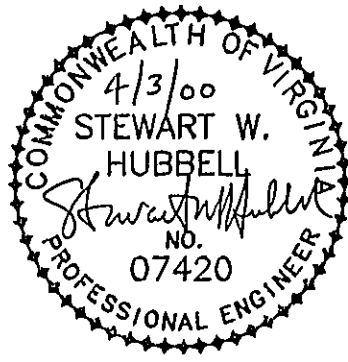

 Mattern & Craig CONSULTING ENGINEERS - SURVEYORS	DESIGNED: TAM	 	REV.	DATE	DESCRIPTION	BY	APP.	DATE	MARCH 2000 COMM. NO. 1245B	PETERS CREEK SANITARY SEWER REPLACEMENT PROJECT PC-3 PLAN AND PROFILE CITY OF ROANOKE, VIRGINIA	SHEET 7	
	DRAWN: ASB											
	CHECKED: SWH											