



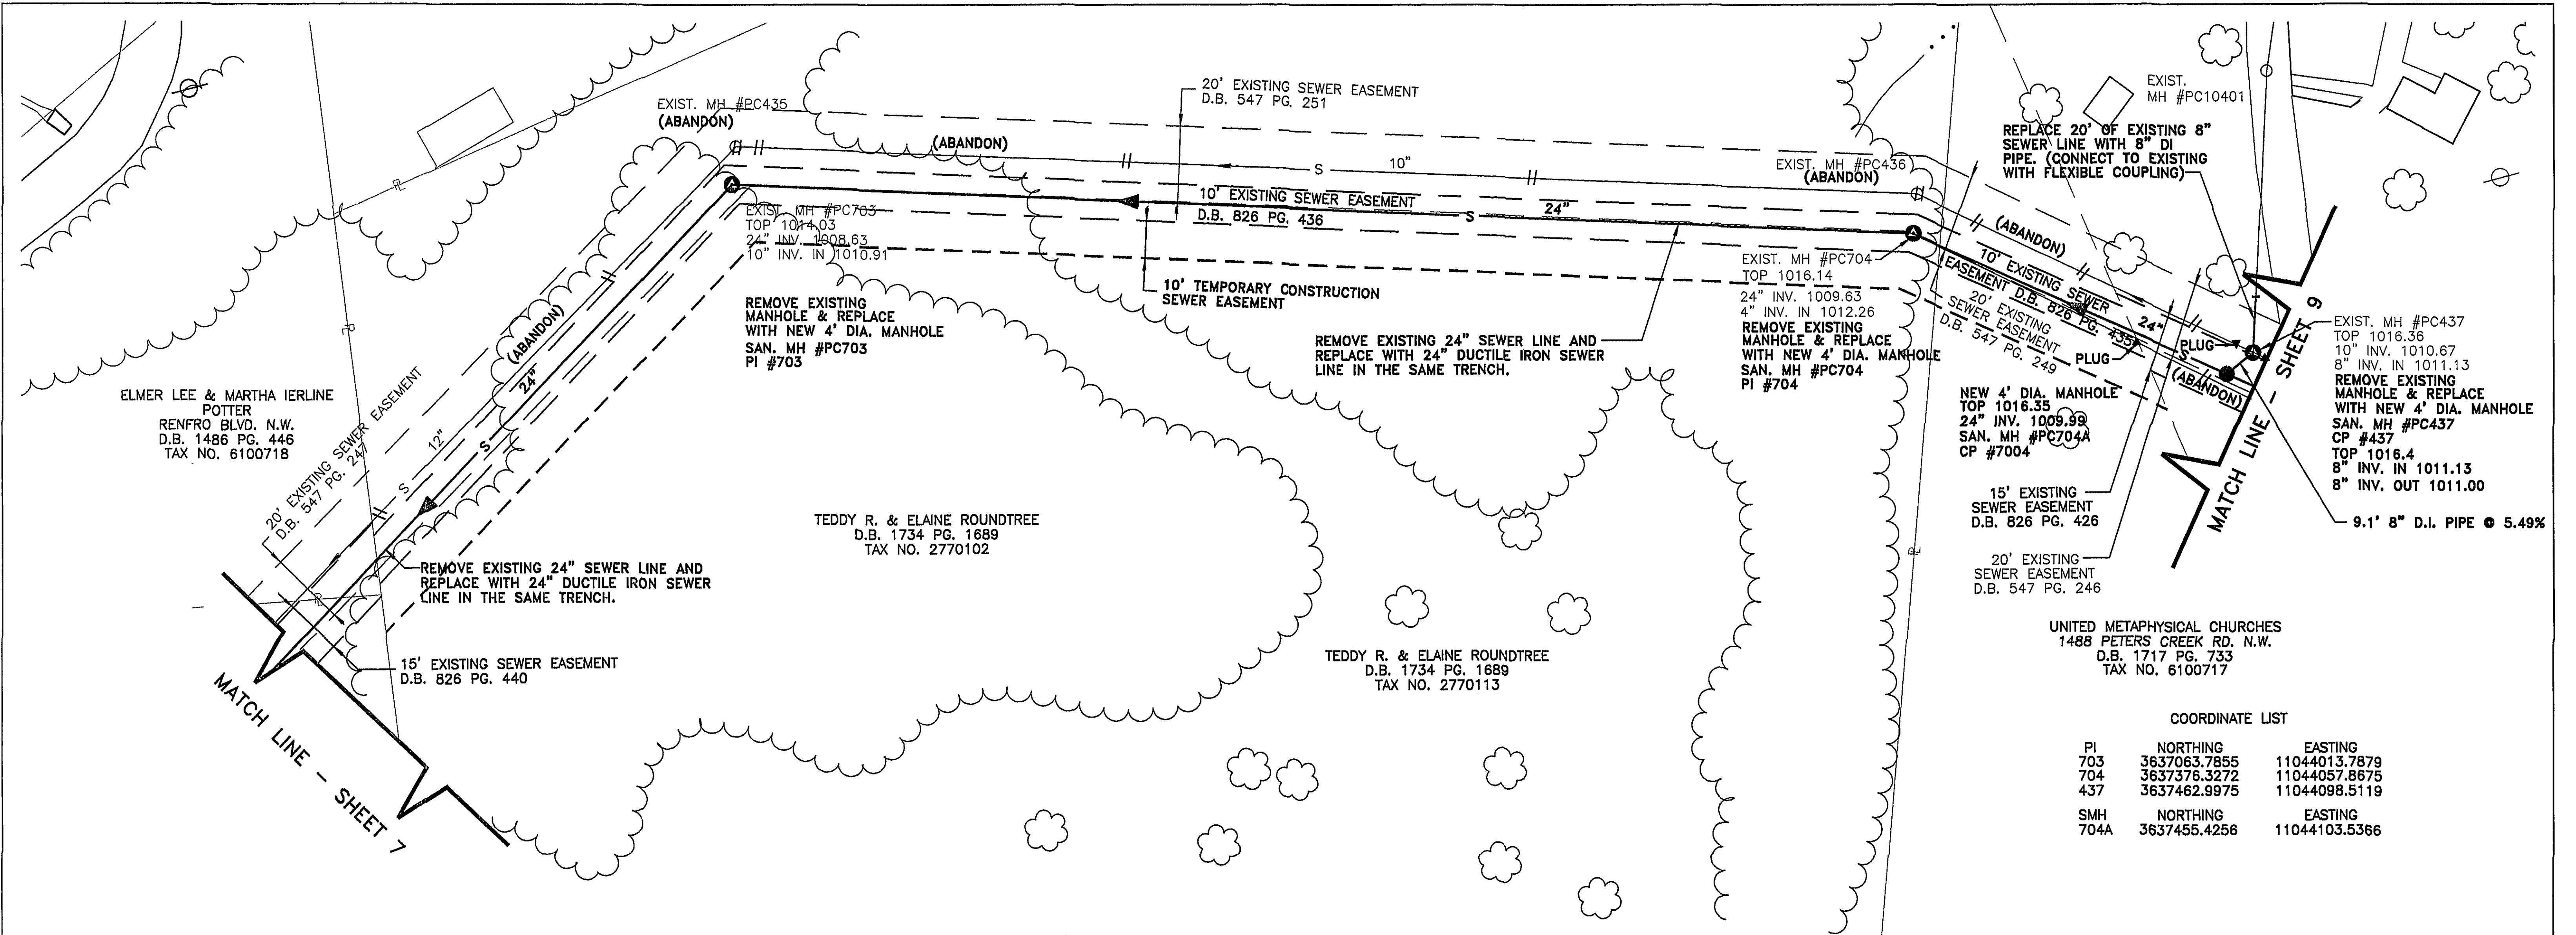


UNITED METAPHYSICAL CHURCHES
1488 PETERS CREEK RD. N.W.
D.B. 1717 PG. 733
TAX NO. 6100717

COORDINATE LIST



PI	NORTHING	EASTING
703	3637063.7855	11044013.7879
704	3637376.3272	11044057.8675
437	3637462.9975	11044098.5119
SMH	NORTHING	EASTING
704A	3637455.4256	11044103.5366

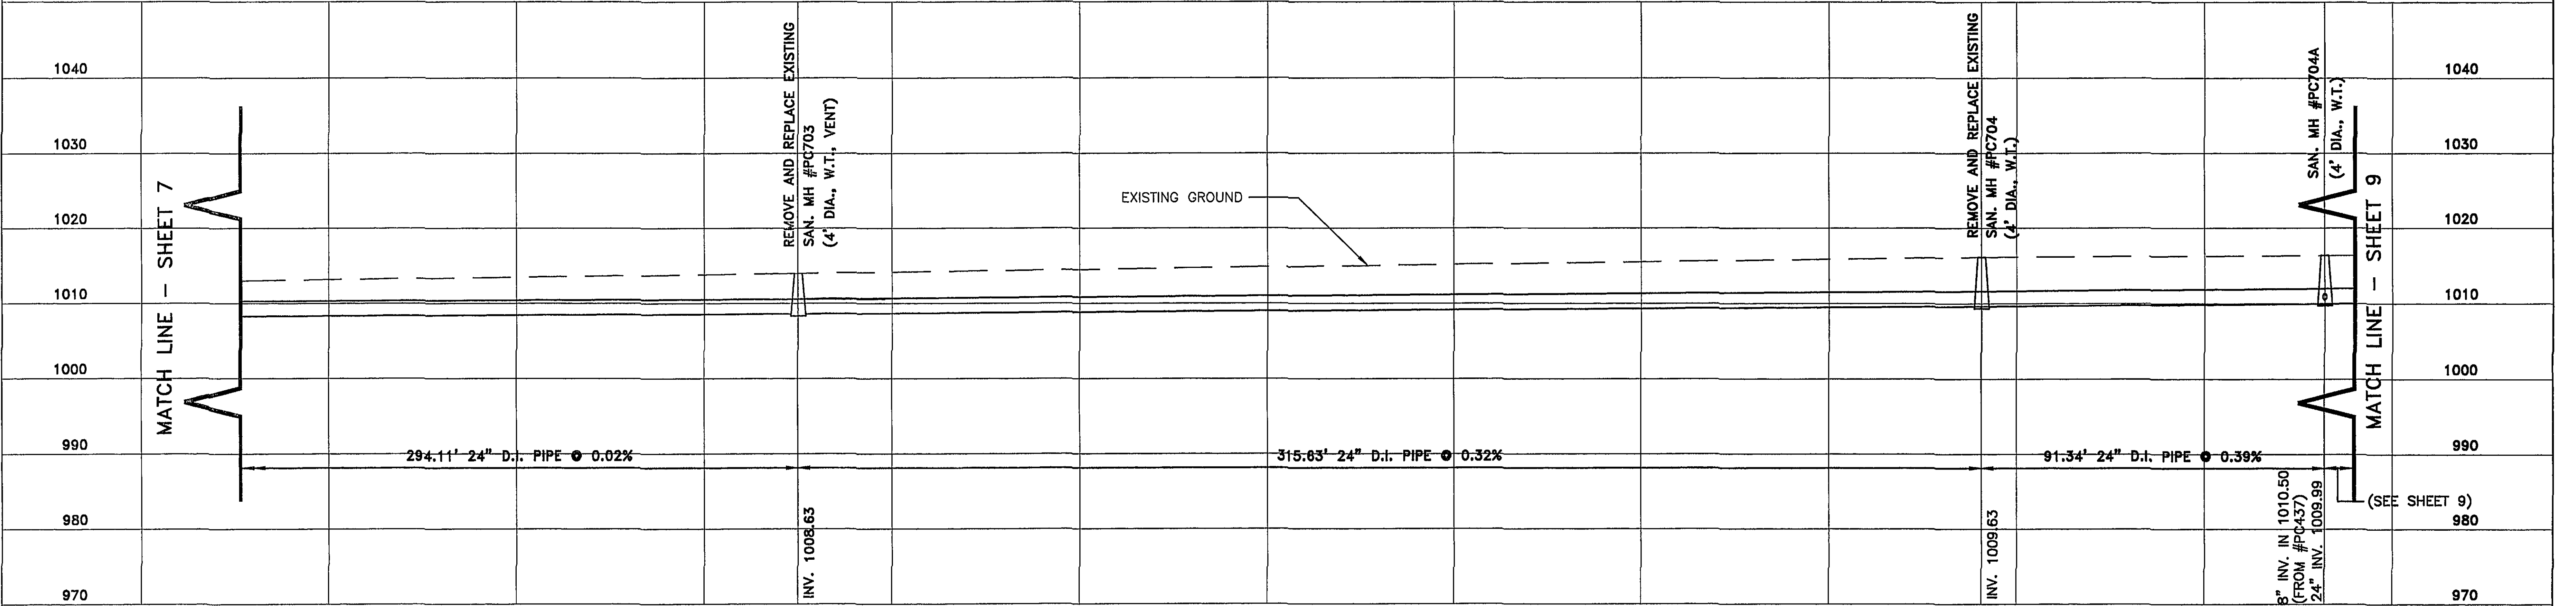

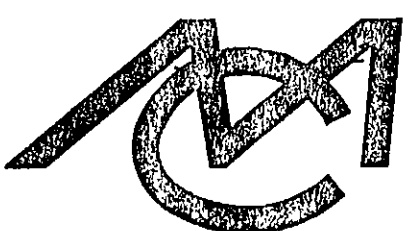

Mattern & Craig
CONSULTING ENGINEERS - SURVEYORS

DESIGNED: TAM
DRAWN: ASB
CHECKED: SWH

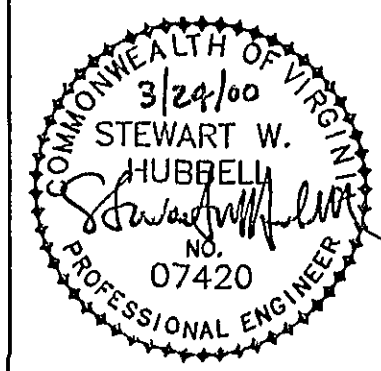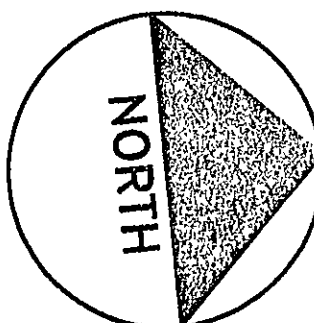

REV.	DATE	DESCRIPTION	BY	APP.

DATE: MARCH 2000
COMM. NO.: 1245B

PETERS CREEK SANITARY SEWER REPLACEMENT
PROJECT PC-3
PLAN AND PROFILE
CITY OF ROANOKE, VIRGINIA

SHEET: 8

SCALE: 1"=20' HORIZONTAL
1"=10' VERTICAL

WVVA ID# 6M7HLJ
ACAD/1245B/8