
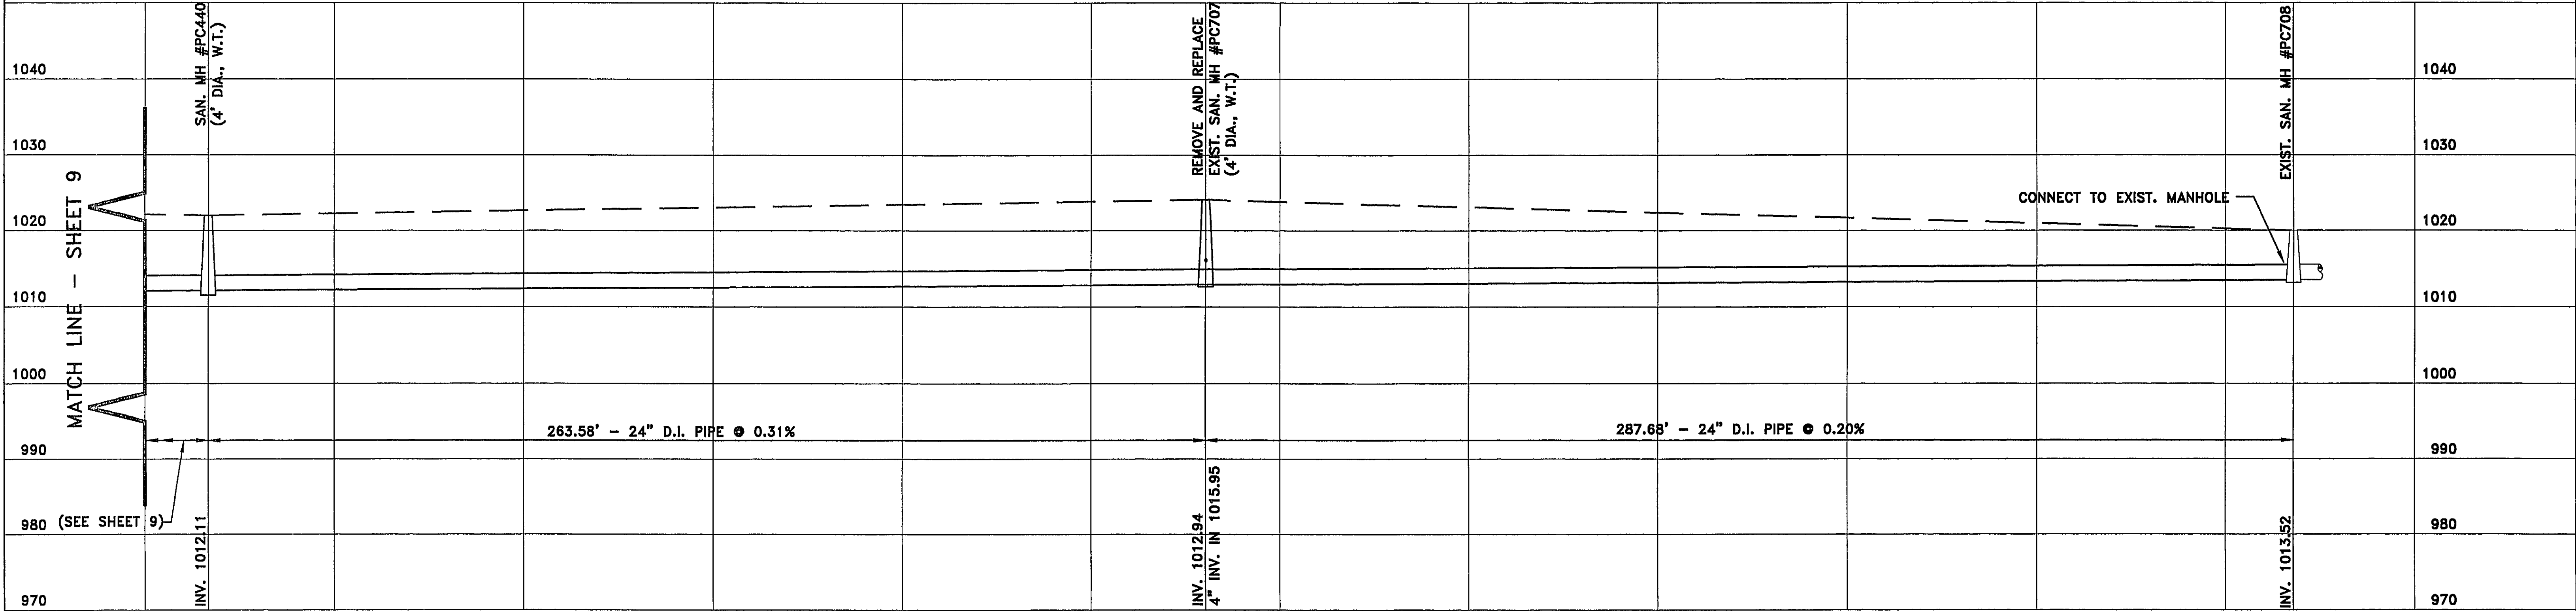
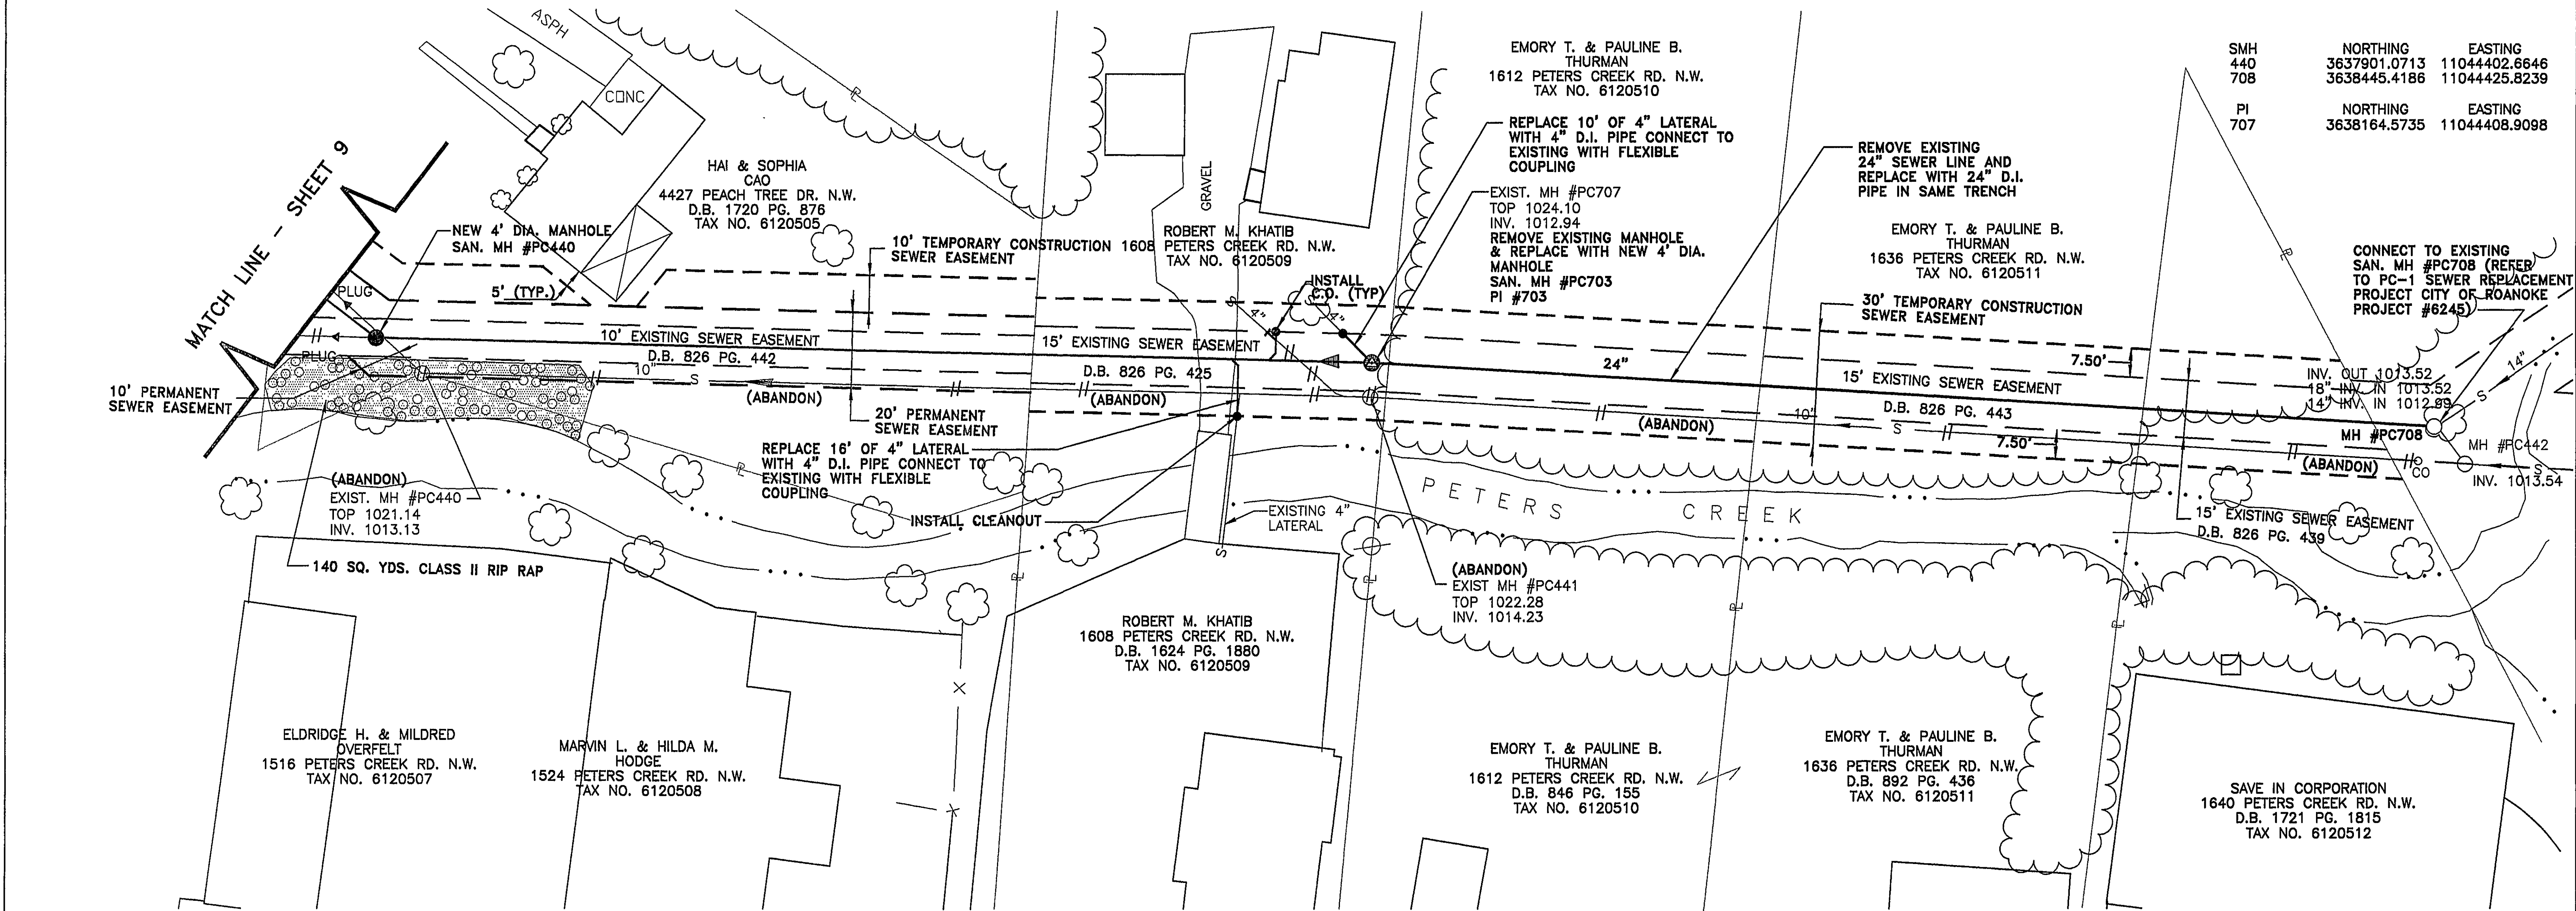
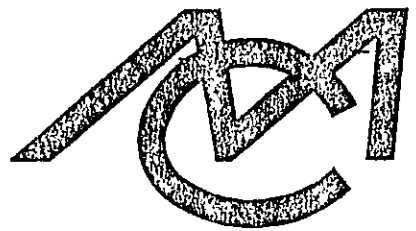
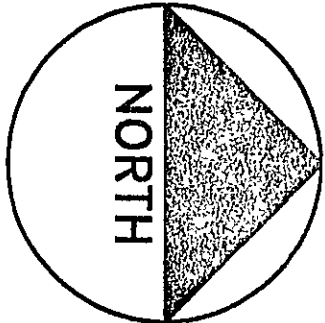


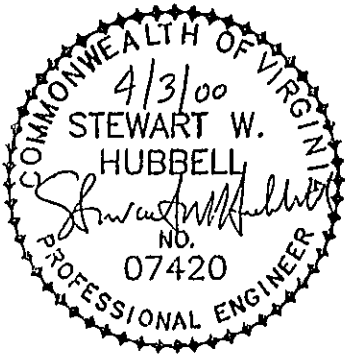

 Mattern & Craig CONSULTING ENGINEERS - SURVEYORS	DESIGNED: TAM			REV.	DATE	DESCRIPTION	BY	APP.	DATE	PETERS CREEK SANITARY SEWER REPLACEMENT PROJECT PC-3 PLAN AND PROFILE CITY OF ROANOKE, VIRGINIA SCALE: 1"=20' HORIZONTAL 1"=10' VERTICAL	SHEET 10	
	DRAWN: ASB											MARCH 2000
	CHECKED: SWH											COMM. NO. 1245B

ACAD/1245B/10

PROJECT NO. 6245B