
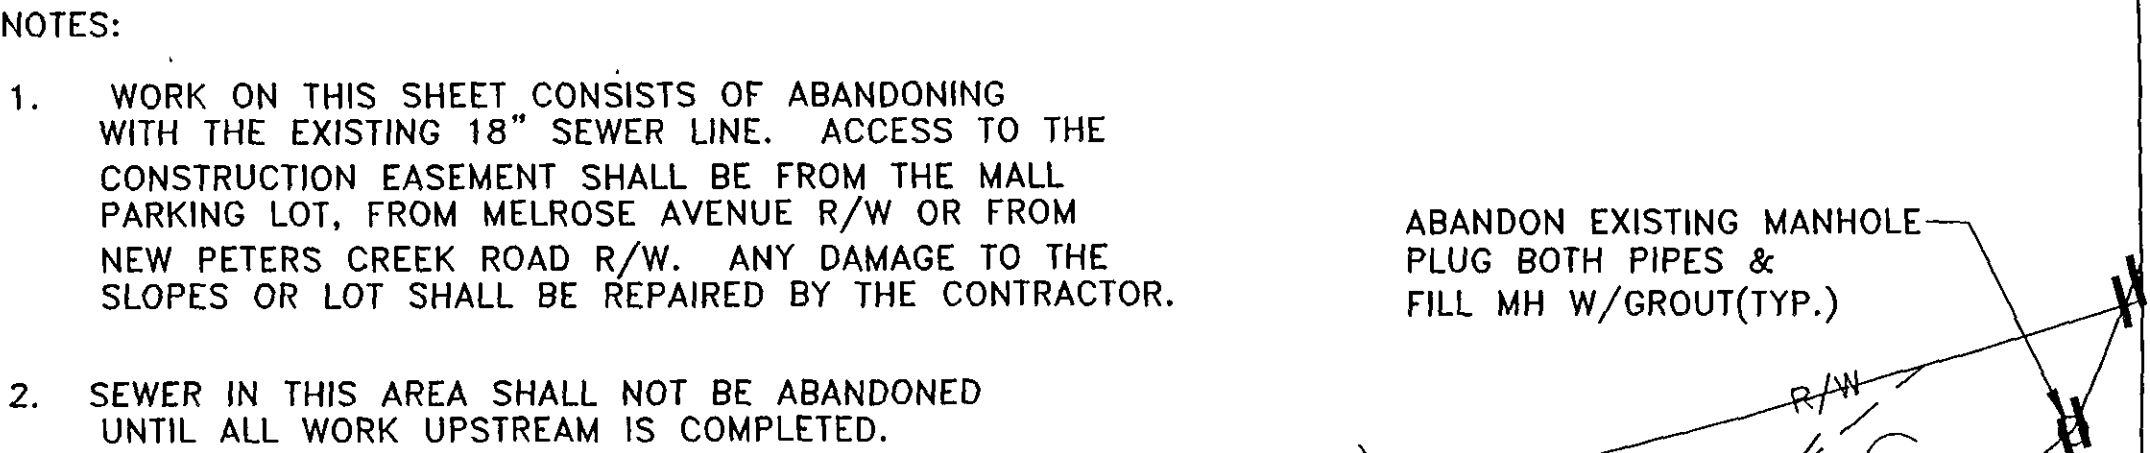
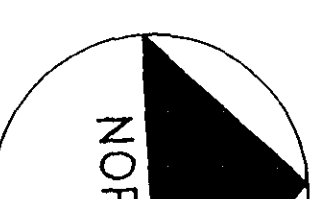


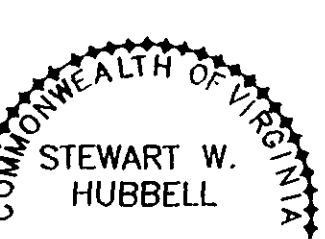

 Mattern & Craig CONSULTING ENGINEERS - SURVEYORS	DESIGNED: TAM	 	REV.	DATE	DESCRIPTION	BY	APP.	DATE	PETERS CREEK SANITARY SEWER REPLACEMENT PROJECT PC-4 PLAN AND PROFILE CITY OF ROANOKE, VIRGINIA SCALE: 1"=20' HORIZONTAL 1"=10' VERTICAL	SHEET
	DRAWN: ASB			11/95	AS PER CITY COMMENTS	DSG	SWH	JANUARY 1995		5
	CHECKED: SWH			10/98	RECORD DRAWINGS	JMC	SWH	COMM. NO. 1245C		