

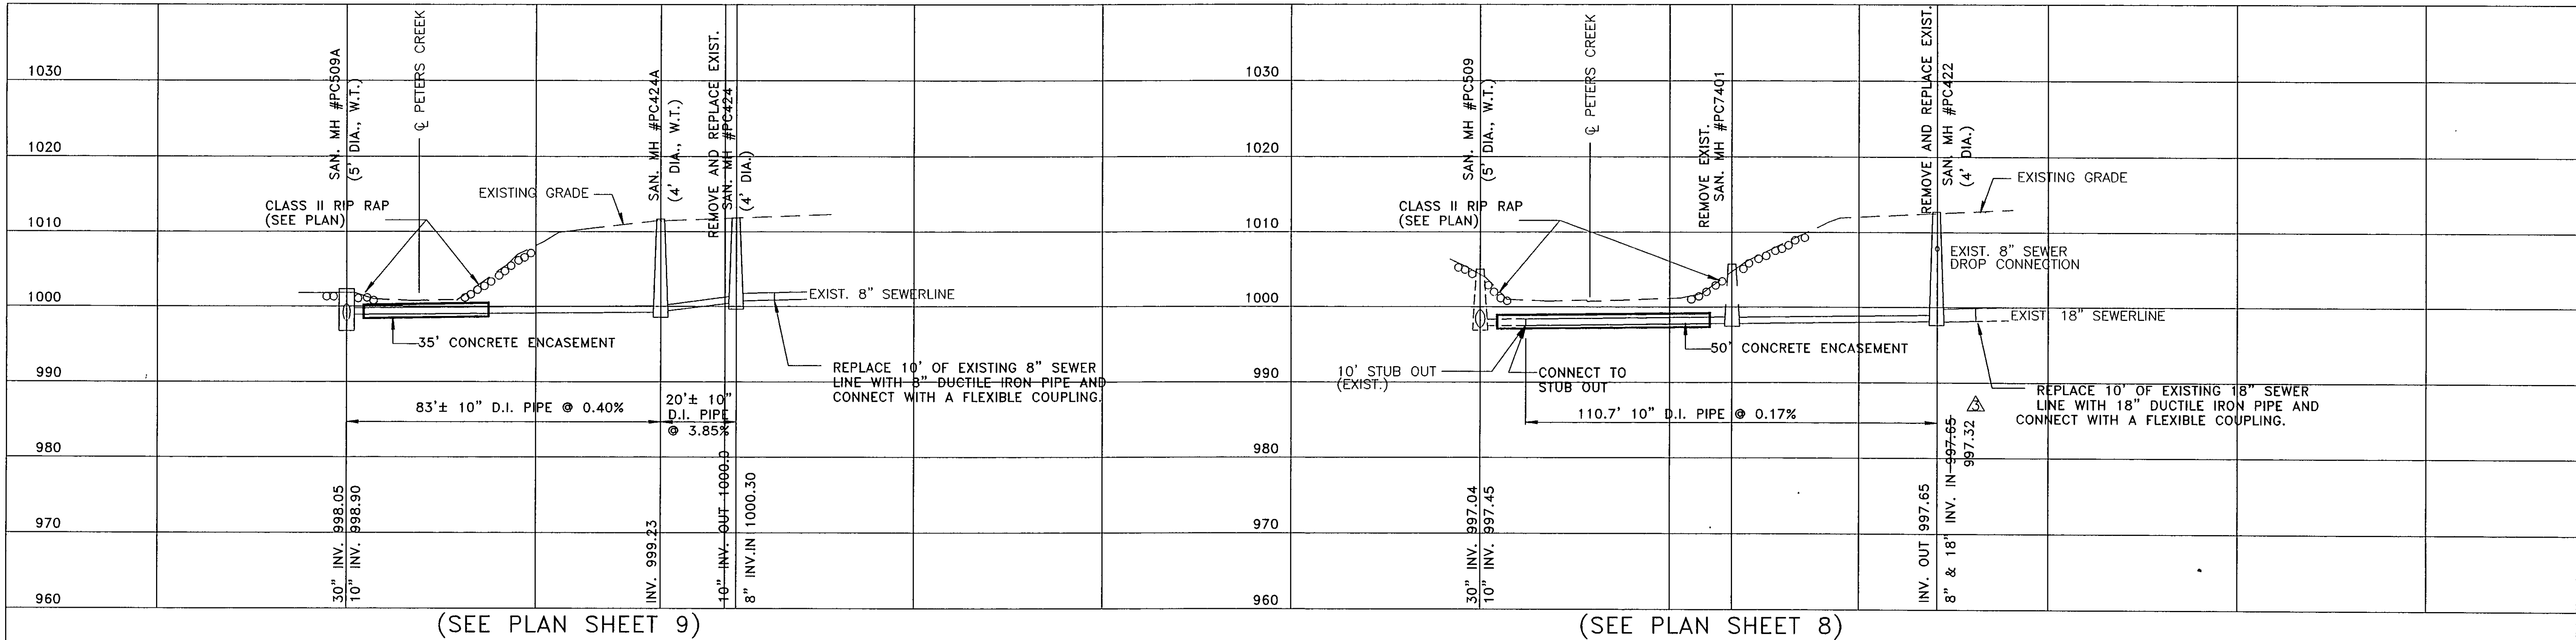
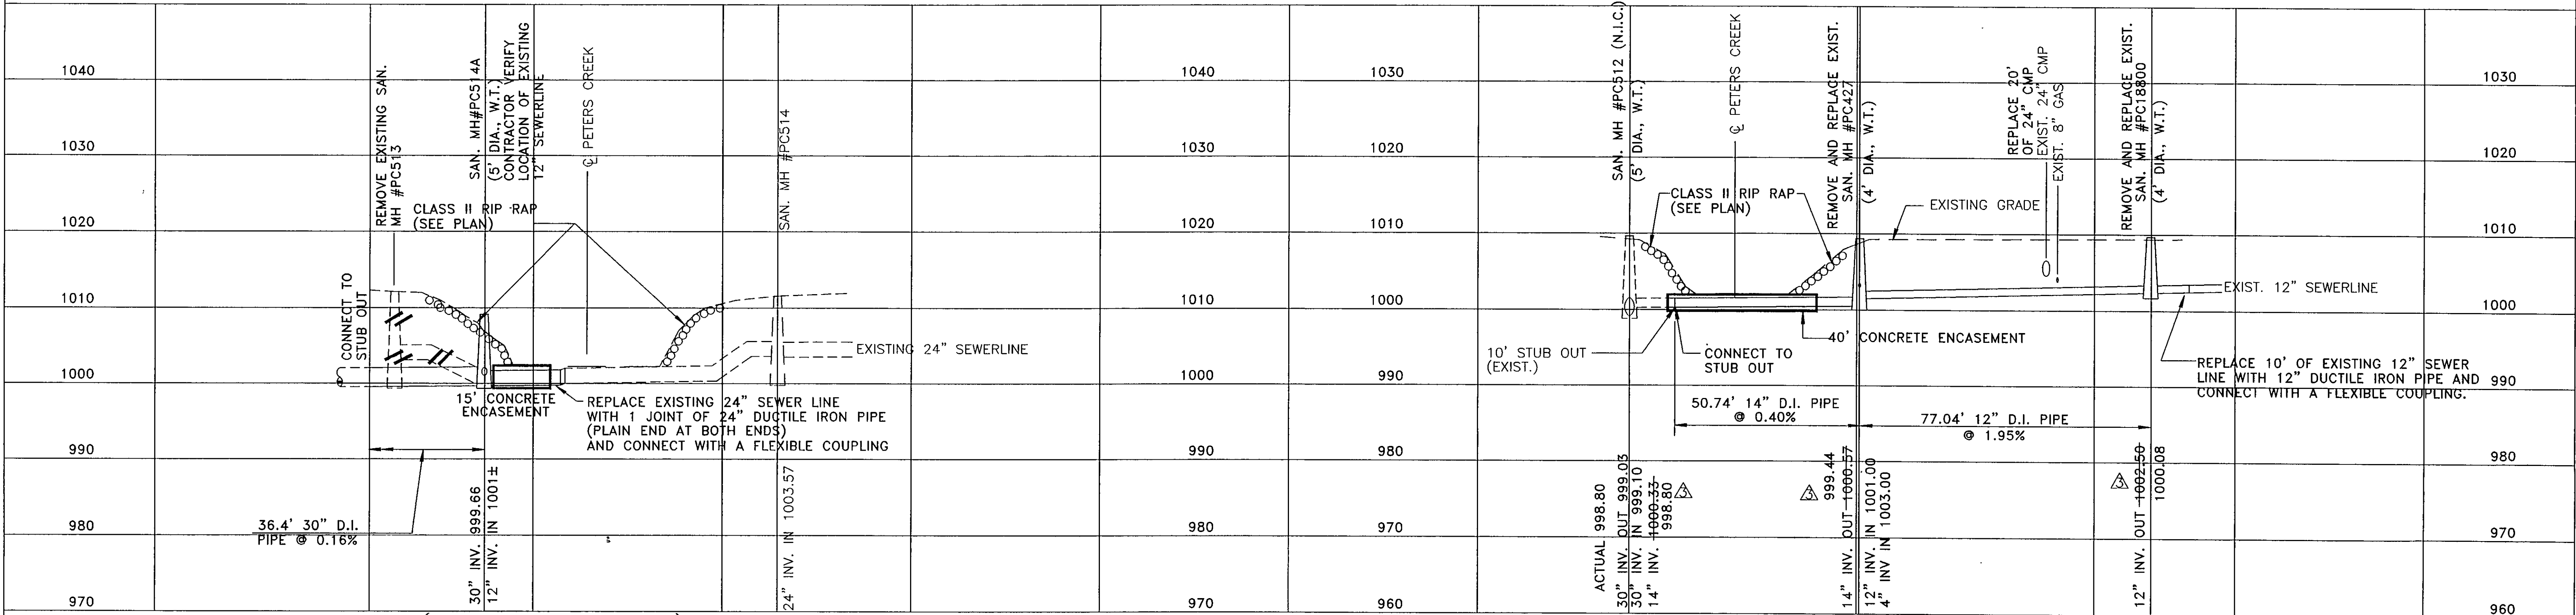


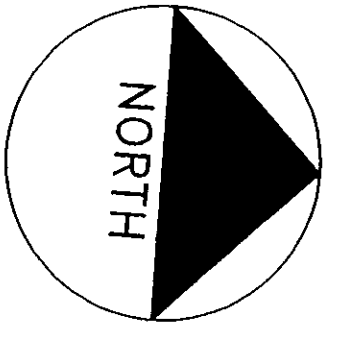

RECORD DRAWINGS
10-11-98

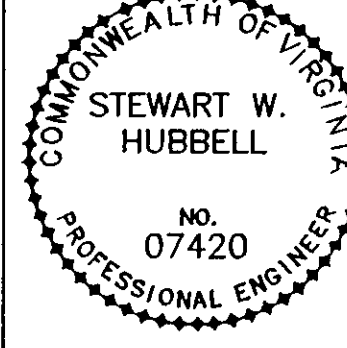

 Mattern & Craig CONSULTING ENGINEERS - SURVEYORS	DESIGNED:	TAM	 NORTH		REV.	DATE	DESCRIPTION	BY	APP.	DATE JANUARY 1995 COMM. NO. 1245C	PETERS CREEK SANITARY SEWER REPLACEMENT PROJECT PC-4 PLAN AND PROFILE CITY OF ROANOKE, VIRGINIA SCALE: 1"=20' HORIZONTAL 1"=10' VERTICAL	SHEET 10 ACAD/1245C/10
	DRAWN:	ASB			△	11/95	AS PER CITY COMMENTS	DSG	SWH			
	CHECKED:	SWH			△	1/98	AS PER CITY COMMENTS	DSG	SWH			
					△	10/98	RECORD DRAWINGS	JMC	SWH			