





S:\angels\12451\4 Mon Aug 05 15:44:33 1996

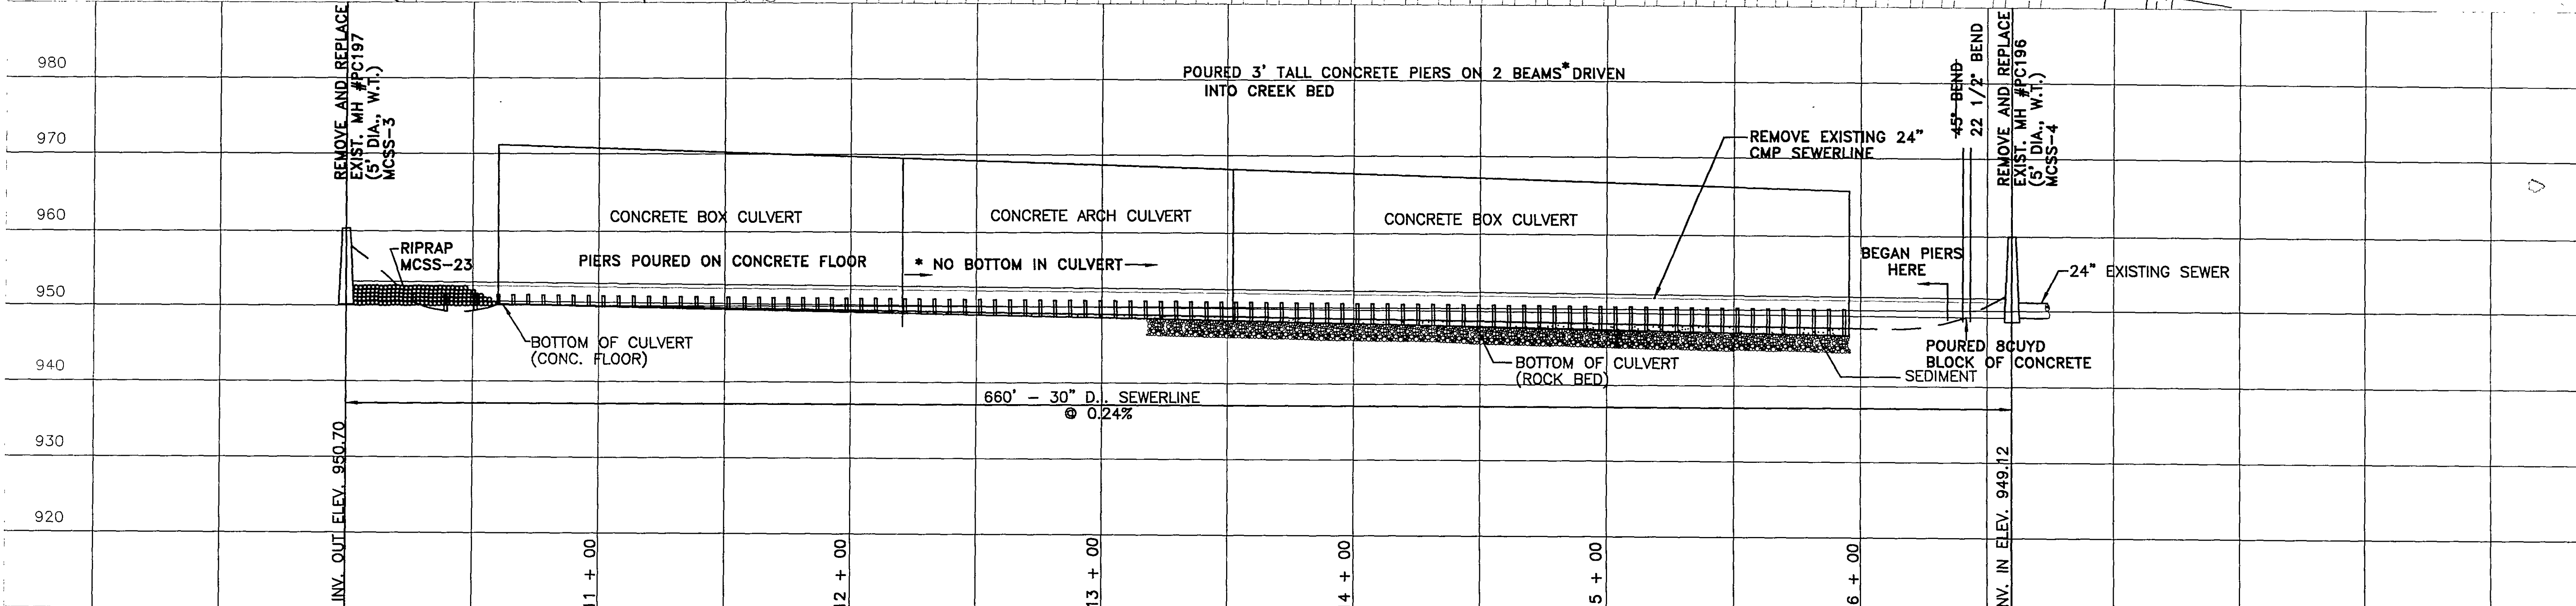

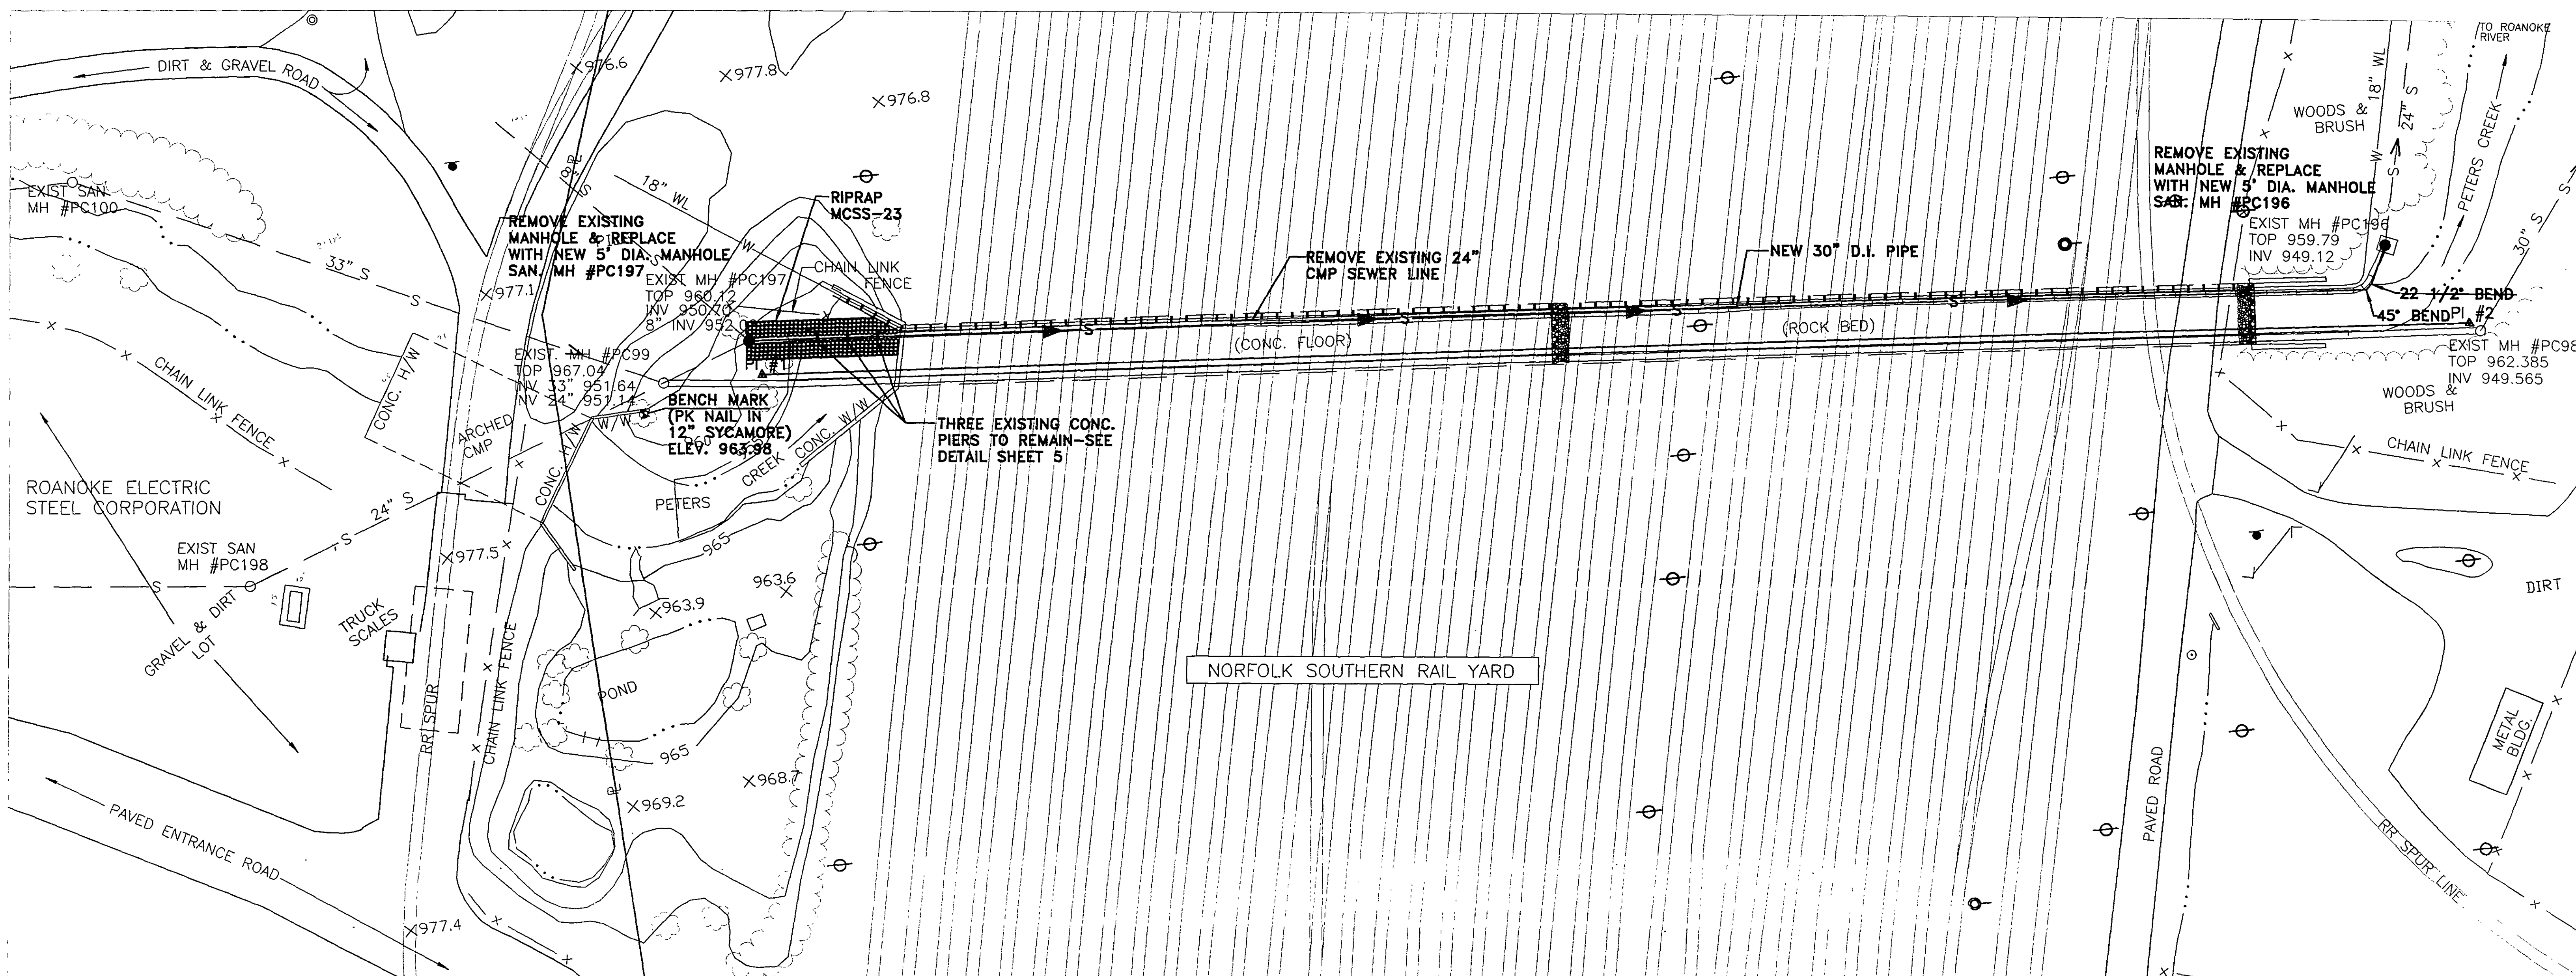

Mattern & Craig
CONSULTING ENGINEERS - SURVEYORS

DESIGNED: SWH
DRAWN: JMC
CHECKED: SWH

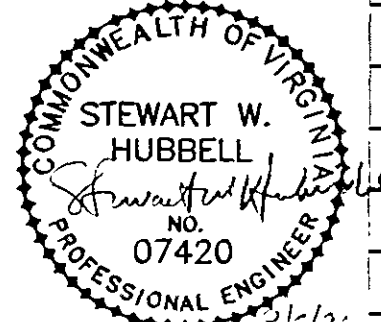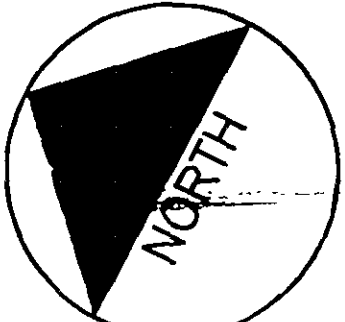

REV.	DATE	DESCRIPTION	BY	APP.

DATE: MARCH 1995
COMM. NO.: 12451

PETERS CREEK SANITARY SEWER REPLACEMENT
PROJECT PC-6A
PLAN AND PROFILE
CITY OF ROANOKE, VIRGINIA

SHEET 4

SCALE: 1"=30' HORIZONTAL
1"=10' VERTICAL

RECORD DRAWINGS
8-5-96

PROJECT NO. 62451

ADMS12451