

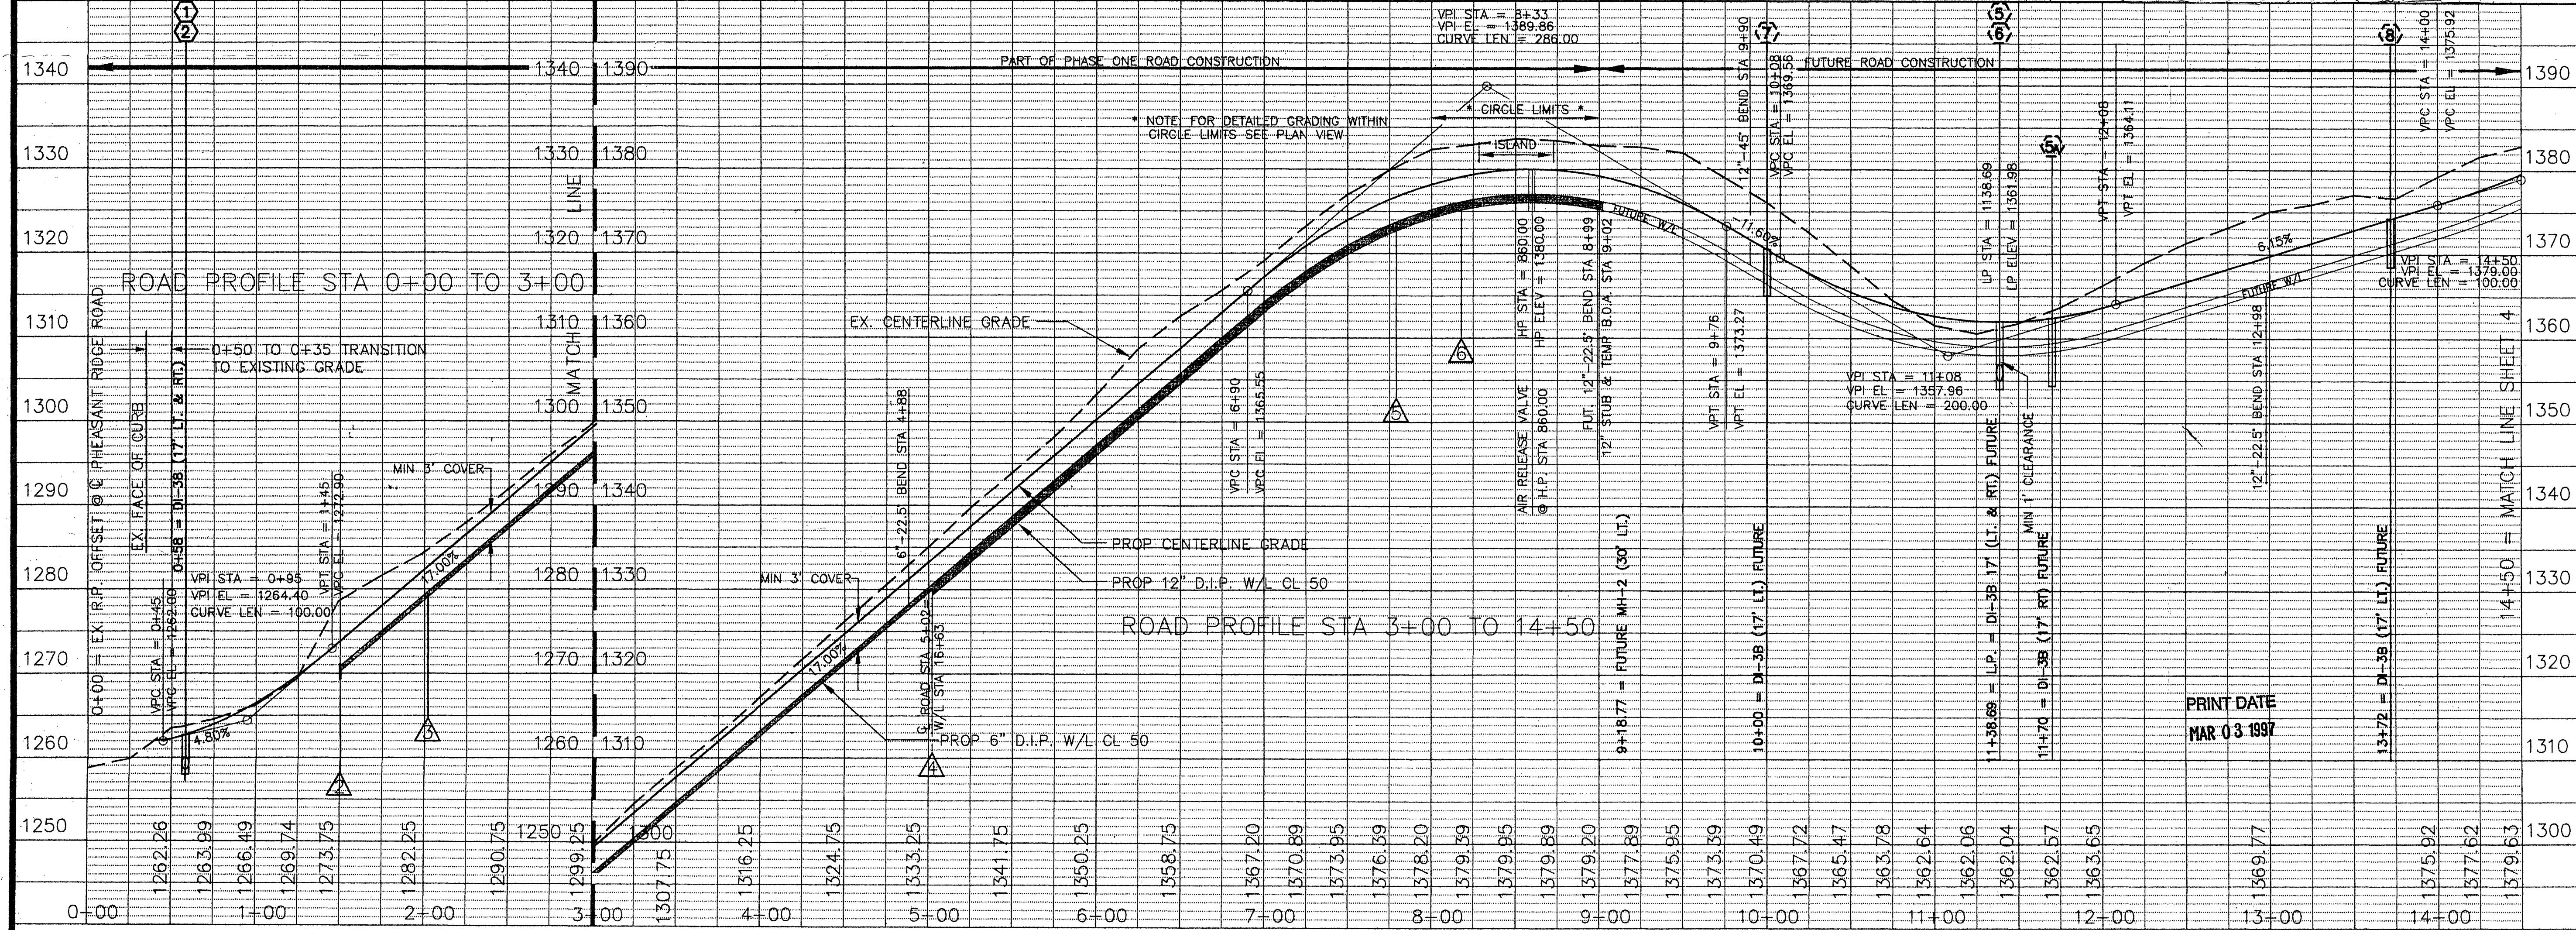


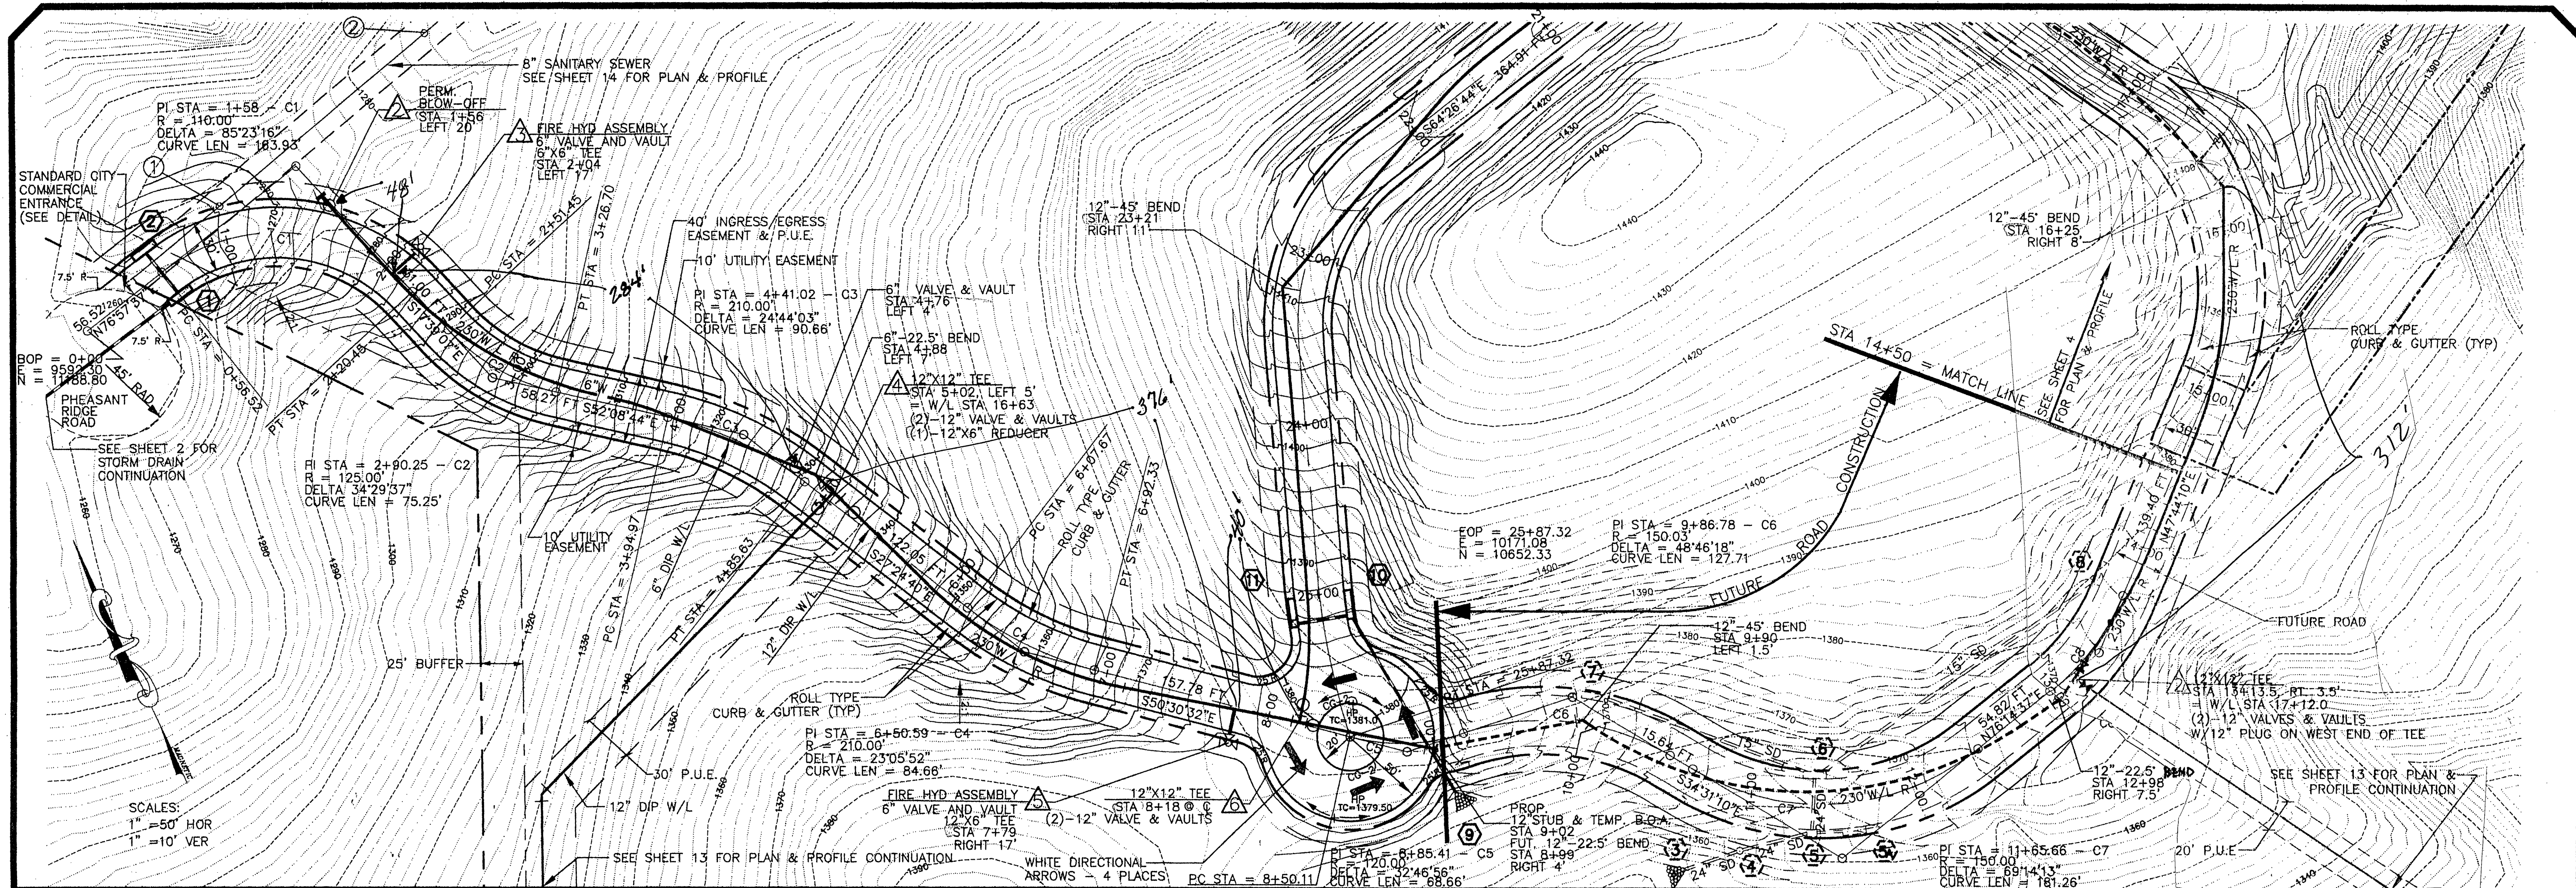

FILE: RCP01001.DWG 4-15-98 ACQUINR13.CEV

SEE SHEET 14 FOR SANITARY SEWER PLAN & PROFILE
SEE SHEET 15 FOR STORM DRAIN PROFILES
SEE SHEET 17 FOR EROSION & SEDIMENT CONTROL
SEE SHEET 4 FOR TYPICAL SECTION

(1) REV. PER CLIENT

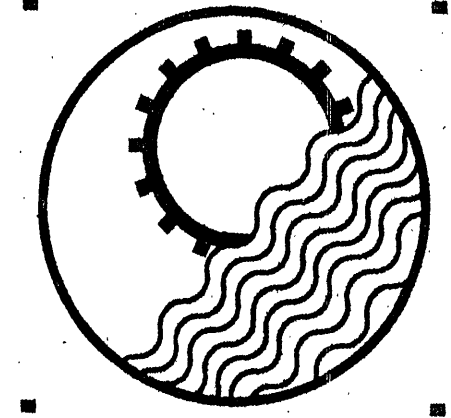


ENGINEERING
CONCEPTS INC.

DESIGNED	CEV/JDE
DRAWN	CEV
CHECKED	LWW/JDE
APPROVED	LWW
SCALE	1"=50'HOR:1"=10'VERT
DATE	APR 96
PROJECT	96017

REVISIONS		
NO.	DATE	BY
1	8/5/96	JDE
2	12/6/96	JDE
3	2/20/97	JDE

ROANOKE NURSING FACILITY
ROAD PLAN AND PROFILE
CITY OF ROANOKE, VIRGINIA

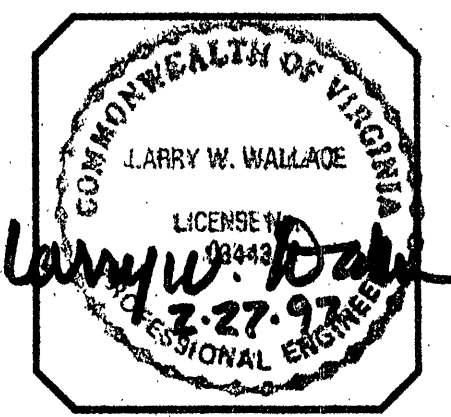

SHEET NO.
3
OF 22