


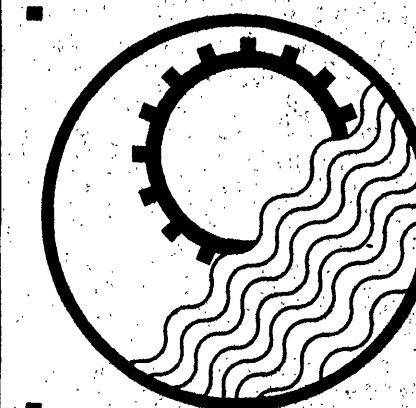

ENGINEERING
CONCEPTS INC.

DESIGNED
JDE
DRAWN
RHW/JDE
CHECKED
LWW/JDE
APPROVED
LWW
SCALE
1"=30'
DATE
APR 96
PROJECT
96017

REVISIONS		
NO.	DATE	BY


SITE PLAN FOR
ROANOKE NURSING FACILITY
CITY OF ROANOKE, VA

SHEET NO.

10

22

OF

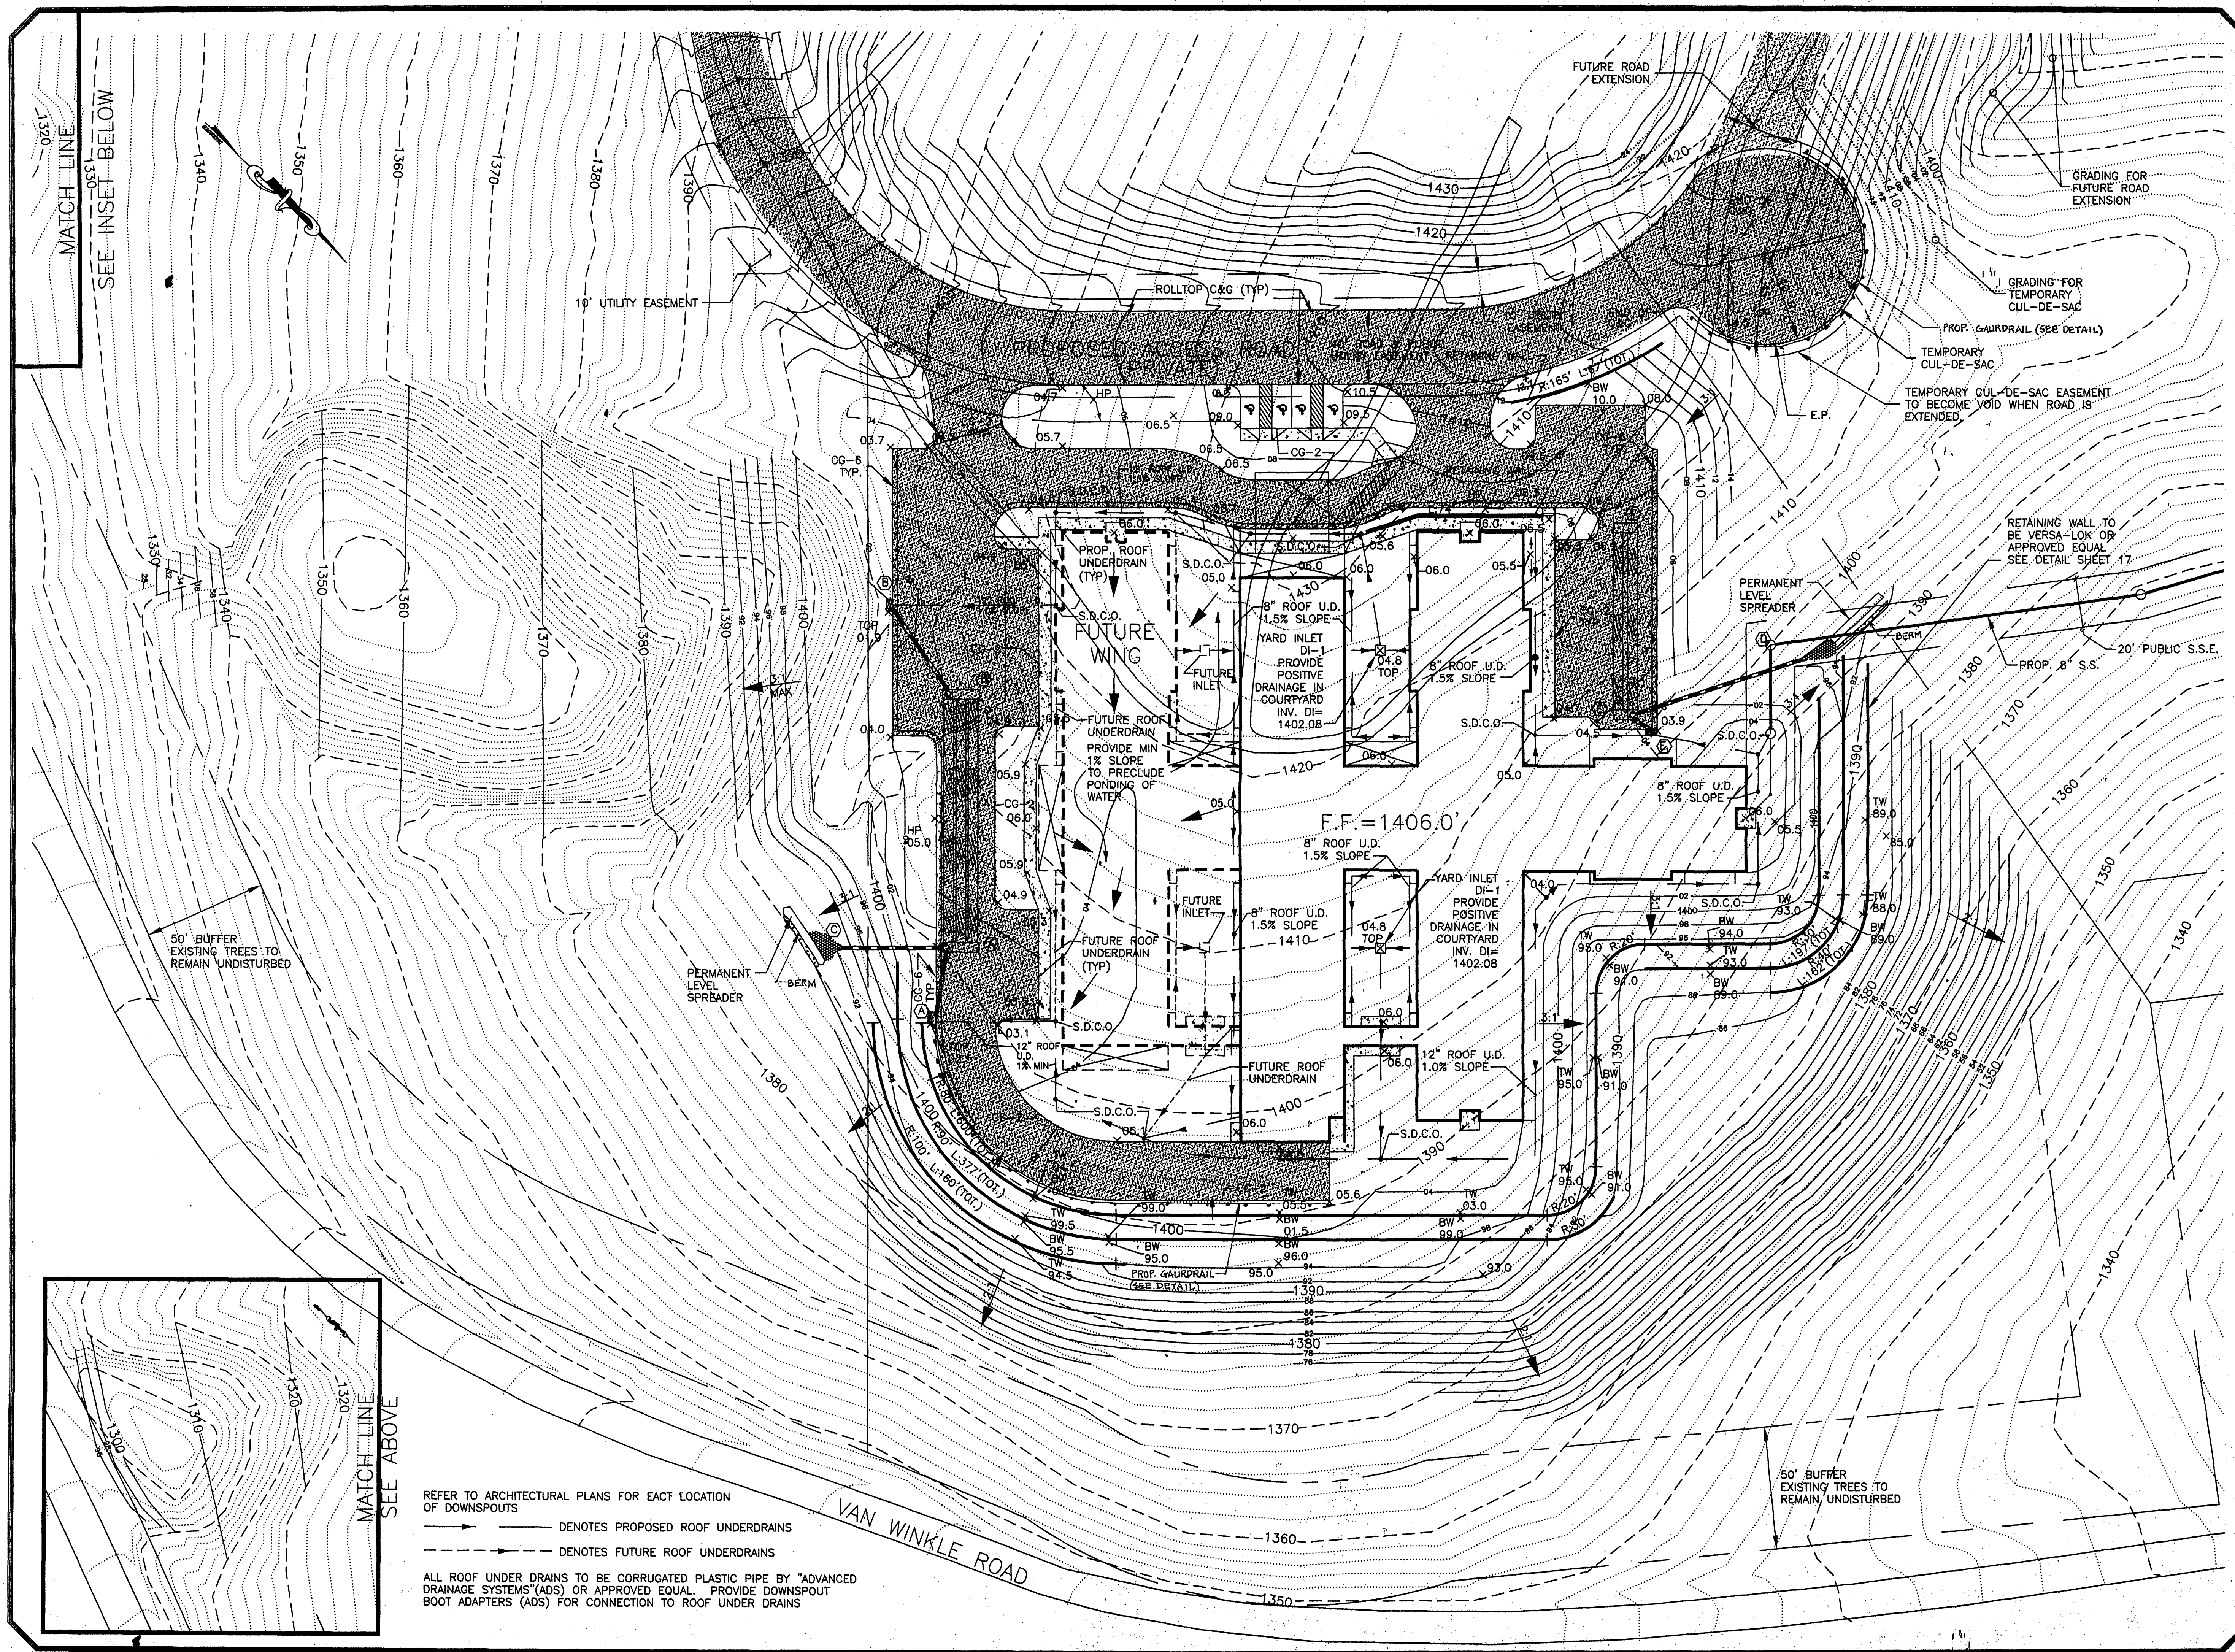

REFER TO ARCHITECTURAL PLANS FOR EXACT LOCATION
OF DOWNSPOUTS

— DENOTES PROPOSED ROOF UNDERDRAINS
- - - DENOTES FUTURE ROOF UNDERDRAINS

ALL ROOF UNDERDRAINS TO BE CORRUGATED PLASTIC PIPE BY "ADVANCED
DRAINAGE SYSTEMS" (ADS) OR APPROVED EQUAL. PROVIDE DOWNSPOUT
BOOT ADAPTERS (ADS) FOR CONNECTION TO ROOF UNDERDRAINS