


MATCHLINE A

MATCHLINE B

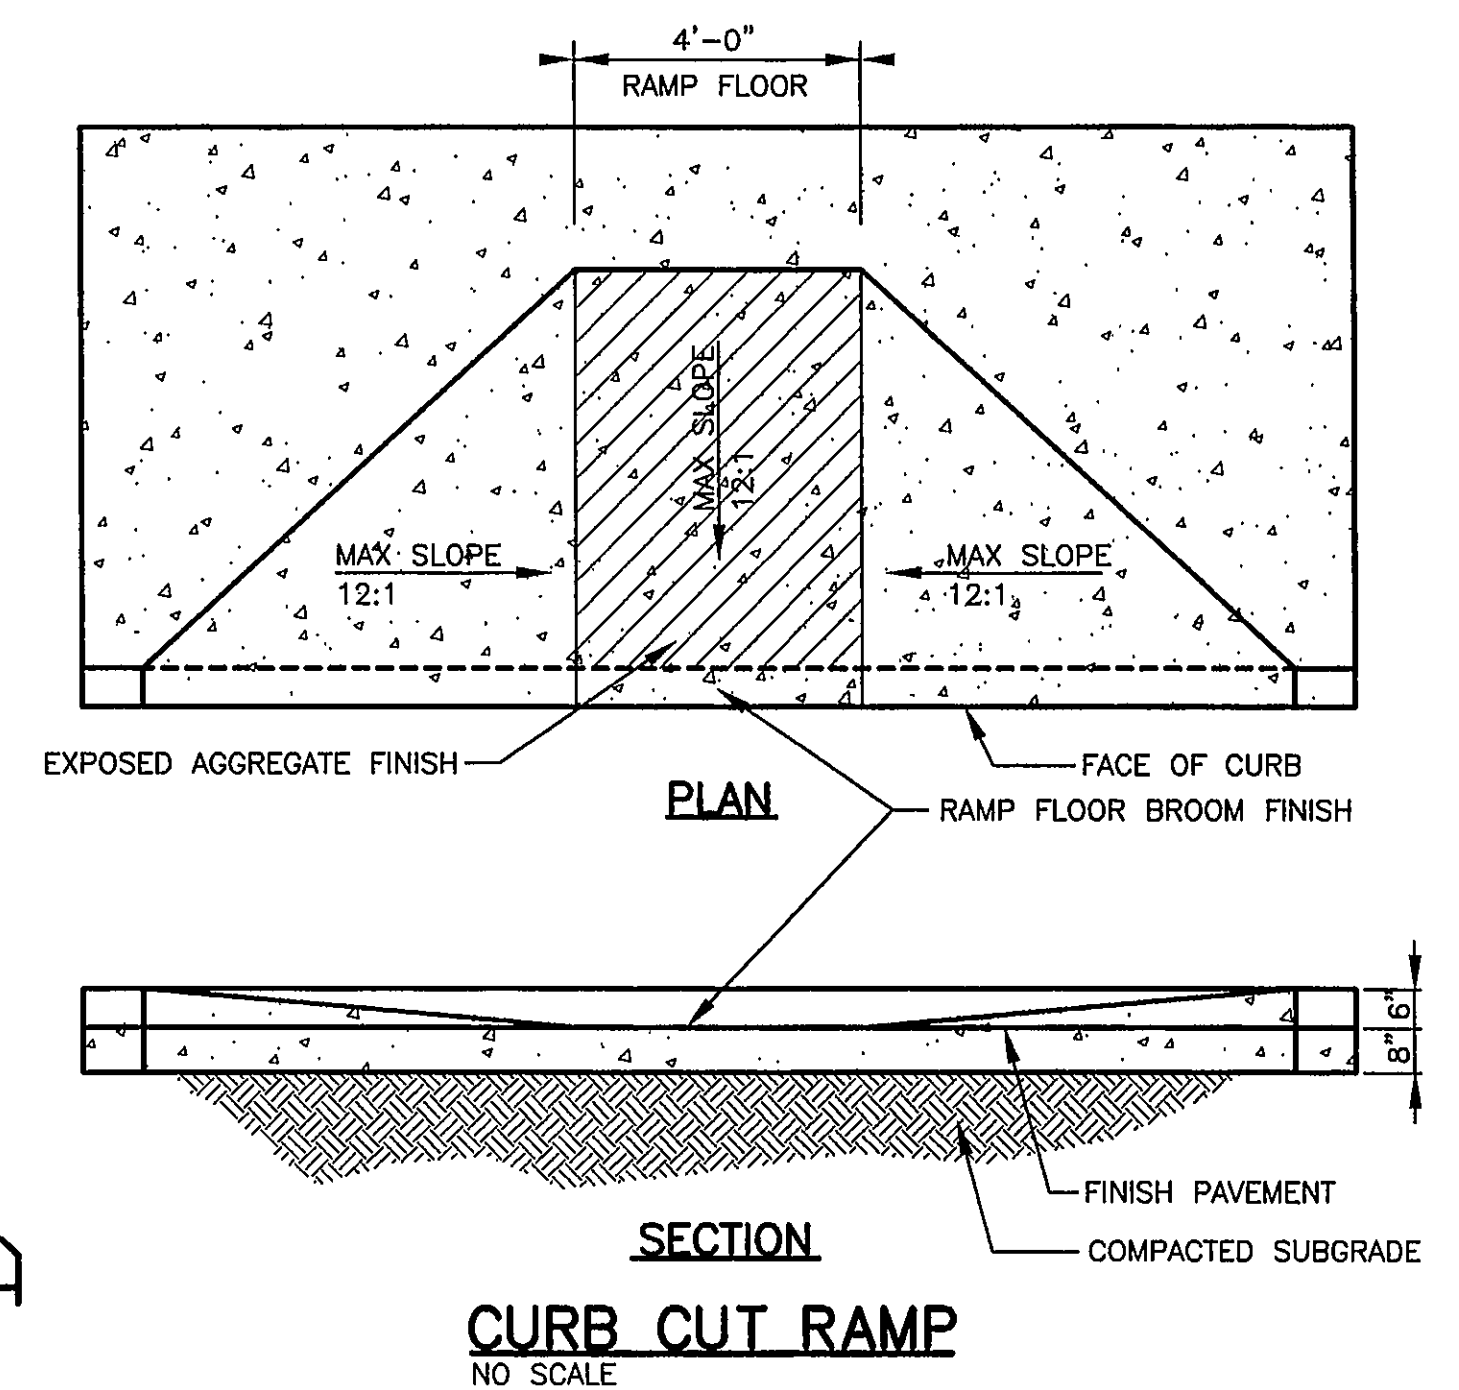

SEE SHEET C8 FOR GENERAL NOTES AND LEGEND.

SEE ARCHITECTURAL SHEET FOR ADDITIONAL LAYOUT INFORMATION.

SEE STRUCTURAL SHEETS FOR SIDEWALK ELEVATIONS.

SEE SANITARY SEWER PROFILE FOR SANITARY SEWER INVERT ELEVATIONS.

SEE SHEET A5 FOR SECTION SHOWING GROUND CONDUIT (GND CND) AND POWER CONDUIT (PWR CND).

TELEPHONE CABLE SLEEVE TO BE PROVIDED BY BELL ATLANTIC.

REVISION	DATE		DESCRIPTION	BY	APP
DESIGNED	CJL	CITY OF ROANOKE RAILSIDE LINEAR WALK PHASE IV			
DRAWN	CJL				
CHECKED		CIVIL SITE PLAN			
APPROVED					
SUBMITTED					
HAYES, SEAY, MATTERN & MATTERN, INC. ARCHITECTS — ENGINEERS — PLANNERS ROANOKE, VIRGINIA			SCALE 1"=10'	COMM. NO. 7288	C5
			DATE SEPT. 17 1999	SHEET	

GRAPHIC SCALE

