
 


MATCHLINE B

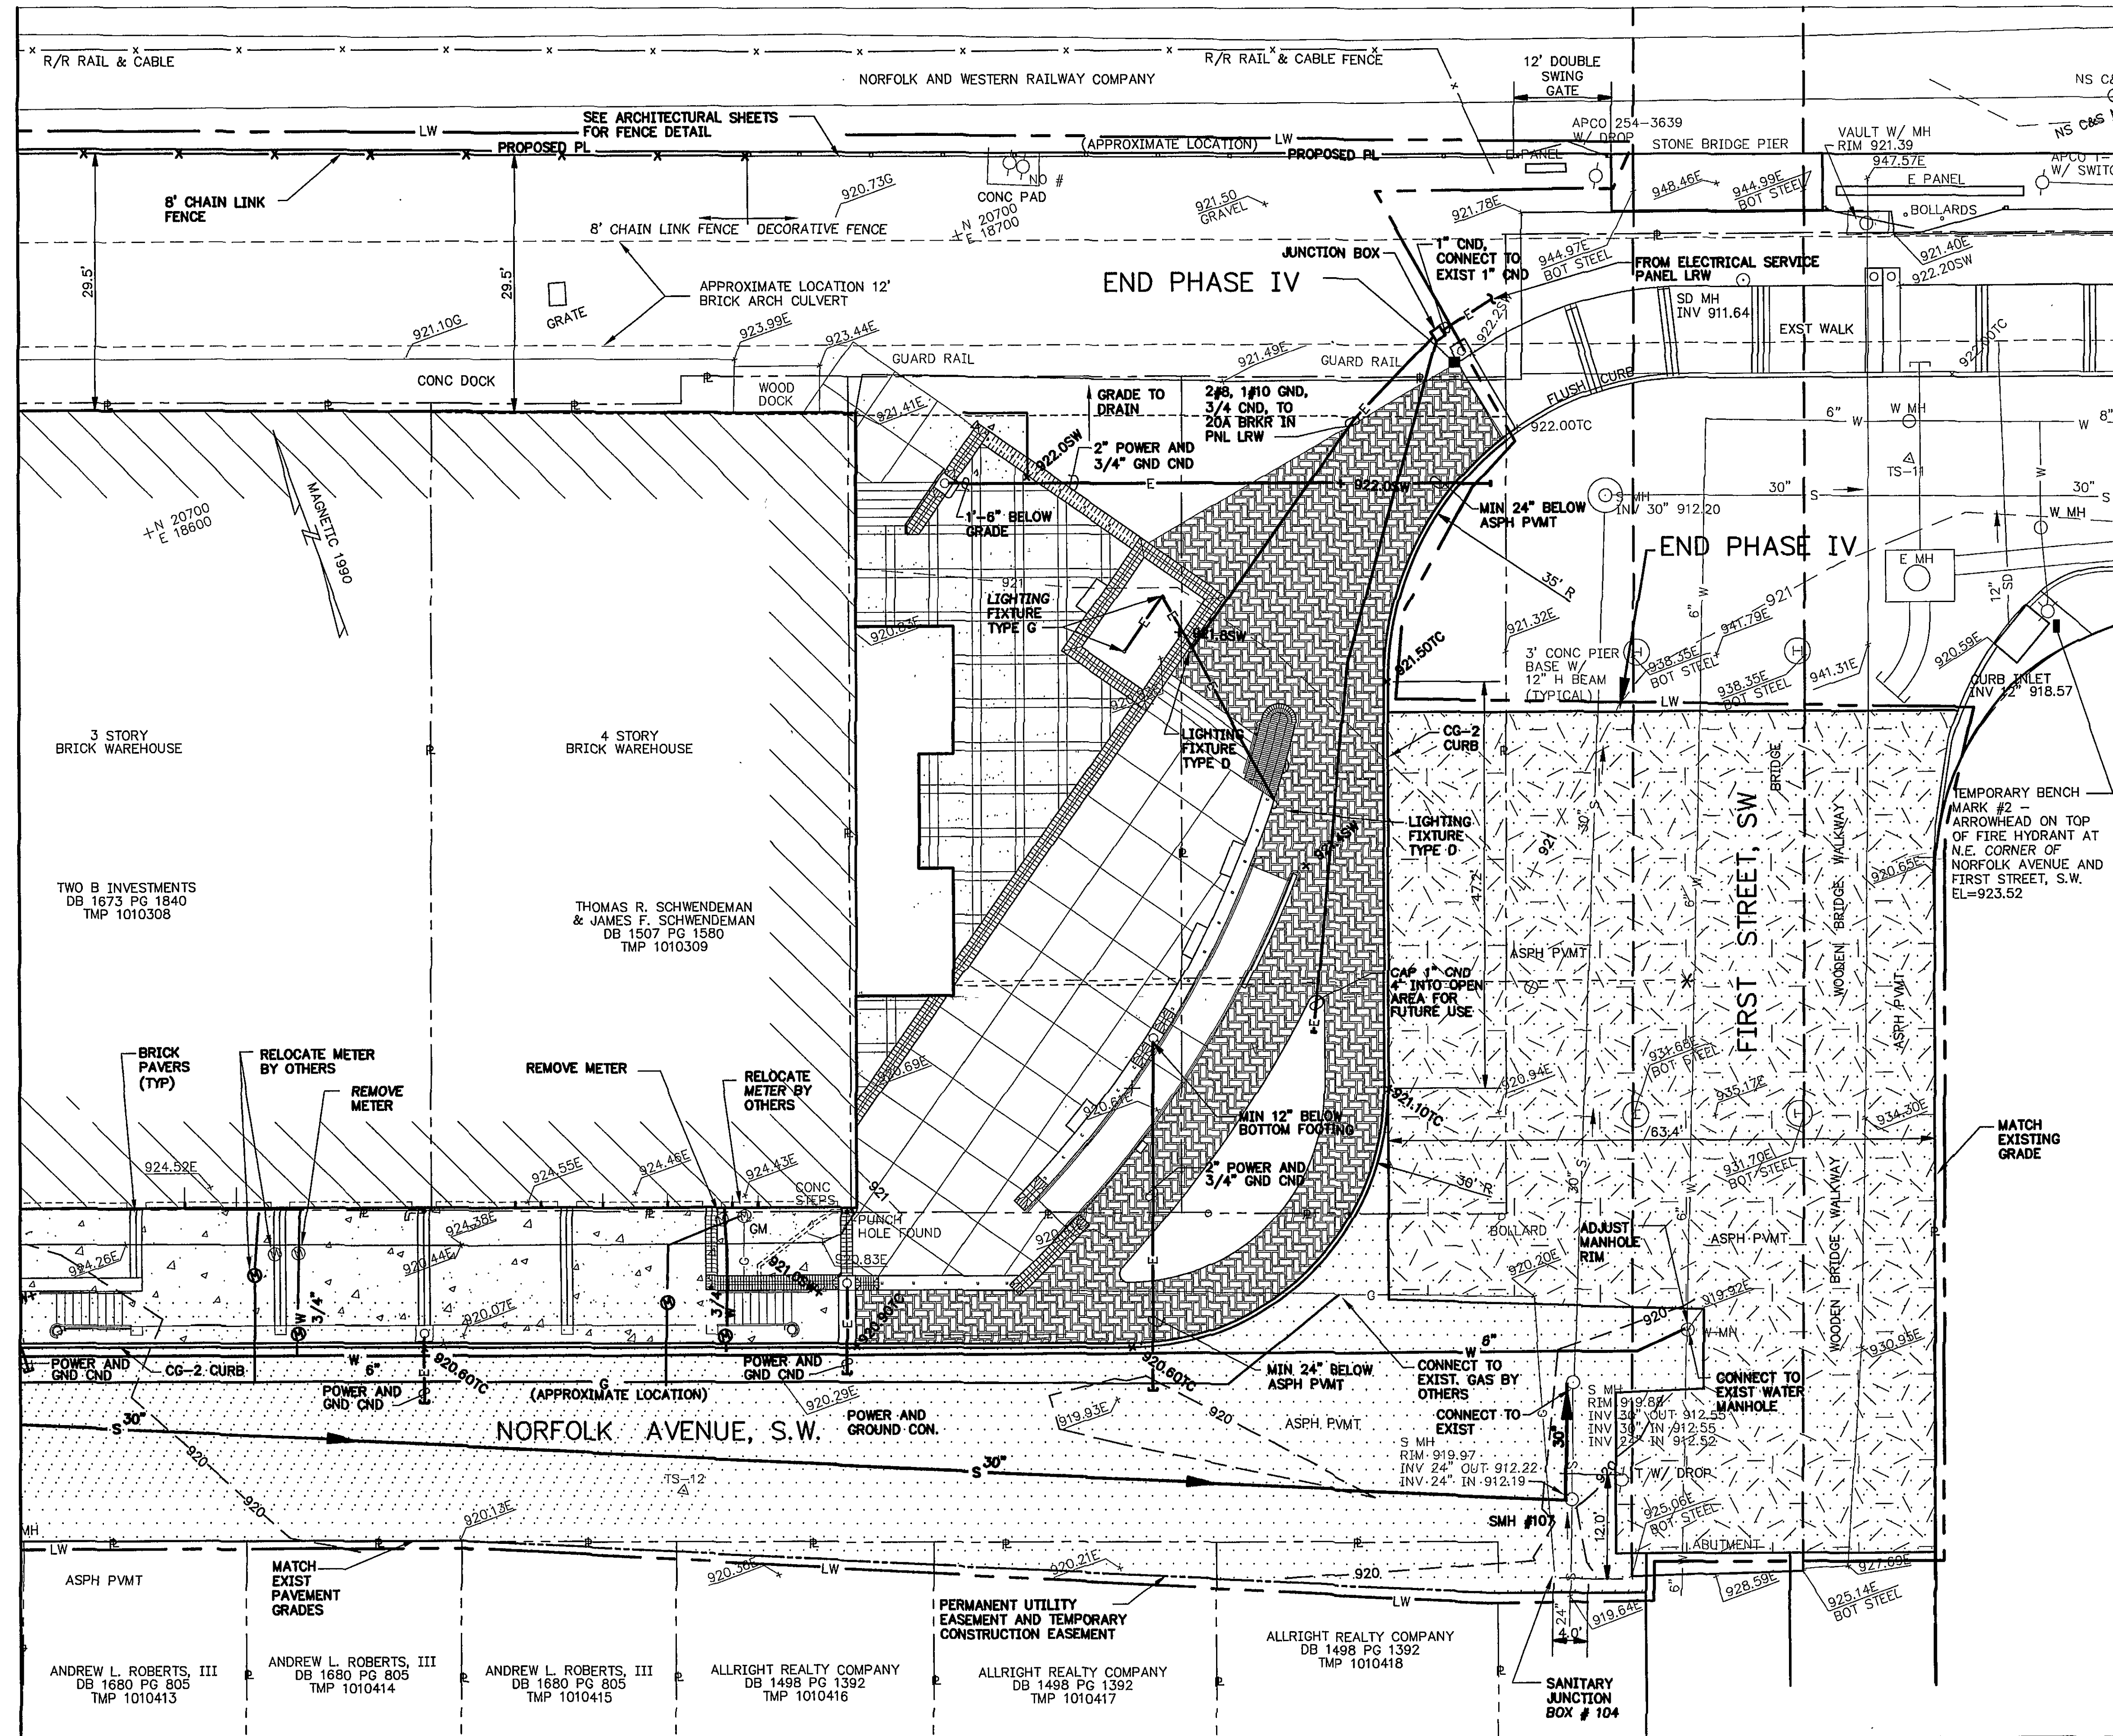

SEE SHEET C8 FOR GENERAL NOTES AND LEGEND.  
SEE ARCHITECTURAL SHEETS FOR ADDITIONAL LAYOUT INFORMATION.  
SEE STRUCTURAL SHEETS FOR SIDEWALK ELEVATIONS.  
SEE SANITARY SEWER PROFILE FOR SANITARY SEWER INVERT ELEVATIONS.  
SEE SHEET A5 FOR SECTION SHOWING GROUND CONDUIT (GND CND) AND POWER CONDUIT (PWR CND).

GRAPHIC SCALE



|                                      |      |                                                     |                   |     |
|--------------------------------------|------|-----------------------------------------------------|-------------------|-----|
| REVISION                             | DATE | DESCRIPTION                                         | BY                | APP |
| DESIGNED                             | CJL  | CITY OF ROANOKE<br>RAILSIDE LINEAR WALK<br>PHASE IV |                   |     |
| DRAWN                                | CJL  |                                                     |                   |     |
| CHECKED                              |      |                                                     |                   |     |
| APPROVED                             |      | CIVIL<br>SITE PLAN                                  |                   |     |
| SUBMITTED                            |      |                                                     |                   |     |
| HAYES, SEAY, MATTERN & MATTERN, INC. |      | SCALE<br>1"=10'                                     | COMM.<br>NO. 7288 |     |
| ARCHITECTS - ENGINEERS - PLANNERS    |      | DATE<br>SEPT. 17 1999                               | SHEET<br>C6       |     |
| ROANOKE, VIRGINIA                    |      |                                                     |                   |     |