


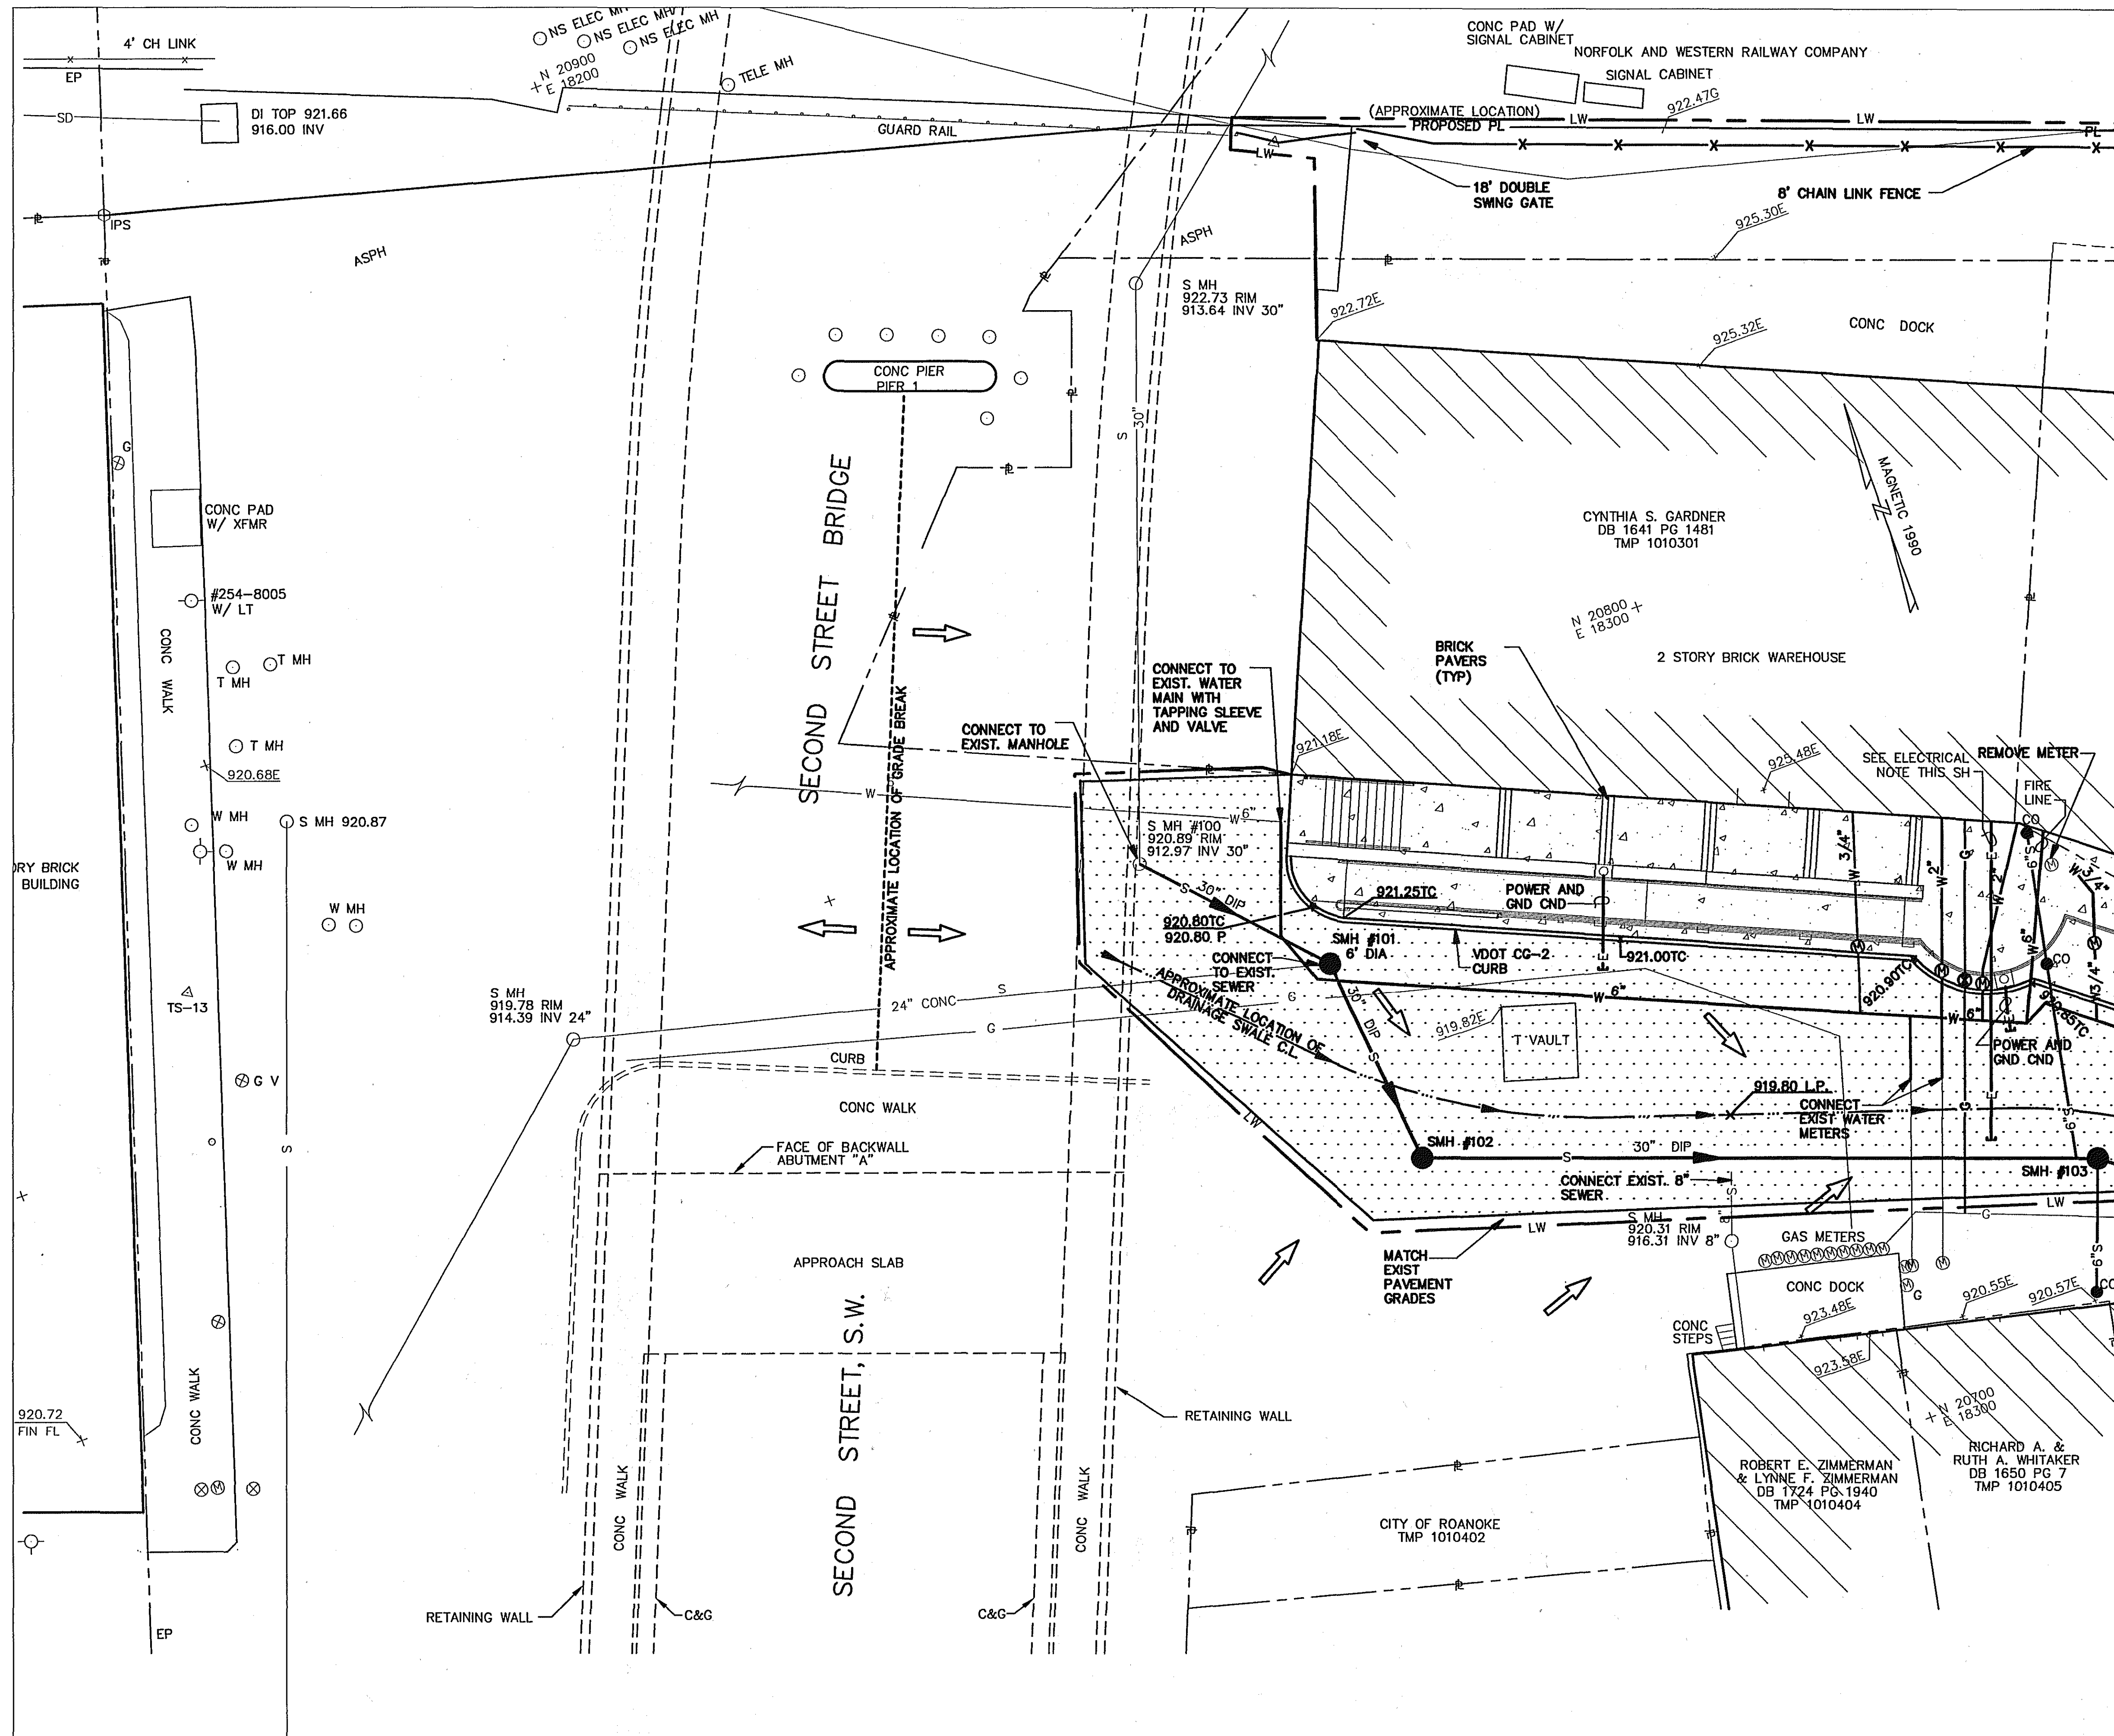

ELECTRICAL NOTE:

AEP ELECTRICAL CONDUITS LOCATIONS ENTERING WAREHOUSE CAN BE DETERMINED BY OBSERVATION IN BASEMENT AREA.

SEE STRUCTURAL SHEETS FOR ADDITIONAL SIDEWALK ELEVATIONS.

SEE ARCHITECTURAL SHEETS FOR ADDITIONAL DIMENSIONS.

 
SEE SHEET C1 FOR GENERAL NOTES AND SHEET C3 FOR LEGEND.

SEE SHEET A5 FOR SECTION SHOWING GROUNDING CONDUIT (GND CND) AND POWER CONDUIT (PWR CND).

SEE SANITARY SEWER MANHOLE PROFILE FOR SANITARY SEWER INVERT ELEVATIONS.

CONTRACTOR SHALL MATCH EXST. DRAINAGE PATTERNS USING DRAINAGE SWALE IN PWT. (APPROX. LOCATION SHOWN).

GRAPHIC SCALE



DESIGNED	CJL	CITY OF ROANOKE RAILSIDE LINEAR WALK PHASE V		NOV 2003	AS-BUILTS	TSP
DRAWN	CJL			REVISION	DATE	DESCRIPTION
CHECKED	MDJ			BY	APP	
APPROVED	MDJ					
SUBMITTED	MB					
HAYES, SEAY, MATTERN & MATTERN, INC.			CIVIL SITE PLAN	SCALE 1"=10'	COMM. NO. 7288	
ARCHITECTS - ENGINEERS - PLANNERS				DATE AUG. 3, 2001	SHEET	C4
ROANOKE, VIRGINIA						