


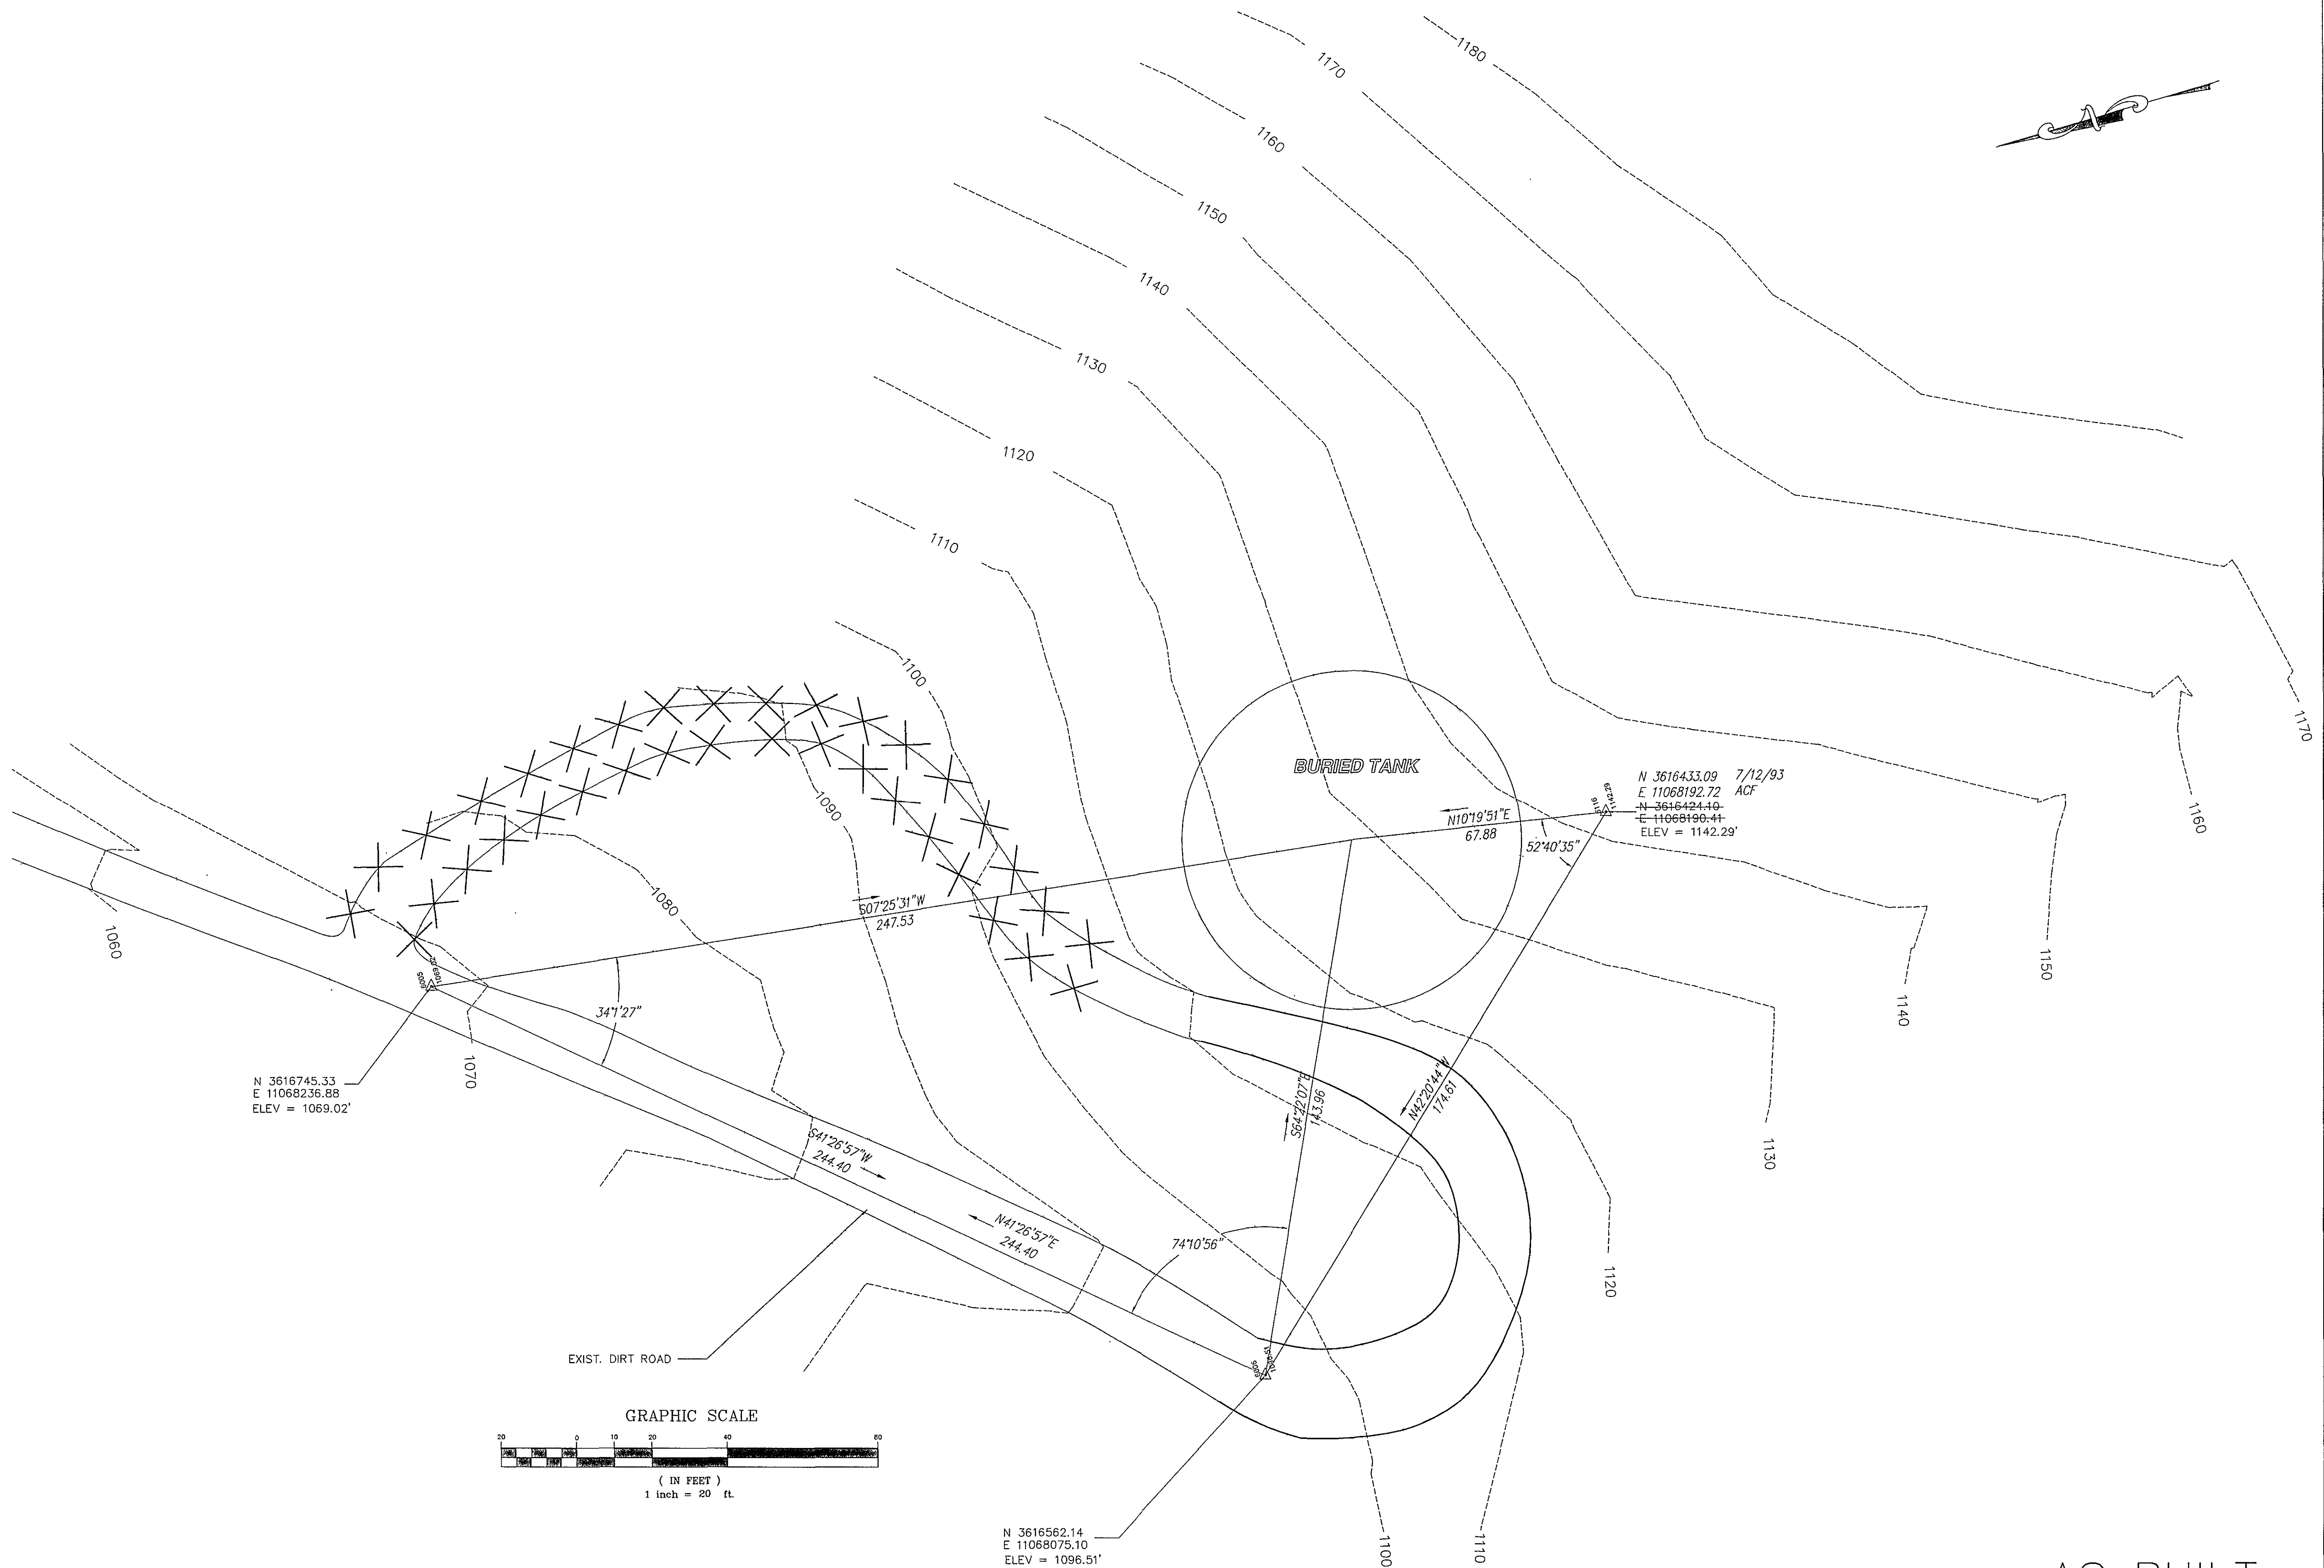

AS BUILT

WATER DEP'T. #93-25

Dewberry & Davis
Architects
Engineers
Planners
Surveyors
5238 Valleypointe Parkway, Suite One-B
Roanoke, Virginia 24019
☎ 703 962-7725

Carvins Cove, Phase II
City of Roanoke
Roanoke, Virginia

CONTRACT "C2"
MILL MOUNTAIN
GROUND STORAGE TANK
SITE PLAN

Drawn By	ACF
Designed By	RBS
Checked By	SEH
Date	MARCH 93
Scale	1" = 20'
Plan Number	TESTMMTS
Zoned	NONE
Sheet	19 of 25
File Number	C1160