


UDC:SPBPB\ICTS\000\6064470\1920-CAD\GSS\910-CAI\02 LITE EDN PKG\02 HSTC-40MD DWG ---- 03/04/2018 12:21:21 EREFH AND ANOV

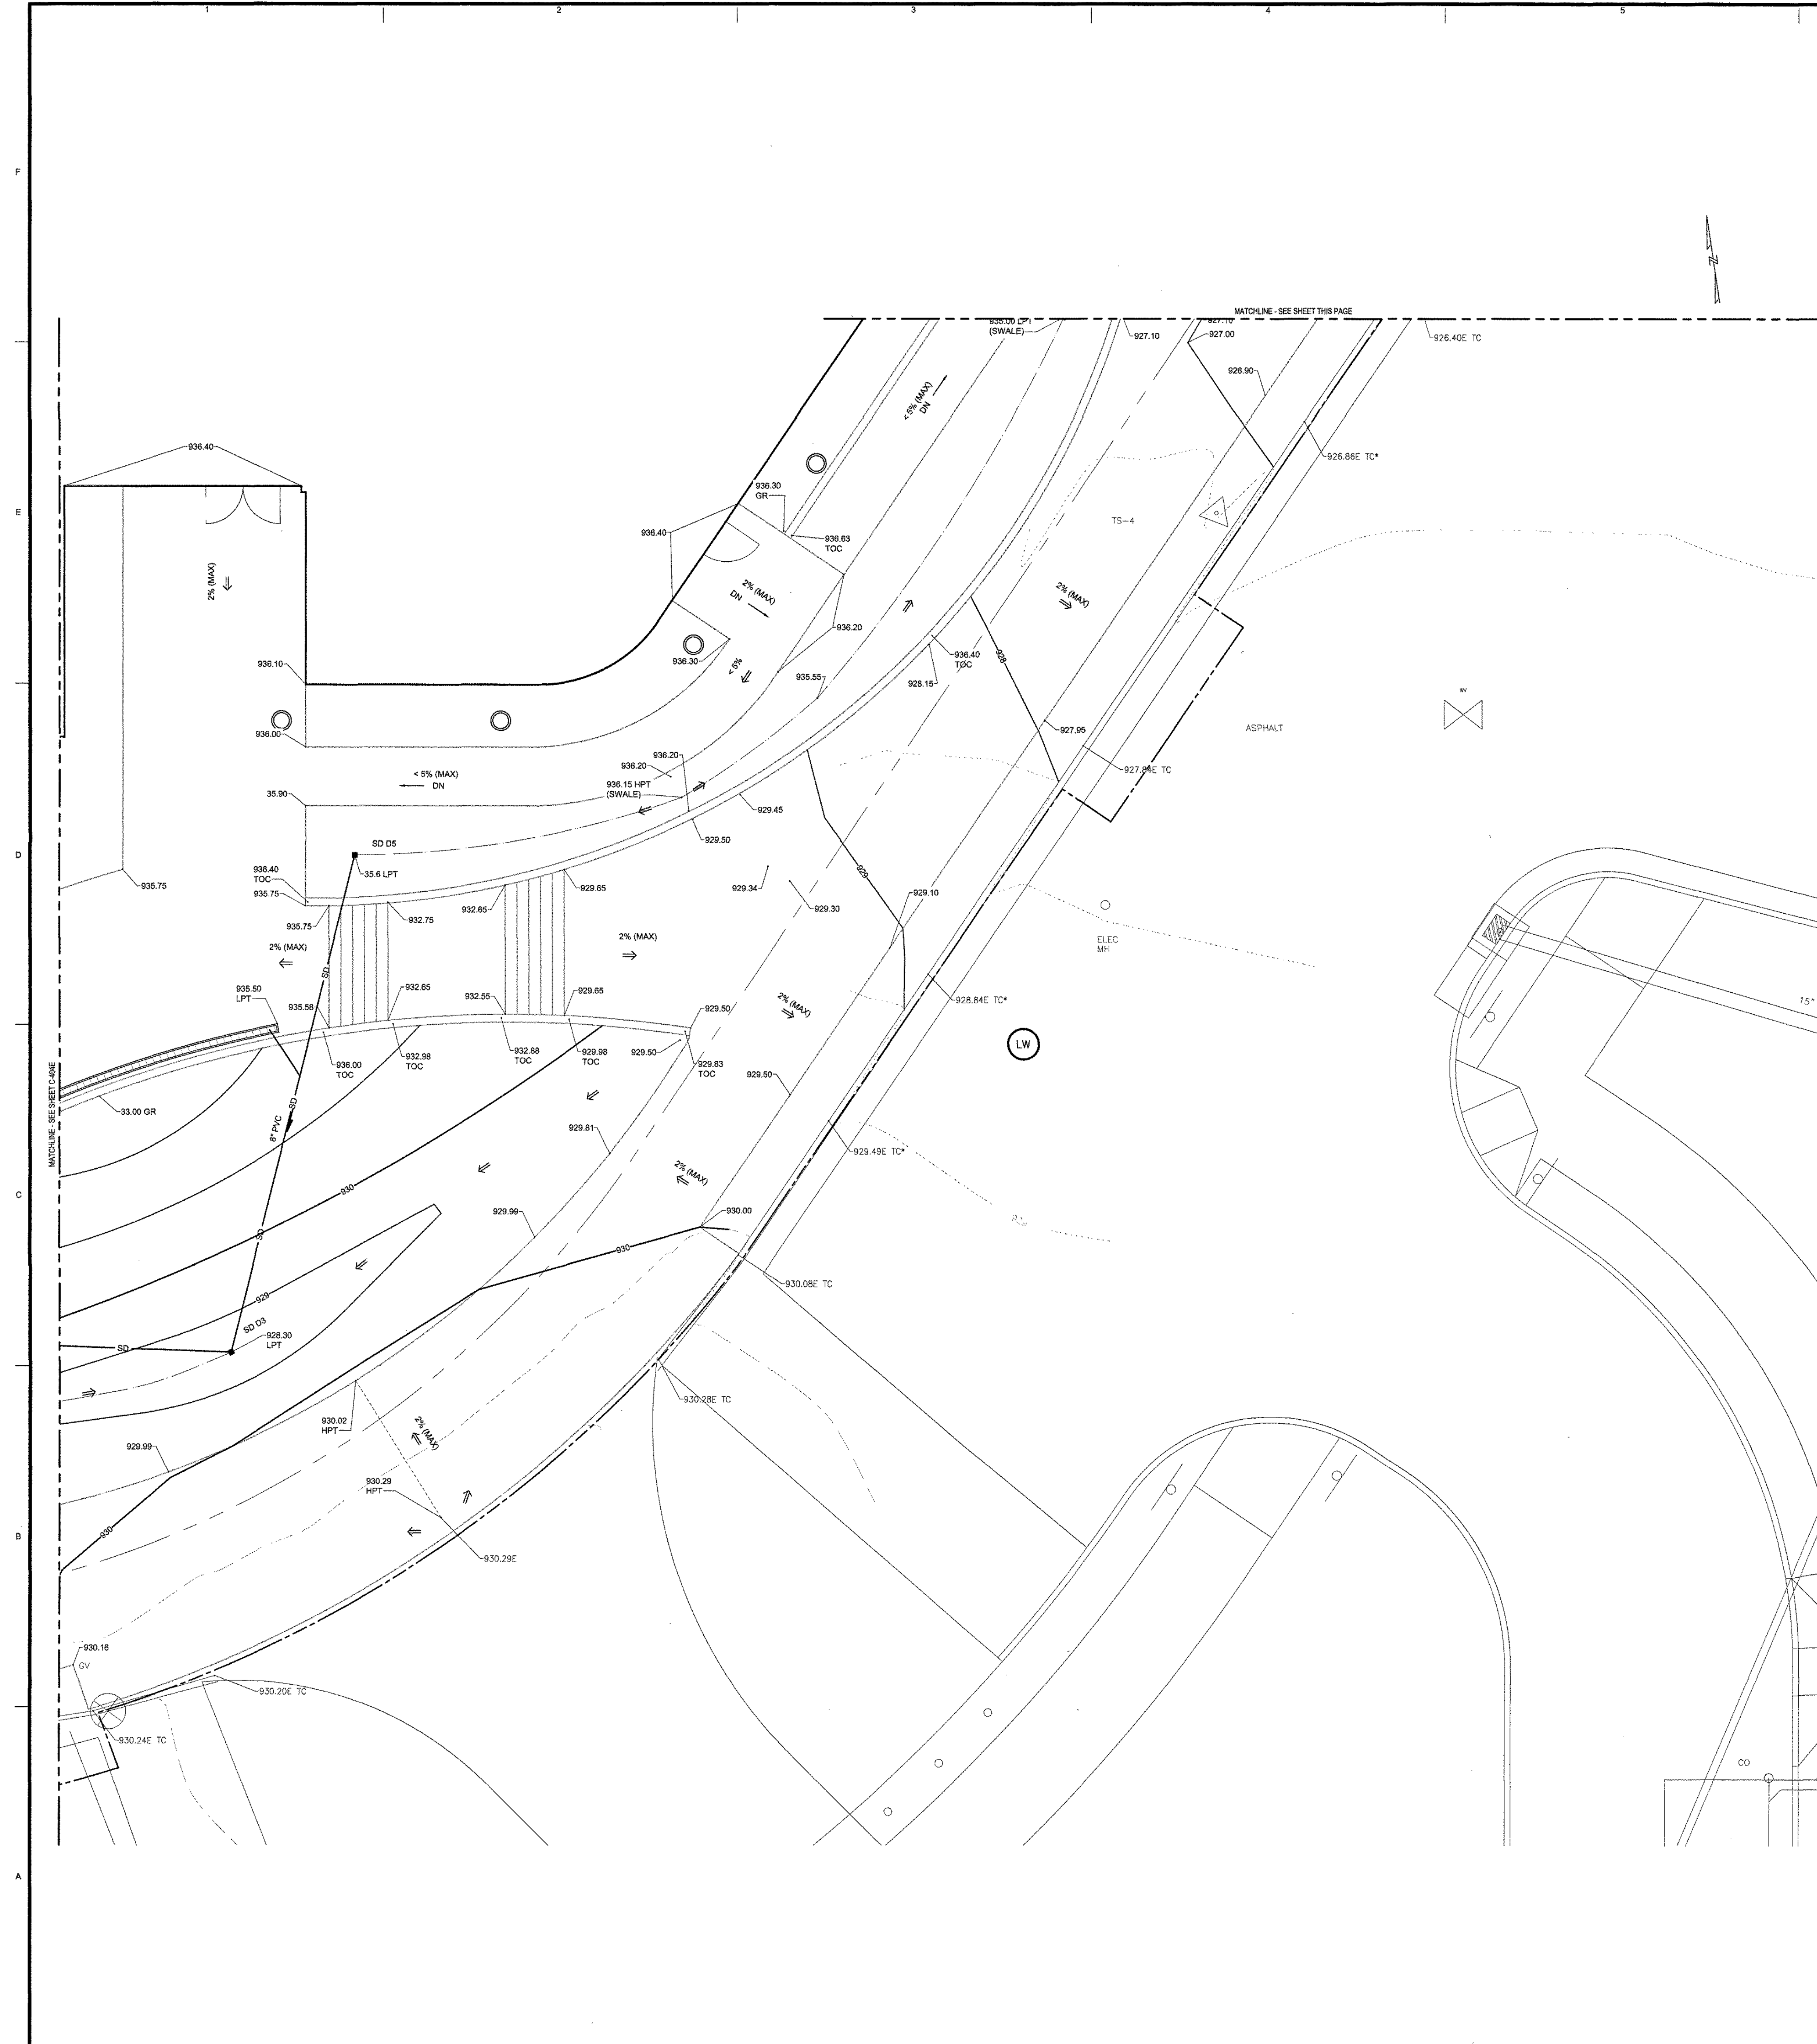

GENERAL NOTES THIS SHEET:

- A. SEE SHEET C-001 FOR CIVIL NOTES, ABBREVIATIONS, AND LEGEND.
- B. SEE COORDINATE POINT DIAGRAMS ON SHEET C-001 FOR BENCHMARK ELEVATION INFORMATION.
- C. PROJECT SITE LIES IN H U D FLOOD HAZARD ZONE AE COMMUNITY PANEL NO. 5116T0164G, DATED SEPTEMBER 28, 2007. THE 100-YEAR FLOODPLAIN ELEVATION AT THE PROJECT SITE IS 934.44 FEET.
- D. THE BUILDING FINISH FLOOR ELEVATION AND THE ELEVATION OF GENERATOR AND TRANSFORMER PAD IS SET AT LEAST TWO FEET ABOVE THE 100-YEAR FLOOD PLAIN ELEVATION.

 SHEET KEYNOTES:

1. BUILDING OUTLINE FOR REFERENCE ONLY. SEE ARCHITECTURAL SHEETS.

PROJECT

**VIRGINIA TECH CARILION (VTC)
BIOMEDICAL RESEARCH
EXPANSION**

VIRGINIA TECH
4 RIVERSIDE CIRCLE
ROANOKE, VA 24016

CLIENT



CARILION CLINIC

213 MCCLANAHAN ST., S.

THIRD FLOOR
ROANOKE, VA 24014

PHONE: 540-881-7024

 VIRGINIA
TECH

CONSULTANT

AECOM

10 South Jefferson Street, Suite 1600
Boulder, Colorado 80501

 
 
Roanoke, Virginia 24011
540.857.3100 tel 540.857.3180 fax

www.aecom.com


— 175 — 184 — 193 — 202



3015

HILL
STUDIO


REGISTRATION

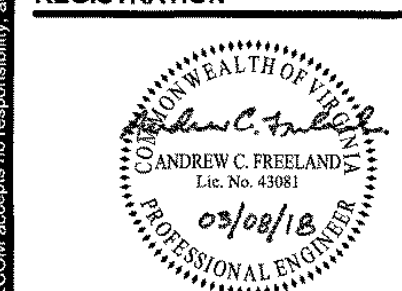

ISSUE/REVISION

3	03/08/2018	CITY CP SUBMISSION
2	01/19/2018	CITY CP SUBMISSION
1	12/04/2017	FOR PRESUBMISSION MEETING
0	12/01/2017	FOUNDATION SUBMISSION
I/R	DATE	DESCRIPTION

KEY PLAN

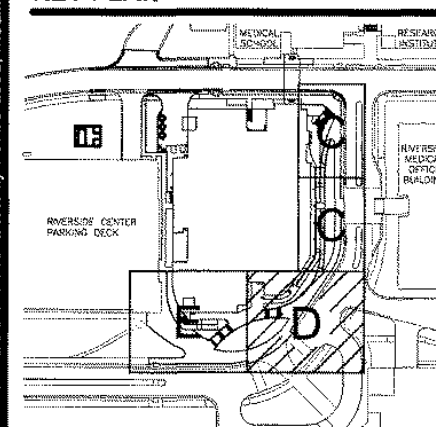

PROJECT NUMBER

60544903

SHEET TITLE

SHEET TITLE
ENLARGED

ENLARGED
GRADING PLAN
(AREA D)

(AREA D)

SHEET NUMBER

C-404D