



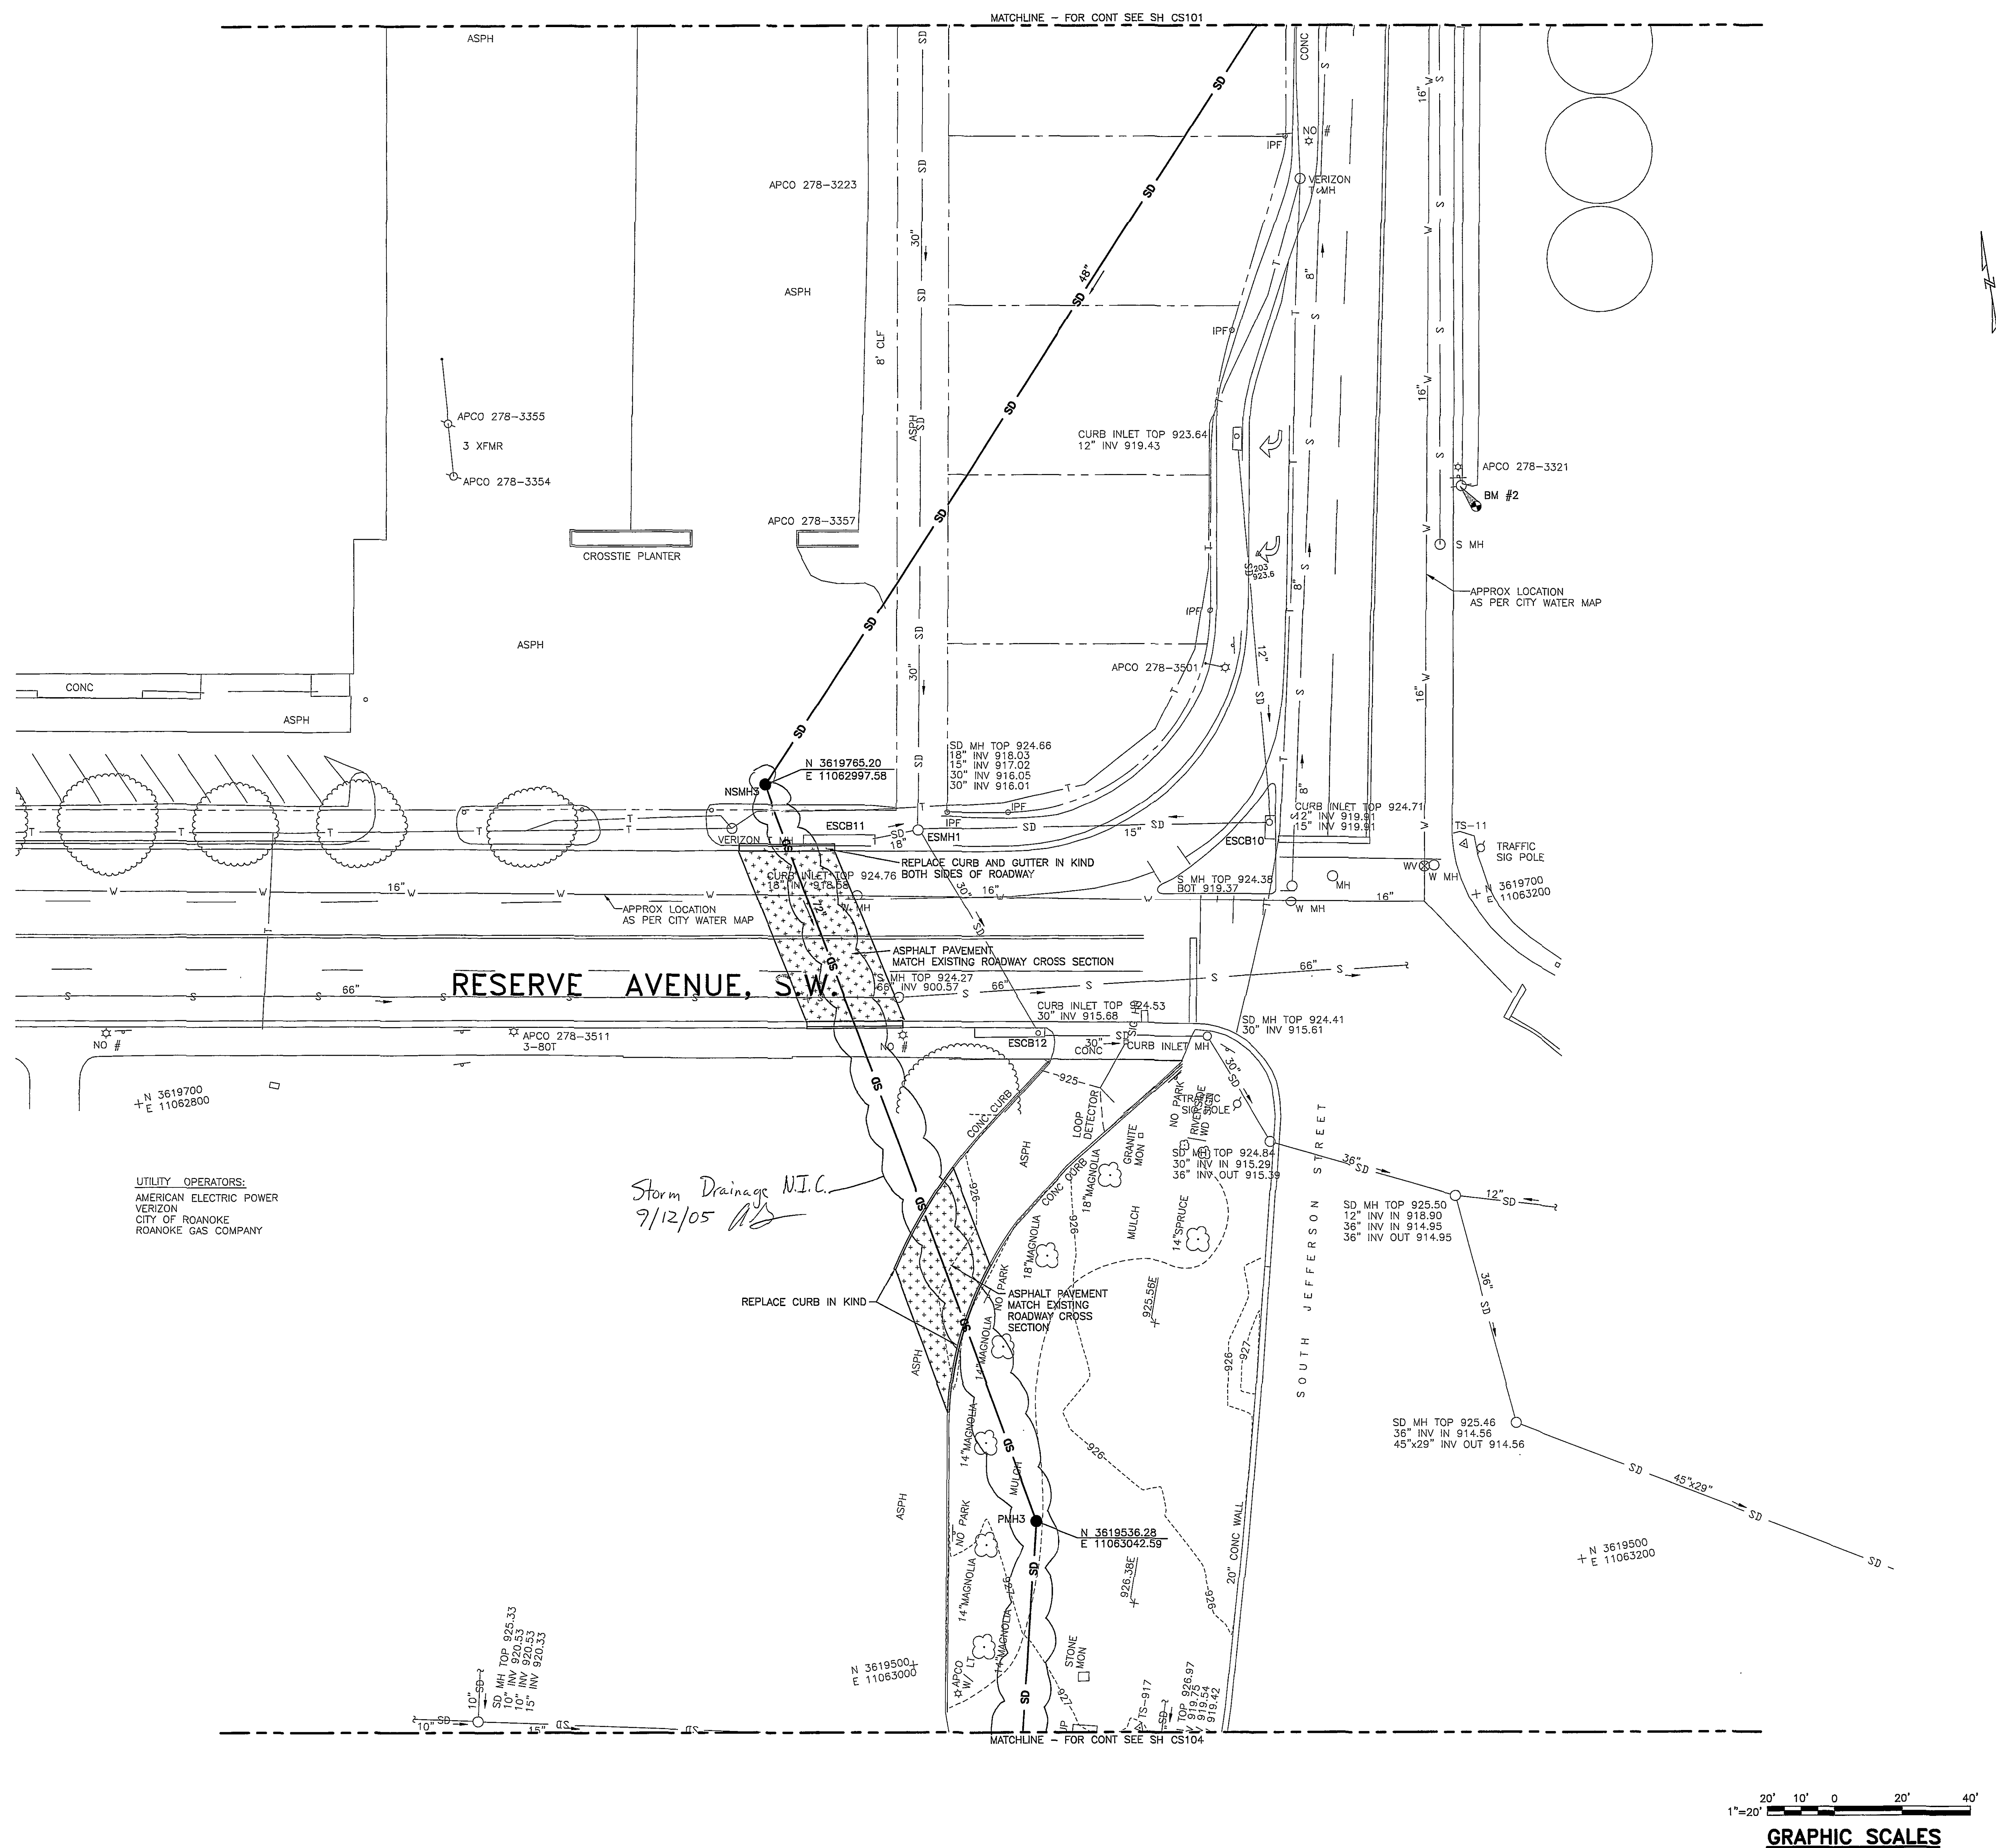

HSM
ARCHITECTS ENGINEERS PLANNERS

HAYES, SEAY, MATTERN & MATTERN, INC.
1315 FRANKLIN ROAD
ROANOKE, VA 24016
(540) 857-3100 WWW.HSM.COM

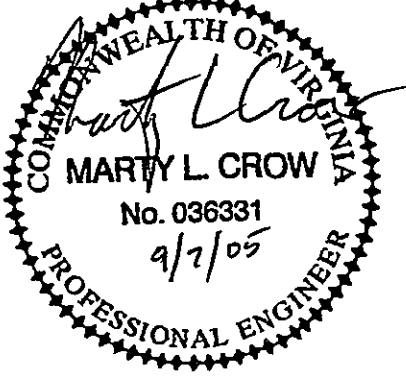

CONSULTANT

CONSULTANT

CARILION
Health System

**RIVERSIDE
CORPORATE CENTRE
OFFICE BUILDING**

CARILION HEALTH SYSTEM

ROANOKE, VIRGINIA

REV	DATE	DESCRIPTION	APP

COMM NO: 40049
ISSUE DATE: SEPTEMBER 2, 2005
DESIGNED BY: ARG DRAWN BY: ARG
CHECKED BY: MLC SUBMITTED BY: GLH
© HAYES, SEAY, MATTERN & MATTERN, INC.,
2005. ALL RIGHTS RESERVED.

CIVIL

SITE LAYOUT
AND UTILITY PLAN

CS103