


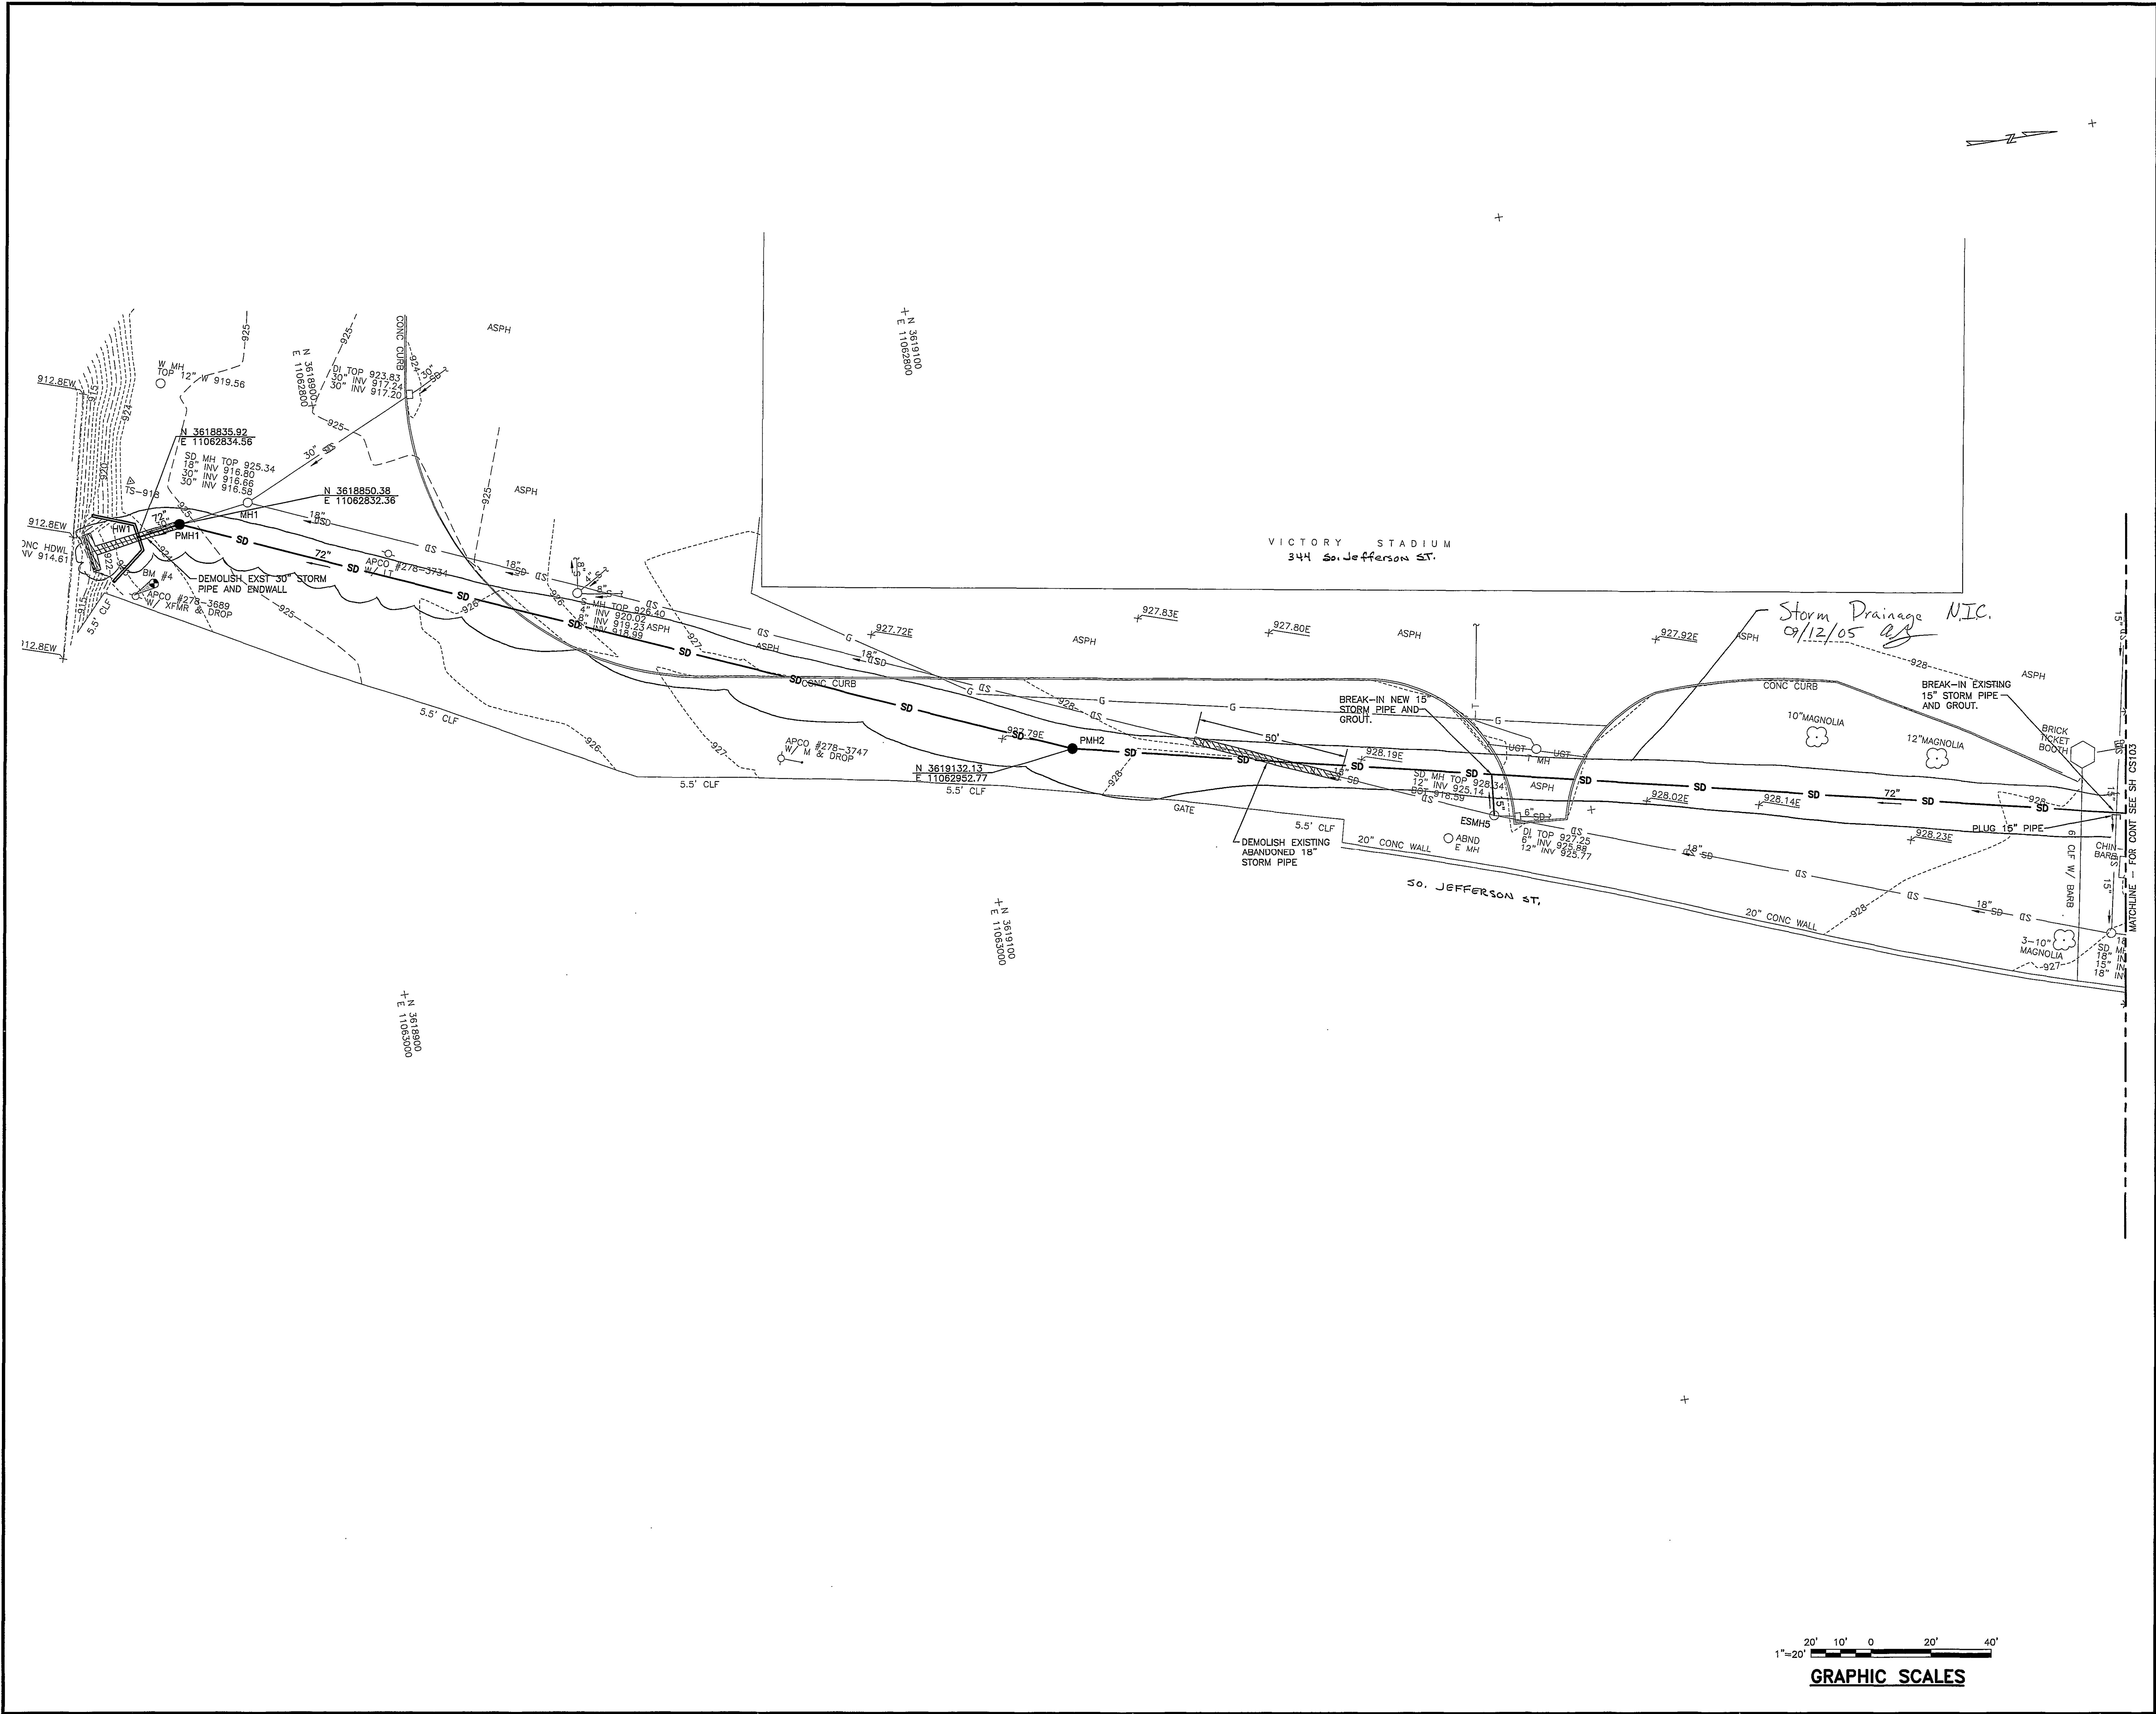

HSMM
ARCHITECTS ENGINEERS PLANNERS

HAYES, SEAY, MATTERN & MATTERN, INC.
1315 FRANKLIN ROAD
ROANOKE, VA 24016
(540) 857-3100 WWW.HSMM.COM



CONSULTANT

CONSULTANT

CARILION
Health System

**RIVERSIDE
CORPORATE CENTRE
OFFICE BUILDING**

CARILION HEALTH SYSTEM

ROANOKE, VIRGINIA


REV	DATE	DESCRIPTION	APP

COMM NO: 40049
ISSUE DATE: SEPTEMBER 2, 2005
DESIGNED BY: ARG DRAWN BY: ARG
CHECKED BY: MLC SUBMITTED BY: GLH
© HAYES, SEAY, MATTERN & MATTERN, INC.,
2005. ALL RIGHTS RESERVED.

CIVIL

SITE LAYOUT
AND UTILITY PLAN

CS104

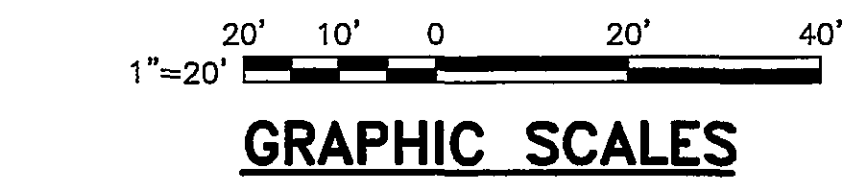

M:\4000SERIES\40049\CADD\DWG\EWDCSN_0104.DWG C:\40049 09/07/2005 08:35:35 ADLBERT
NCS_HSMM_Full.ctb RF: ew0g_nxbrdr,??ew0e_ex??,ew0csexp,ew0cunexp,??ew0e_ex??,ew0c_nwp00