


SEALS

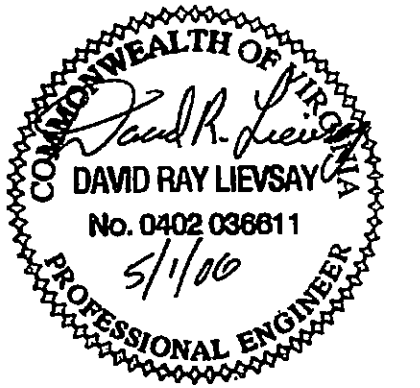

CONSULTANT

CONSULTANT

**RIVERSIDE
CORPORATE CENTRE
OFFICE BUILDING
PHASE II**

CARILION HEALTH SYSTEM

ROANOKE, VIRGINIA

[illegible]

COMM NO: 40049

ISSUE DATE: MAY 1, 2006

DESIGNED BY:	RLL	DRAWN BY:	RLL
--------------	-----	-----------	-----

CHECKED BY: DRL SUBMITTED BY: GLH
© HAYES, SEAY, MATTERN & MATTERN, INC.,
2005. ALL RIGHTS RESERVED.


ELECTRICAL

ELECTRICAL SITE LIGHTING PLAN

REFER TO SHEET ES100

SK-048

SHEET 1 OF 2

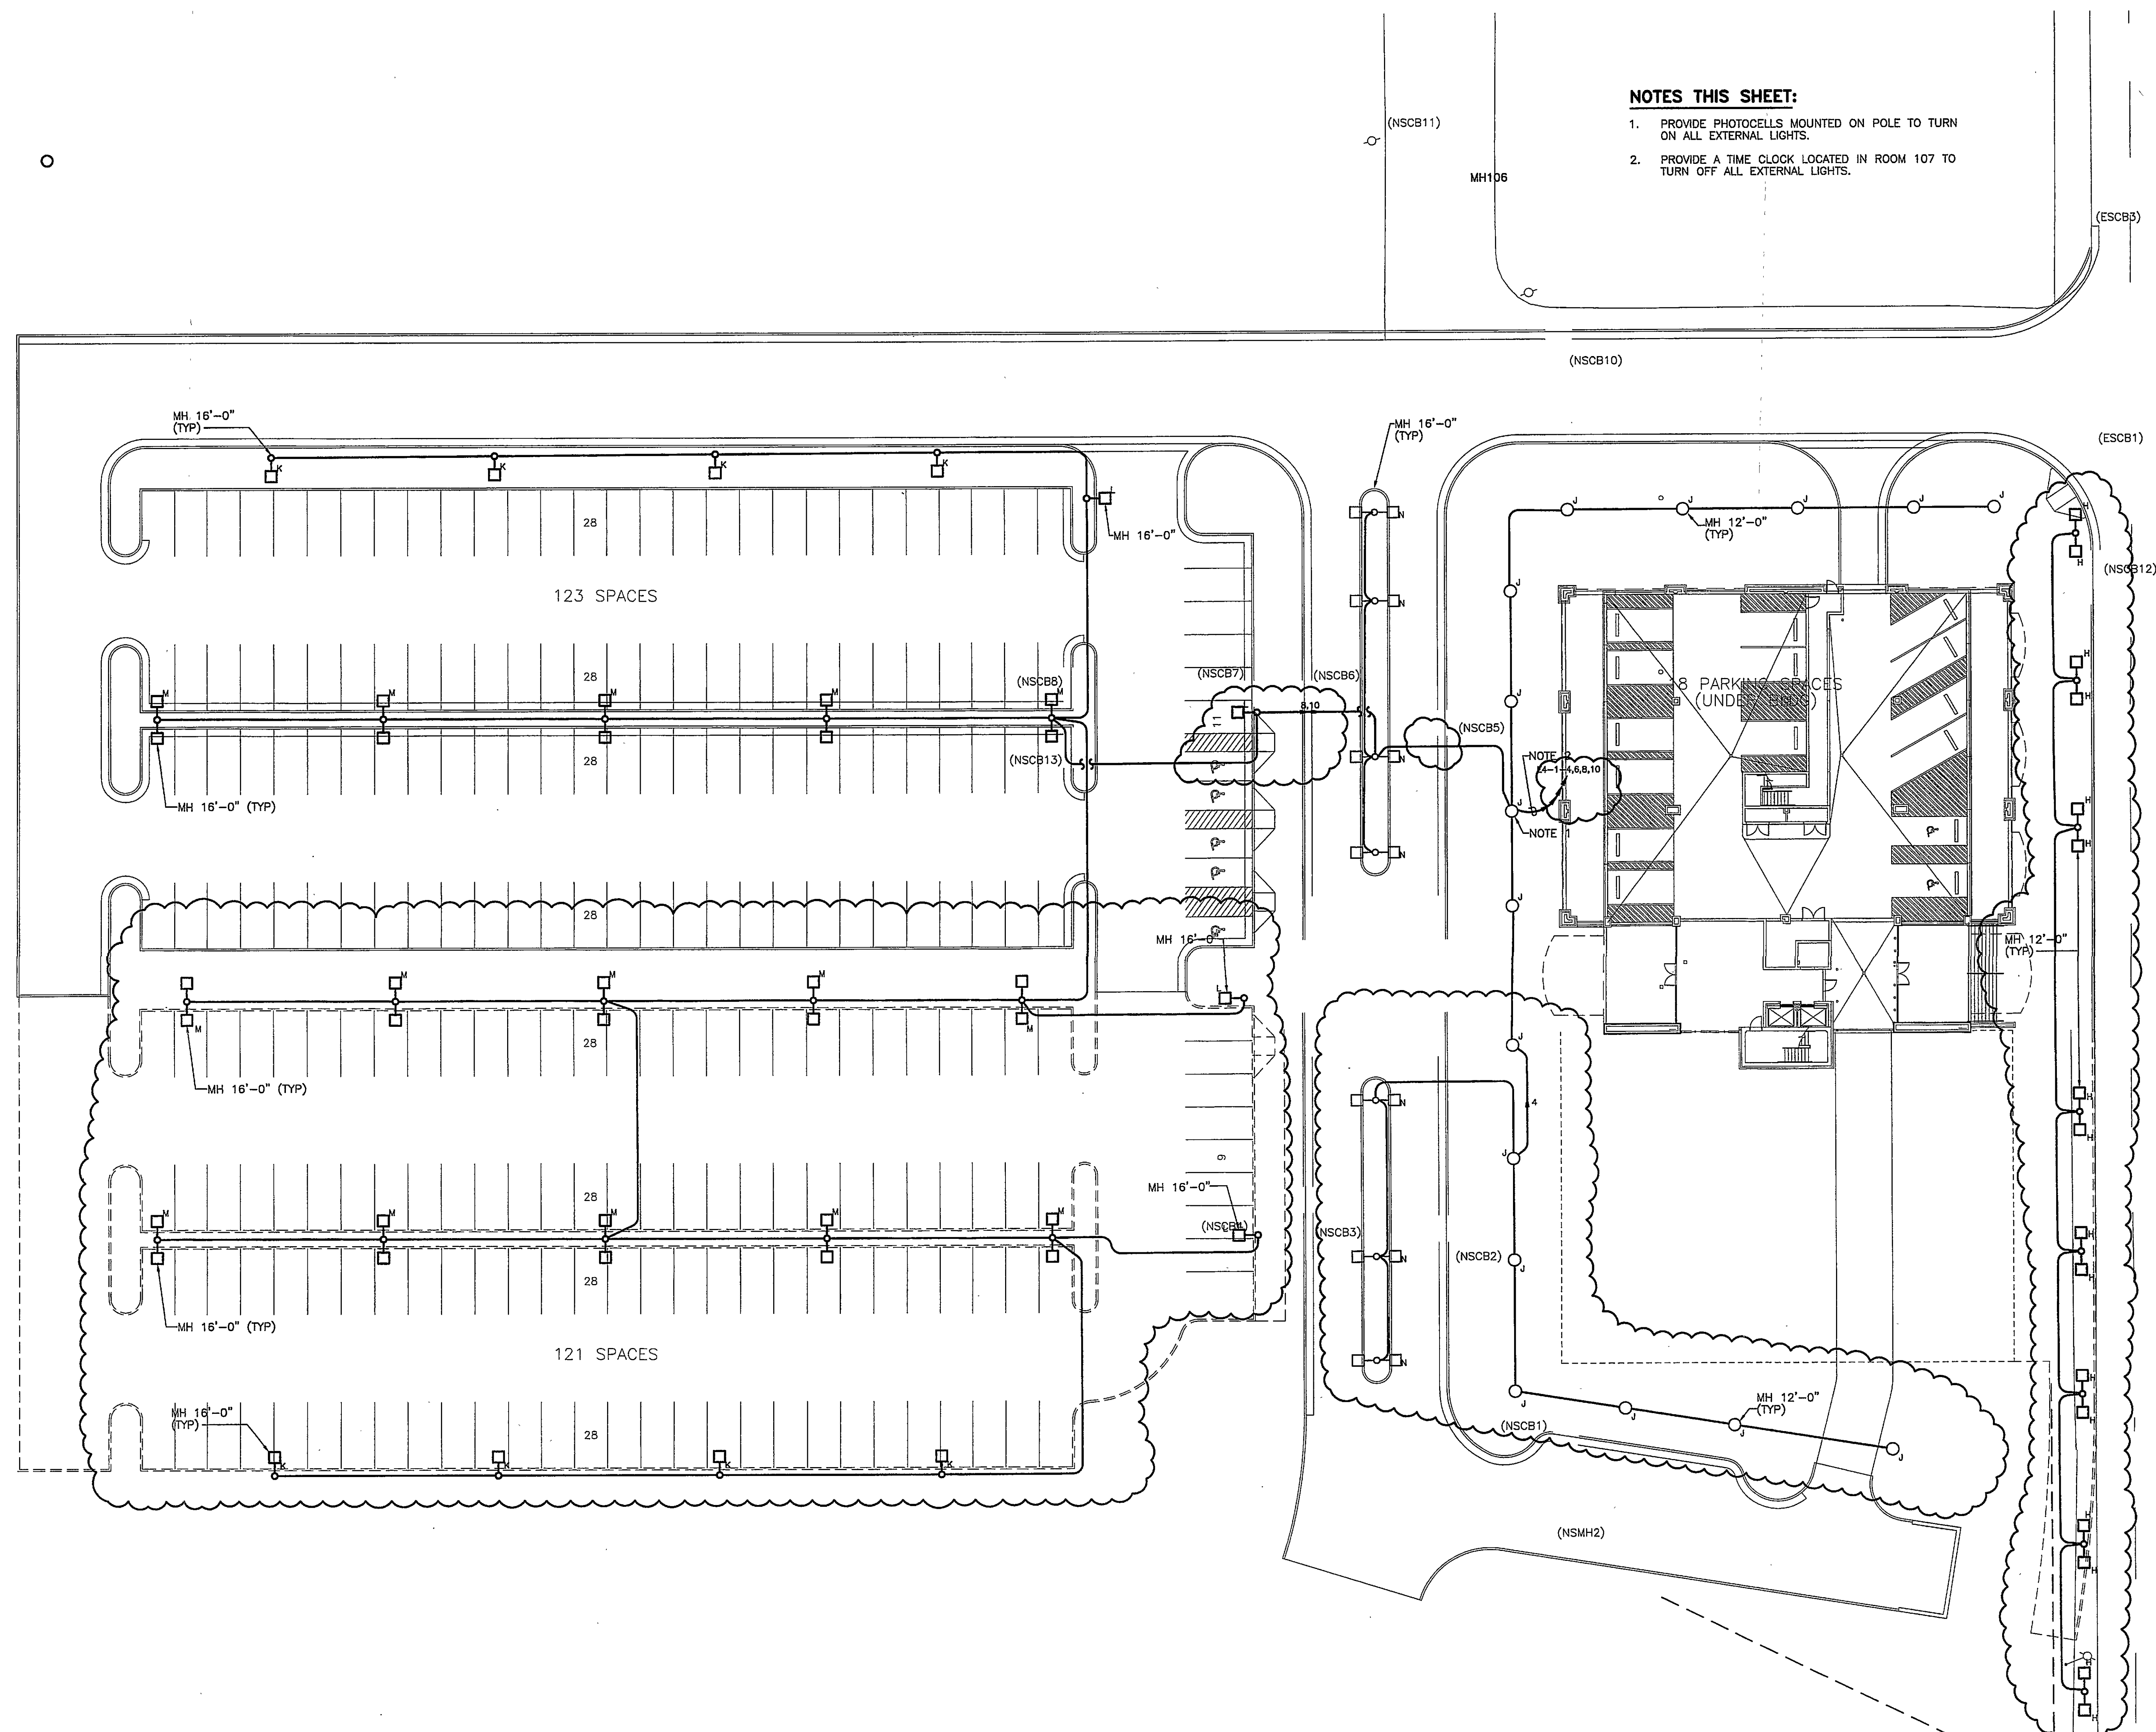

**ELECTRICAL
SITE LIGHTING PLAN**
SCALE: 1"=20'

