


REVISIONS	BY



UTILITY PLAN

NEW FULFILLMENT CENTER
ROANOKE CENTRE FOR
INDUSTRY AND TECHNOLOGY
ROANOKE, VIRGINIA

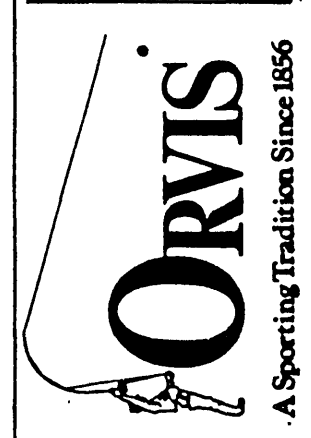


Horner & Associates

DATE	10/24/86
SCALE	1"=30'
DRN	CAT
JOB	86-42
SHEET	C7
OF 10 SHEETS	

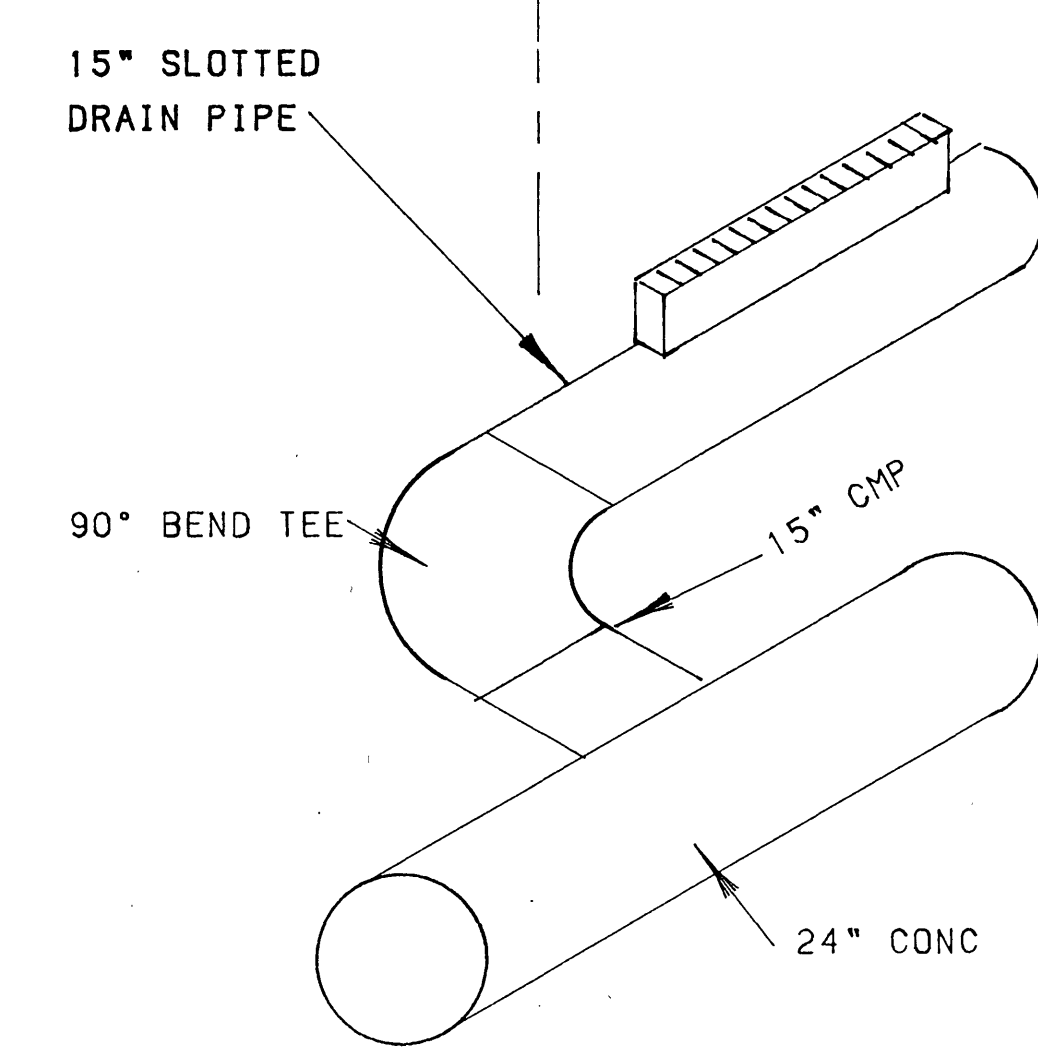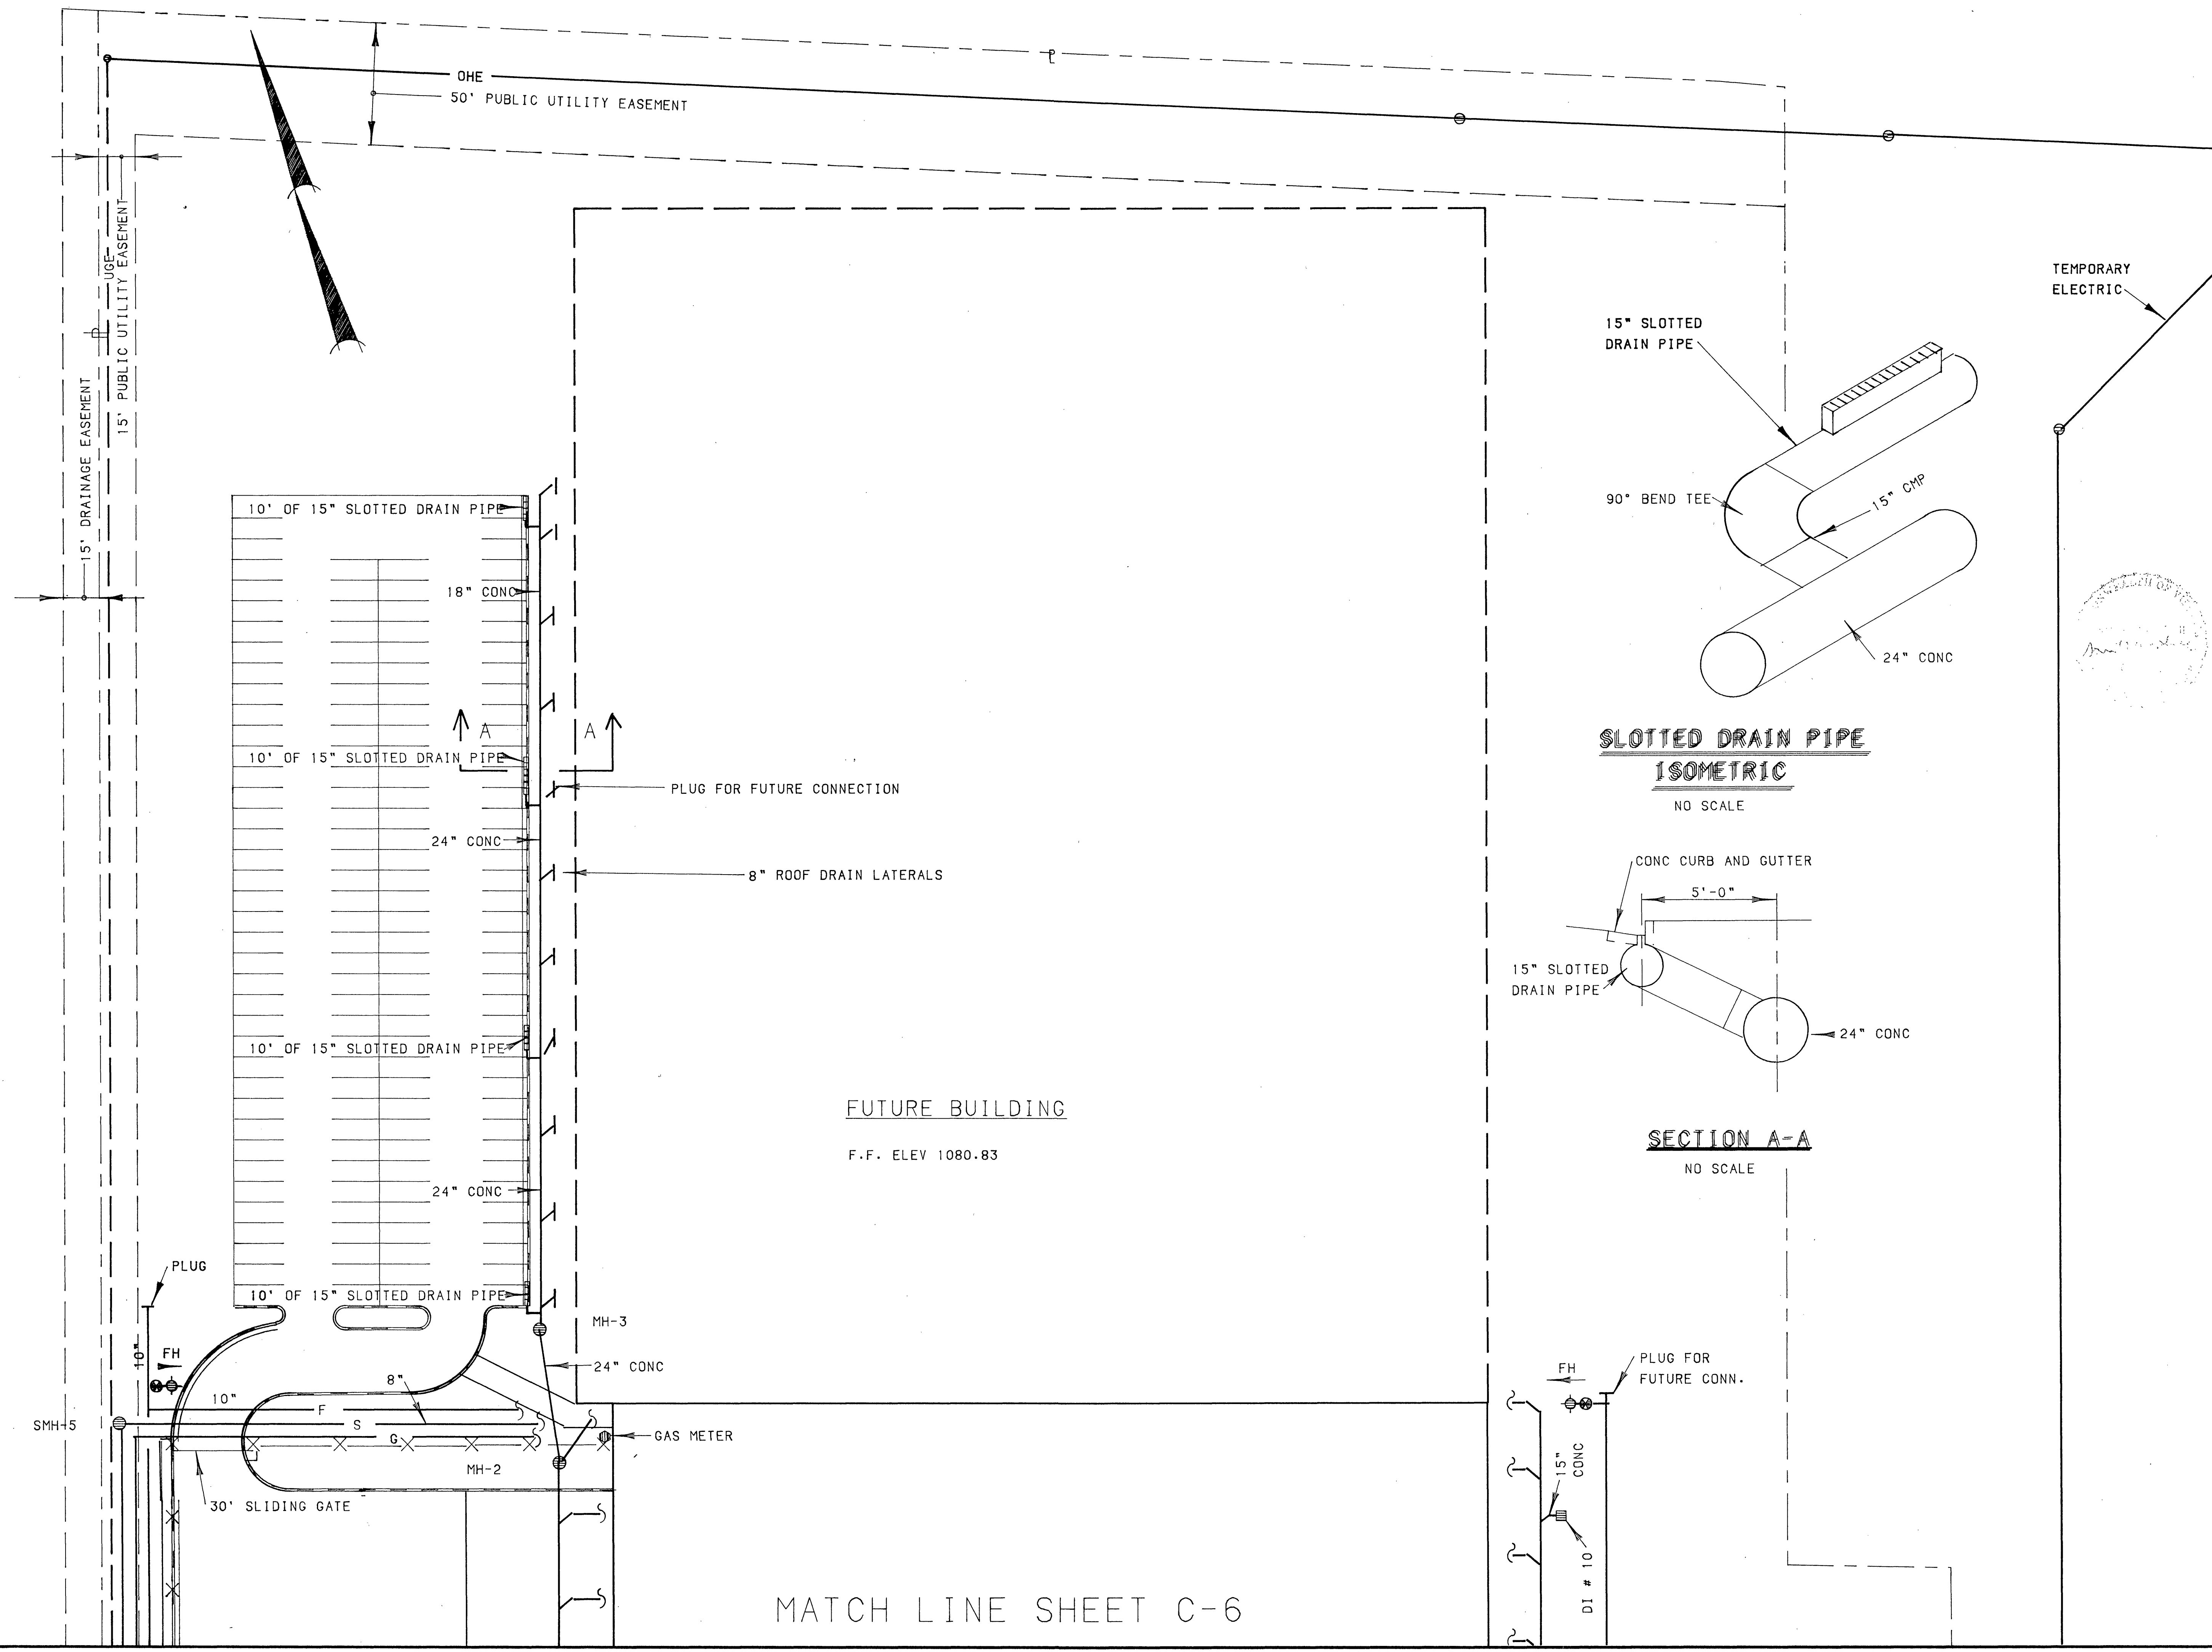

SLOTTED DRAIN PIPE
ISOMETRIC
NO SCALE

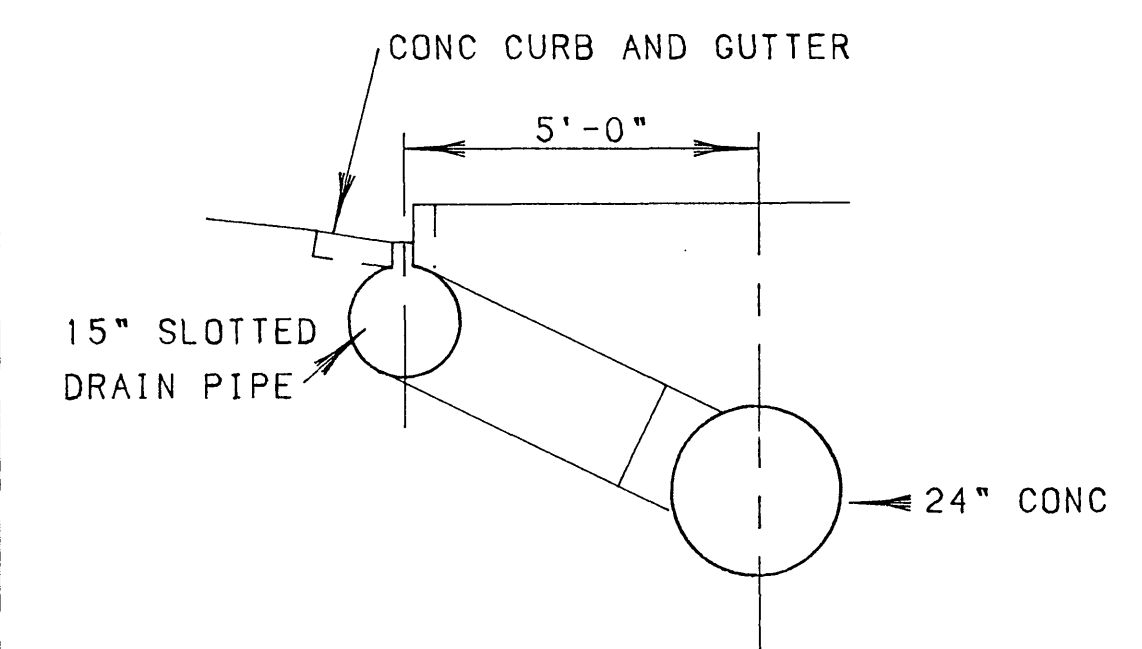

SECTION A-A
NO SCALE

MATCH LINE SHEET C-6