




REVISION		DATE	DESCRIPTION
DESIGNED	KLR		GRADING AND STORM DRAINAGE PLAN FOR R.C.I.T. ADDITION, PHASE II
DRAWN	PVR, VMB		PREPARED FOR CITY OF ROANOKE, VIRGINIA
CHECKED	MSW		ROANOKE, VIRGINIA
LUMSDEN ASSOCIATES, P.C.			SCALE: 1" = 30'
ENGINEERS-SURVEYORS-PLANNERS			DATE: 11 Nov. 1994
ROANOKE, VIRGINIA			COMM: 94-4448
			SHEET 3 of 10

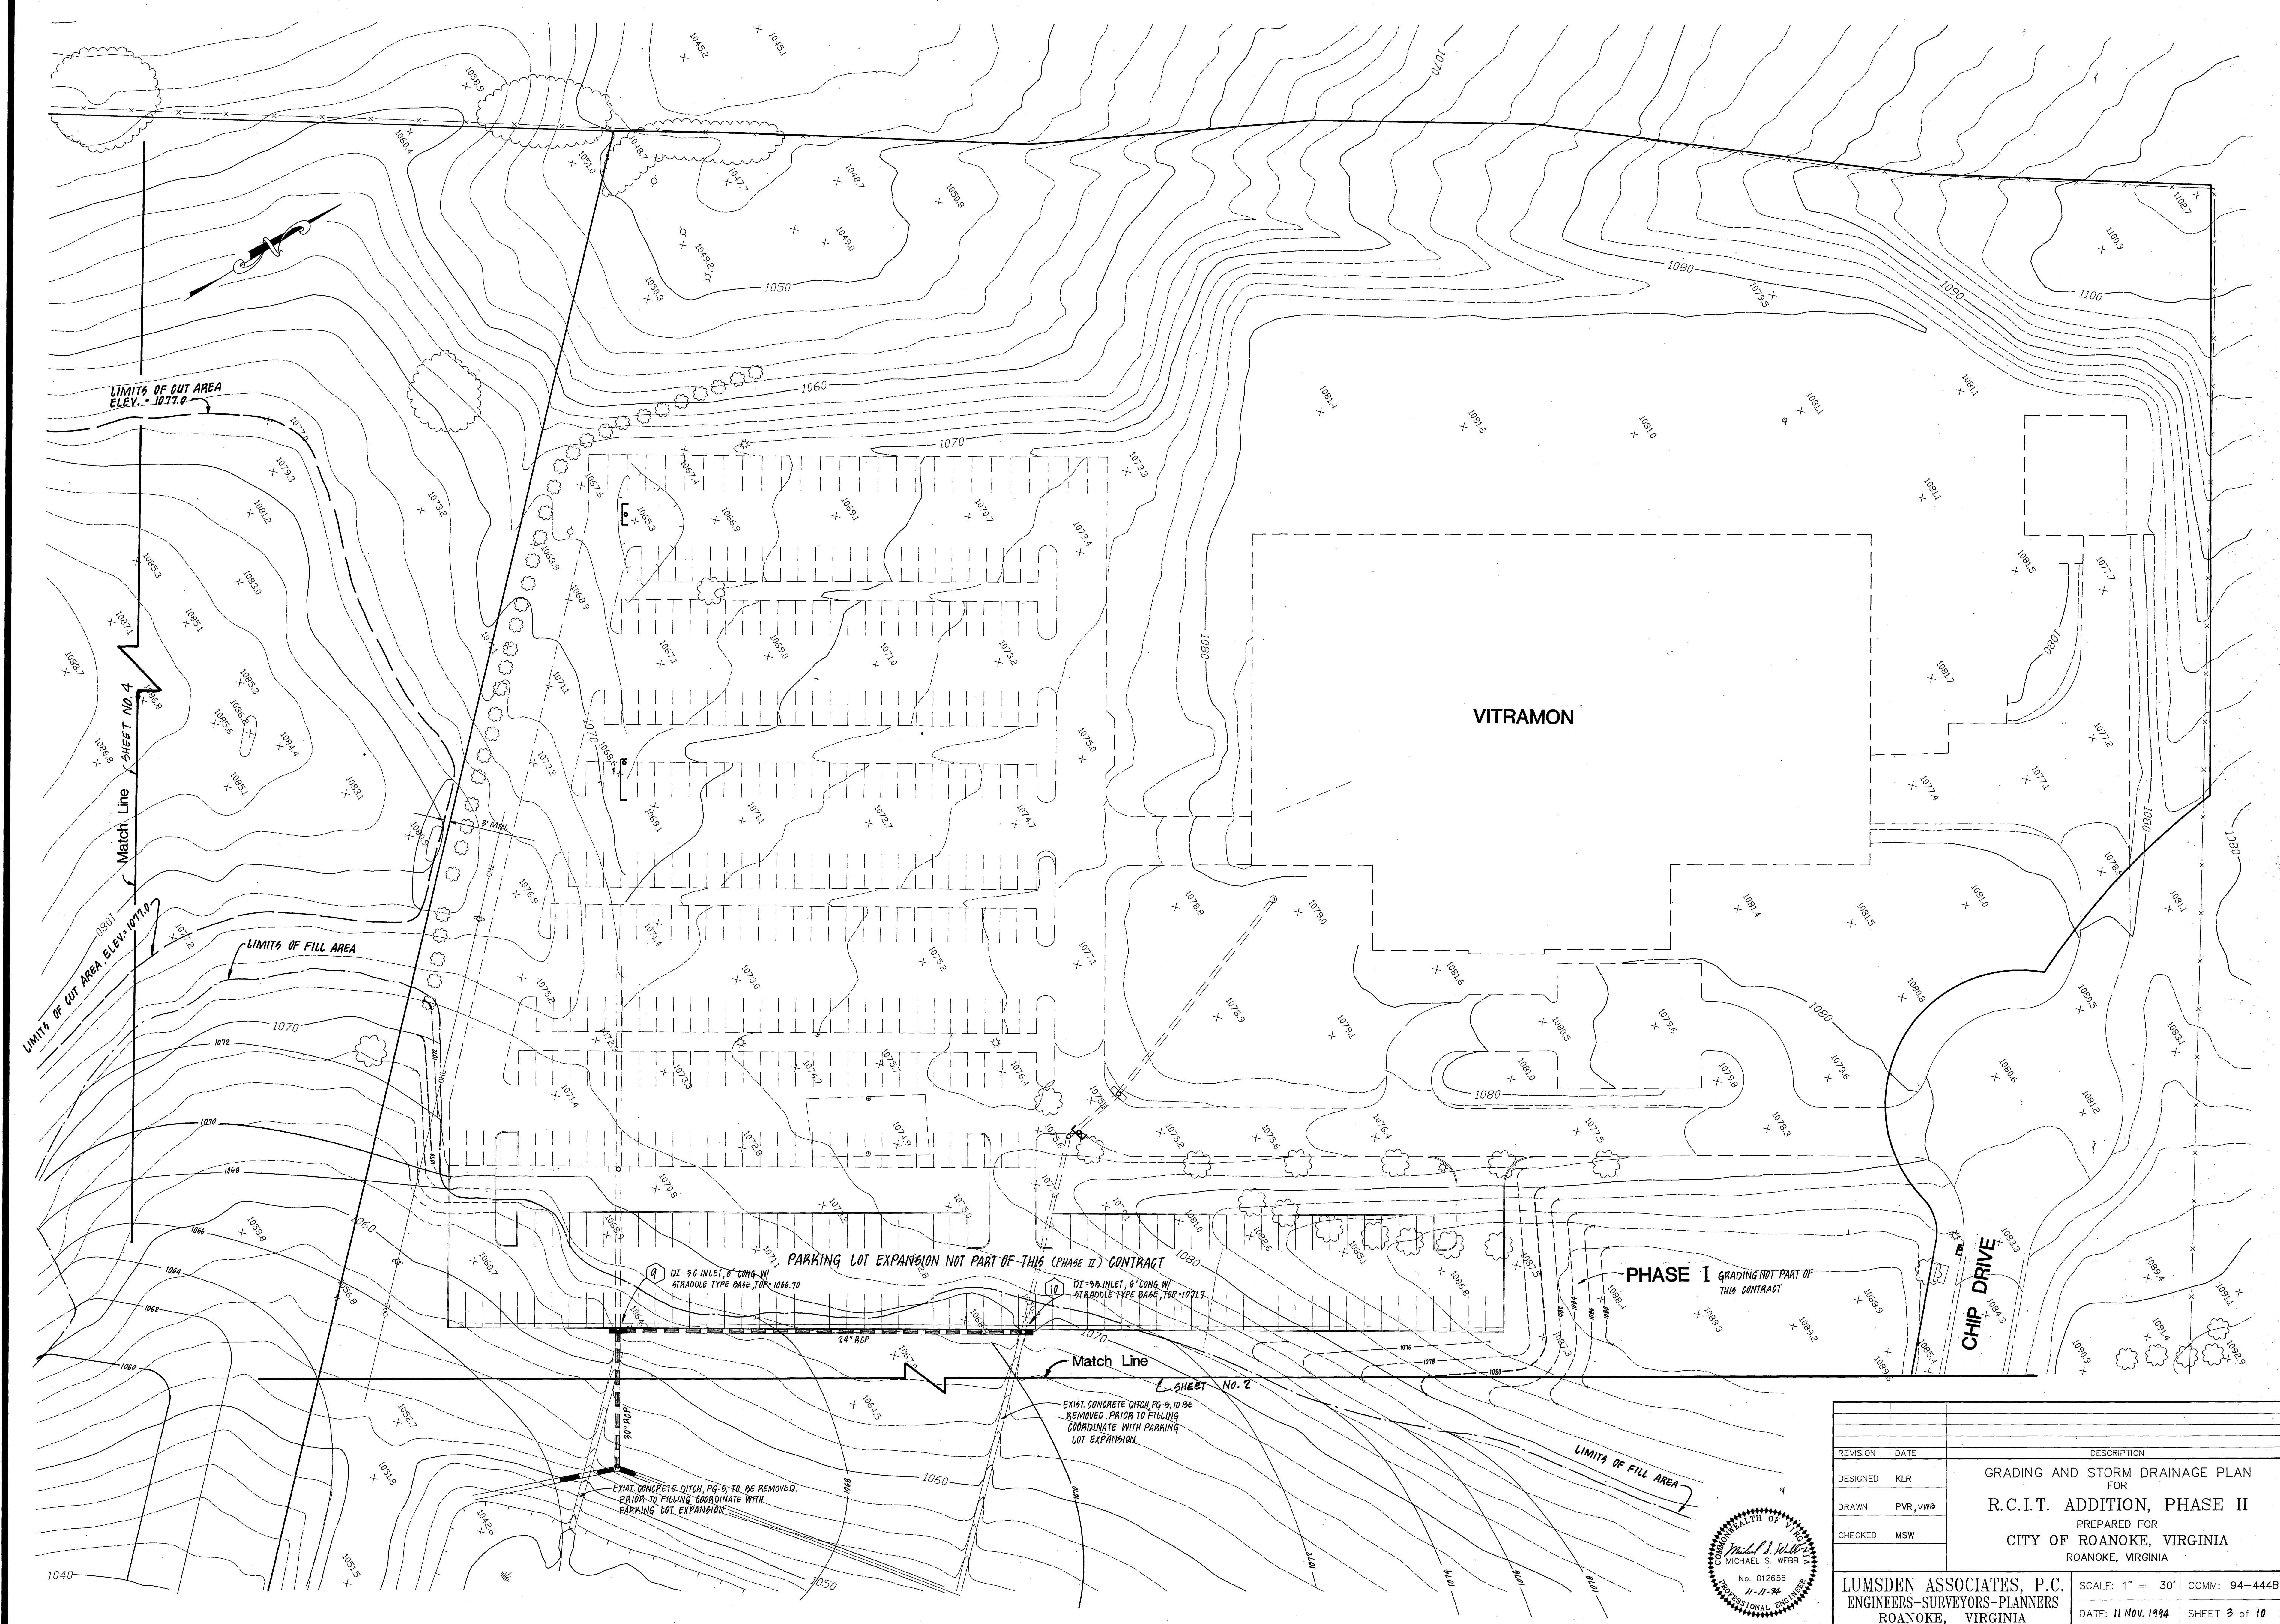