
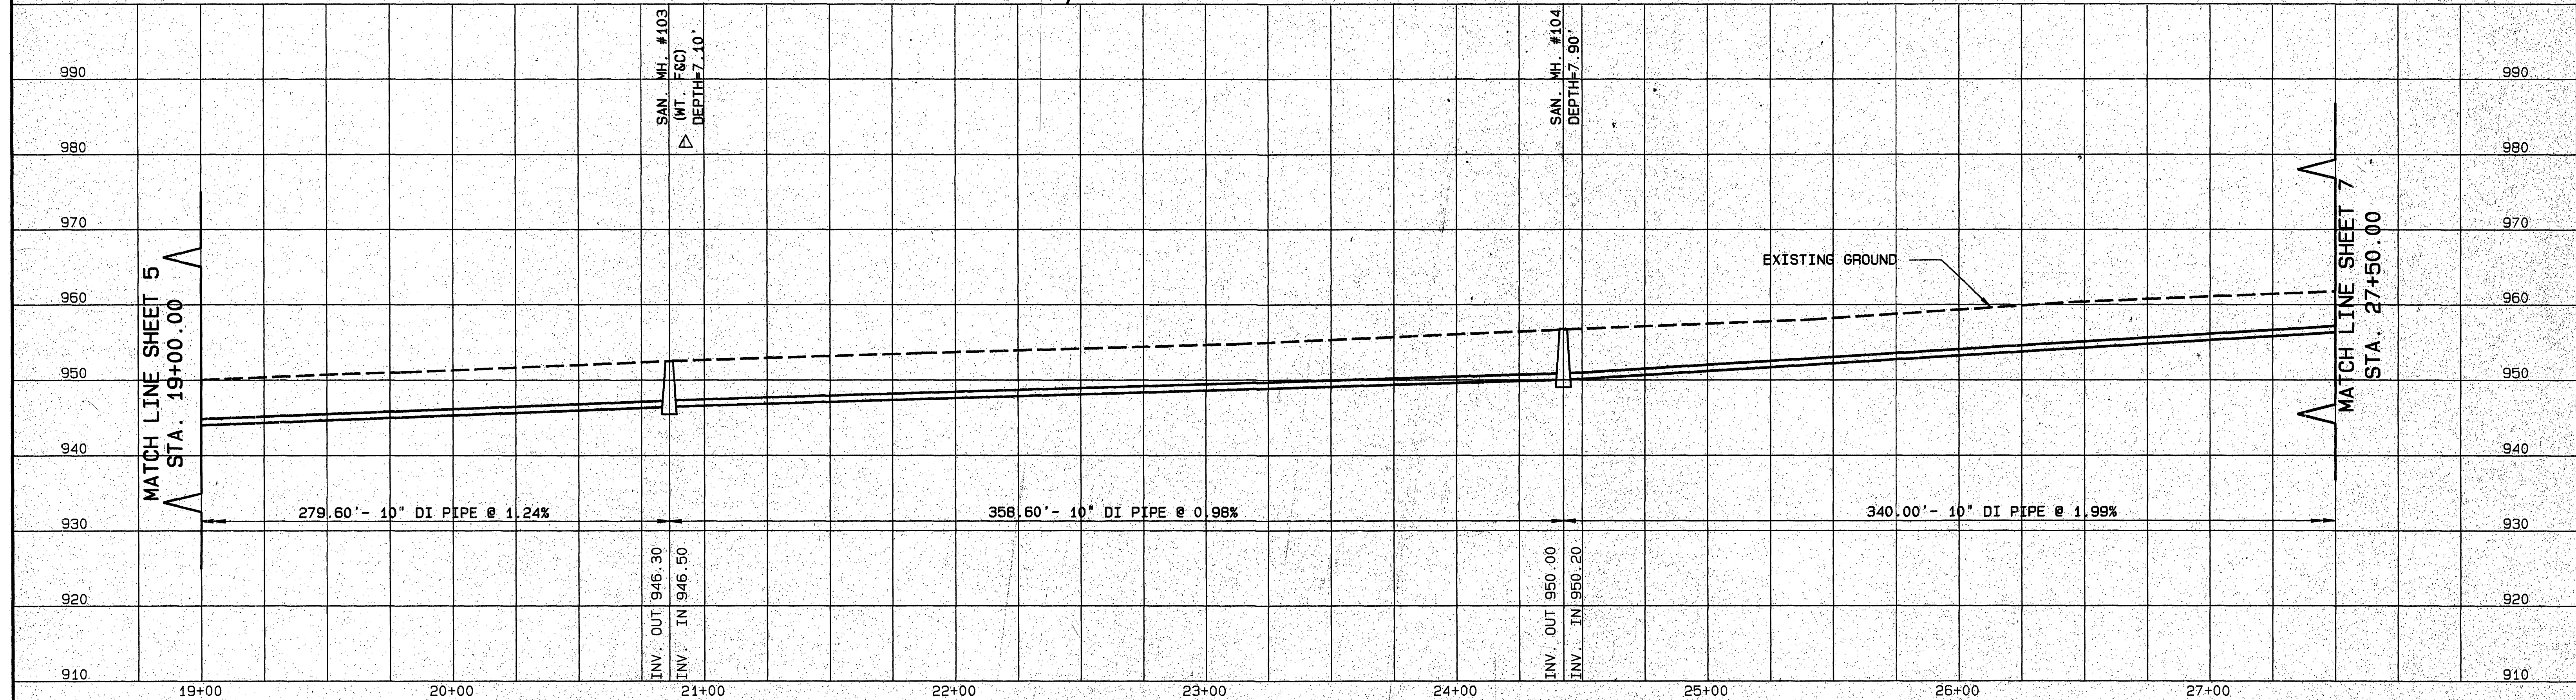


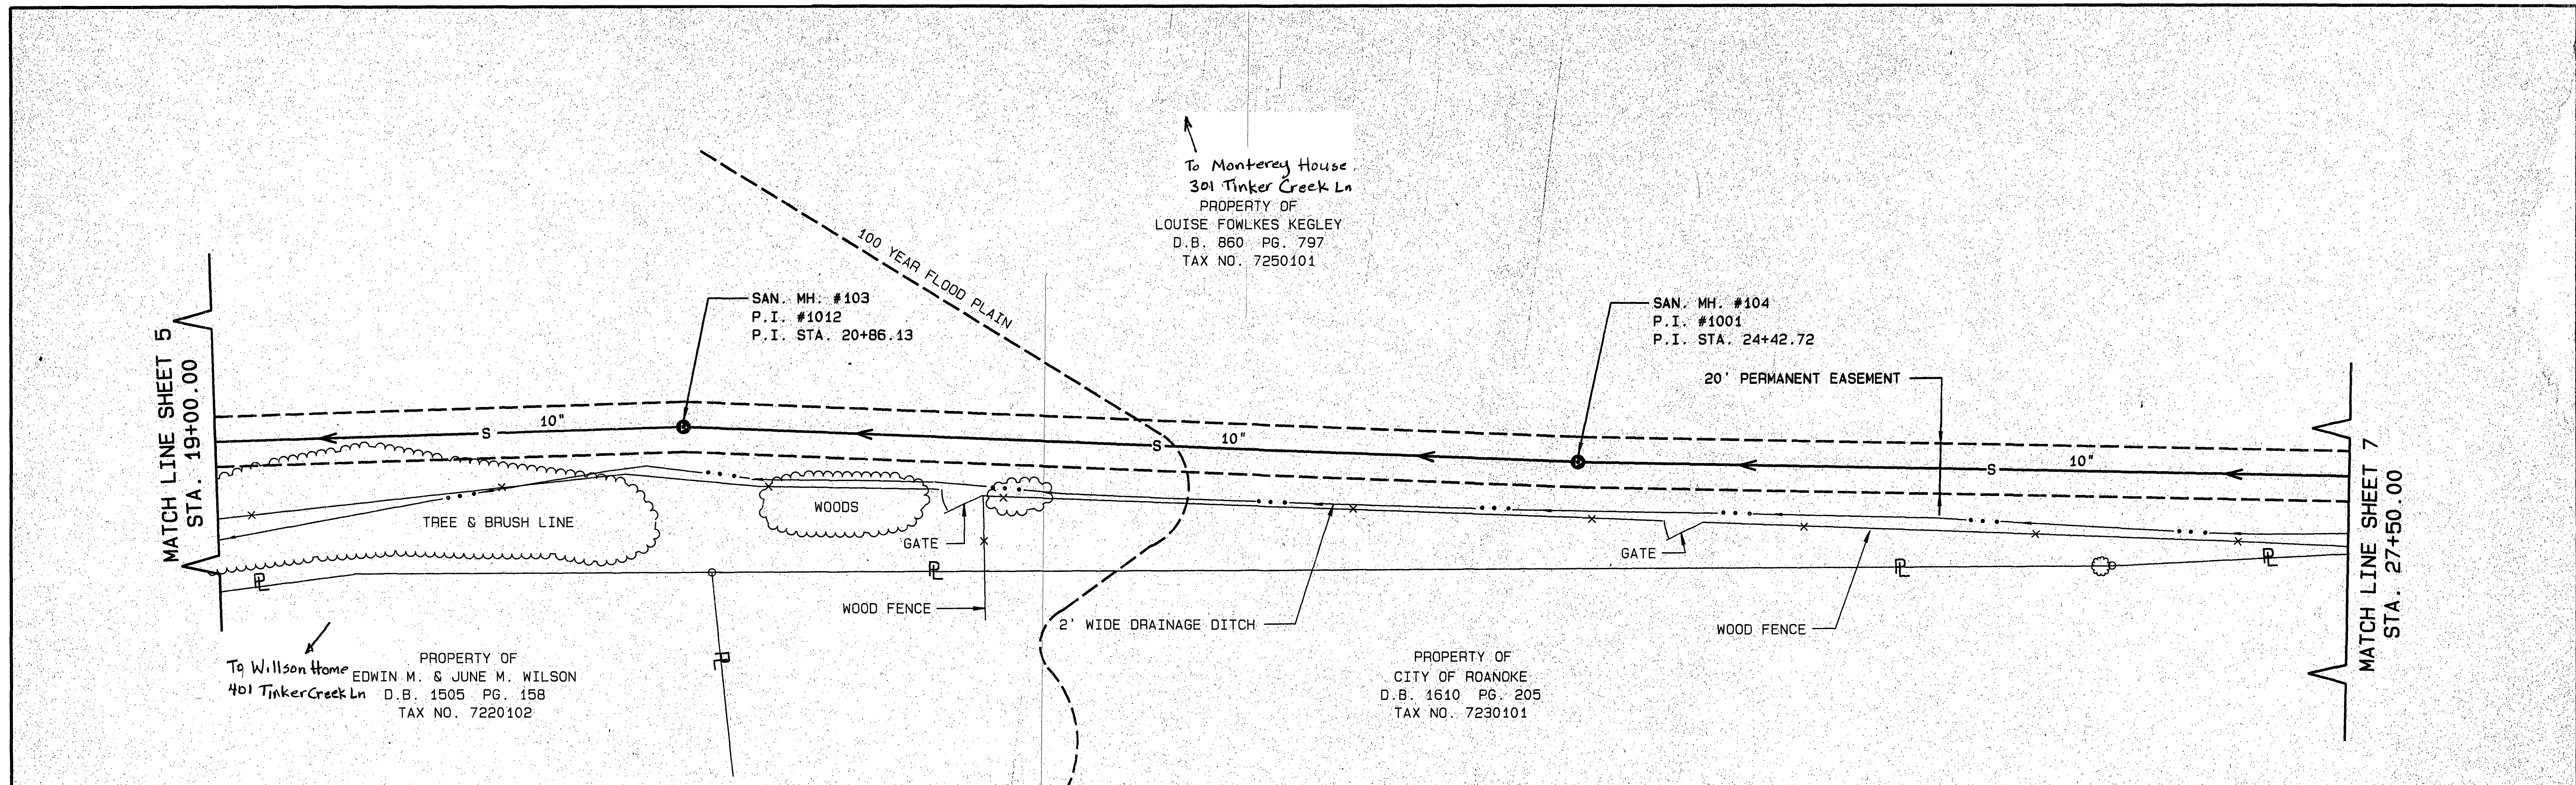

RECORD DRAWING

Mattern & Craig CONSULTING ENGINEERS - SURVEYORS	DESIGNED: JMB	NORTH	REVISION	DATE	DESCRIPTION	BY	APP.	DATE JUNE 1992 COMM. 1165B	SANITARY SEWER EXTENSION ROANOKE CENTRE FOR INDUSTRY & TECHNOLOGY PLAN & PROFILE CITY OF ROANOKE, VIRGINIA SCALE: HORIZ. 1"=30' VERT. 1"=10'	SHEET 6 PLAN NO. 6209 DIM: 0-1165B-6
	DRAWN: REH		Δ	12/11/92	AS PER COMMENTS FROM VDH/OWP	ARB				
	APPROVED: SHM		Δ	12-20-94	RECORD DRAWING	DSG				