
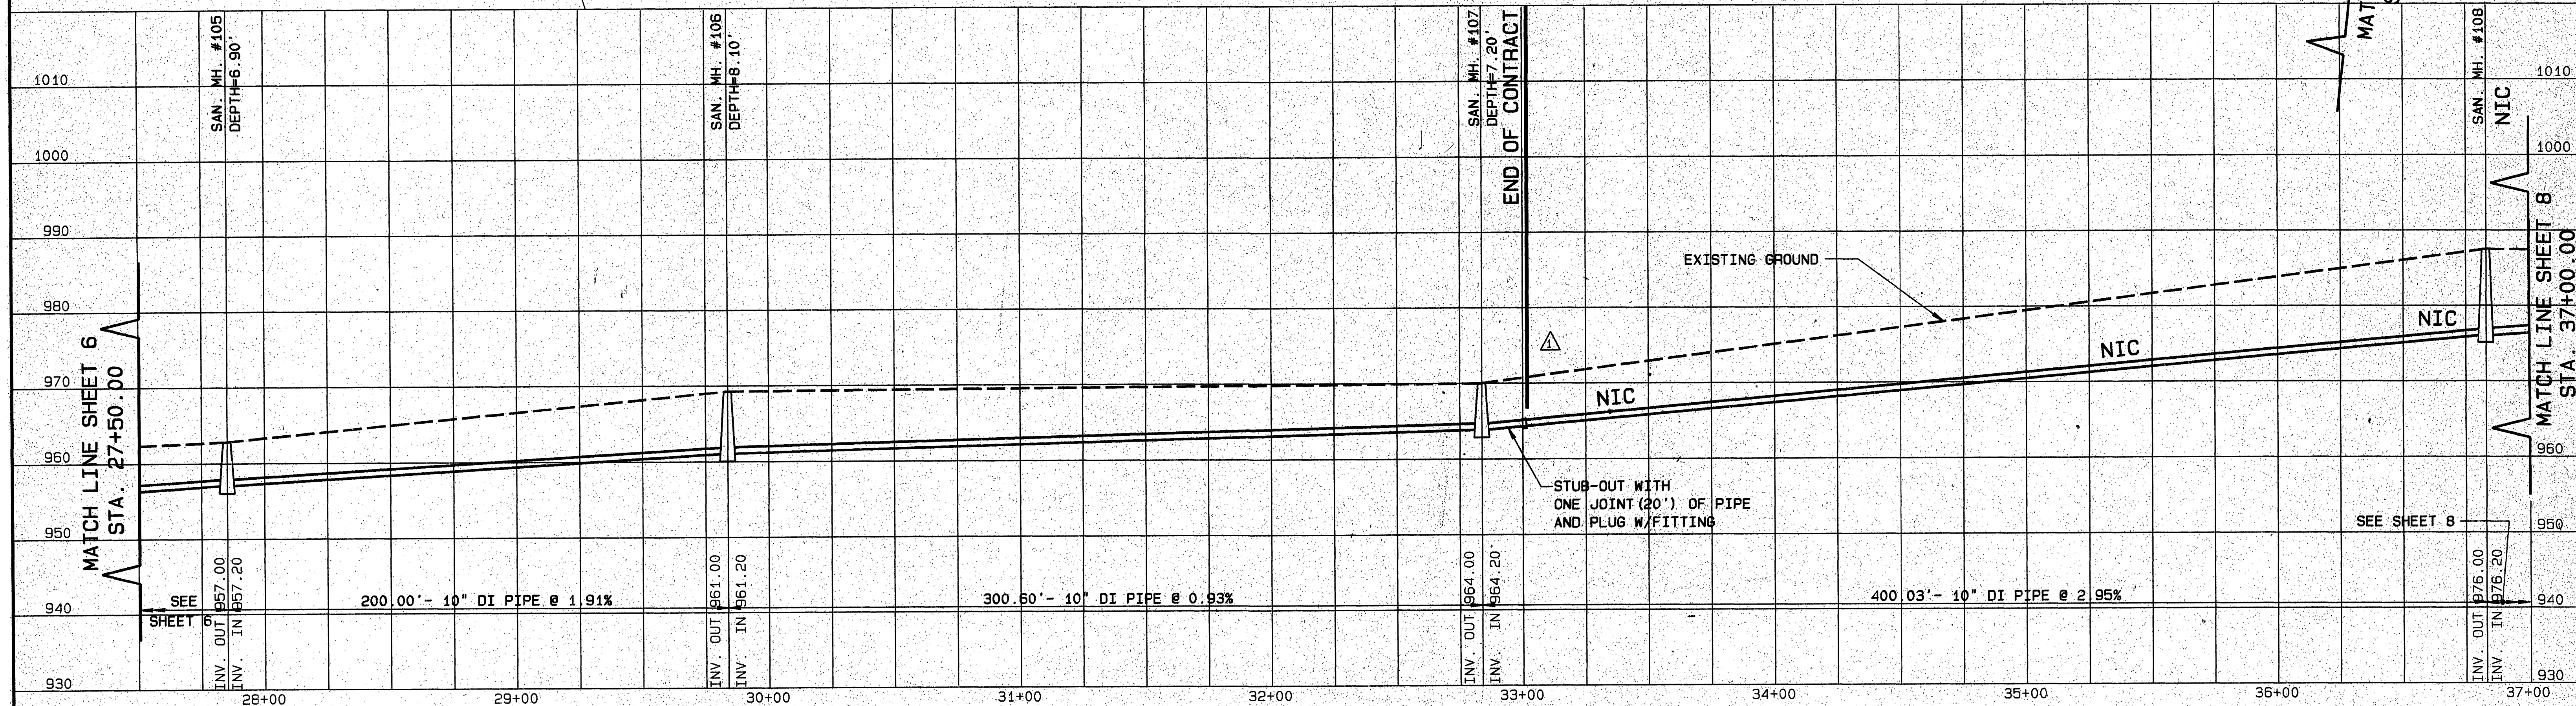
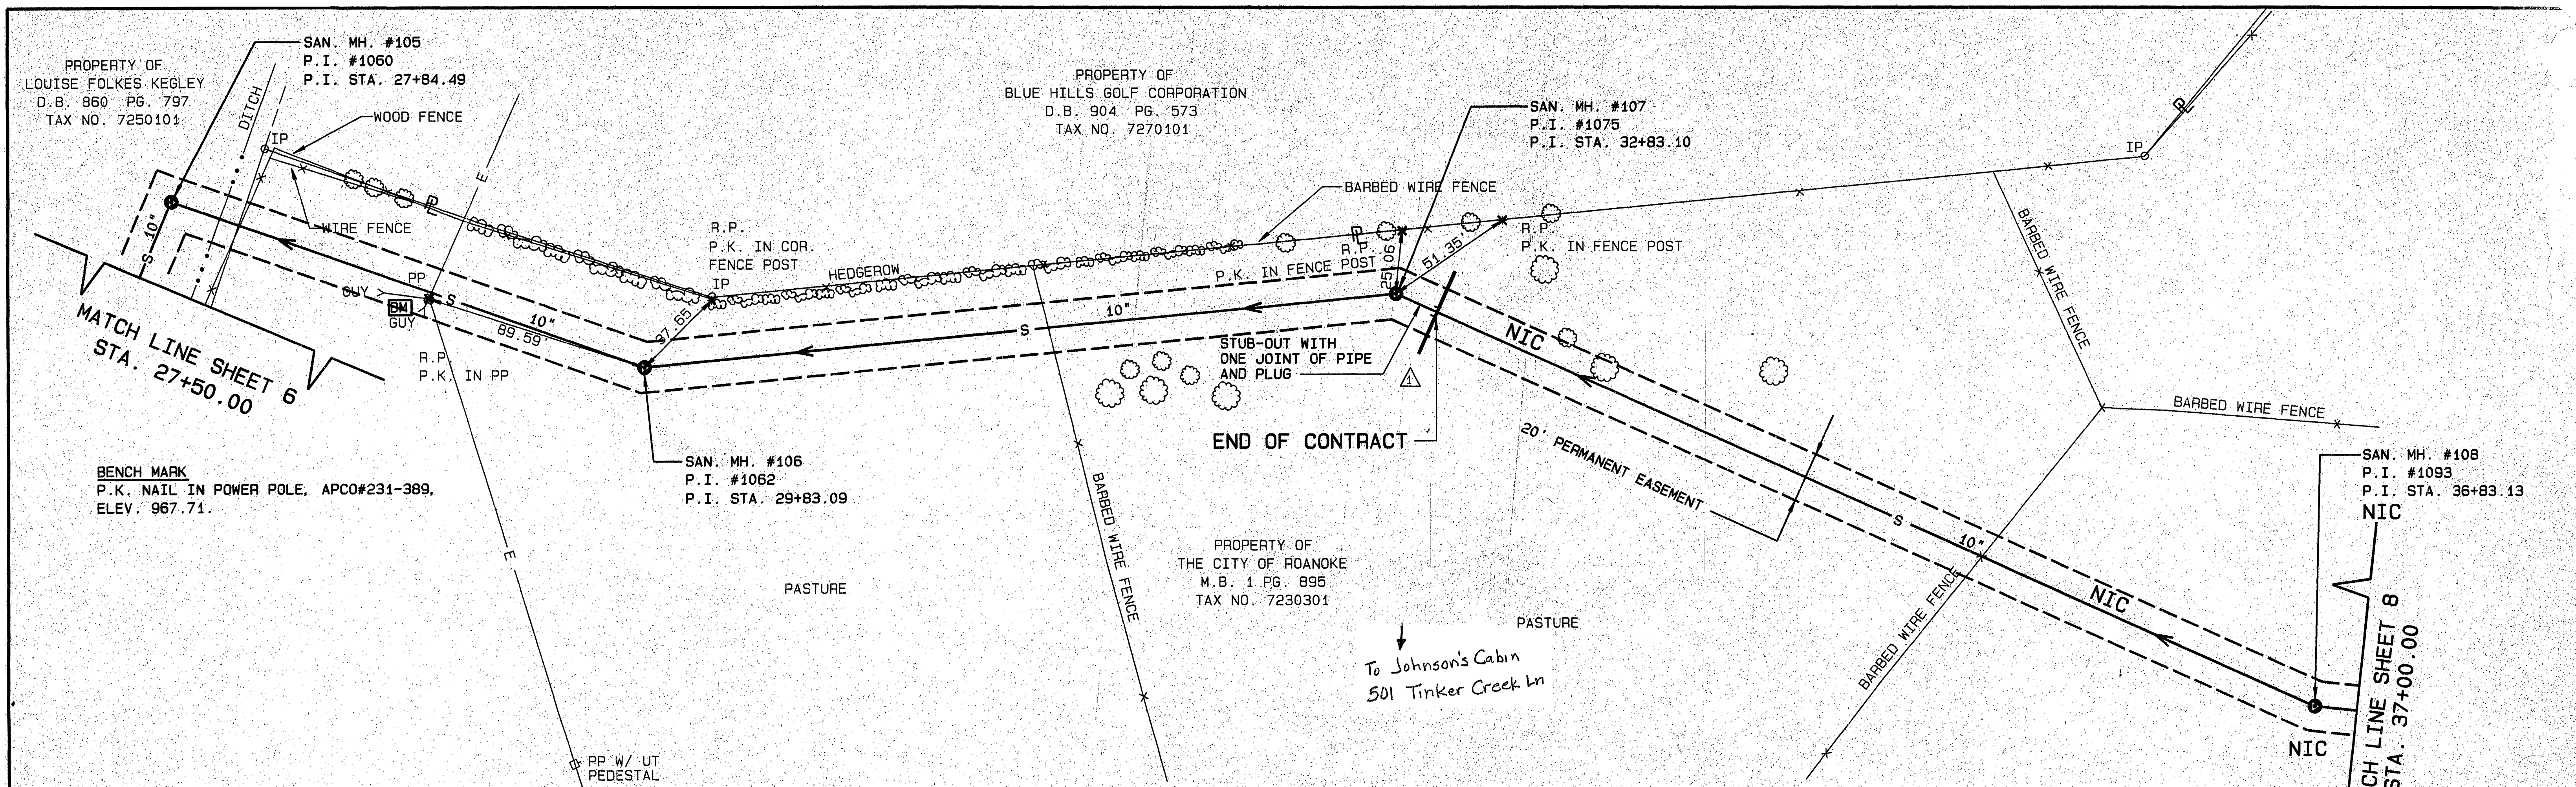
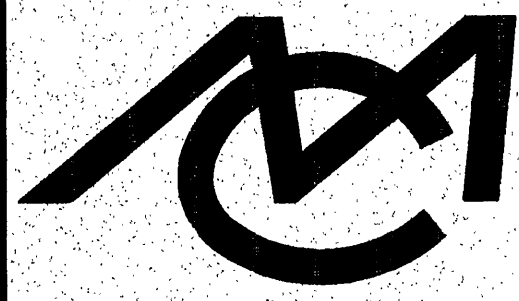


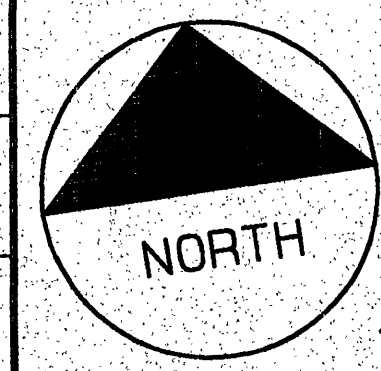

RECORD DRAWING

 Mattern & Craig CONSULTING ENGINEERS - SURVEYORS	DESIGNED: JMB	 NORTH	REVISION	DATE	DESCRIPTION	BY	APP.	DATE	SANITARY SEWER EXTENSION ROANOKE CENTRE FOR INDUSTRY & TECHNOLOGY PLAN & PROFILE CITY OF ROANOKE, VIRGINIA SCALE: HORIZ. 1"=30' VERT. 1"=10'	SHEET
	DRAWN: REH		△	5-17-94	END CONTRACT WITH STUB-OUT AT MH #107	DSG	WJJ	JUNE 1992		7
	APPROVED: SHM		△	12-20-94	RECORD DRAWING	DSG				PLAN NO.
										6209