


PROJECT LOCATION MAP

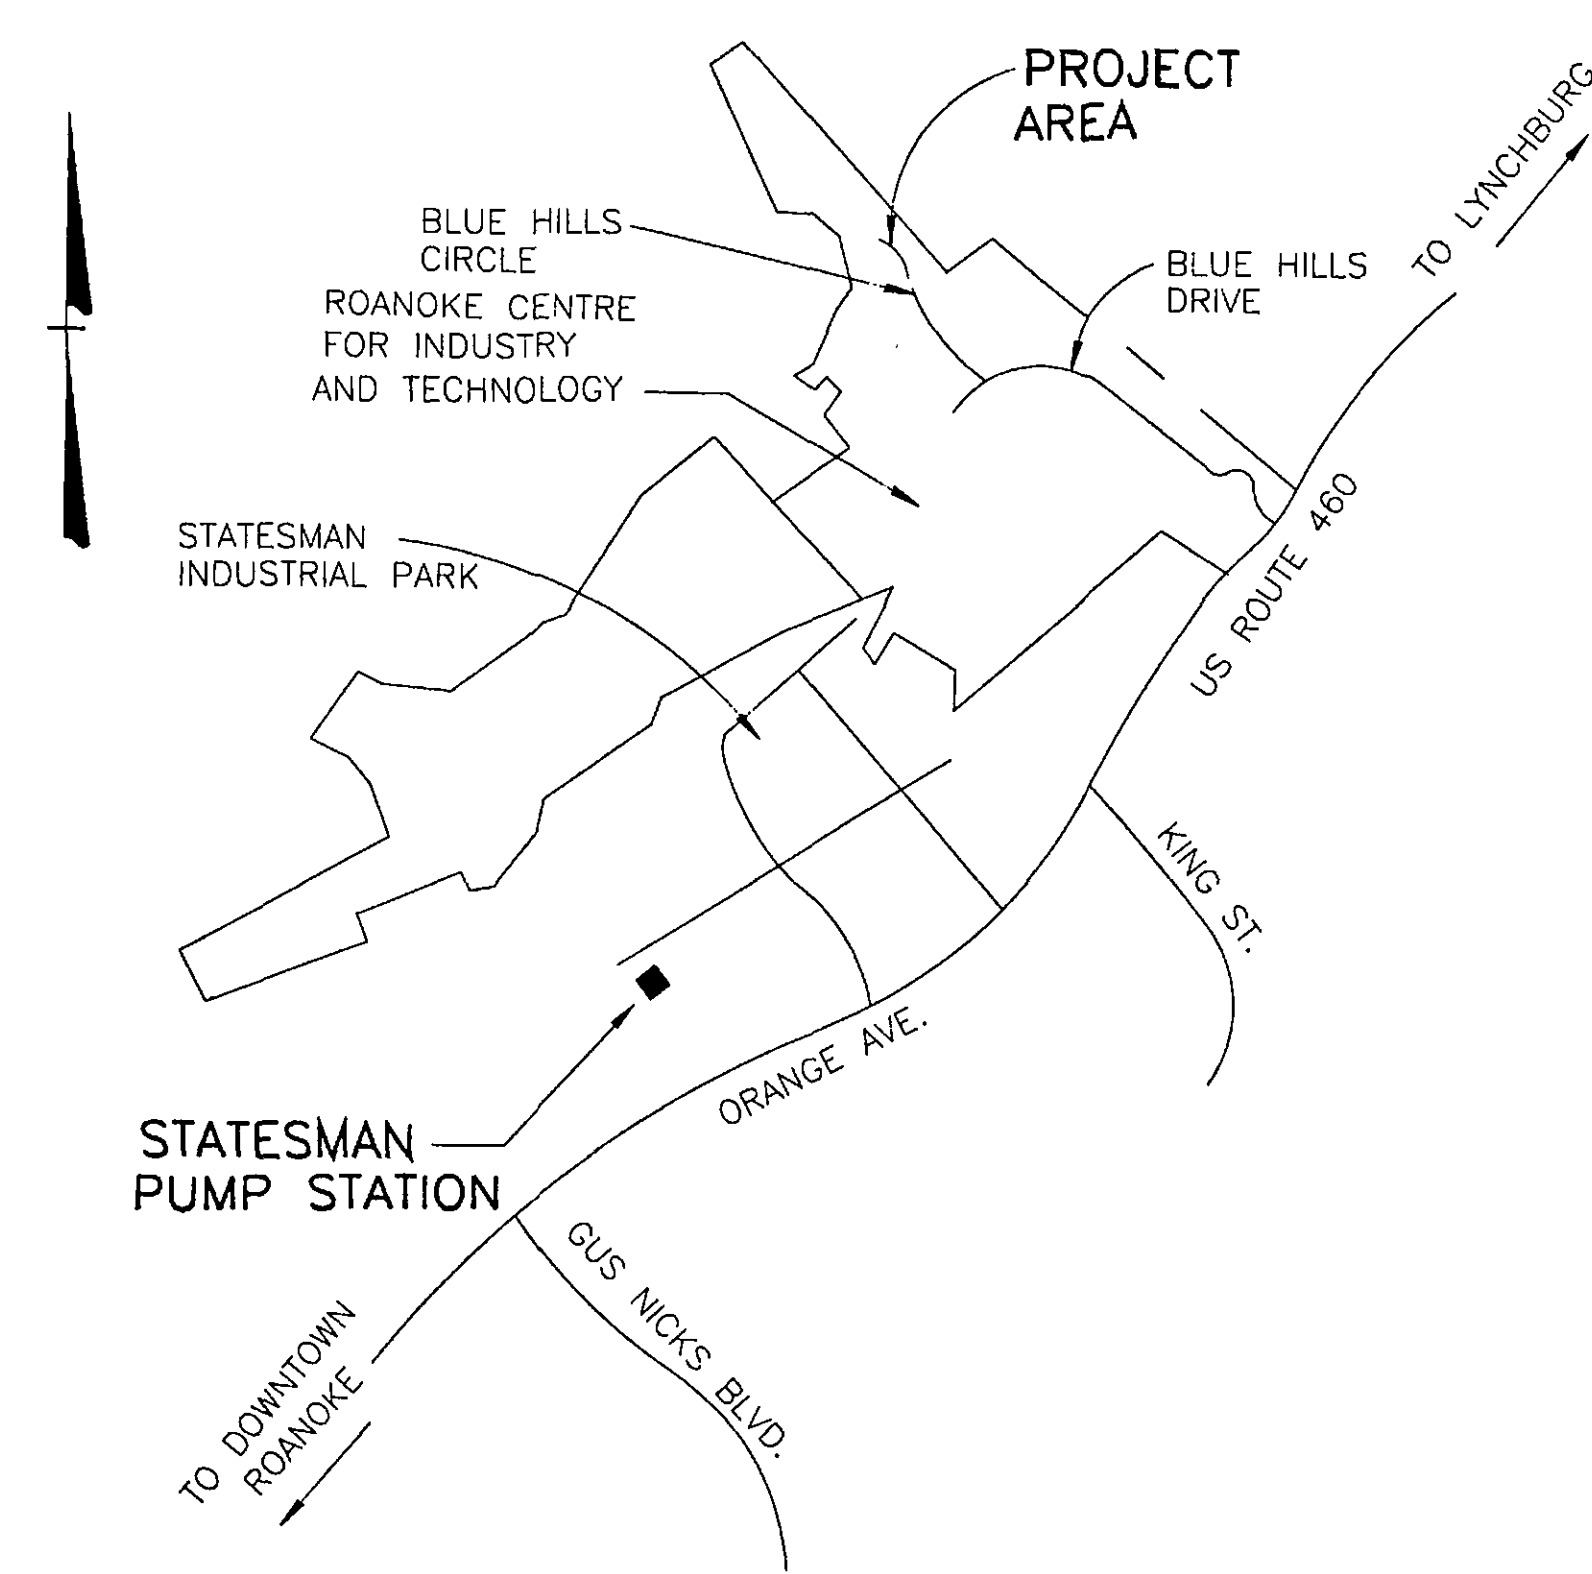


OFFICE OF CITY ENGINEER
ROOM 350
MUNICIPAL BUILDING
215 CHURCH AVENUE, S.W.
ROANOKE, VIRGINIA 24011

INDEX OF SHEETS

- 1 TITLE
- 2 SUMMARY OF QUANTITIES
- 3 GENERAL ABBREVIATIONS & LEGEND
- 4 SHEET INDEX
- 5 PLAN & PROFILE
- 6 PLAN & PROFILE
- 7 PLAN & PROFILE
- 8 PUMP STATION
- 9 ELECTRICAL DETAILS & TELEMETRY


RECEIVED
MAR 28 1994
CITY OF ROANOKE
DEPARTMENT OF PLANNING AND
COMMUNITY DEVELOPMENT

CONSULTING ENGINEERS

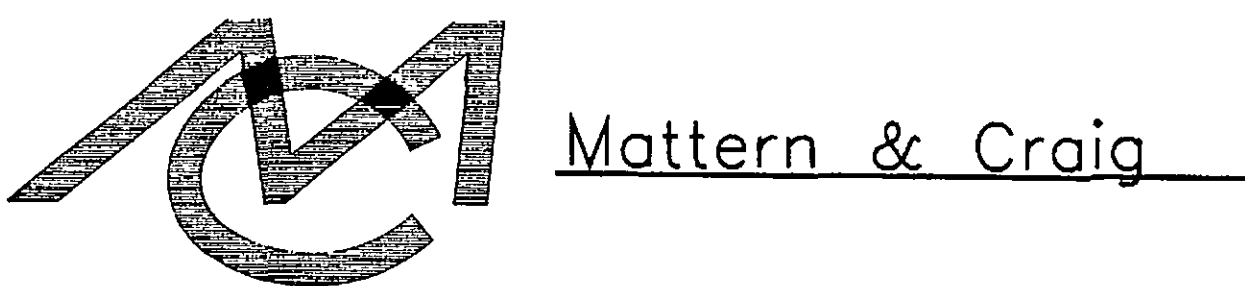

CONSULTING ENGINEERS
SURVEYORS
701 FIRST STREET
ROANOKE, VIRGINIA

COMMISSION NUMBER: 1165G

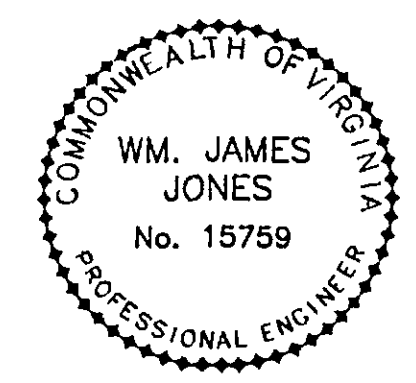

PROJECT NAME

ROANOKE CENTRE FOR INDUSTRY
AND TECHNOLOGY
WATER STORAGE TANK – CONTRACT II
CITY OF ROANOKE, VIRGINIA

PROJECT NUMBER: 6260

REVISION BY	DESCRIPTION:	DATE
REVISION BY	DESCRIPTION:	DATE
REVISION BY	DESCRIPTION:	DATE
REVISION BY	DESCRIPTION:	DATE

APPROVED FOR CONSTRUCTION

<u>Charles M. Huffine</u> ROANOKE CITY ENGINEER	<u>12-27-93</u> DATE
<u>William F. Clark</u> DIRECTOR OF PUBLIC WORKS	<u>12-28-93</u> DATE
<u>W. B. L.</u> DIRECTOR OF PUBLIC UTILITIES AND OPERATIONS	<u>12/28/93</u> DATE
	DATE
	DATE

ADVERTISED DATE: _____

SET NUMBER: _____

SHEET NUMBER: 1 OF 9

Waterline to the tank - Contract II
water dept # 93-27