


PROJECT LOCATION MAP

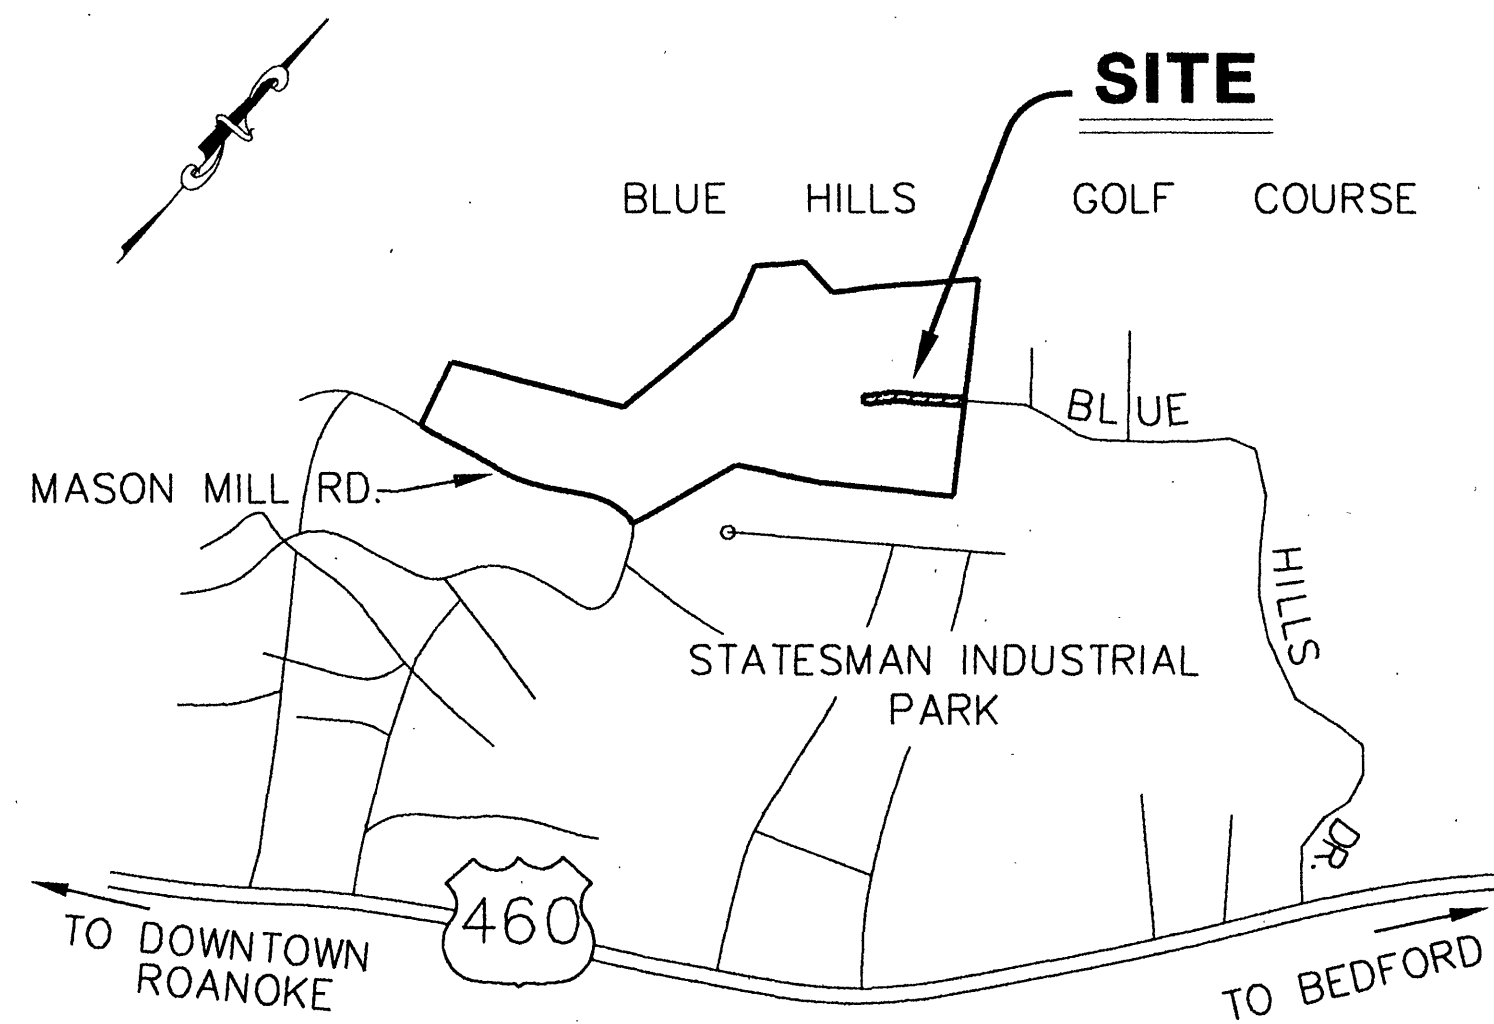

LOCATION MAP

NO SCALE



OFFICE OF CITY ENGINEER

ROOM 350

MUNICIPAL BUILDING

215 CHURCH AVENUE, S.W.

ROANOKE, VIRGINIA 24011

INDEX OF SHEETS

1. COVER SHEET
2. SHEET INDEX, LEGEND AND SUMMARY OF QUANTITIES
3. DEMOLITION PLAN AND GENERAL NOTES
4. BLUE HILLS DRIVE - PLAN AND PROFILE
5. BLUE HILLS DRIVE - PLAN AND PROFILE
6. BLUE HILLS DRIVE - GRADING PLAN
7. SANITARY SEWER - PLAN AND PROFILE
8. SANITARY SEWER - PLAN AND PROFILE
9. SANITARY SEWER - PLAN AND PROFILE
10. SANITARY SEWER - PLAN AND PROFILE
11. SANITARY SEWER - PLAN AND PROFILE
12. CONSTRUCTION DETAILS
13. CROSS SECTIONS - BLUE HILLS DRIVE
14. CROSS SECTIONS - BLUE HILLS DRIVE
15. STORM DRAIN PROFILES
16. WATER LINE PROFILES

CONSULTING ENGINEERS

LUMSDEN ASSOCIATES, P.C.
ENGINEERS-SURVEYORS-PLANNERS
ROANOKE, VIRGINIA

COMMISSION NUMBER: 97-80



PROJECT NAME

**INFRASTRUCTURE IMPROVEMENTS
ROANOKE CENTRE FOR INDUSTRY
AND TECHNOLOGY**

BLUE HILLS DRIVE AND SANITARY SEWER EXTENSION

PROJECT NUMBER: 6349



REVISION BY

DESCRIPTION: DELETED STREET LIGHTING AND RELATED APPURTENANCES FROM CONTRACT. REVISED STORM DRAIN SYSTEM BETWEEN DRAINAGE STRUCTURES (A) AND (B). CHANGED LOCATION OF 12" WATER LINE 5'4" OUT.

6/26/97

DATE

REVISION BY

DESCRIPTION:

DATE

REVISION BY

DESCRIPTION:

DATE

REVISION BY

DESCRIPTION:

DATE

APPROVED FOR CONSTRUCTION

Charles M. Huffine
ROANOKE CITY ENGINEER

5-1-97
DATE

William F. Clark
DIRECTOR OF PUBLIC WORKS

5-1-97
DATE

But B. L.
DIRECTOR OF UTILITIES AND OPERATIONS

5/1/97
DATE

DATE

DATE

ADVERTISED DATE: MAY 4, 1997

SET NUMBER:

SHEET NUMBER: 1 OF 16

BLUE HILLS DRIVE - AS BUILT 10.30.97

PROJECT 6349