



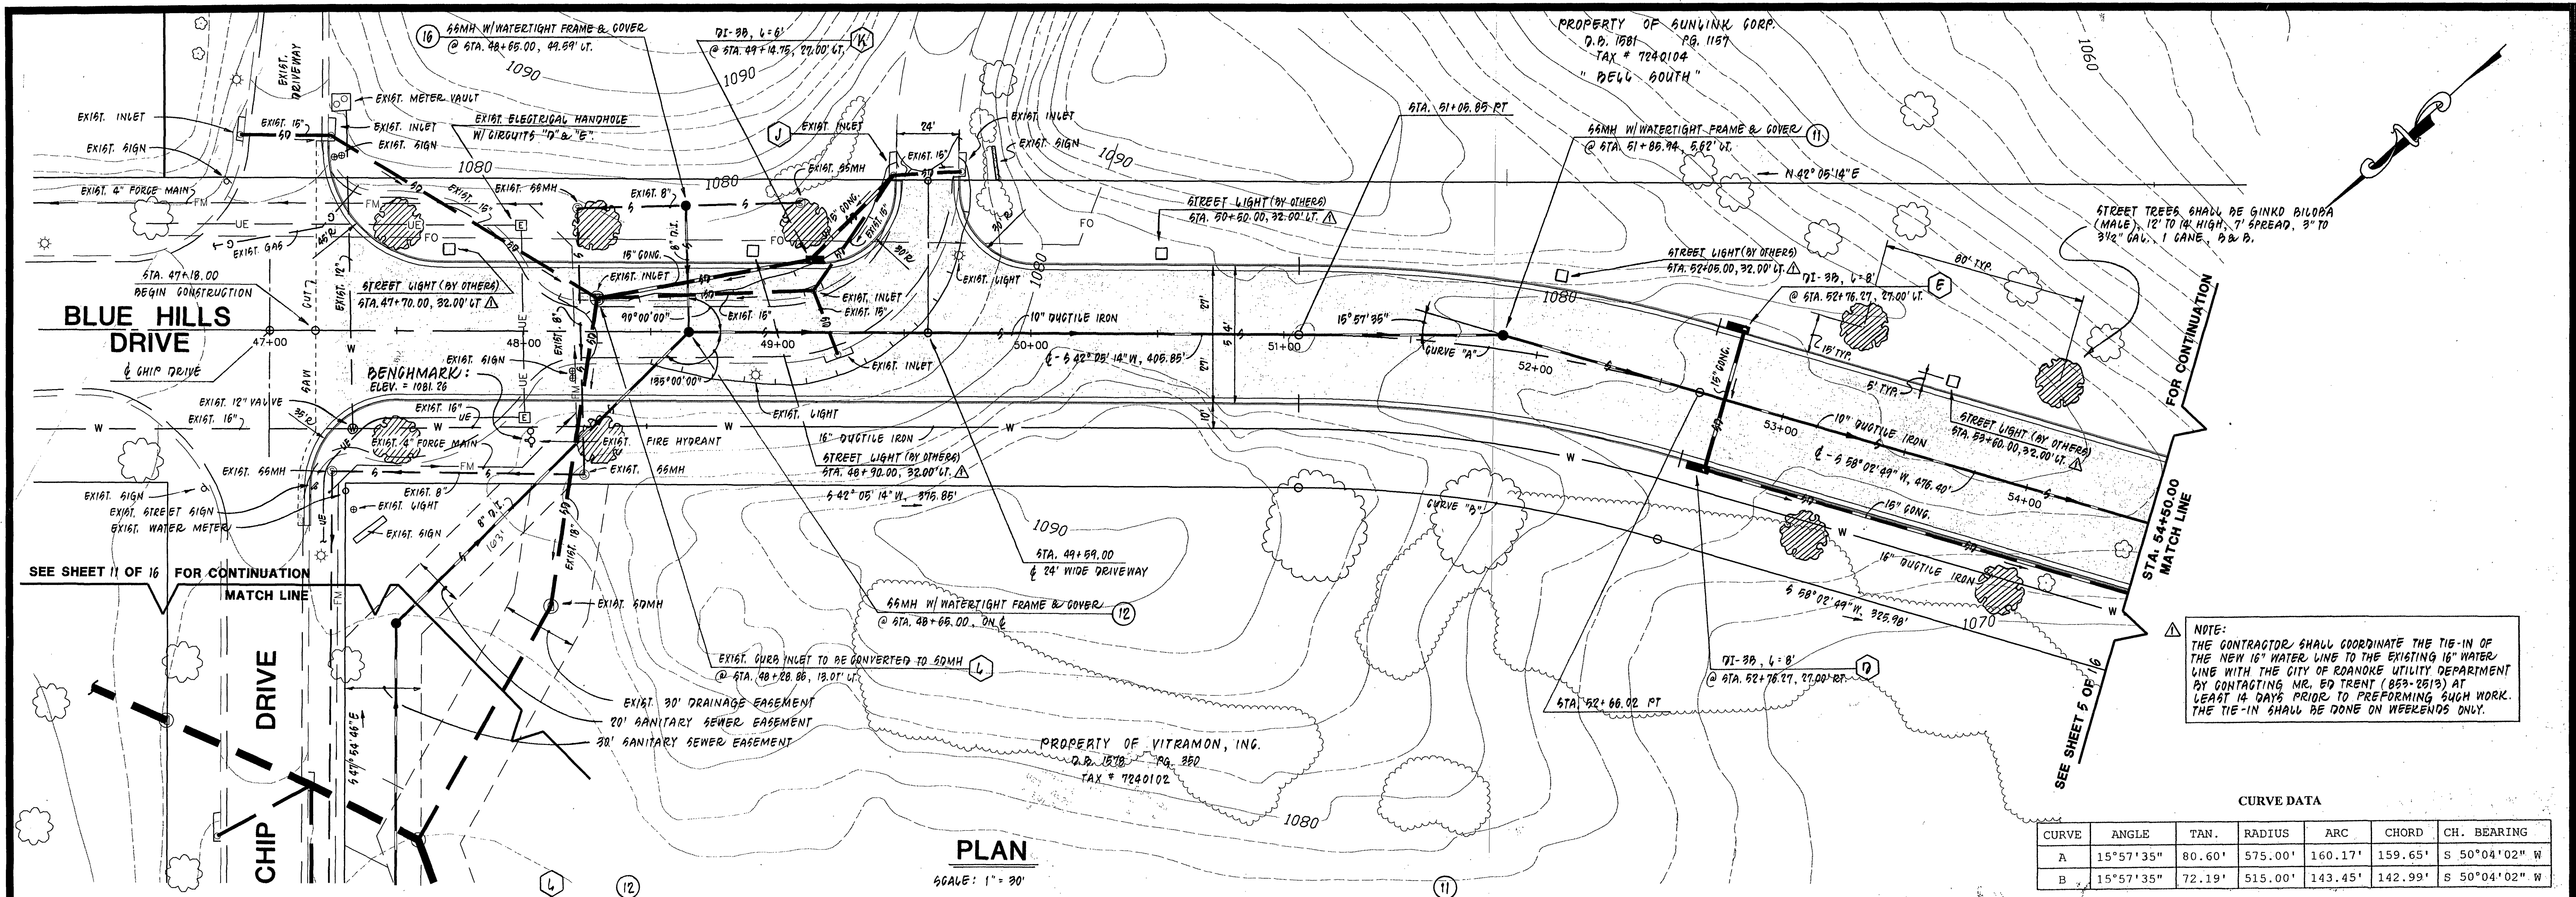

NOTE:
THE CONTRACTOR SHALL COORDINATE THE TIE-IN OF
THE NEW 16" WATER LINE TO THE EXISTING 16" WATER
LINE WITH THE CITY OF ROANOKE UTILITY DEPARTMENT
BY CONTACTING MR. ED TRENT (853-2813) AT
LEAST 14 DAYS PRIOR TO PERFORMING SUCH WORK.
THE TIE-IN SHALL BE DONE ON WEEKENDS ONLY.

CURVE DATA						
CURVE	ANGLE	TAN.	RADIUS	ARC	CHORD	CH. BEARING
A	15°57'35"	80.60'	575.00'	160.17'	159.65'	S 50°04'02" W
B	15°57'35"	72.19'	515.00'	143.45'	142.99'	S 50°04'02" W

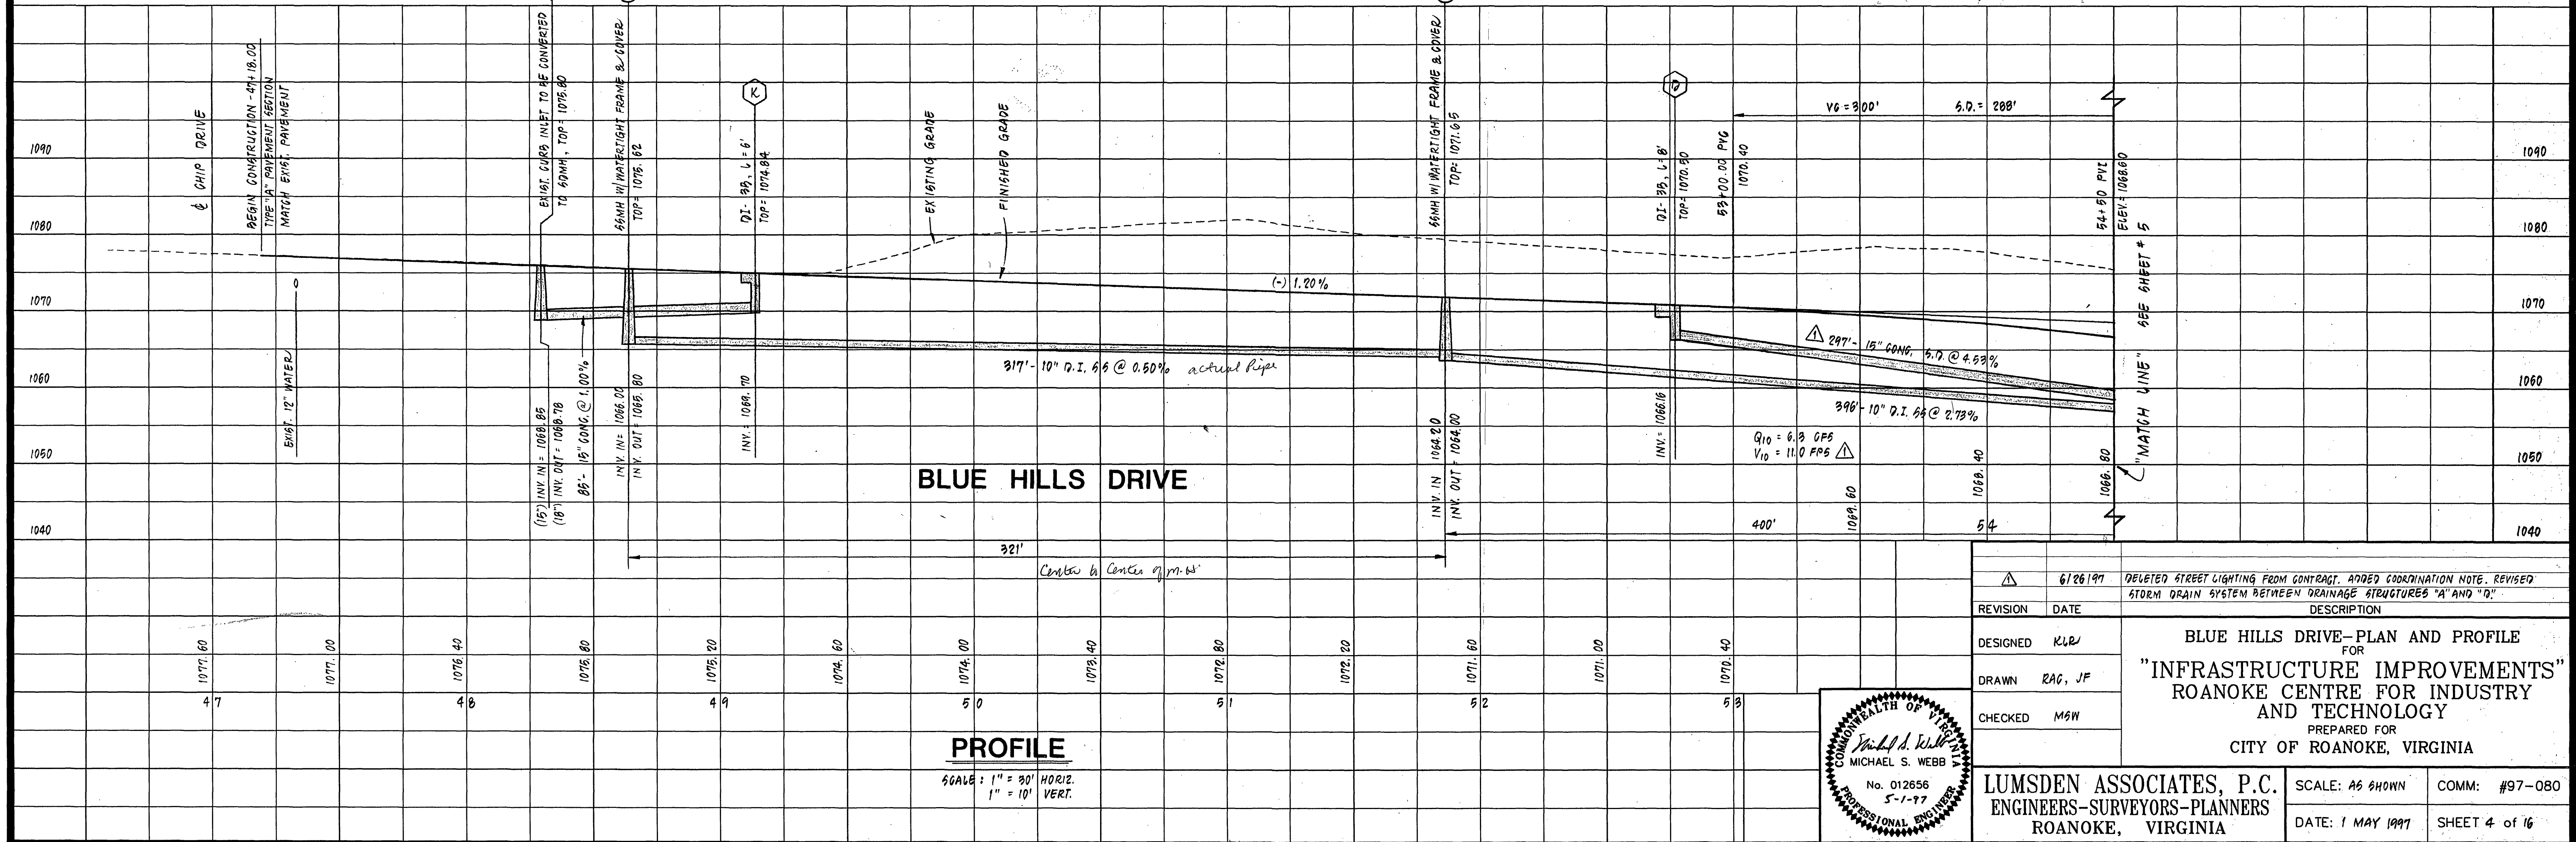

DESIGNED	KLR	BLUE HILLS DRIVE-PLAN AND PROFILE FOR "INFRASTRUCTURE IMPROVEMENTS" ROANOKE CENTRE FOR INDUSTRY AND TECHNOLOGY PREPARED FOR CITY OF ROANOKE, VIRGINIA
DRAWN	RAC, JF	
CHECKED	MSW	
DATE	6/26/97	
REVISION		DELETED STREET LIGHTING FROM CONTRACT. ADDED COORDINATION NOTE. REVISED STORM DRAIN SYSTEM BETWEEN DRAINAGE STRUCTURES "A" AND "D"
DESCRIPTION		
LUMSDEN ASSOCIATES, P.C. ENGINEERS-SURVEYORS-PLANNERS ROANOKE, VIRGINIA		
SCALE: AS SHOWN		COMM: #97-080
DATE: 1 MAY 1997		SHEET 4 of 16

