



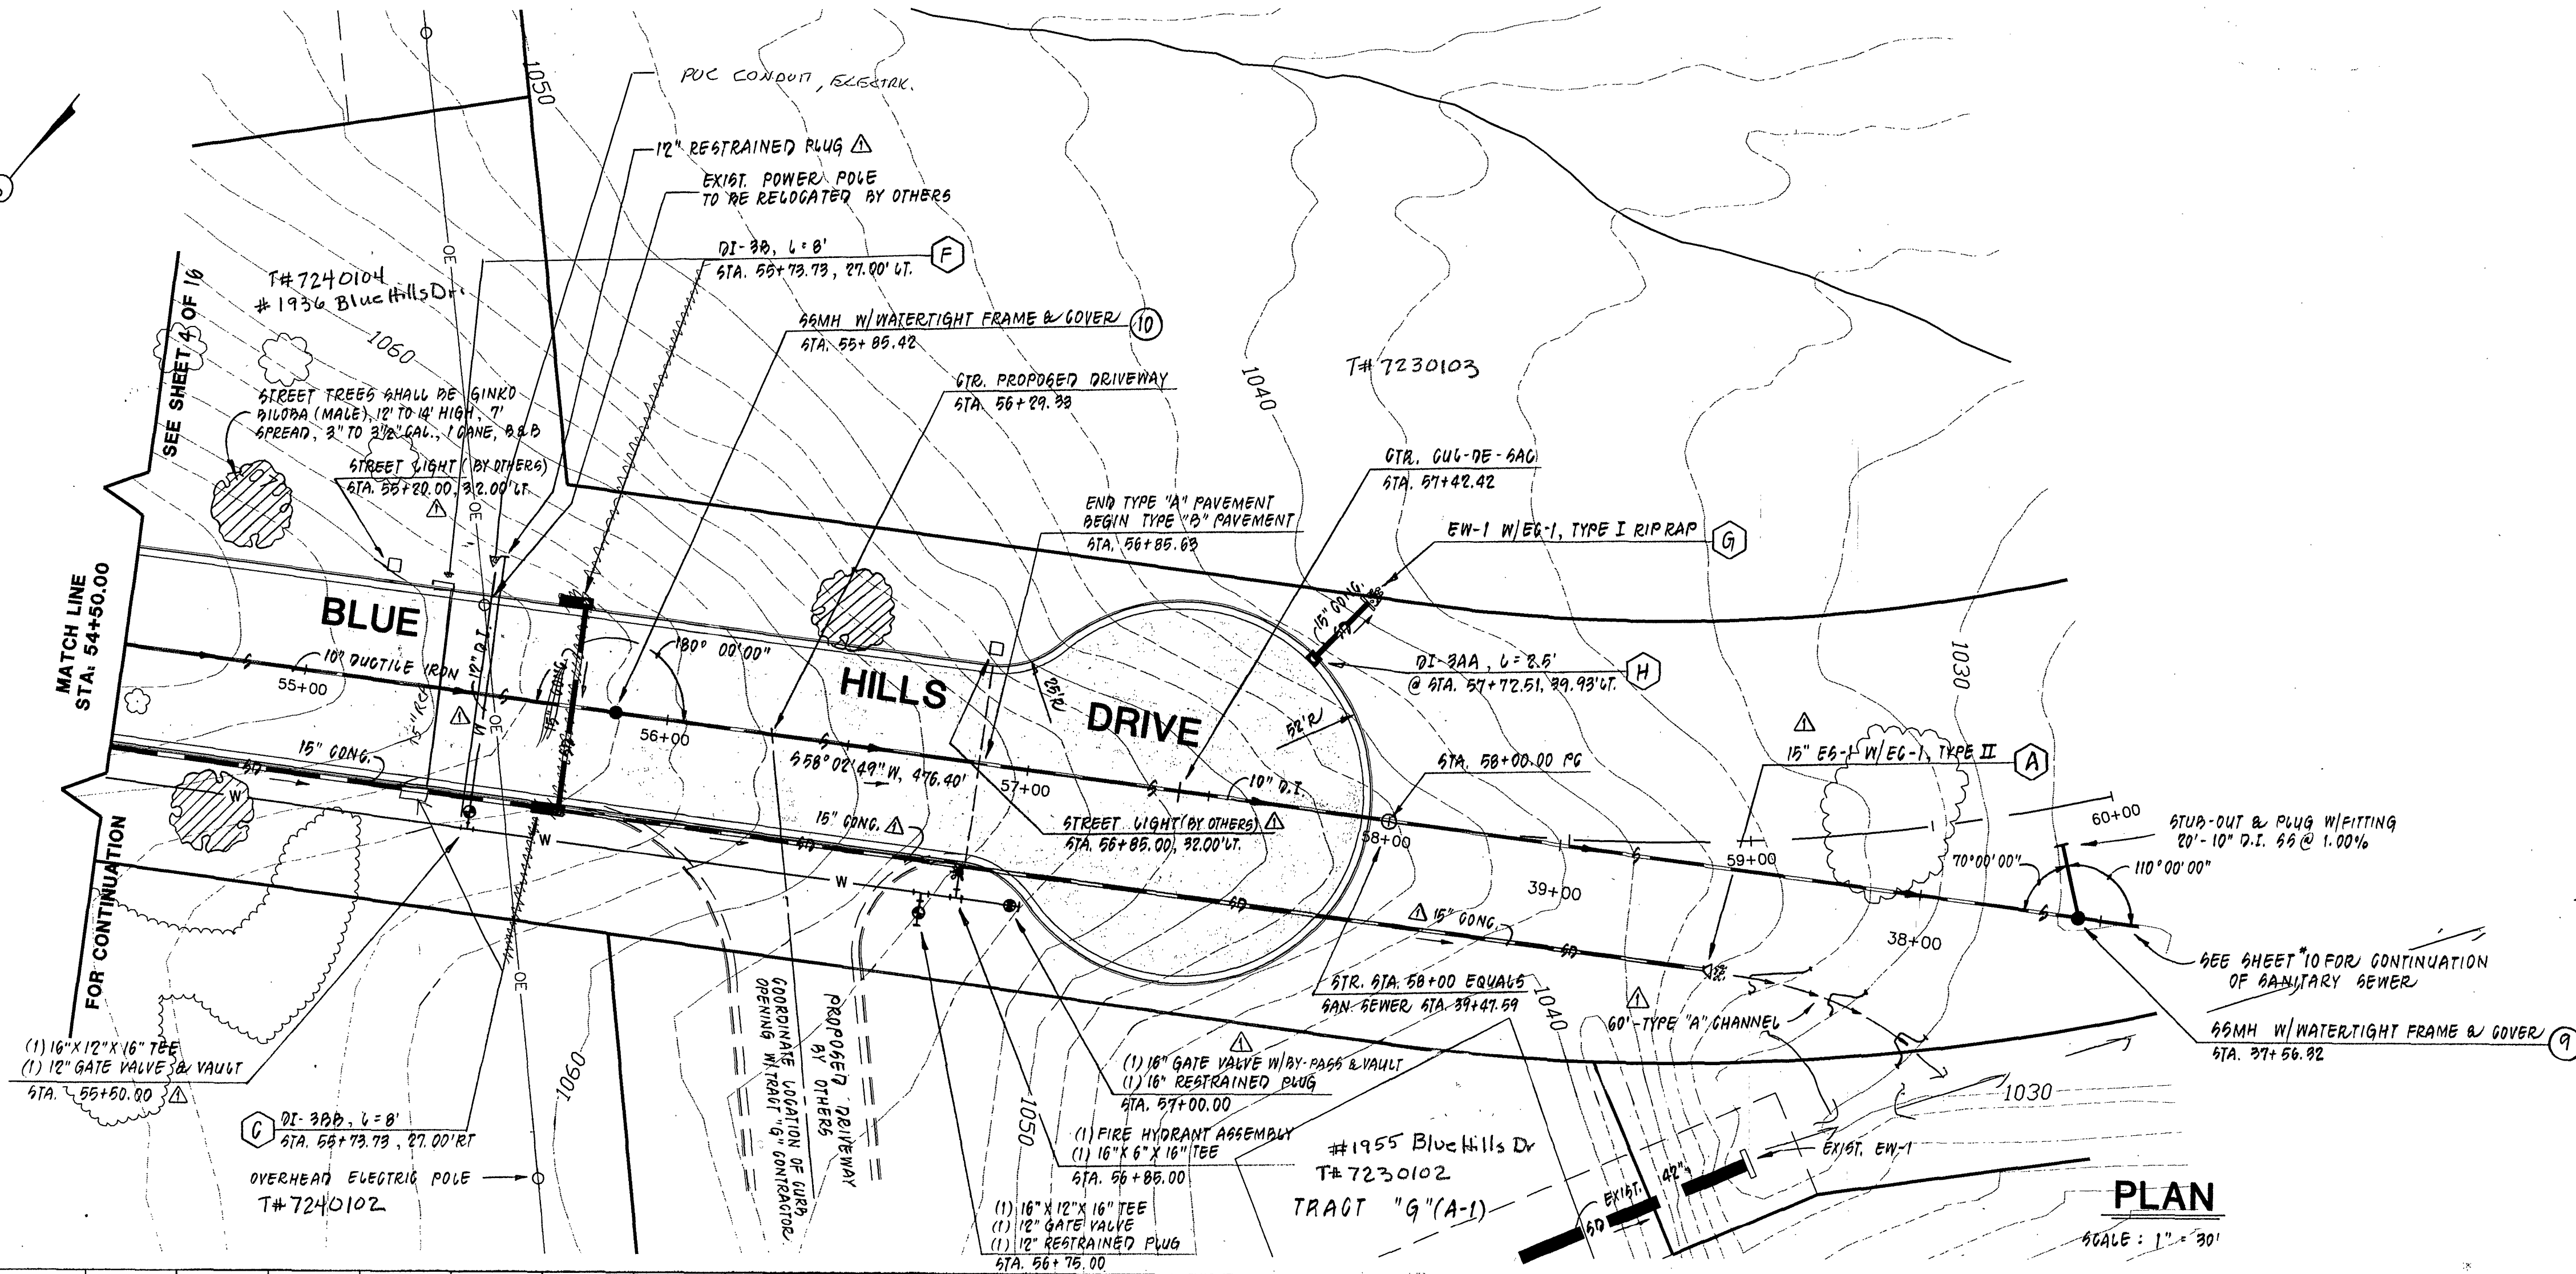

PLAN

SCALE: 1" = 30'

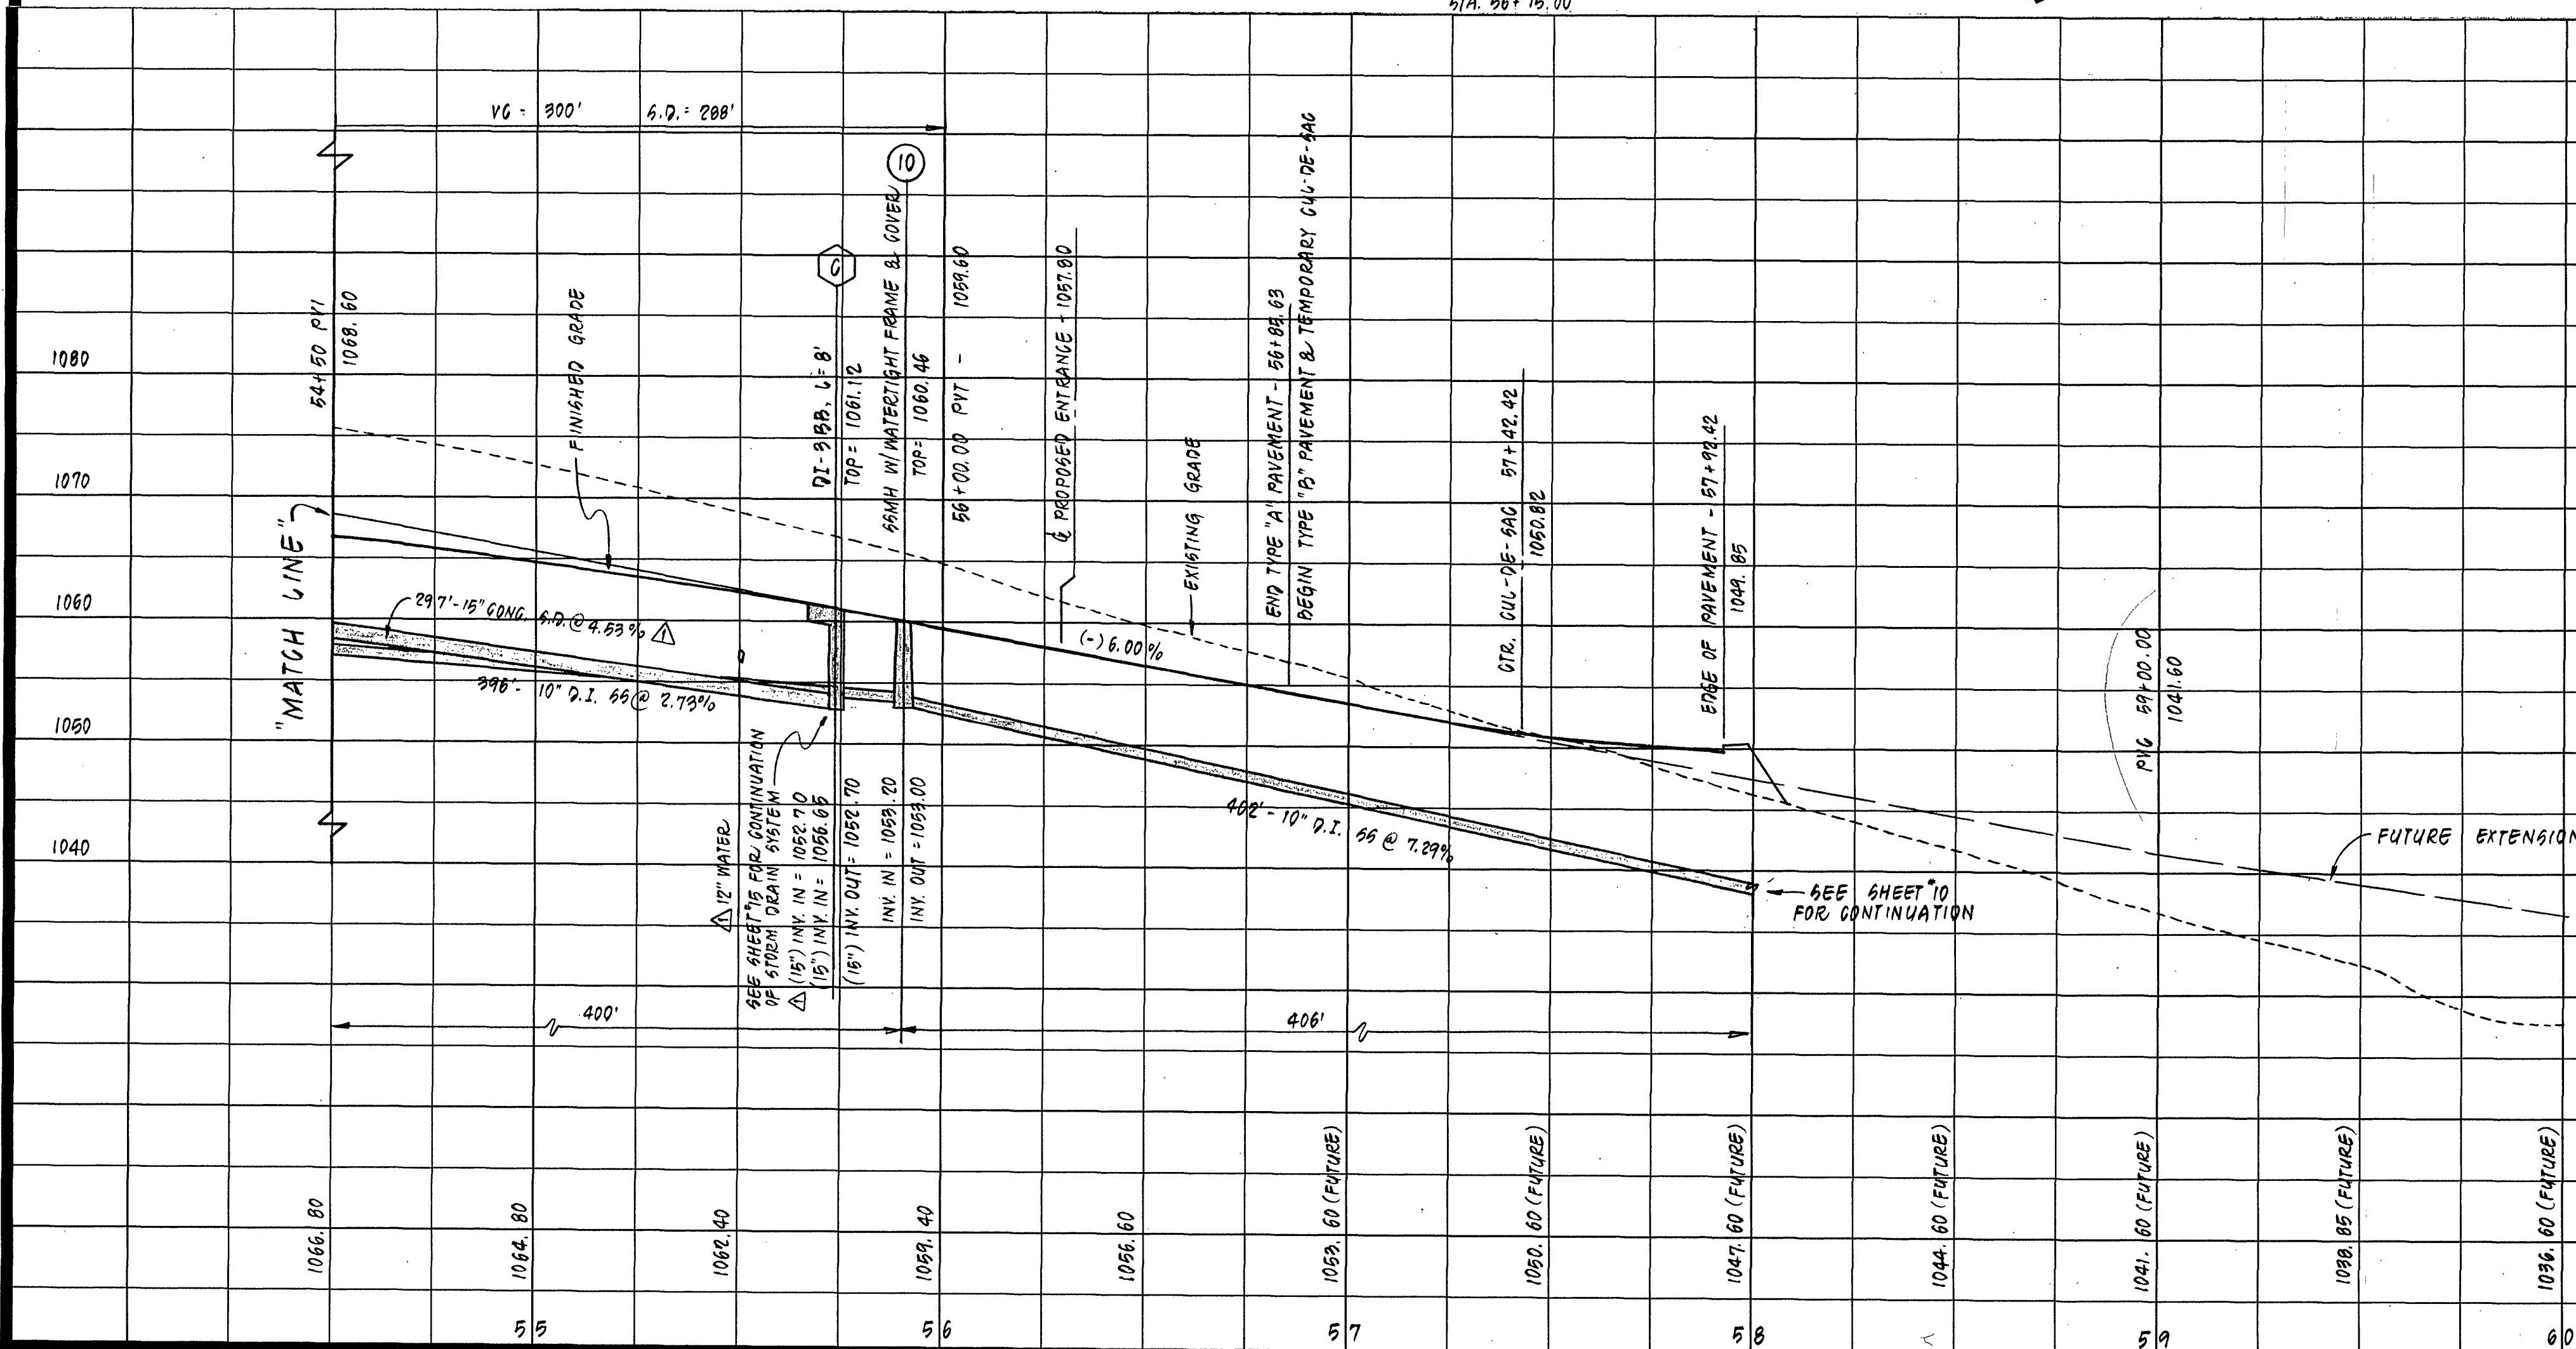

PROFILE

SCALE: 1" = 30' HORIZ.
1" = 10' VERT.

REVISION	DATE	DESCRIPTION
1	6/26/97	DELETED STREET LIGHTING FROM CONTRACT. CHANGED LOCATION OF 12" WATER LINE STUB-OUT FROM STA. 56+10.00 TO STA. 56+50.00. REVISED STORM DRAIN SYSTEM BETWEEN DRAINAGE STRUCTURES "A" & "D".
DESIGNED	KLR	BLUE HILLS DRIVE—PLAN AND PROFILE FOR "INFRASTRUCTURE IMPROVEMENTS" ROANOKE CENTRE FOR INDUSTRY AND TECHNOLOGY PREPARED FOR CITY OF ROANOKE, VIRGINIA
DRAWN	RAG, JP	
CHECKED	MSW	
LUMSDEN ASSOCIATES, P.C. ENGINEERS-SURVEYORS-PLANNERS ROANOKE, VIRGINIA		SCALE: AS NOTED DATE: 1 MAY 1997 COMM: #97-080 SHEET 5 of 16

