

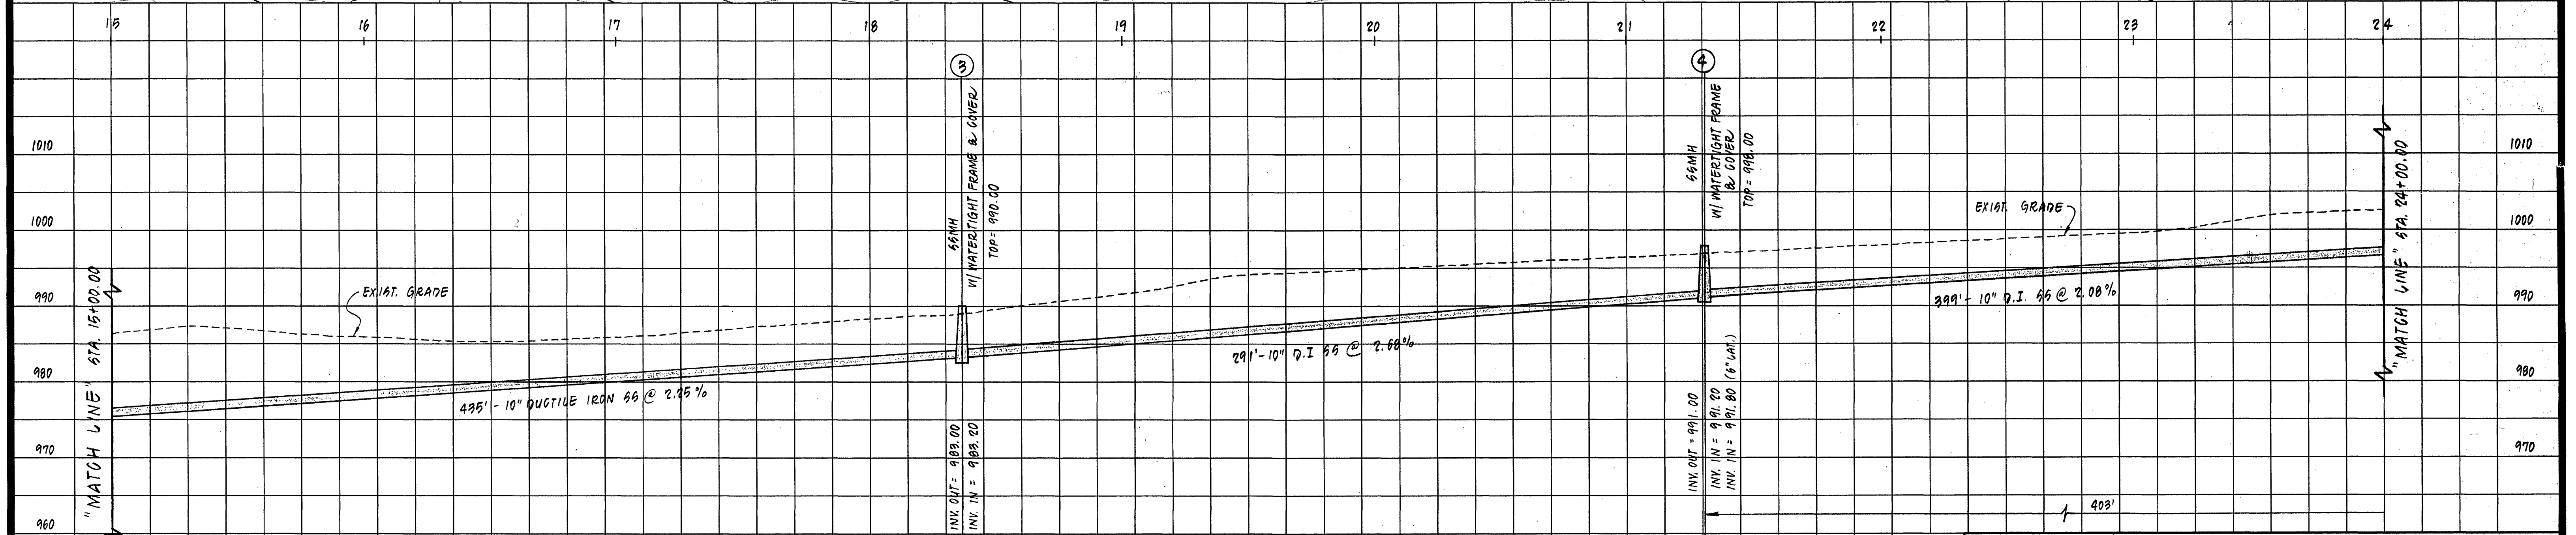


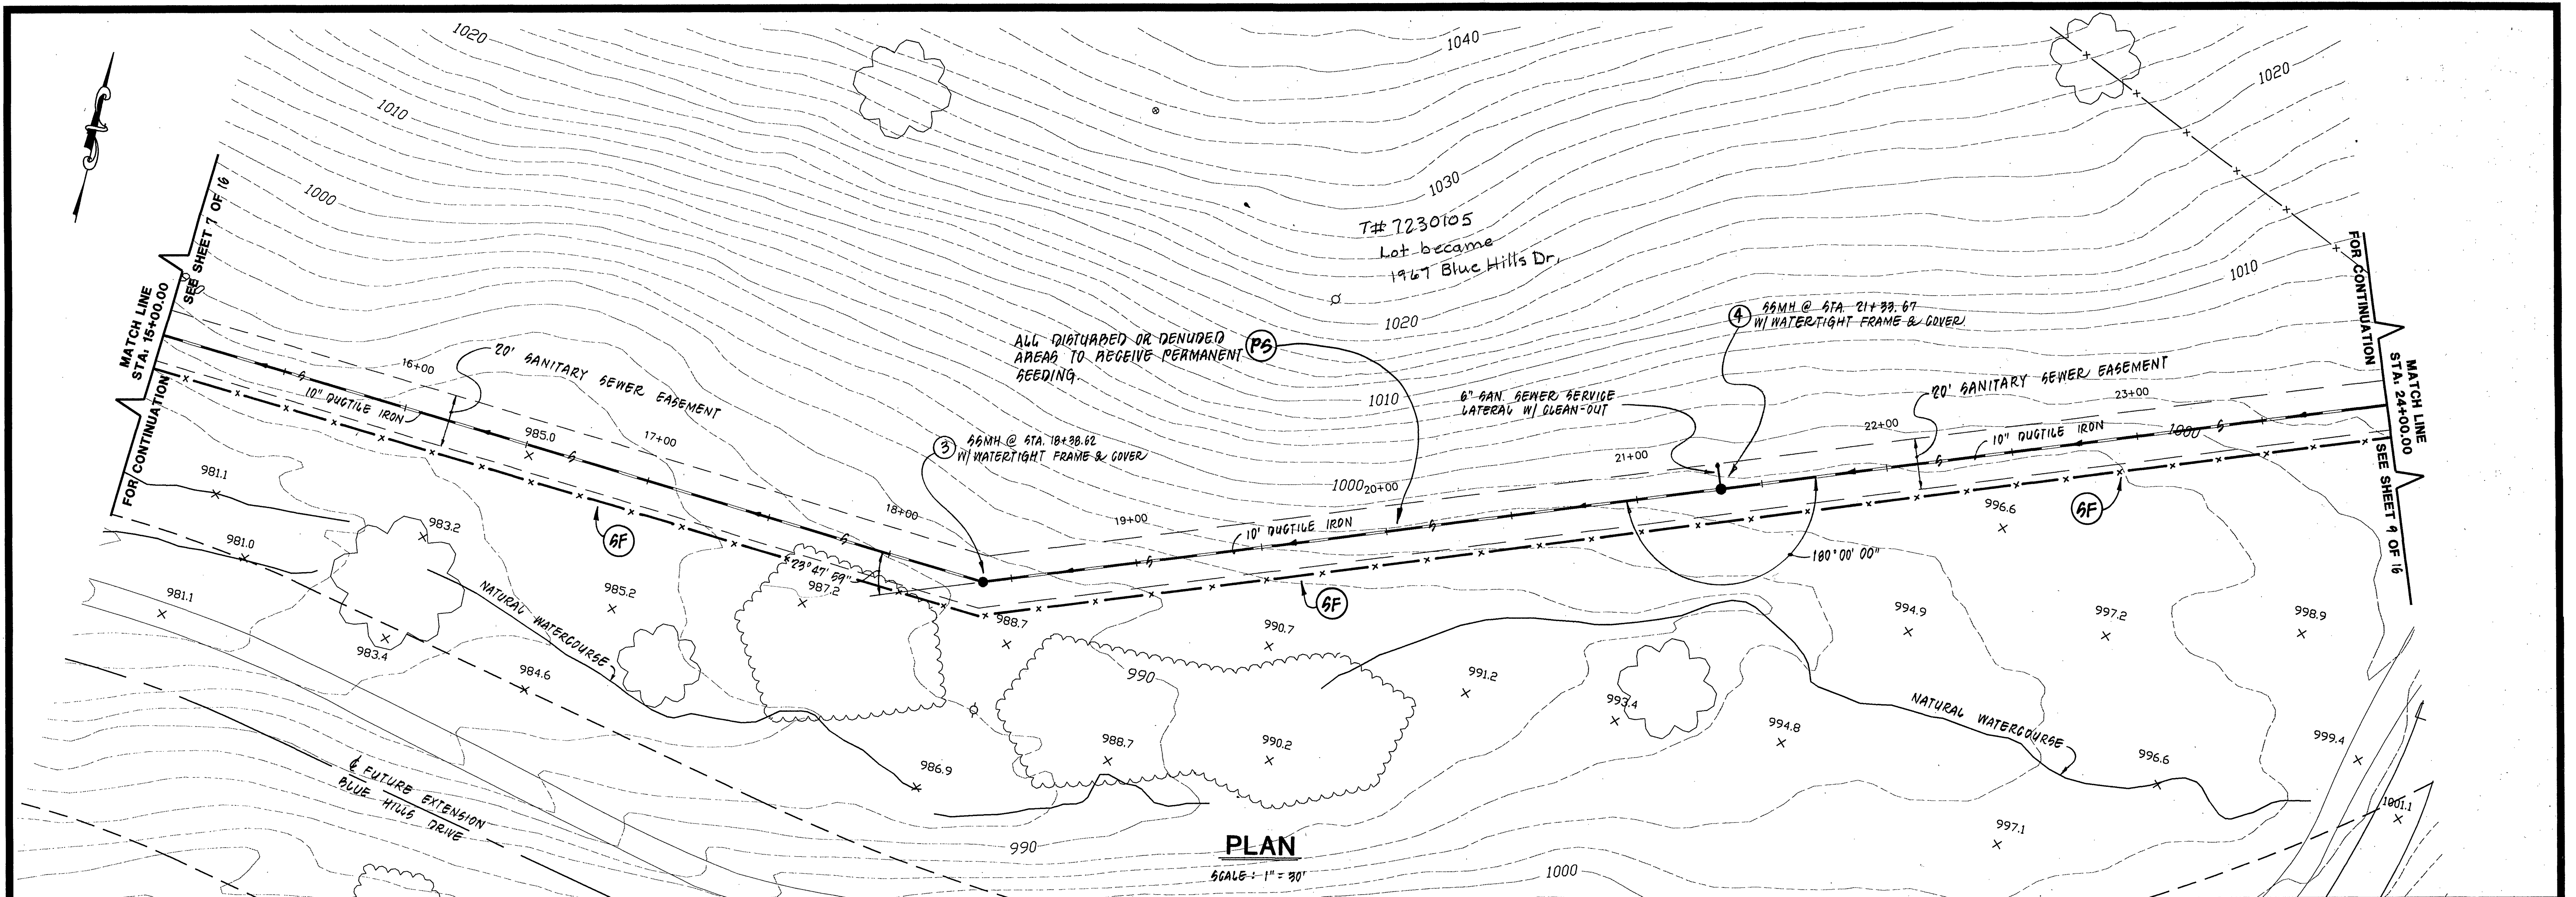

PROFILE
 SCALE: 1" = 30' HORIZ
 1" = 10' VERT.

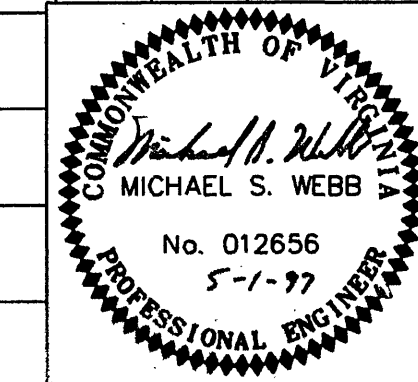

REVISION	DATE	DESCRIPTION
DESIGNED	KLR	SANITARY SEWER—PLAN AND PROFILE FOR "INFRASTRUCTURE IMPROVEMENTS" ROANOKE CENTRE FOR INDUSTRY AND TECHNOLOGY PREPARED FOR CITY OF ROANOKE, VIRGINIA
DRAWN	RAG, JF	
CHECKED	MSW	
LUMSDEN ASSOCIATES, P.C. ENGINEERS—SURVEYORS—PLANNERS ROANOKE, VIRGINIA		SCALE: AS SHOWN DATE: 1 MAY 1997
		COMM: #97-080 SHEET 8 of 16