

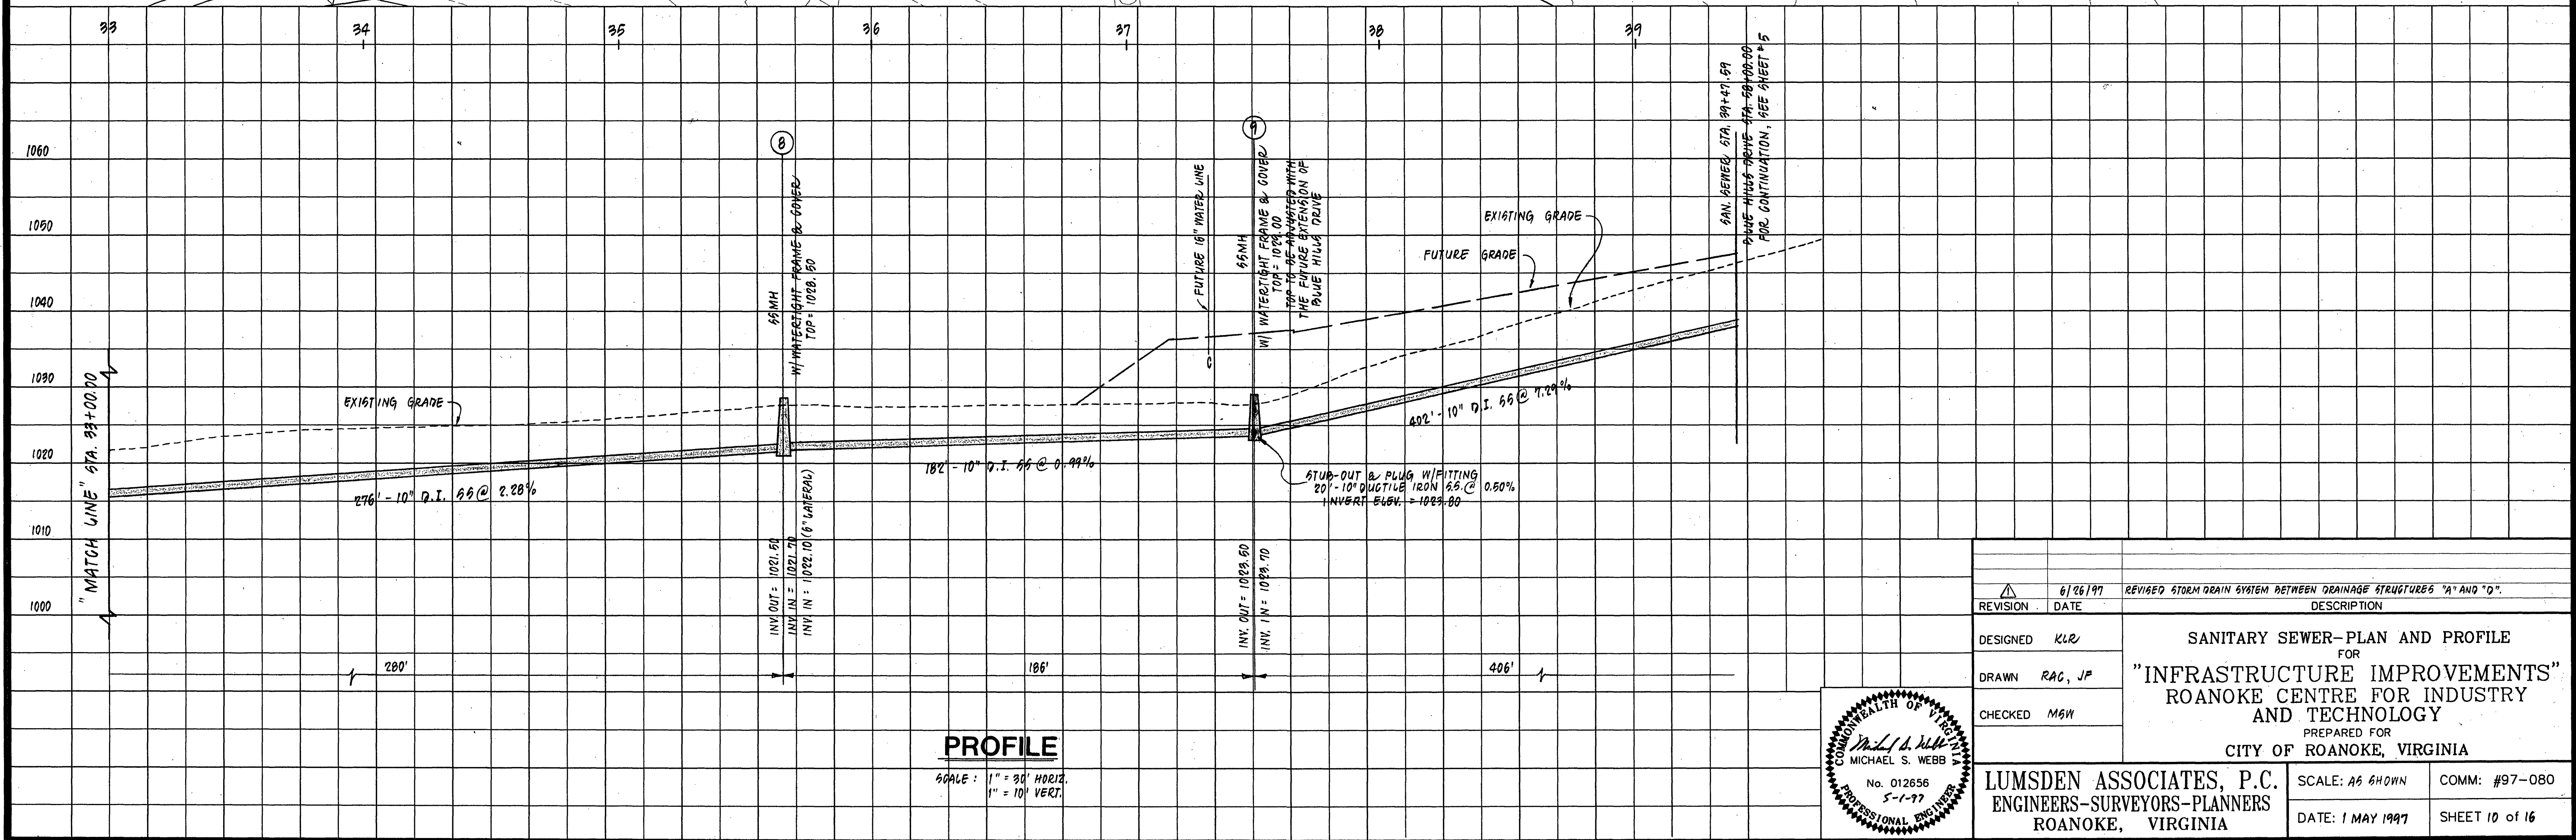


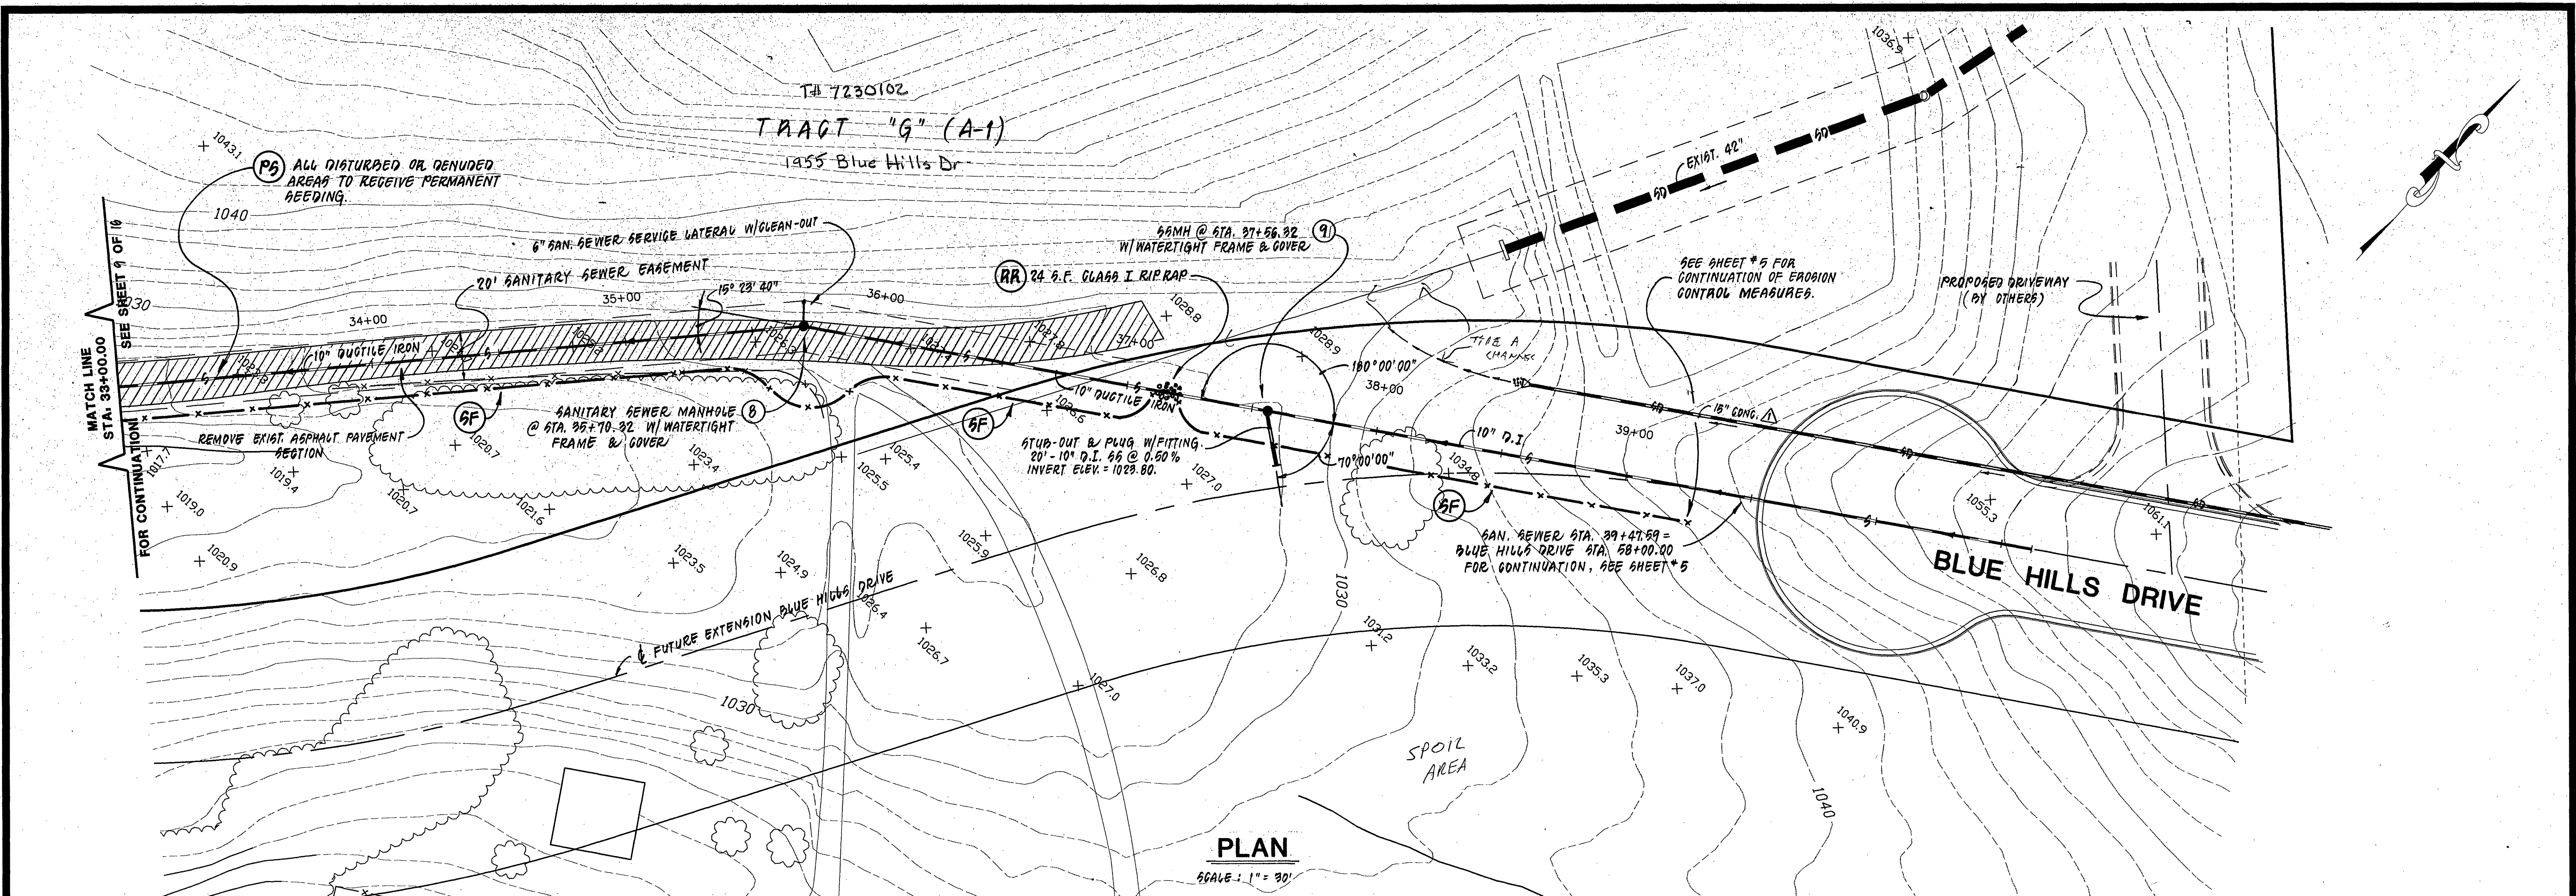

REVISION	DATE	DESCRIPTION
1	6/26/97	REVISED STORM DRAIN SYSTEM BETWEEN DRAINAGE STRUCTURES "A" AND "D".
DESIGNED	KLR	SANITARY SEWER-PLAN AND PROFILE FOR "INFRASTRUCTURE IMPROVEMENTS" ROANOKE CENTRE FOR INDUSTRY AND TECHNOLOGY PREPARED FOR CITY OF ROANOKE, VIRGINIA
DRAWN	RAC, JP	
CHECKED	MSW	
LUMSDEN ASSOCIATES, P.C. ENGINEERS-SURVEYORS-PLANNERS ROANOKE, VIRGINIA		SCALE: AS SHOWN DATE: 1 MAY 1997 COMM: #97-080 SHEET 10 of 16

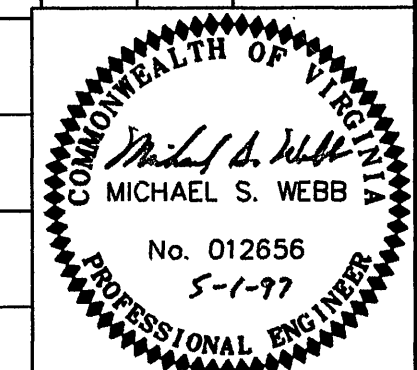

L:\1997\0000\ENG\225504 510559.dwg PLOT 11 03:28:31 1997