


[illegible]

ROANOKE, VIRGINIA






ALL RIGHTS RESERVED. NO PART OF THIS WORK
MAY BE USED, REPRODUCED, DISTRIBUTED,
DISPLAYED, OR COMMUNICATED IN ANY WAY,
FORM, OR BY ANY MEANS WITHOUT THE PRIOR
WRITTEN CONSENT OF
MAPLE LEAF FOODS INC.

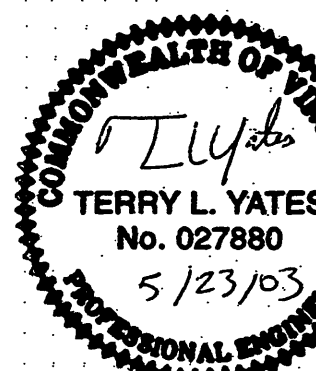


TITLE:

GRADING, DIMENSIONAL,
UTILITY, AND STORM PIPING
PLAN AND PROFILES


PLANT ADDRESS: MB-ROA250-		CAD FILE: 12011C2-01.DWG	
DRAWN BY: CNM		DATE: 5-22-03	
CHECKED BY:		DATE:	
SCALE: AS NOTED		E	DRAWING NO: C2-01
DATE PLOTTED:			

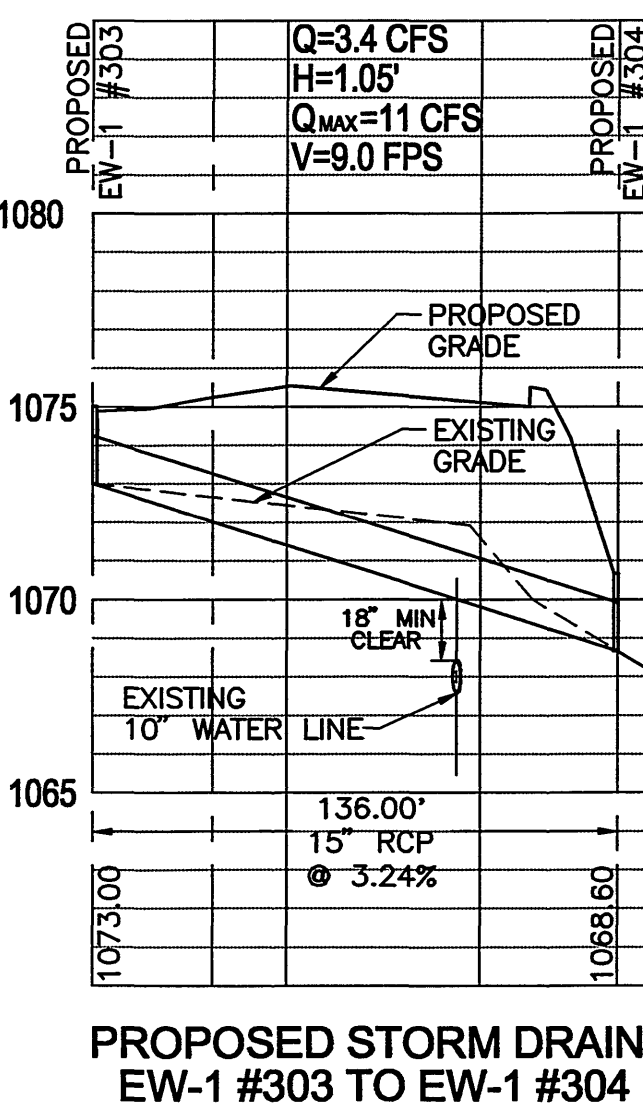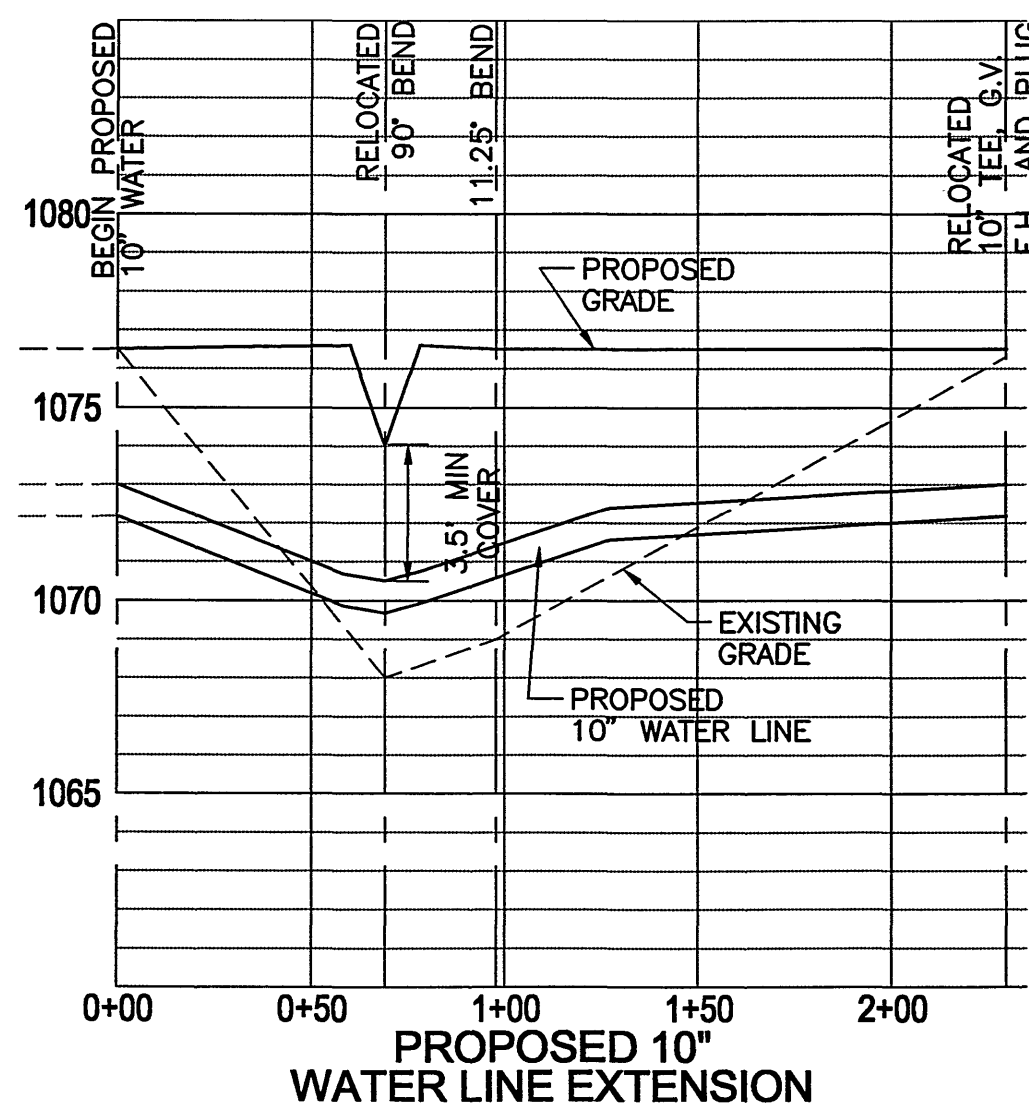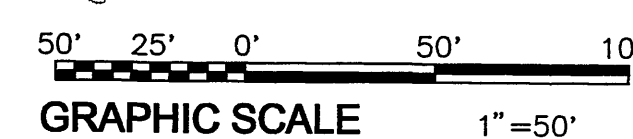

**PROPOSED STORM DRAIN
EW-1 #303 TO EW-1 #304**

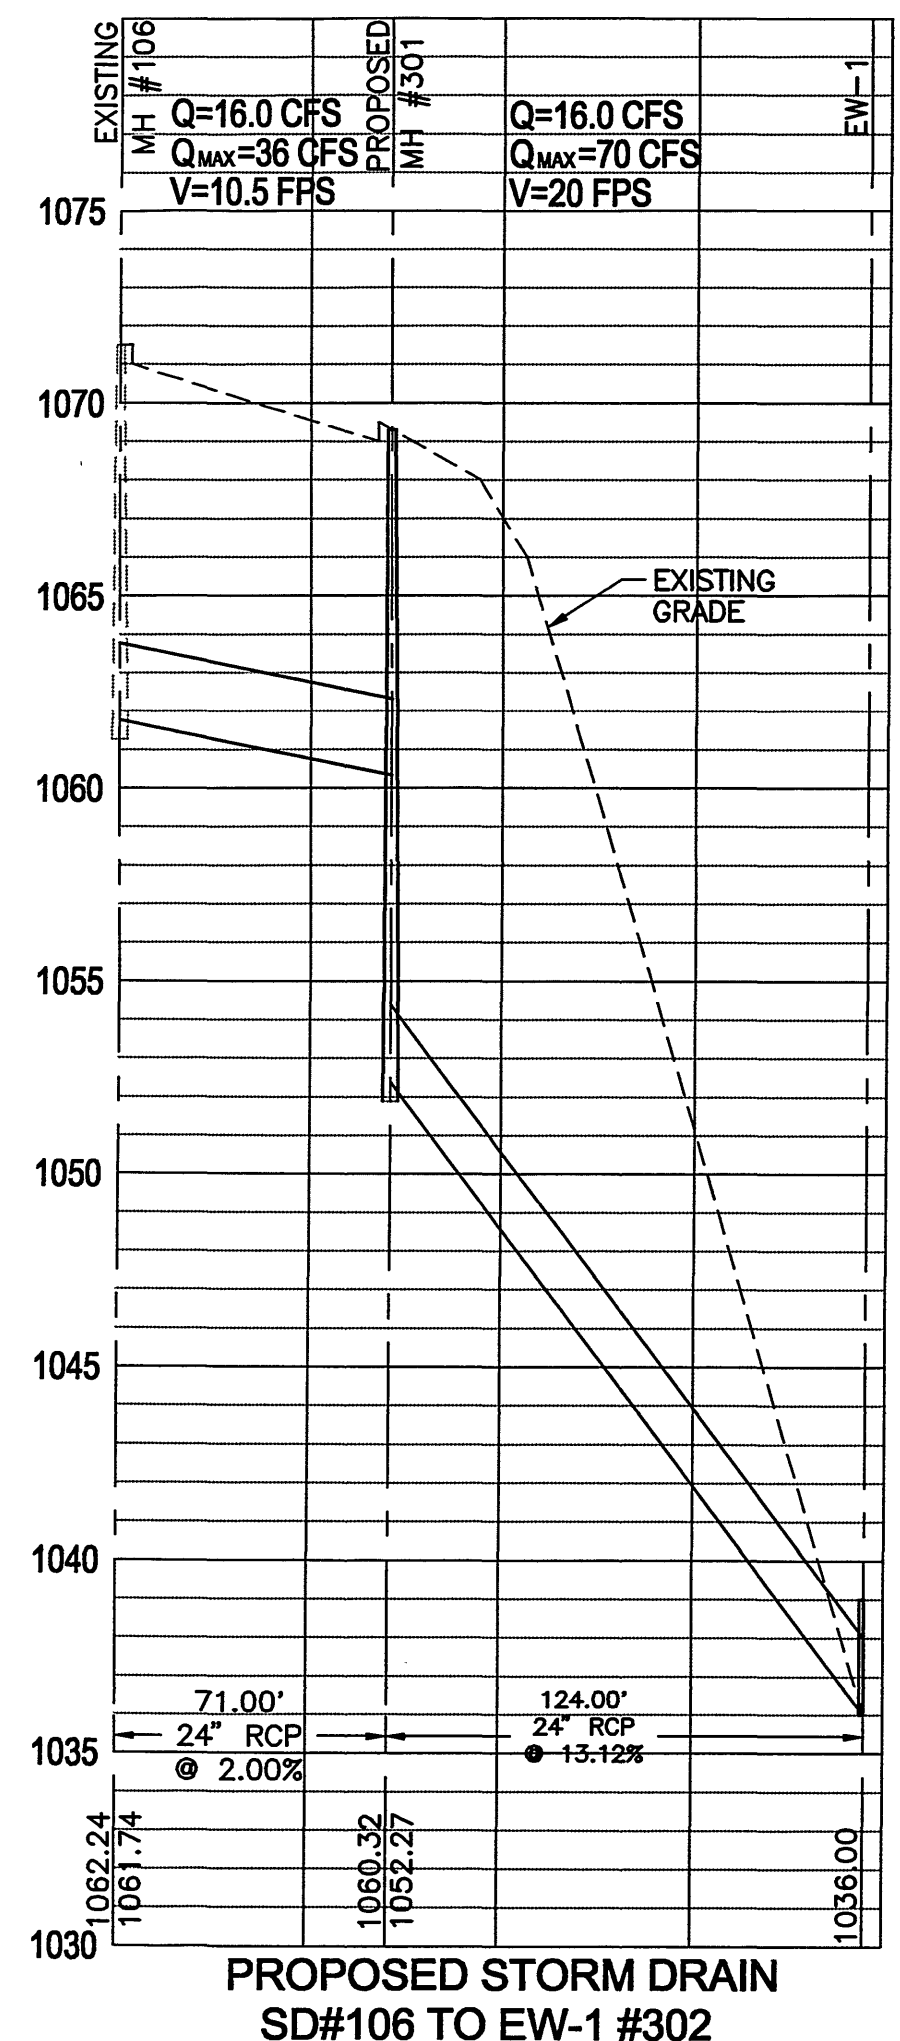

PROPOSED STORM DRAIN
SD#106 TO EW-1 #302

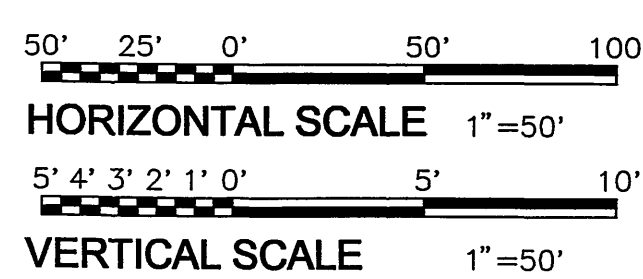

VERTICAL SCALE 1"=50'