
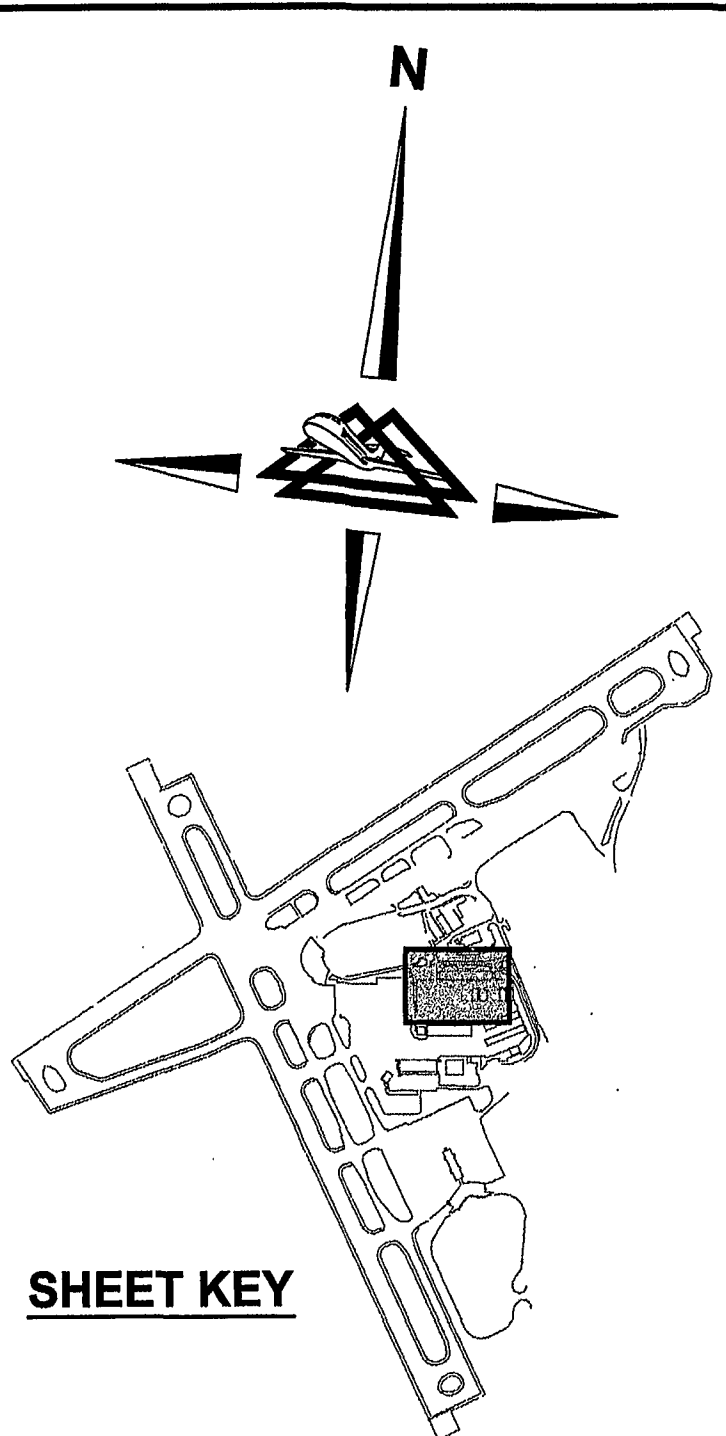


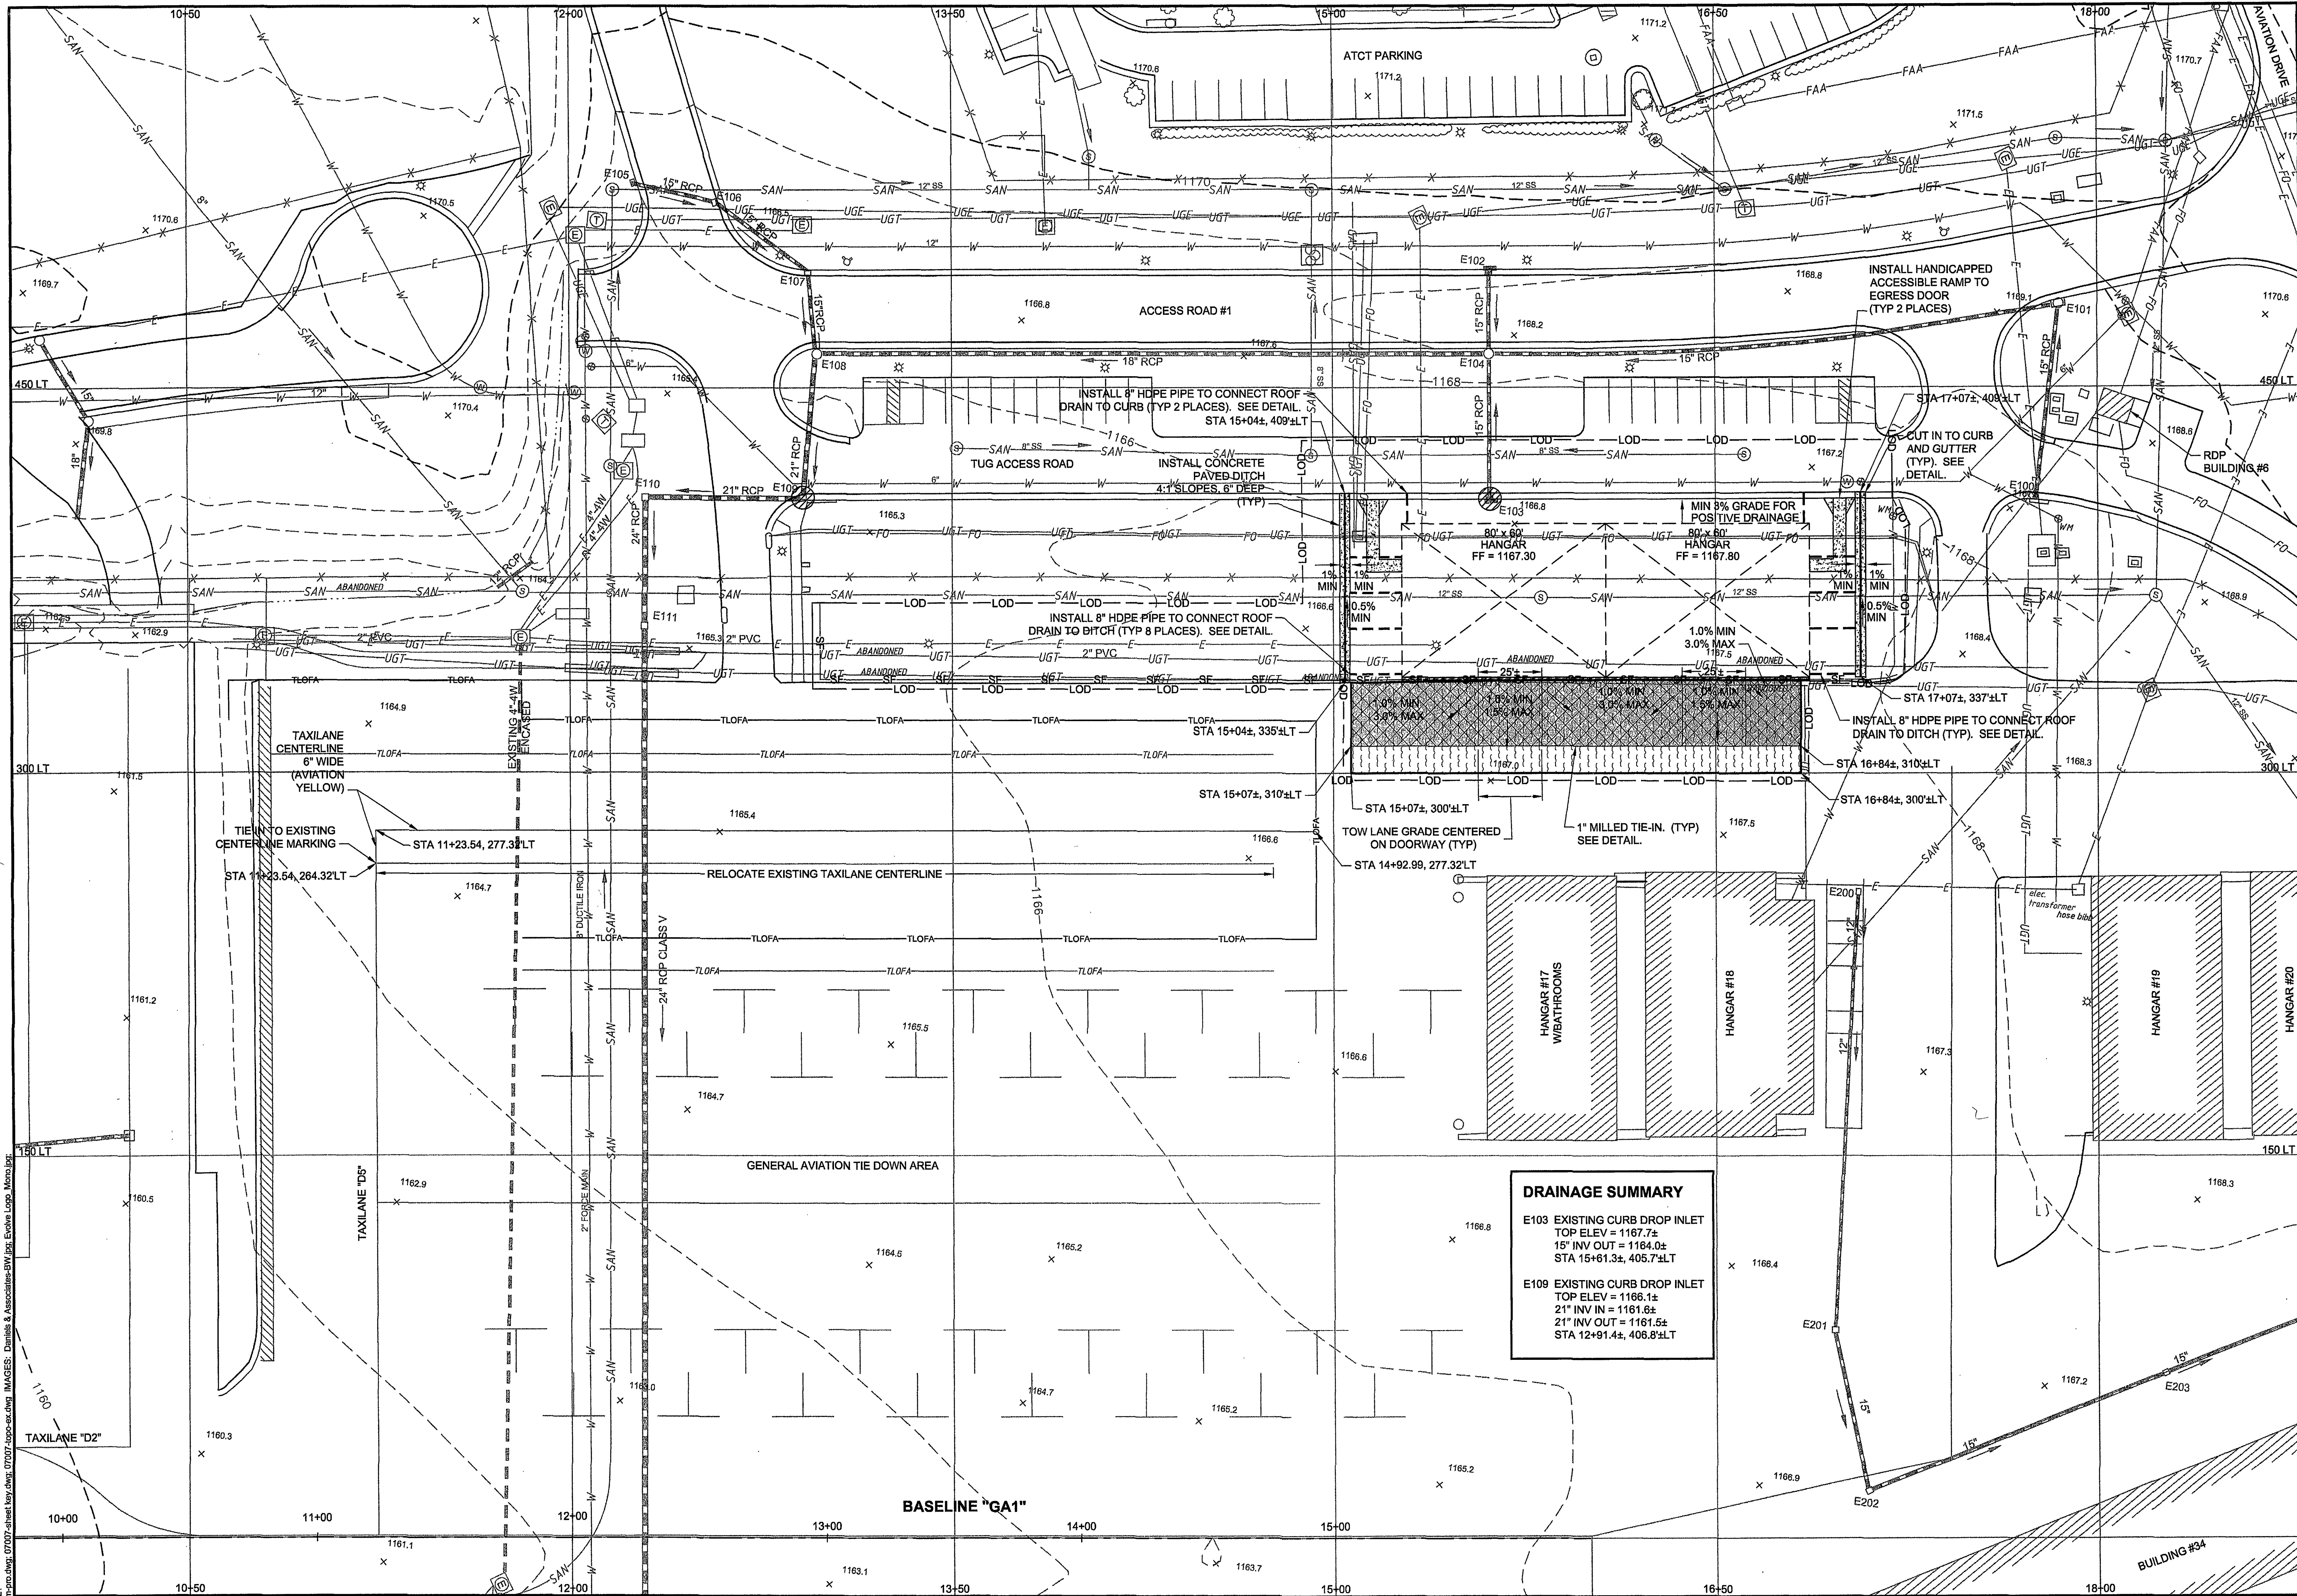

SHEET KEY

LEGEND

- ⊙ EXISTING PULLCAN
- ⊕ EXISTING ELECTRICAL MANHOLE
- ⊕ EXISTING TELEPHONE PEDESTAL
- ⊕ EXISTING SEWER LINE MANHOLE
- ⊕ EXISTING WATER LINE MANHOLE
- ⊕ EXISTING MANHOLE
- ⊕ EXISTING DROP INLET
- ⊕ INLET PROTECTION (IP 3.07)
- EXISTING FENCE
- EXISTING FIBER OPTICS
- EXISTING SANITARY SEWER LINE
- EXISTING WATER LINE
- EXISTING UNDERGROUND ELECTRIC LINE
- EXISTING UNDERGROUND TELEPHONE LINE
- EXISTING STORM DRAIN
- PROPOSED ROOF DRAIN
- LOD LIMITS OF DISTURBANCE/WORK
- SF PROPOSED SILT FENCE (SF 3.05)
- TLOFA TAXILANE OBJECT FREE AREA
- Variable Depth Mill and 2" Min Overlay
- Proposed Concrete
- Hangar Entrance Pavement
- Seal Coat

- NOTES:
- STATIONS AND OFFSETS ARE BASED ON BASELINE "GA1".
 - BUILDING DIMENSIONS SHOWN ARE APPROXIMATE.
 - PAVING LIMITS SHOWN ARE APPROXIMATE.
 - UTILITY LOCATIONS SHOWN ARE APPROXIMATE.
 - BUILDING REVIEW NOTE - BATHROOM FACILITIES ARE LOCATED IN HANGAR 17.

30 0 30 60
SCALE: 1"=30'
FEET

NO.	REVISIONS	BY	APP.	DATE



1111 East Main Street
Suite 150
Richmond, VA 23219
Tel: (804) 649-9400
Fax: (804) 649-9475
evolvearchitecture.com



DANIELS & ASSOCIATES, P.C.
Consulting Engineers
9307 Brook Road
Glen Allen, Virginia 23060
(804) 553-1283 Fax: (804) 553-1096



**DELTA AIRPORT
CONSULTANTS, INC.**

9711 Farrar Court, Suite 100 • Richmond, VA 23236
phone: (804) 275-8301 • fax: (804) 275-8371 • www.deltairport.com



CONSTRUCT HANGARS

SITE PLAN

ROANOKE REGIONAL AIRPORT

AIP NO.	NON-AIP	JOB NO.
		VA 07007
DRAWN BY:	PJW	SHEET
DESIGNED BY:	JKB	5
		OF
		13
SCALE:	1"=30'	DATE:
		JUNE 2007