

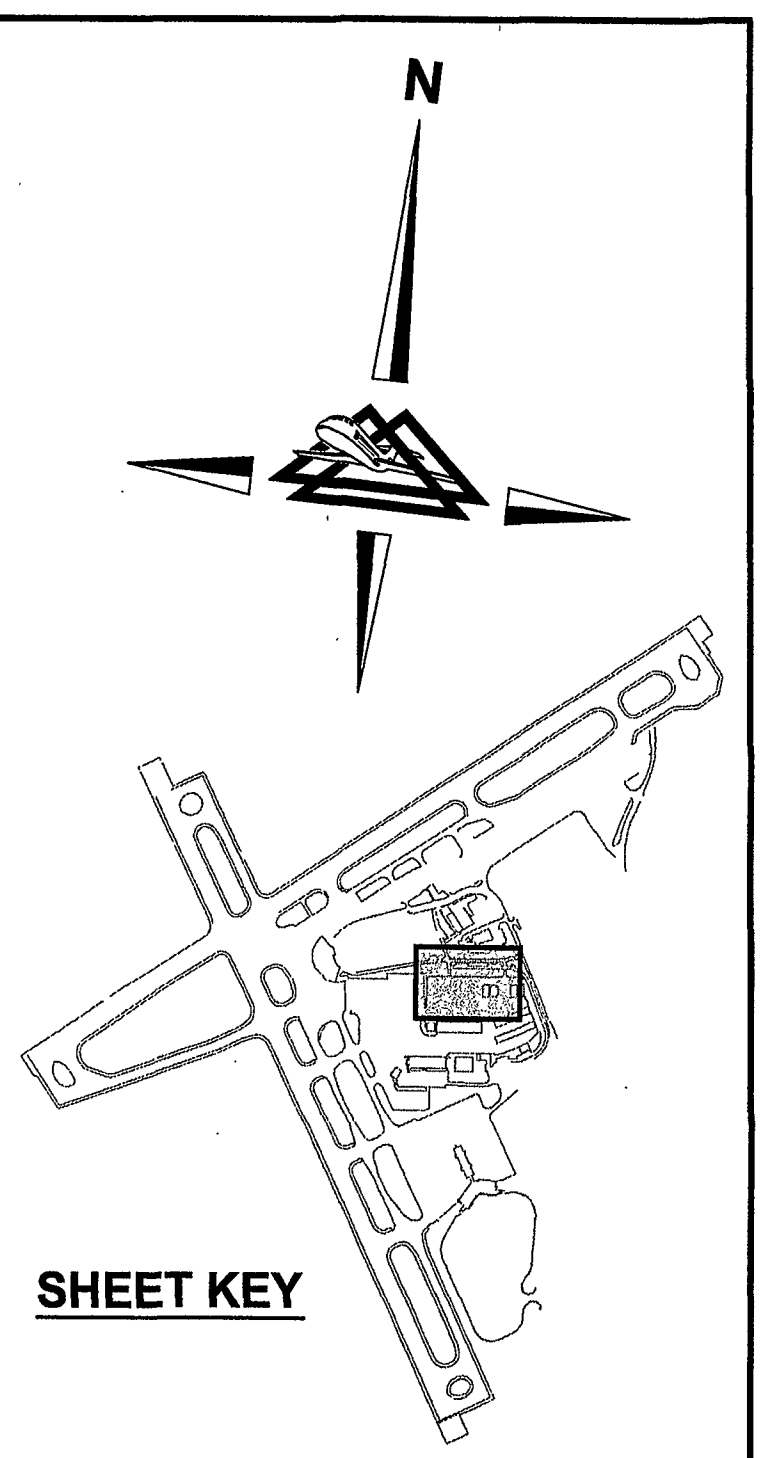


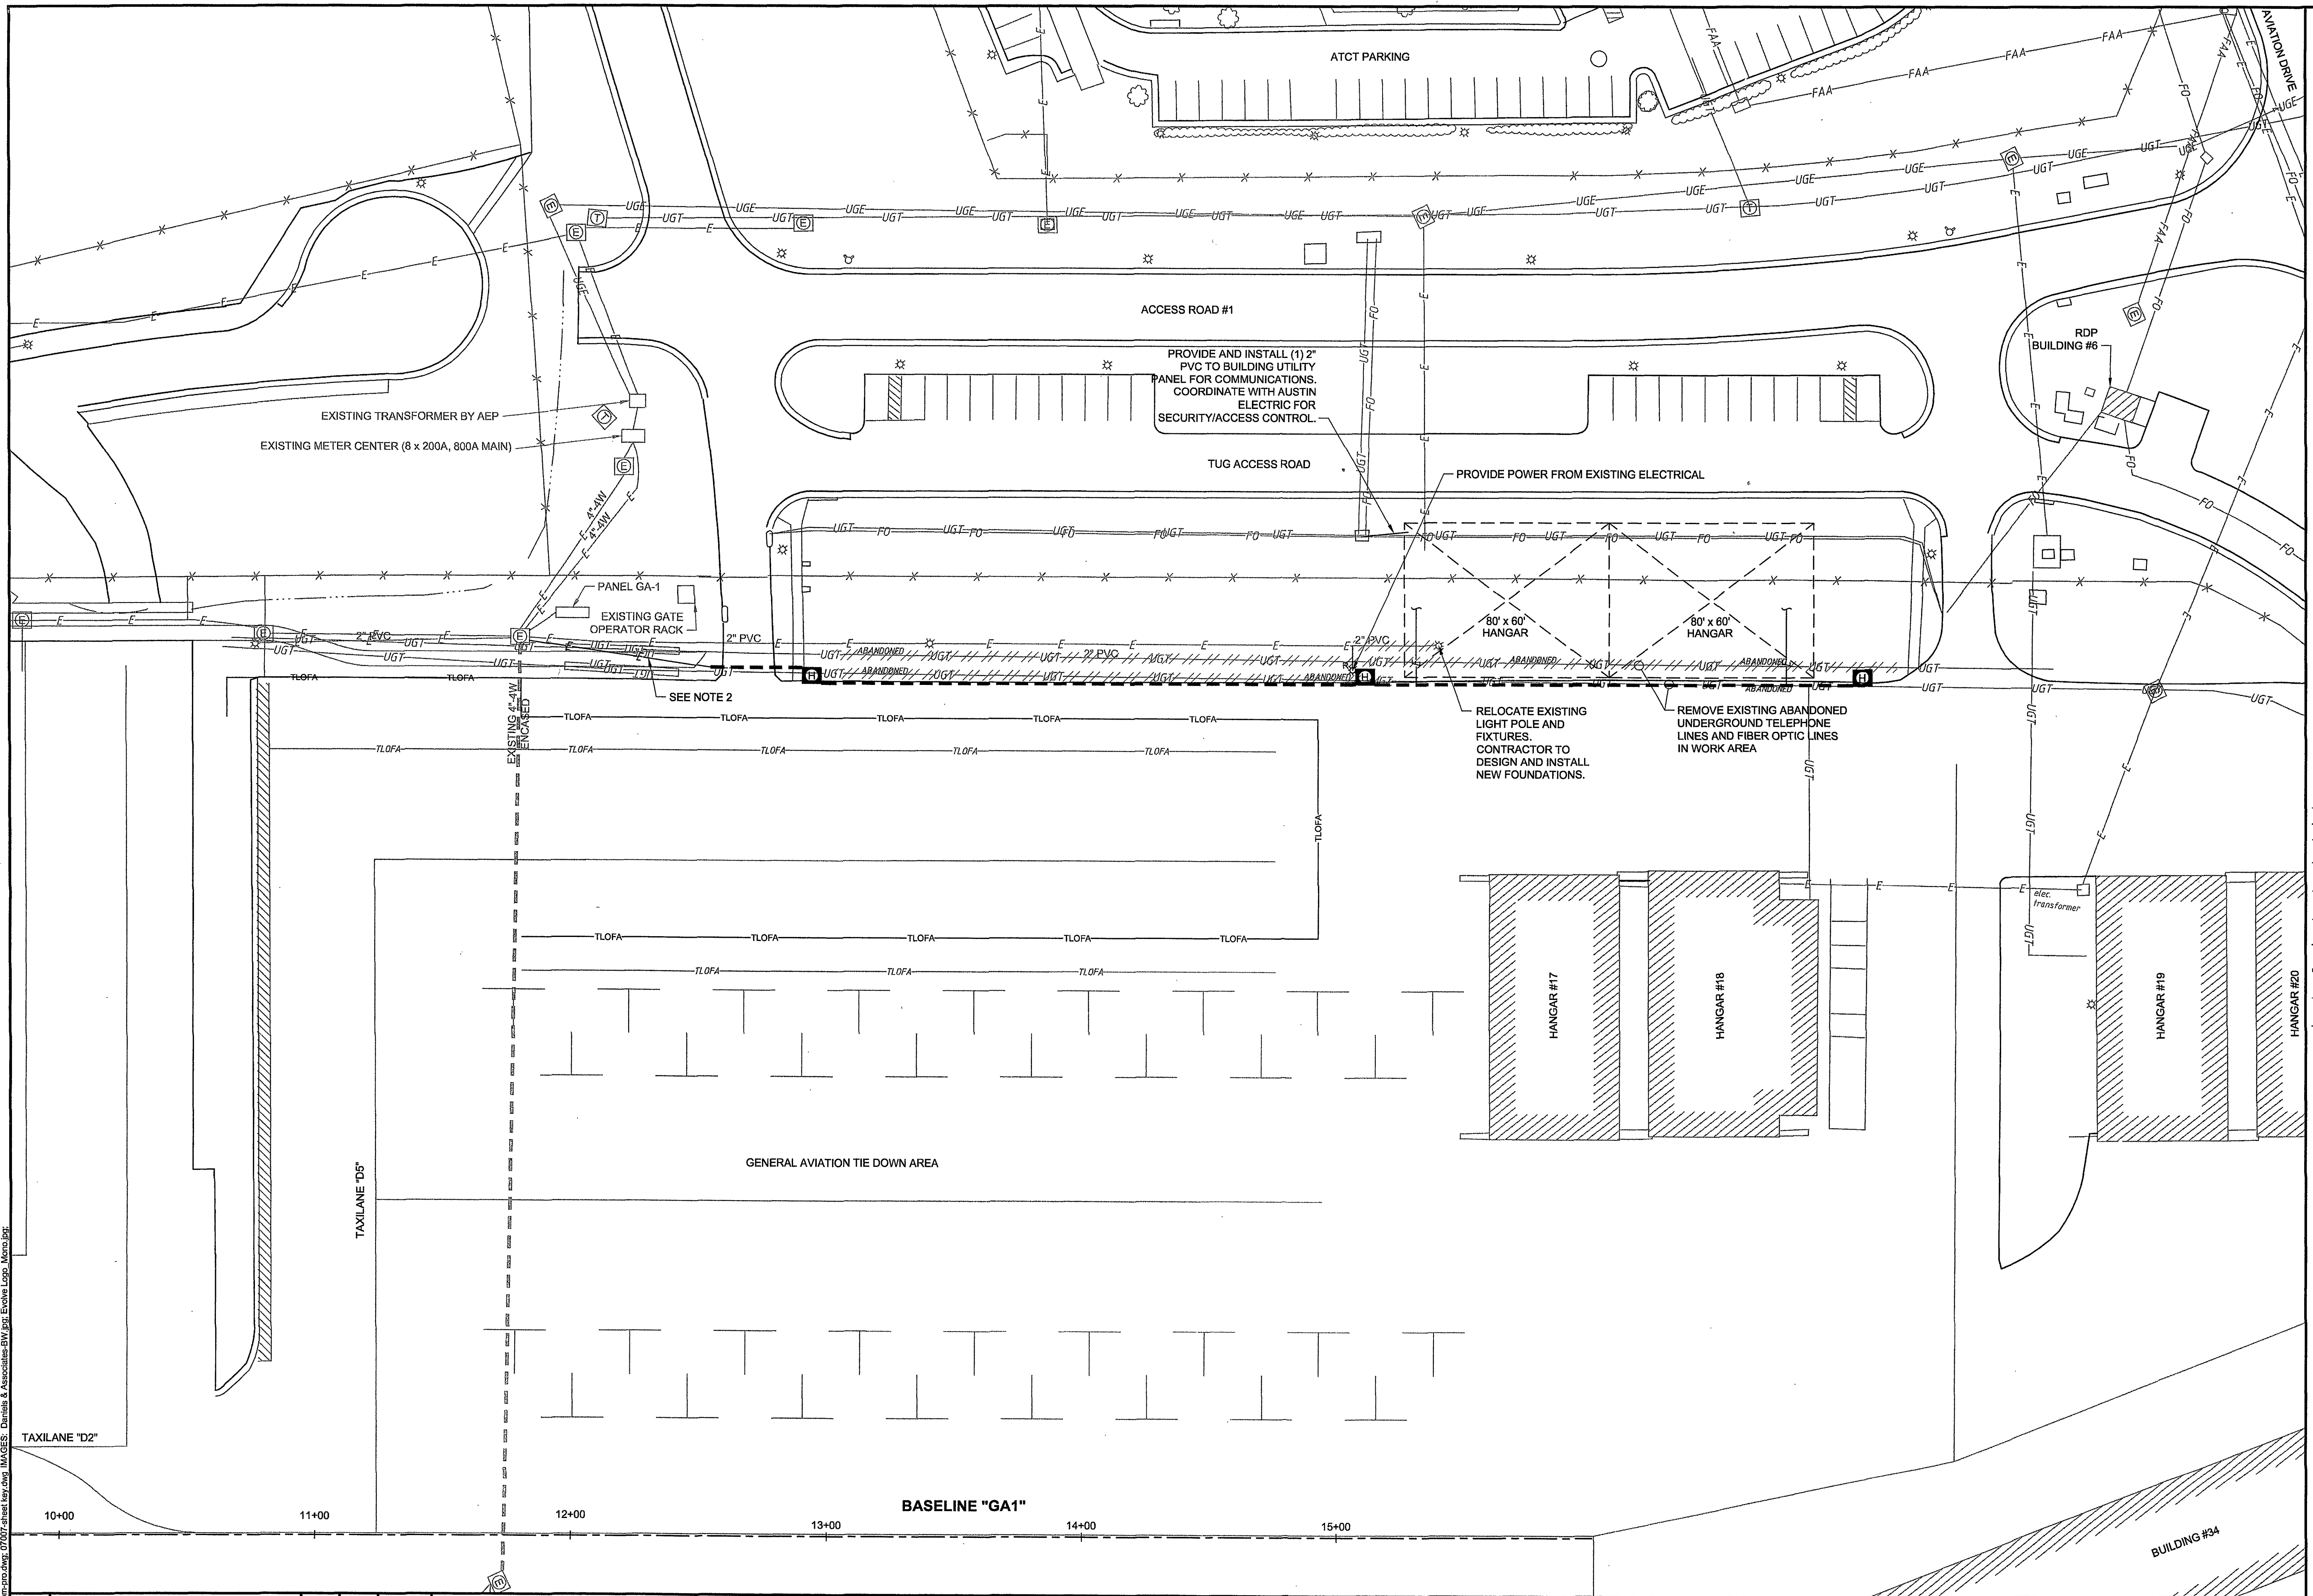

SHEET KEY

- LEGEND**
- EXISTING LIGHT POLE
 - RELOCATED LIGHT POLE
 - EXISTING ELECTRICAL MANHOLE
 - PROPOSED ELECTRICAL HANDHOLE
 - EXISTING TELEPHONE PEDESTAL
 - EXISTING FENCE
 - TAXILANE OBJECT FREE AREA
 - EXISTING FIBER OPTICS
 - EXISTING UNDERGROUND ELECTRIC LINE OWNED BY POWER COMPANY
 - EXISTING ELECTRIC LINE OWNED BY AIRPORT
 - EXISTING UNDERGROUND ELECTRIC LINE TO BE REMOVED
 - PROPOSED ELECTRIC LINE OWNED BY AIRPORT
 - CONCRETE ENCASED CONDUIT
 - EXISTING UNDERGROUND TELEPHONE LINE
 - EXISTING UNDERGROUND TELEPHONE LINE TO BE REMOVED


- NOTES:**
- UTILITY LOCATIONS SHOWN ARE APPROXIMATE.
 - INSTALL (2) 3" PVC CONDUITS AND UPDATE METER CENTER FOR SERVICE TO:
1 - TENANT 1
2 - TENANT 2
5 - FLOOD LIGHT - FUTURE USE

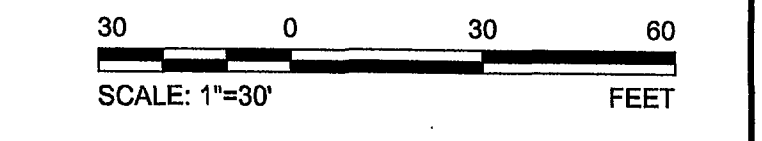

NO.	REVISIONS	BY	APP.	DATE
1	ADDENDUM NO. ONE (1)	PJW	MWK	7/17/07

EVOLVE
CONSULTANTS, P.C.
1111 East Main Street
Suite 150
Richmond, VA 23219
Tel: (804) 649-9400
Fax: (804) 649-9475
evolvearchitecture.com

DELTA AIRPORT CONSULTANTS, INC.
9711 Farrar Court, Suite 100 • Richmond, VA 23236
phone: (804) 275-8301 • fax: (804) 275-8371 • www.deltairport.com

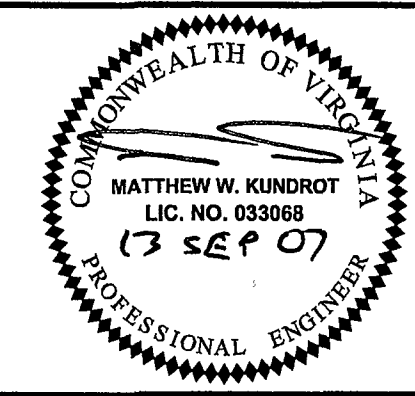

CONSTRUCT HANGARS		AIP NO.	NON-AIP	JOB NO.
SITE ELECTRICAL PLAN		DRAWN BY:	PJW	VA 07007
		DESIGNED BY:	JKB	SHEET 7 OF 13
ROANOKE REGIONAL AIRPORT		SCALE:	DATE:	
		1"=30'	JUNE 2007	