




OVERFLOW PARKING LOT MODIFICATIONS AND ADDITIONS

ROANOKE REGIONAL AIRPORT
ROANOKE, VIRGINIA


PREPARED FOR
ROANOKE REGIONAL AIRPORT COMMISSION
JANUARY, 2002
RRAC BID NO. 01-010

SHEET LIST:


- C1. COVER SHEET
- C2. ABBREVIATIONS & LEGEND
- C3. OVERALL AIRPORT PLAN & GENERAL NOTES
- C4. EXISTING SITE CONDITIONS/DEMOLITION PLAN
- C5. SITE PLAN-AREA 'A'
- C6. SITE PLAN-AREA 'B'
- C7. GRADING & STORM DRAINAGE-AREA 'A'
- C8. GRADING & STORM DRAINAGE-AREA 'B'
- C9. UTILITY DETAIL & CONTROL LAYOUT
- C10. EROSION & SEDIMENT CONTROL
- C11. STORM DRAIN PROFILES & RETAINING WALL PROFILE
- C12. TYPICAL SECTIONS
- C13. MISCELLANEOUS DETAILS
- C14. MISCELLANEOUS DETAILS
- C15. EROSION & SEDIMENT CONTROL DETAILS
- E1. ELECTRICAL LAYOUT
- E2. ELECTRICAL DETAILS
- E3. TICKET BOOTH COMMUNICATIONS CONDUIT
- A1. CANOPY DETAILS
- A2. TICKET BOOTH DETAILS
- A3. TICKET BOOTH DETAILS

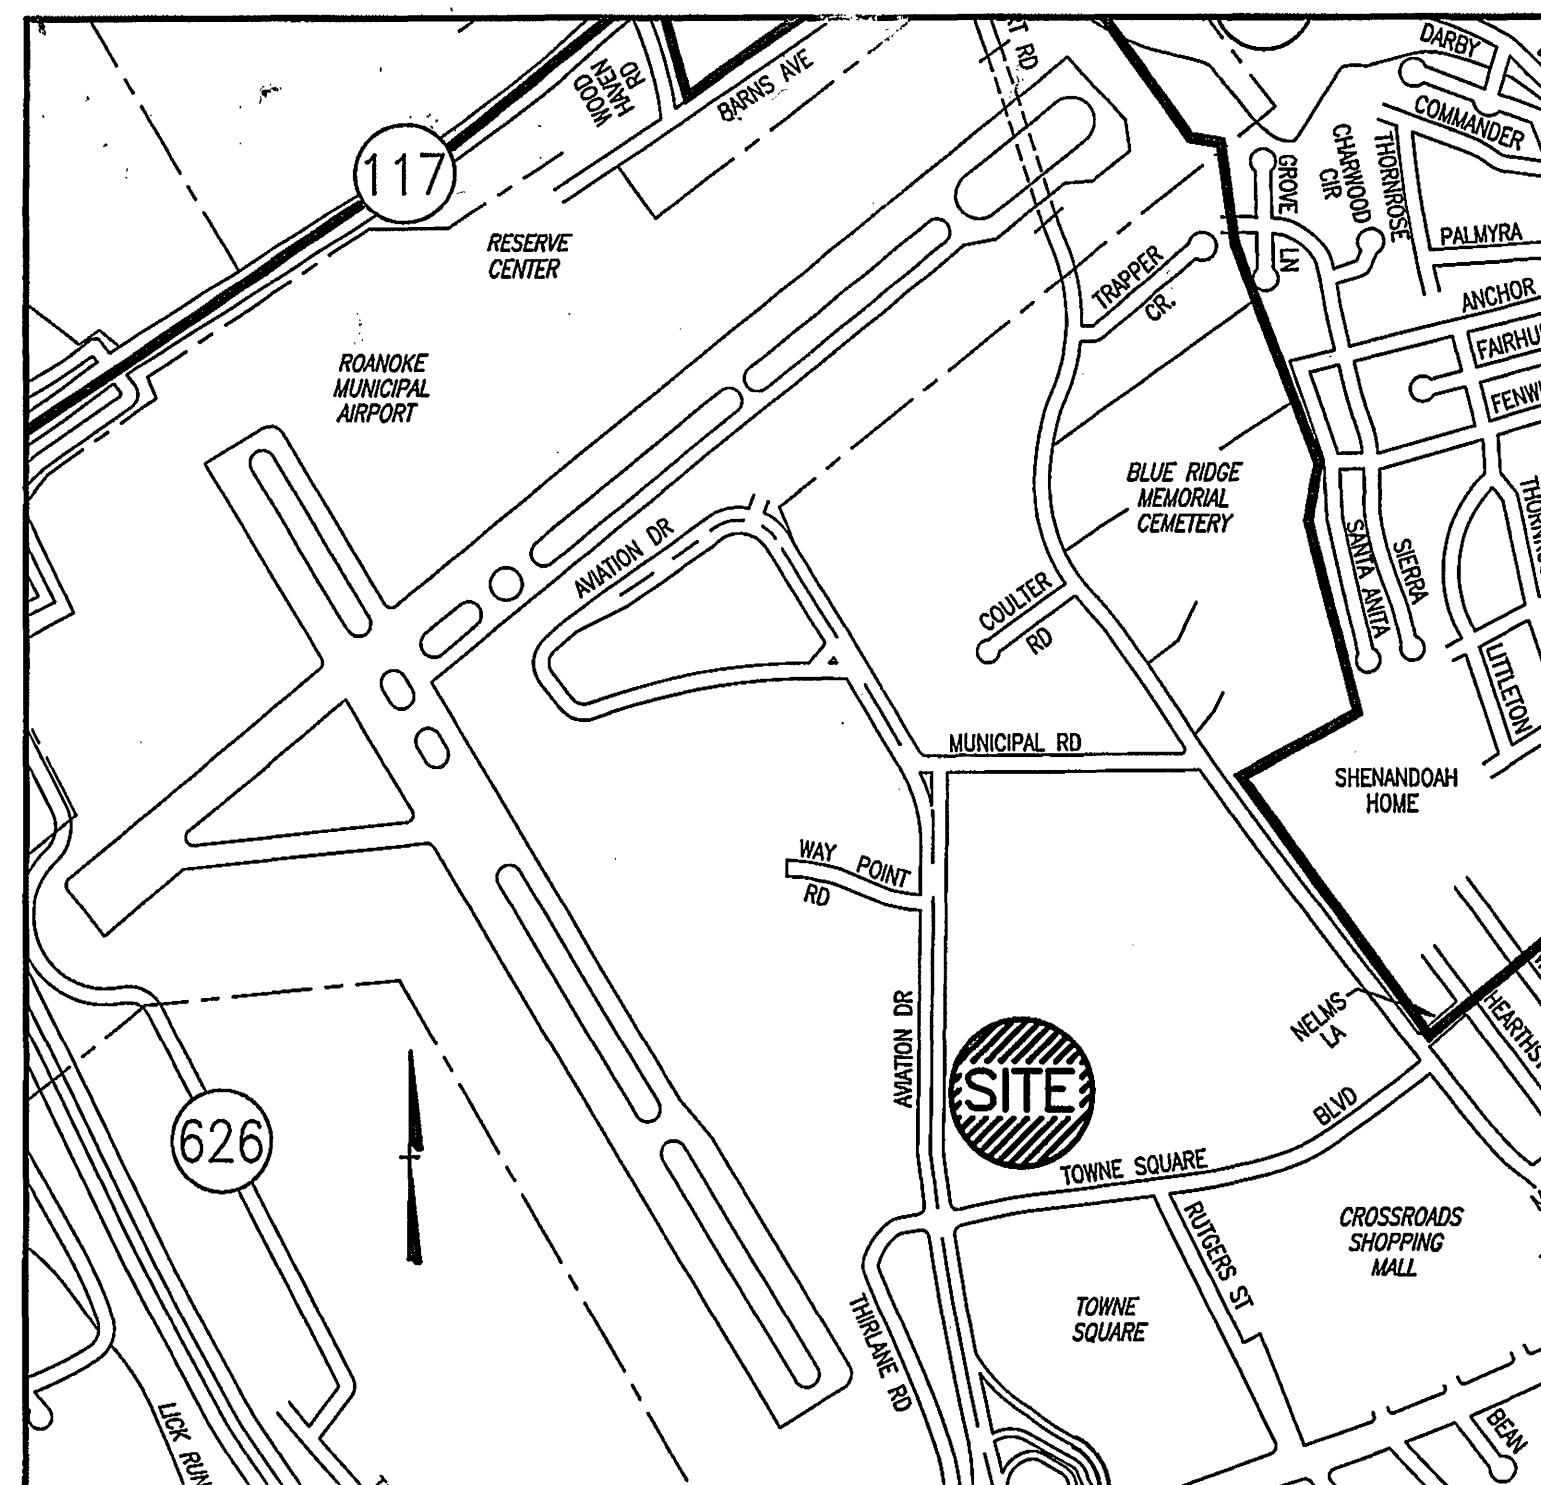

LOCATION MAP
SCALE: NONE

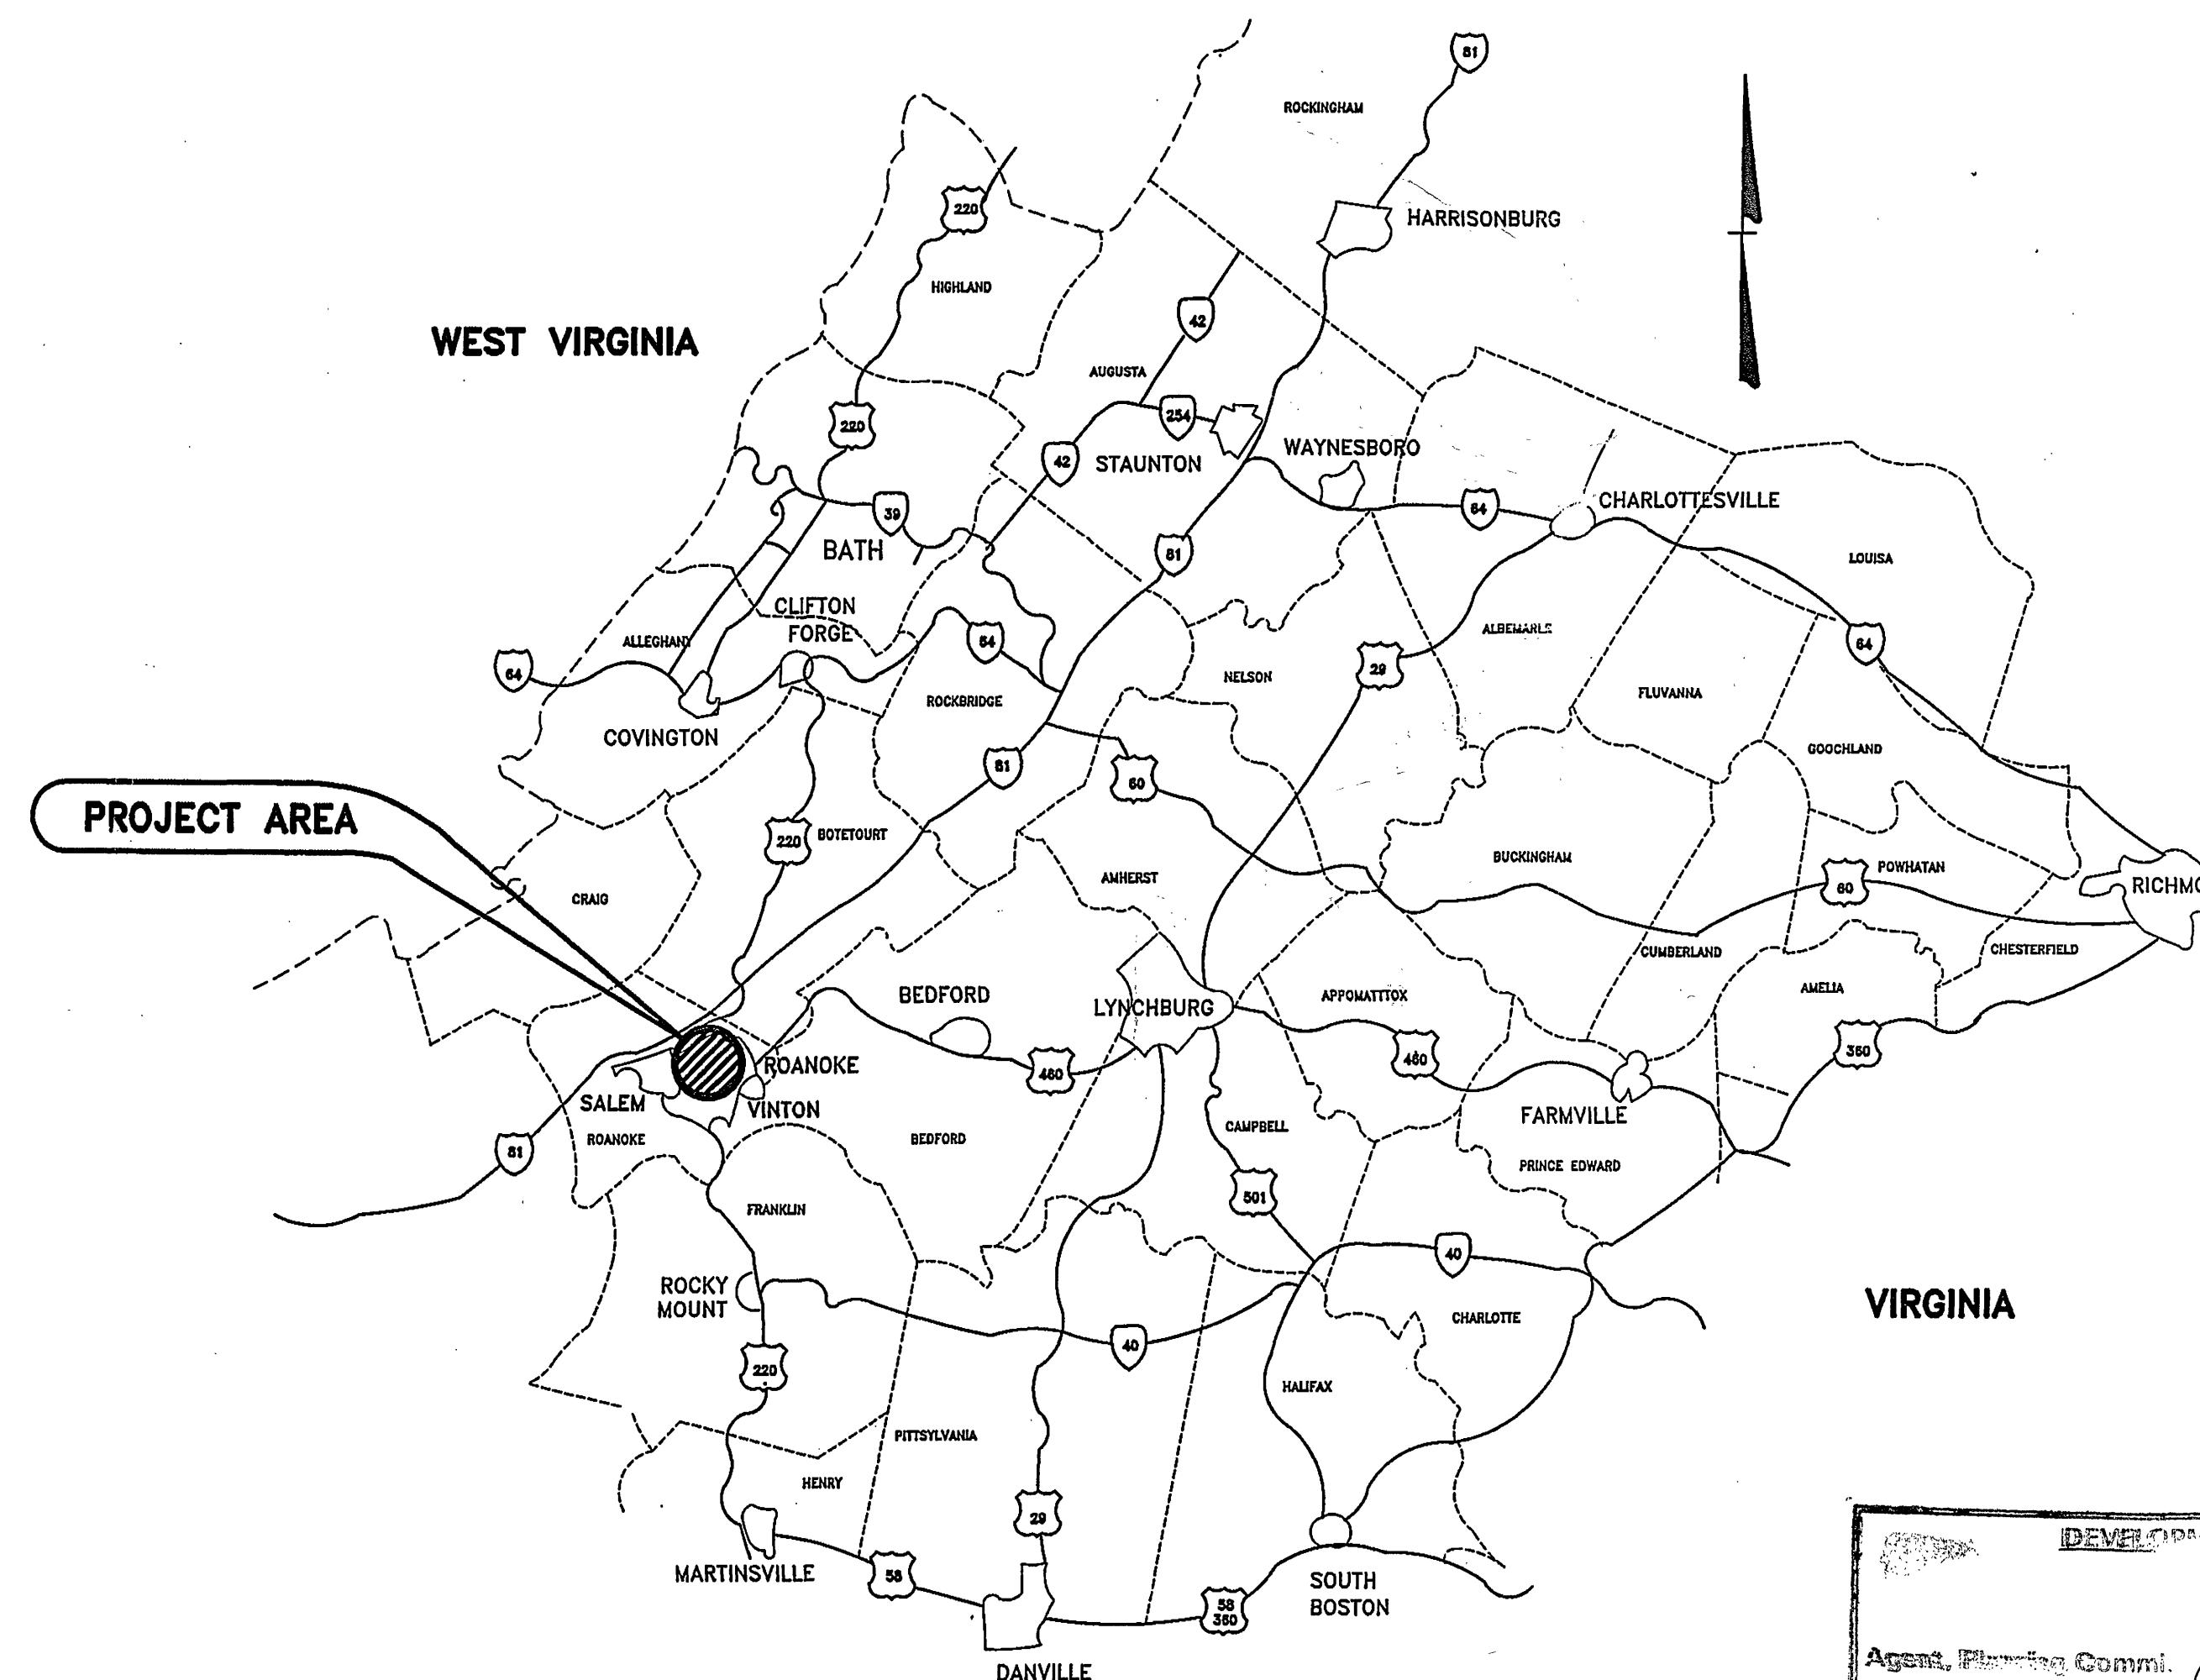


VICINITY MAP FOR
CITY OF ROANOKE, VIRGINIA
SCALE: NONE

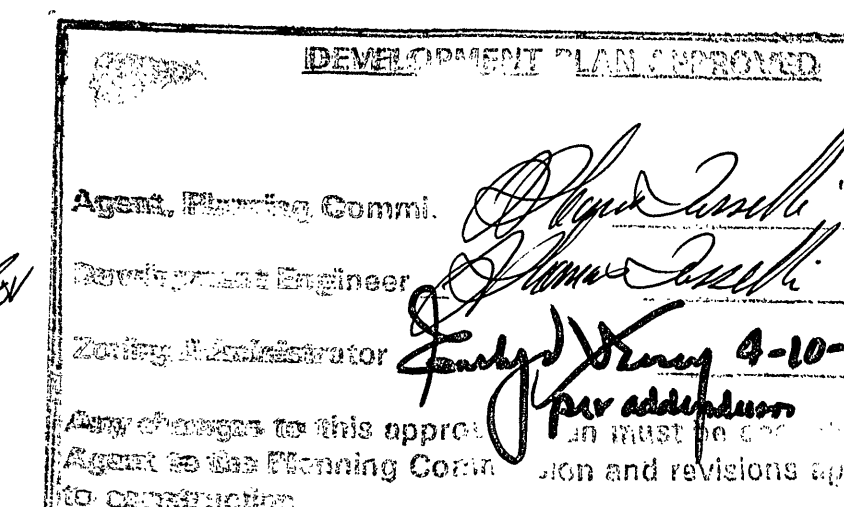

Mattern & Craig, Inc.
CONSULTING ENGINEERS • SURVEYORS
701 FIRST STREET, S.W.
ROANOKE, VIRGINIA 24016
(540) 345-9342
(540) 345-7691 FAX

SET NO. _____

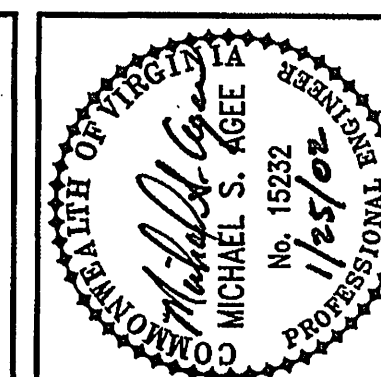

Date	
Revisions	
Issue Date:	AUGUST, 2001
Drawn By:	DEC
Designed By:	JB/RM
Checked By:	MSA
Date:	JAN., 2002

Mattern & Craig
CONSULTING ENGINEERS • SURVEYORS
701 FIRST STREET, S.W.
ROANOKE, VIRGINIA 24016
(540) 345-9342
FAX (540) 345-7691

ROANOKE REGIONAL AIRPORT - OVERFLOW
PARKING LOT MODIFICATIONS & ADDITION
COVER SHEET
ROANOKE, VIRGINIA

Horizontal Scale:	N/A
Commission Number:	1930H
Sheet No.:	C1