



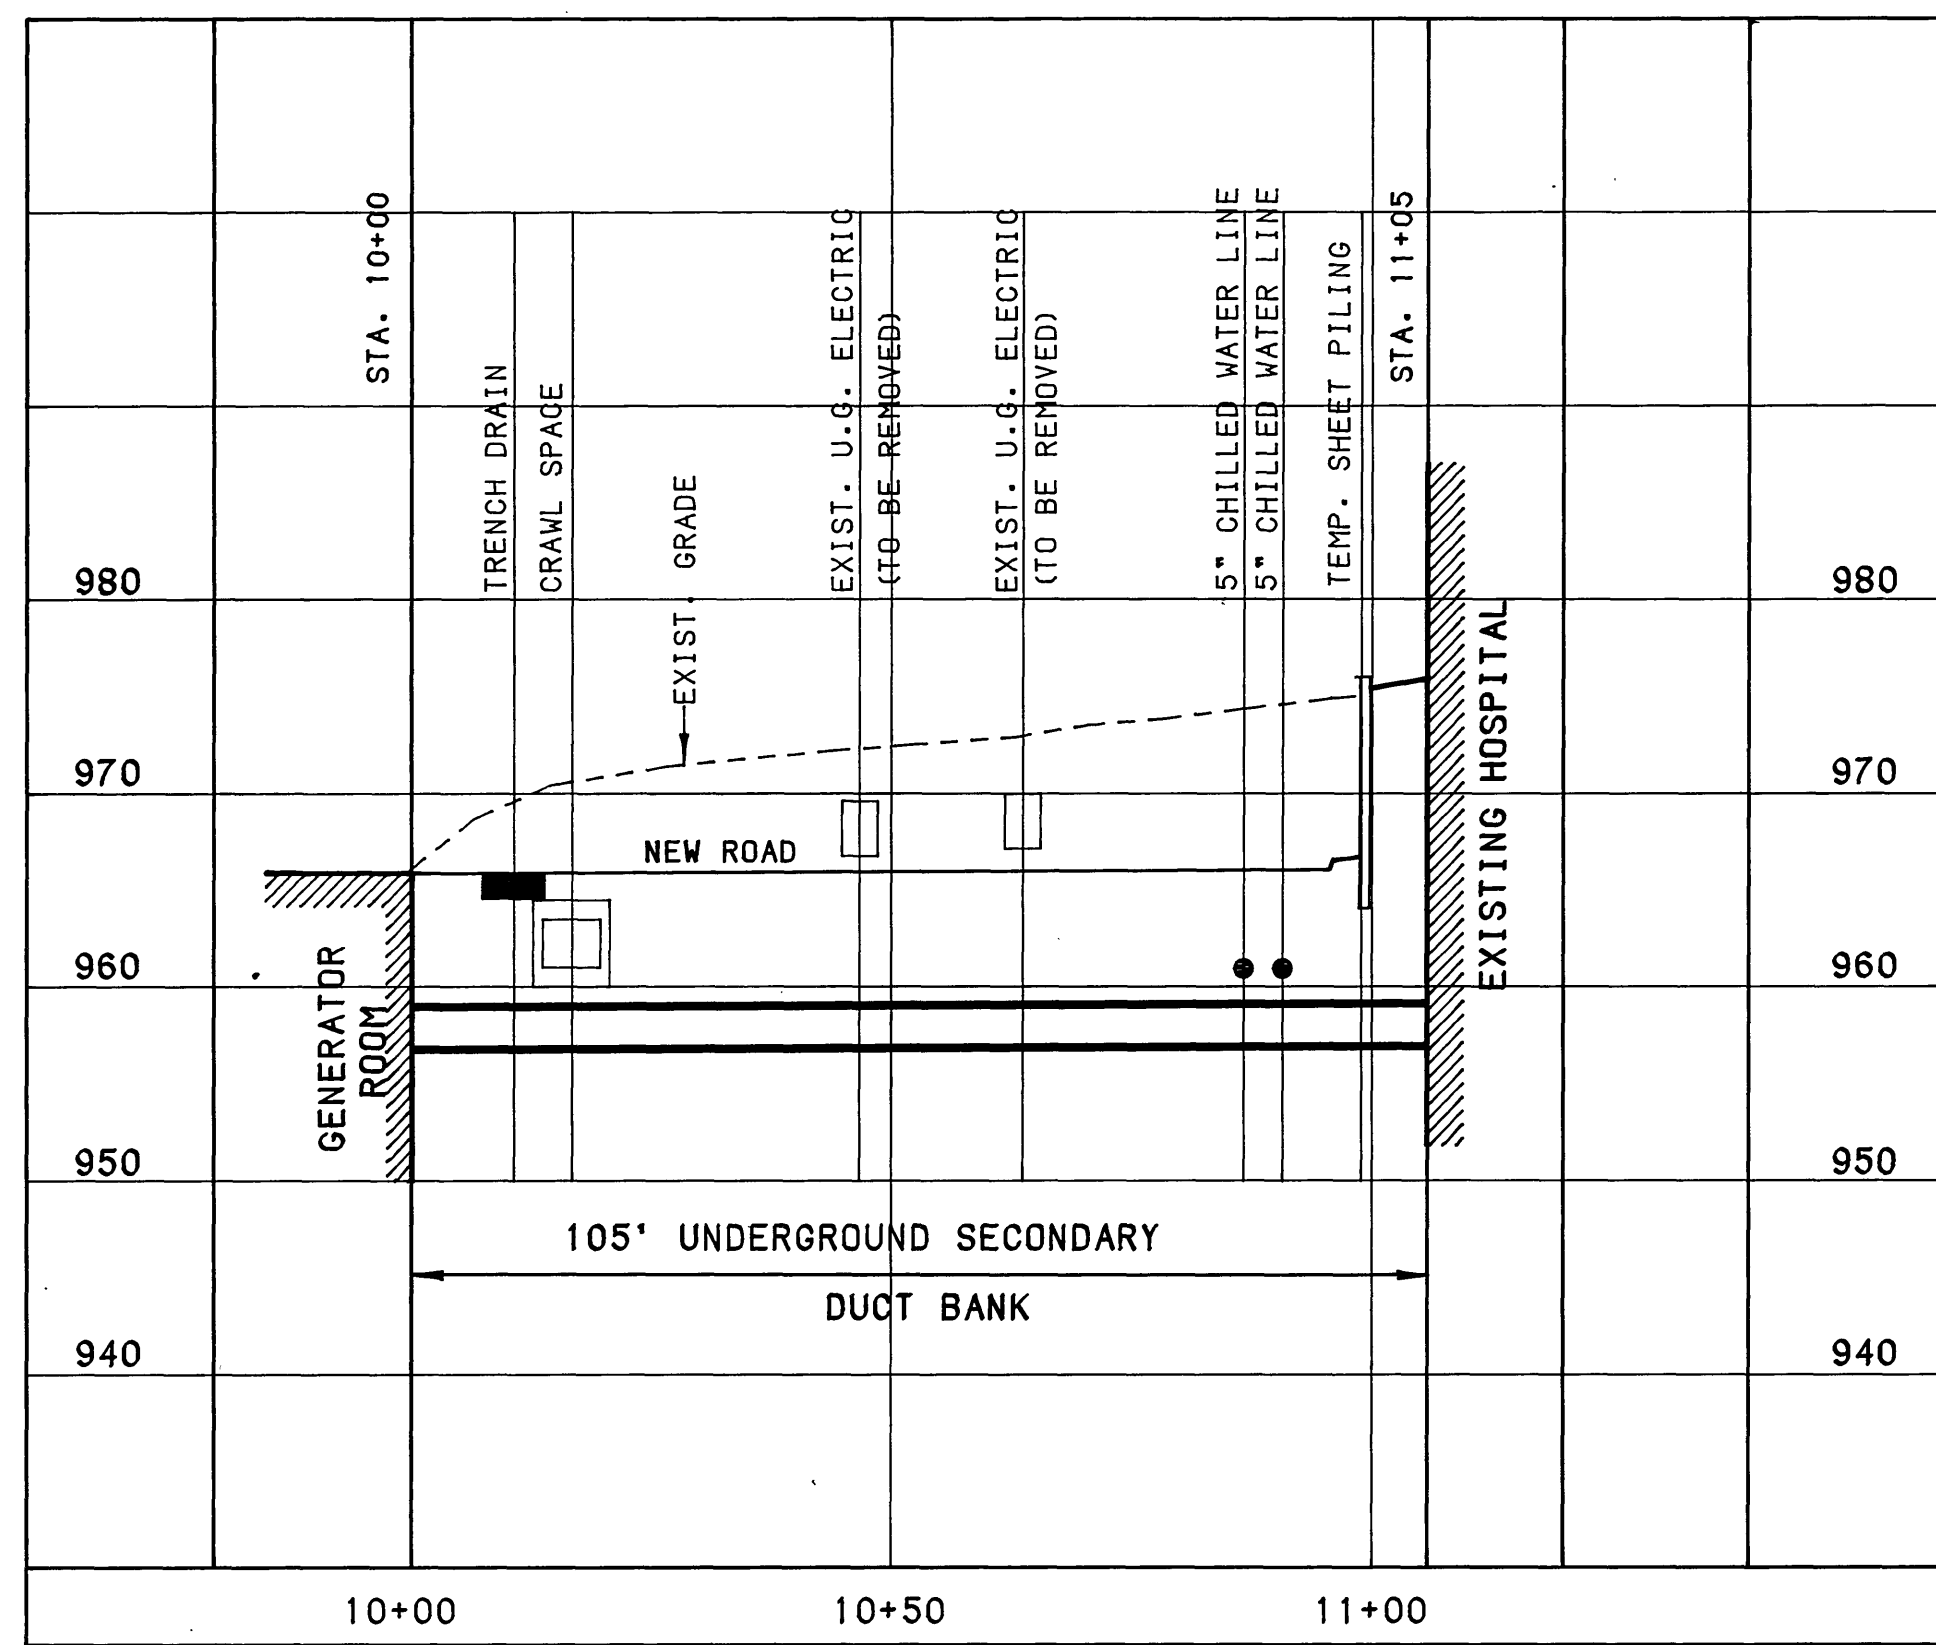


UNDERGROUND SECONDARY DUCT BANK - LINE "B"

SCALE: 1" = 20' HORIZ.
1" = 10' VERT.

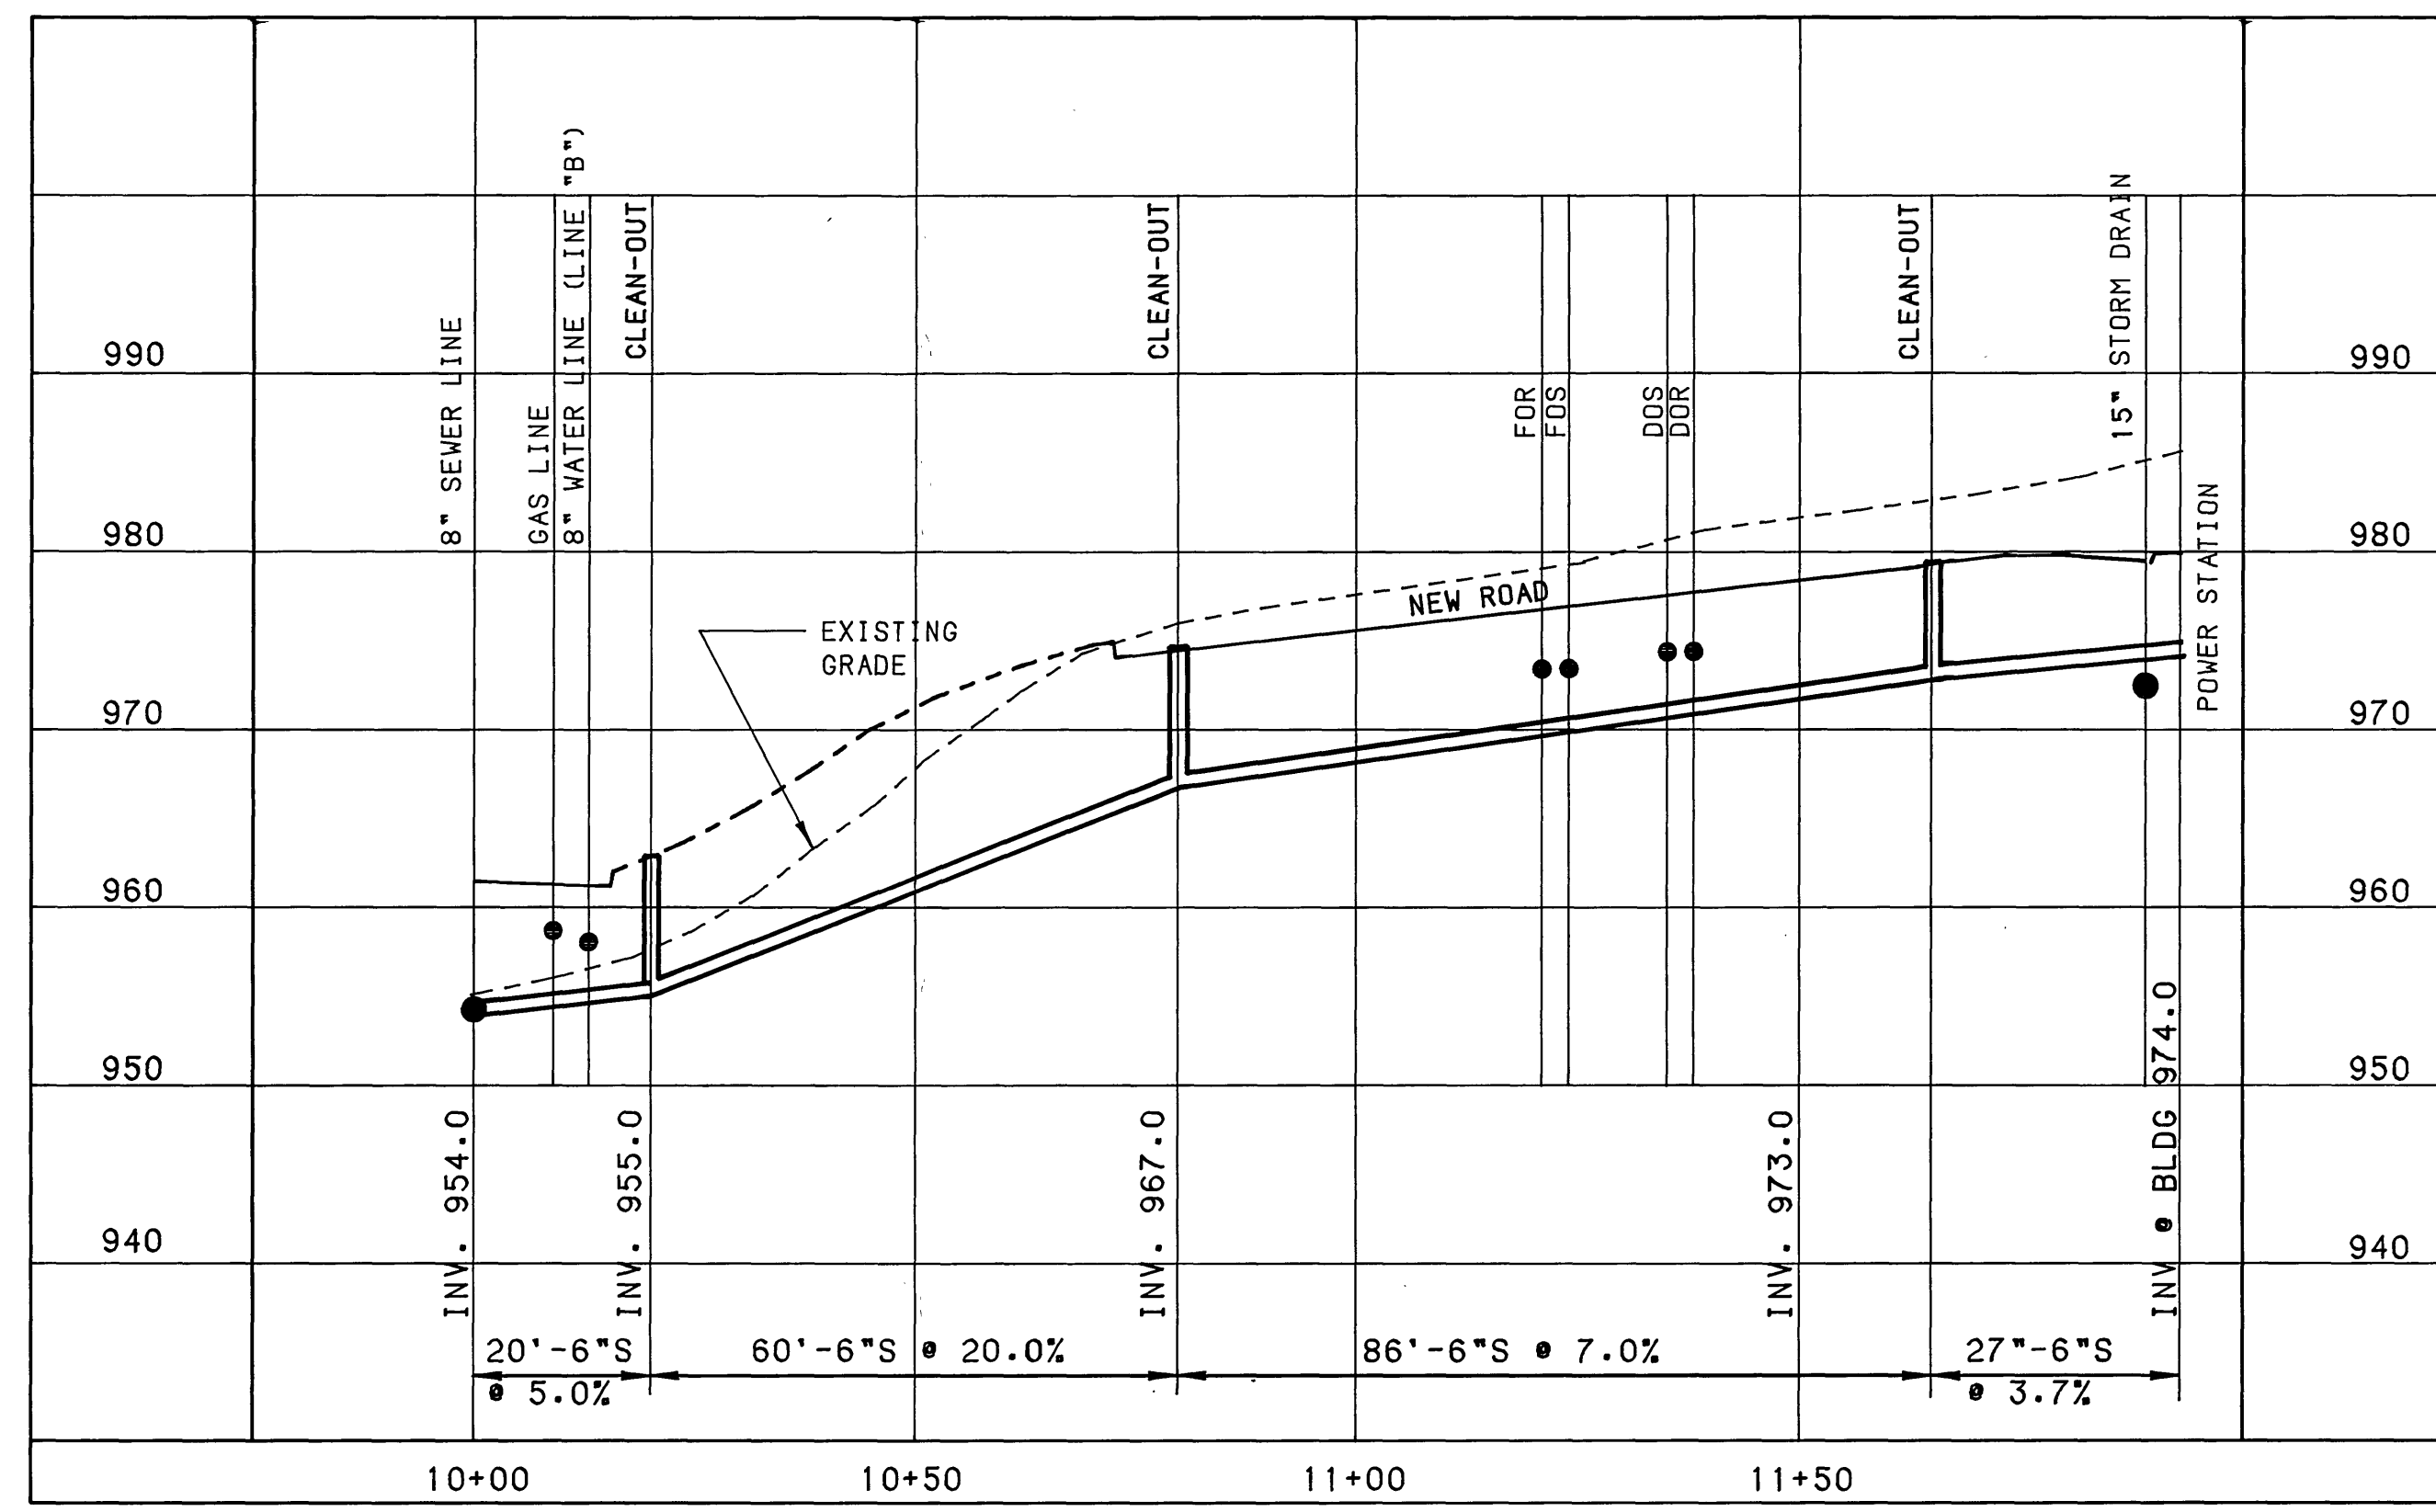


POWER PLANT SEWER LINE PROFILE

SCALE: 1" = 20' HORIZ.
1" = 10' VERT.

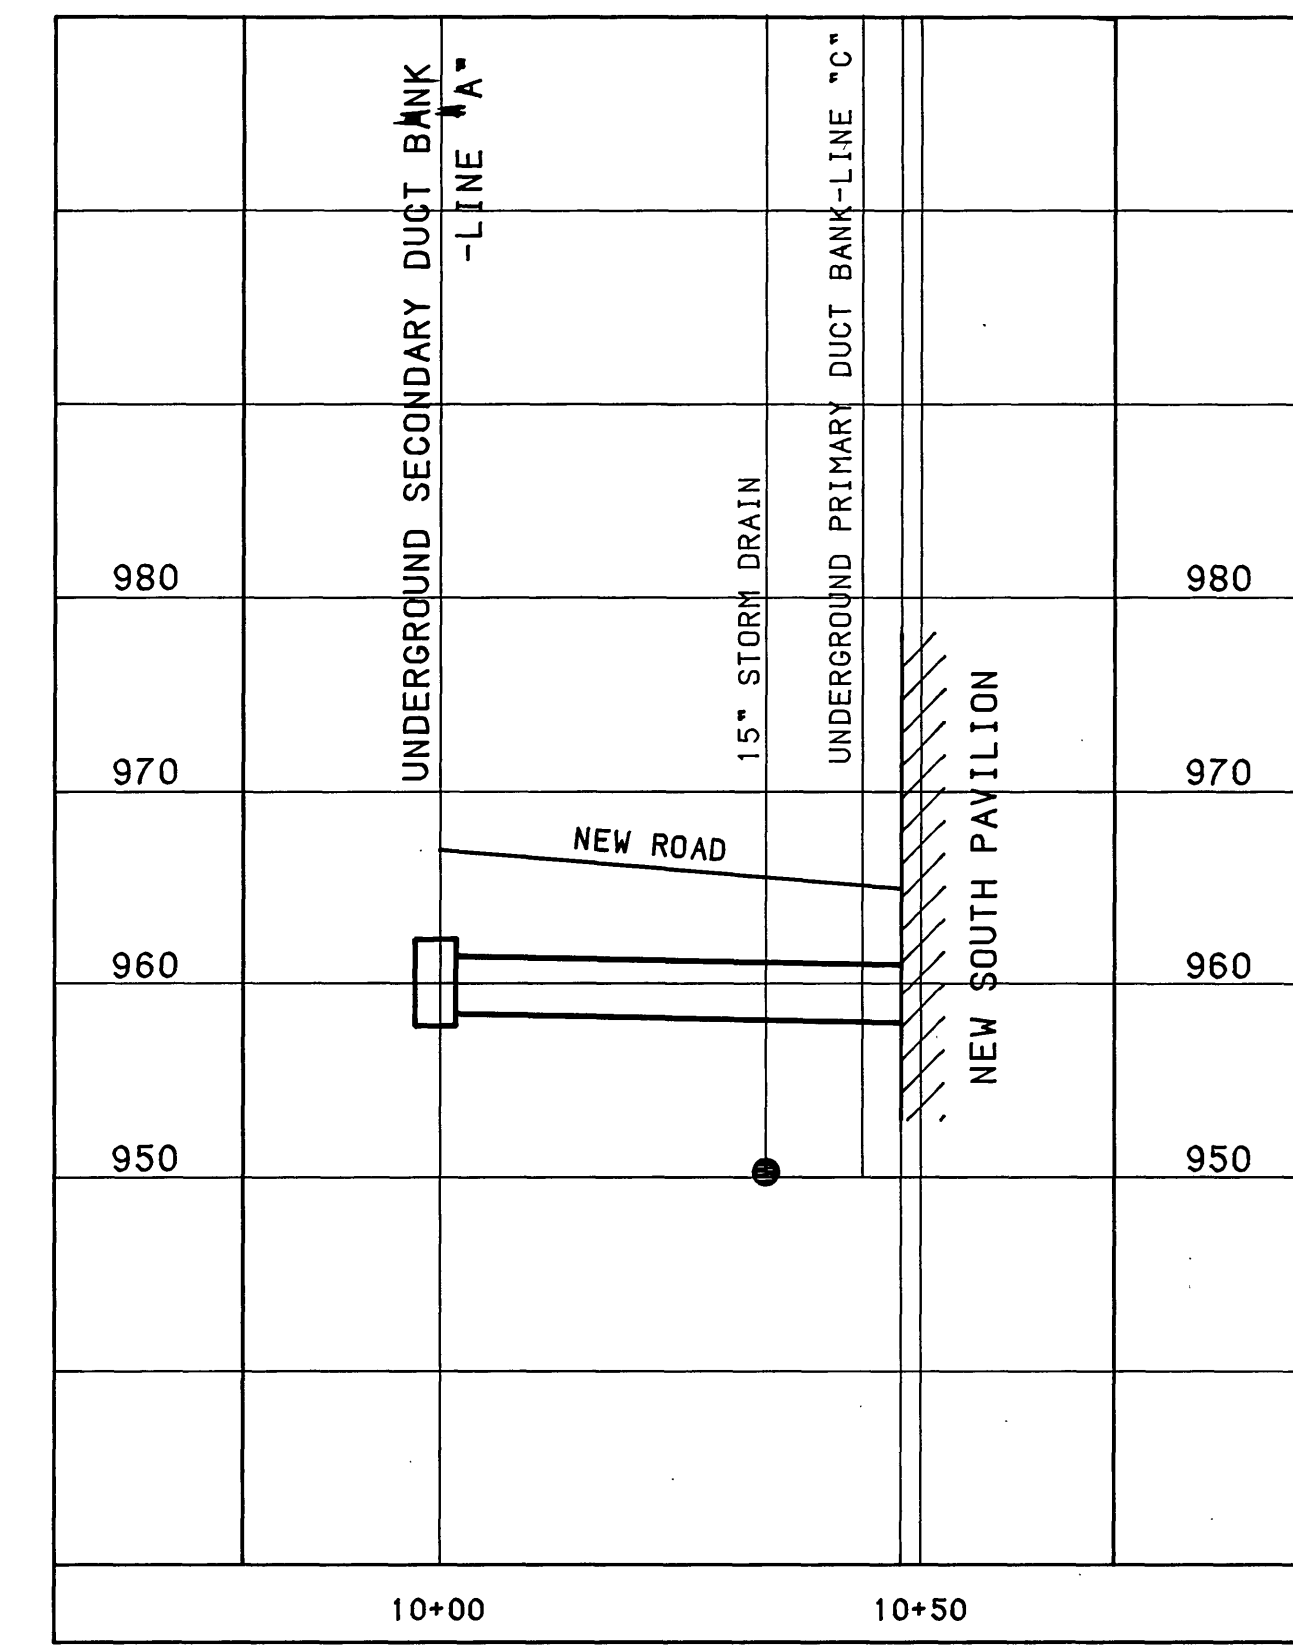


UNDERGROUND SECONDARY DUCT BANK

SCALE: 1" = 20' HORIZ.
1" = 10' VERT.

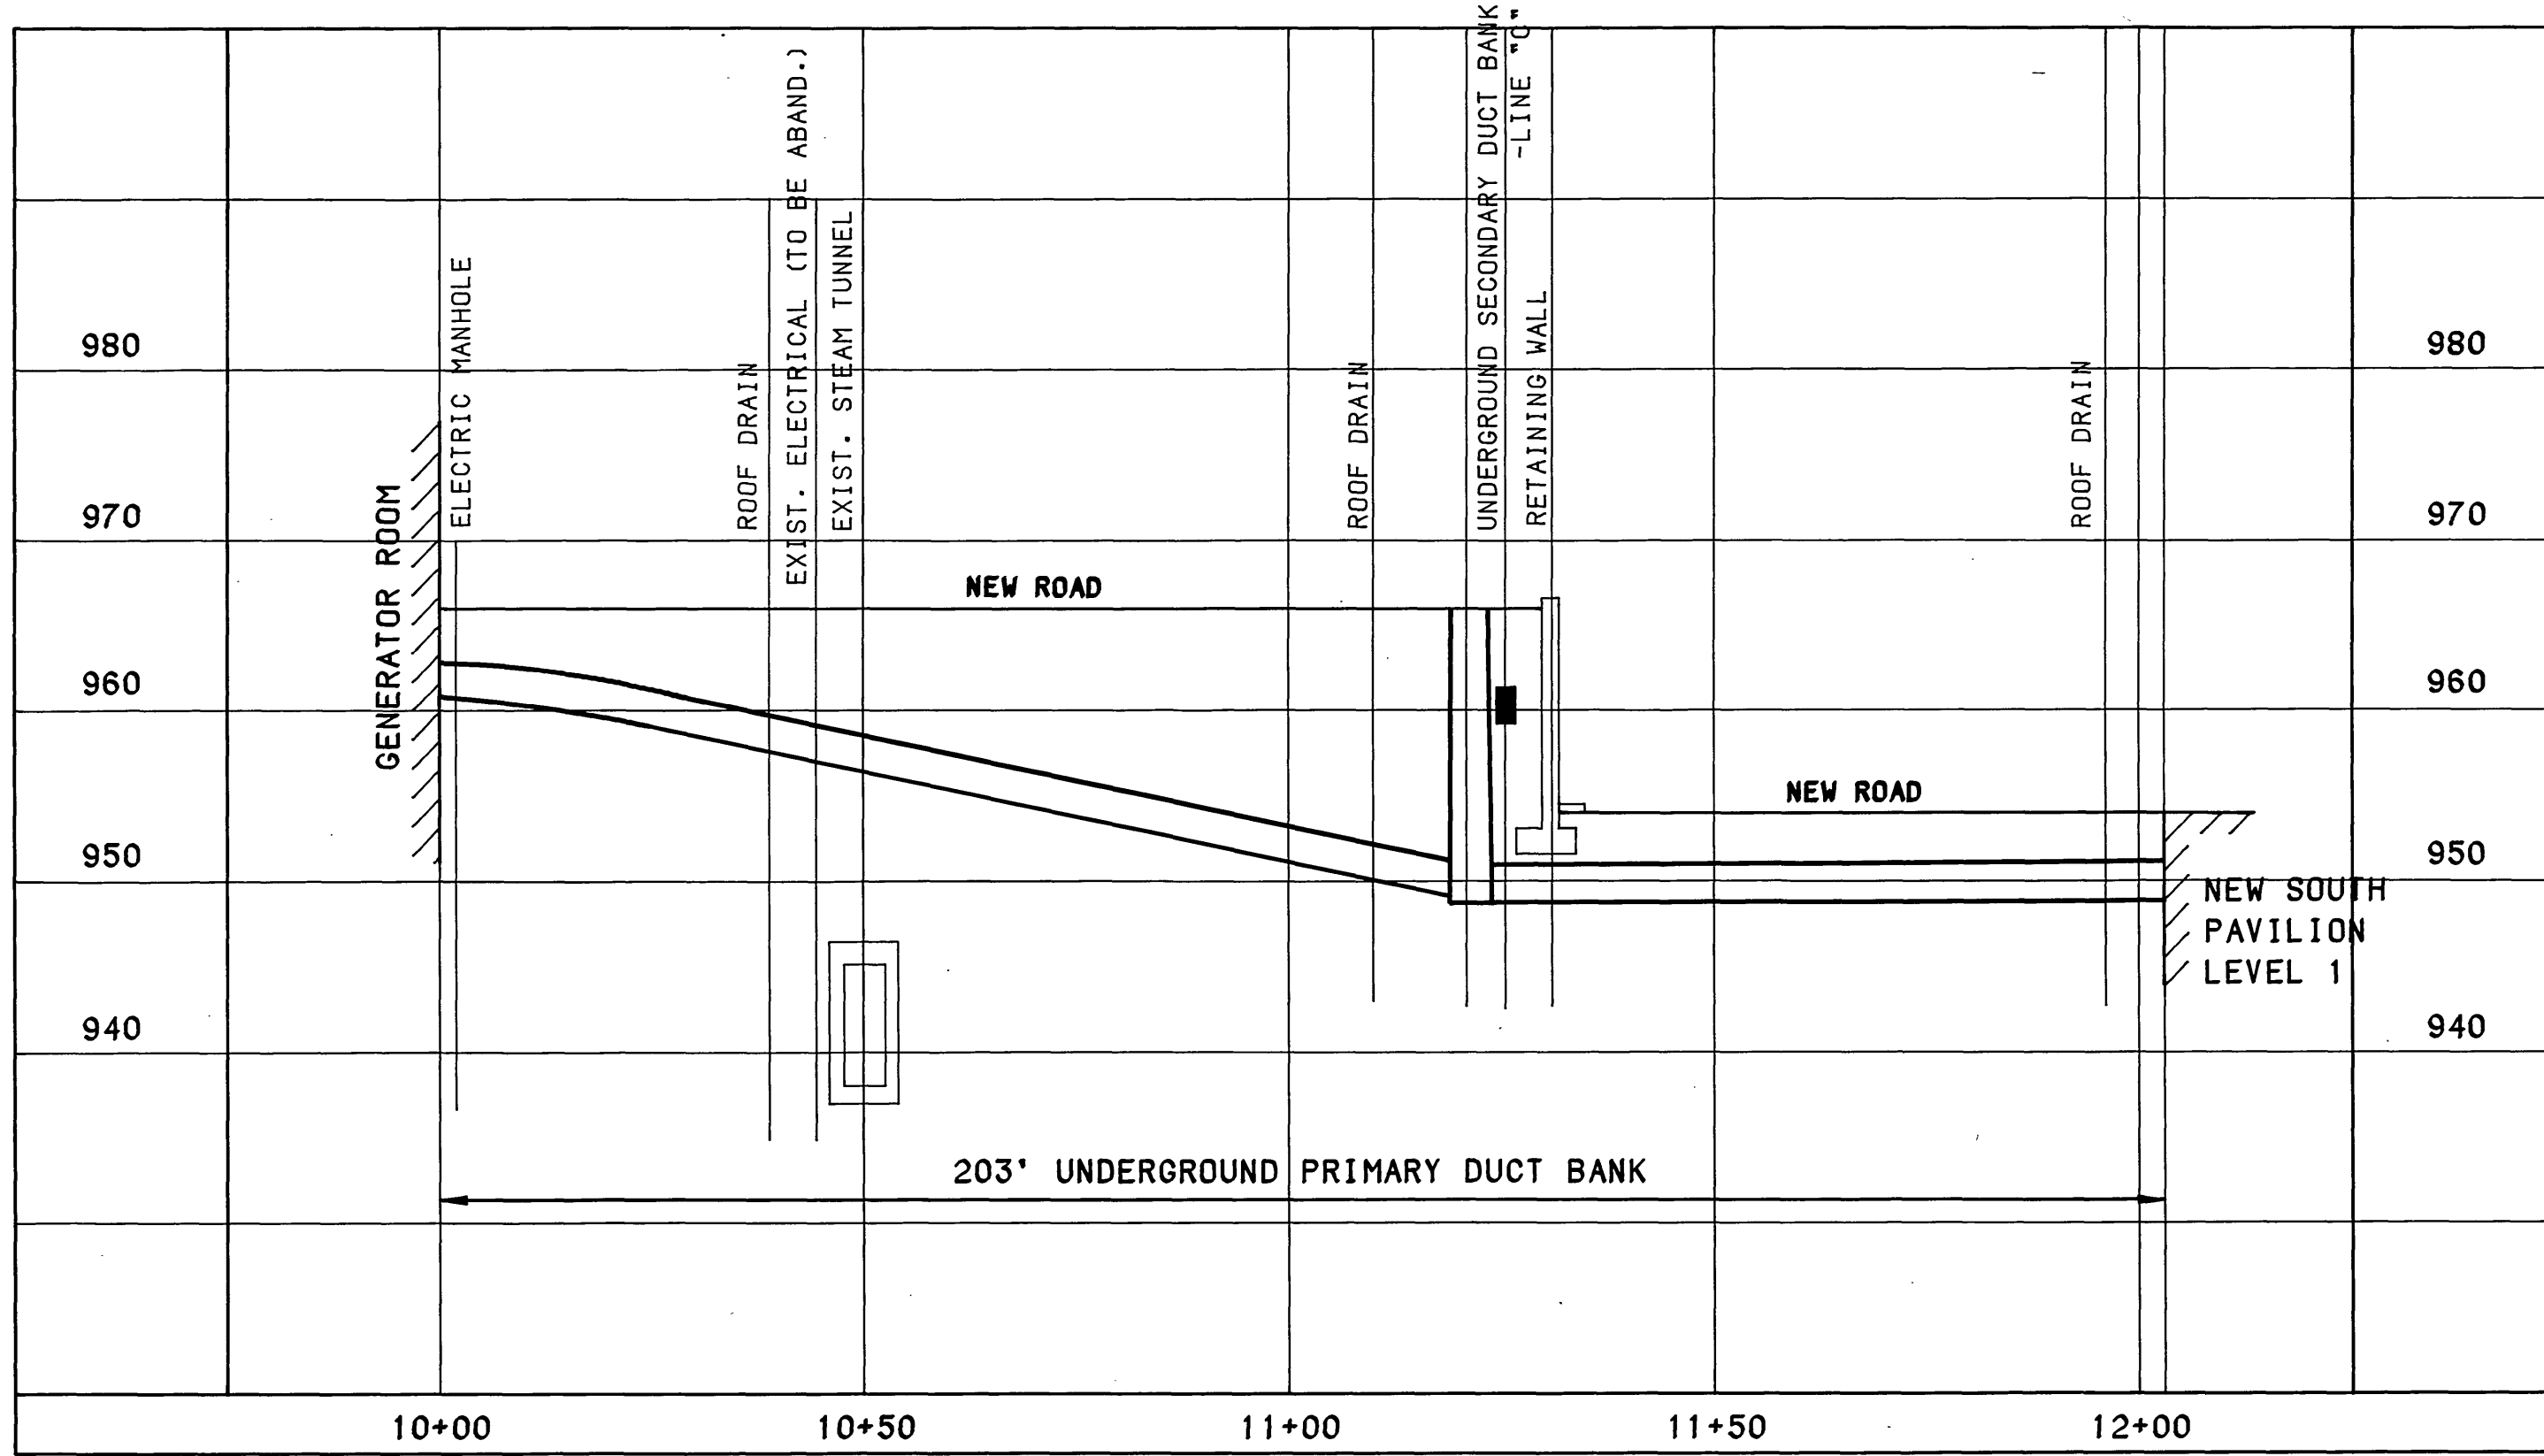


UNDERGROUND PRIMARY DUCT BANK - LINE "C"

SCALE: 1" = 20' HORIZ.
1" = 10' VERT.

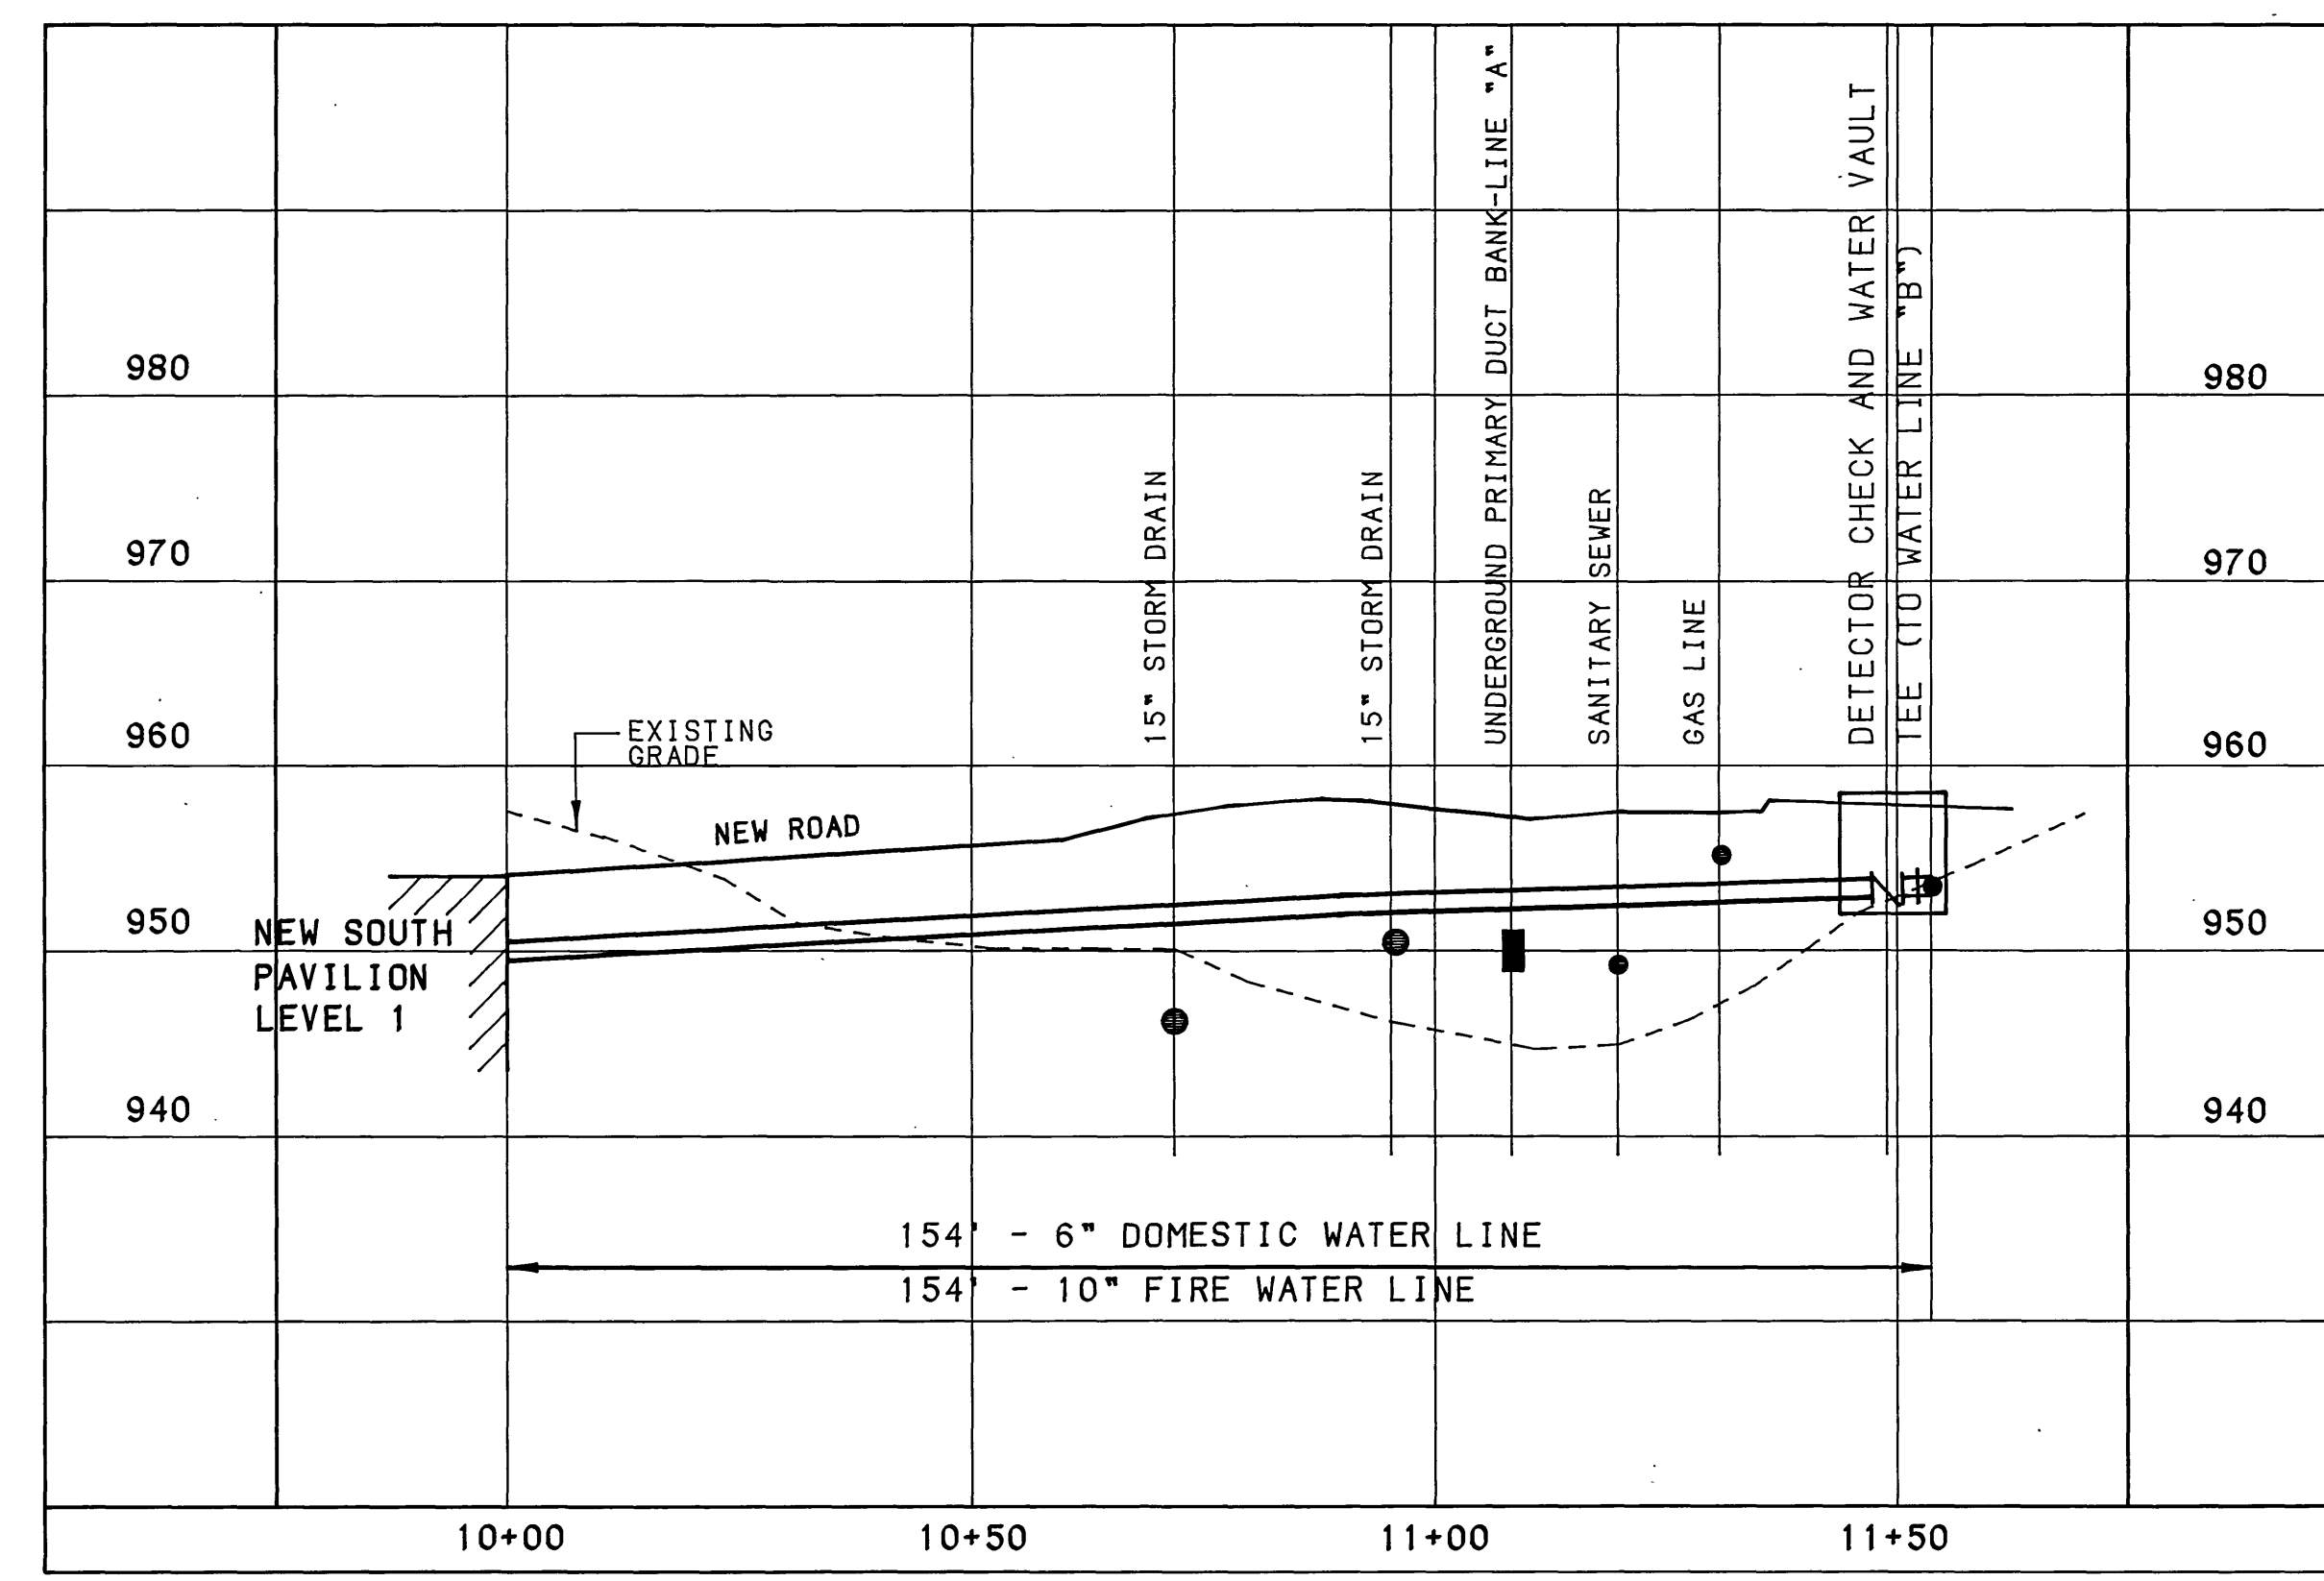

DOMESTIC AND FIRE WATER LINE PROFILES

SCALE: 1" = 20' HORIZ.
1" = 10' VERT.

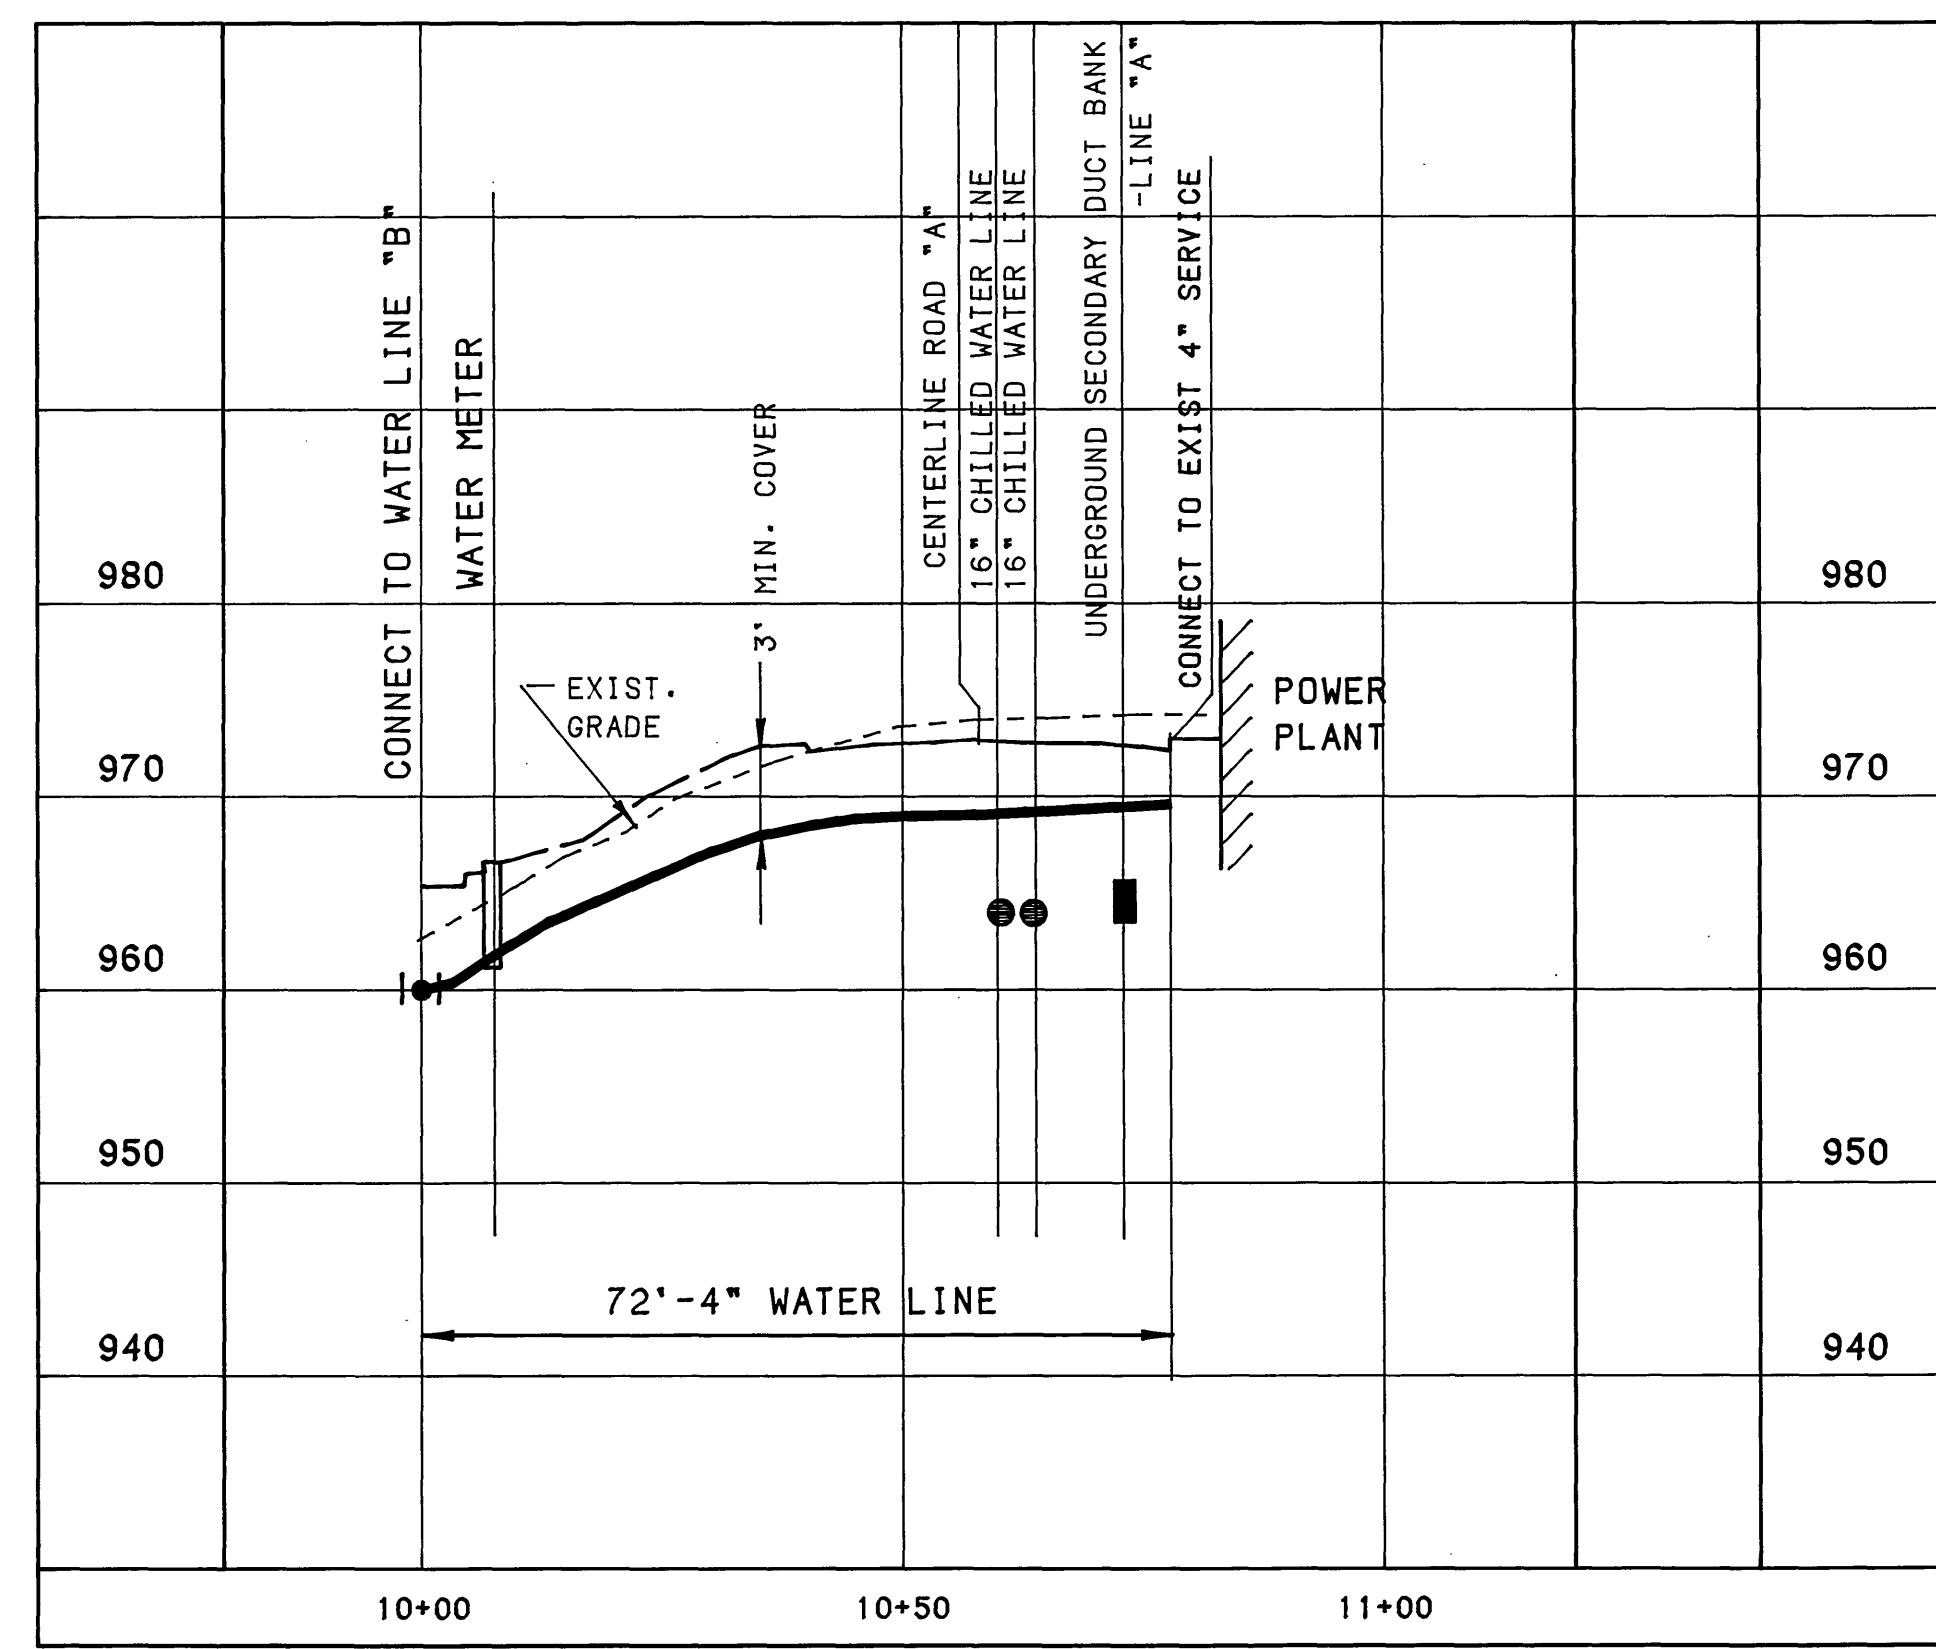

POWER PLANT WATER LINE PROFILE

SCALE: 1" = 20' HORIZ.
1" = 10' VERT.

