
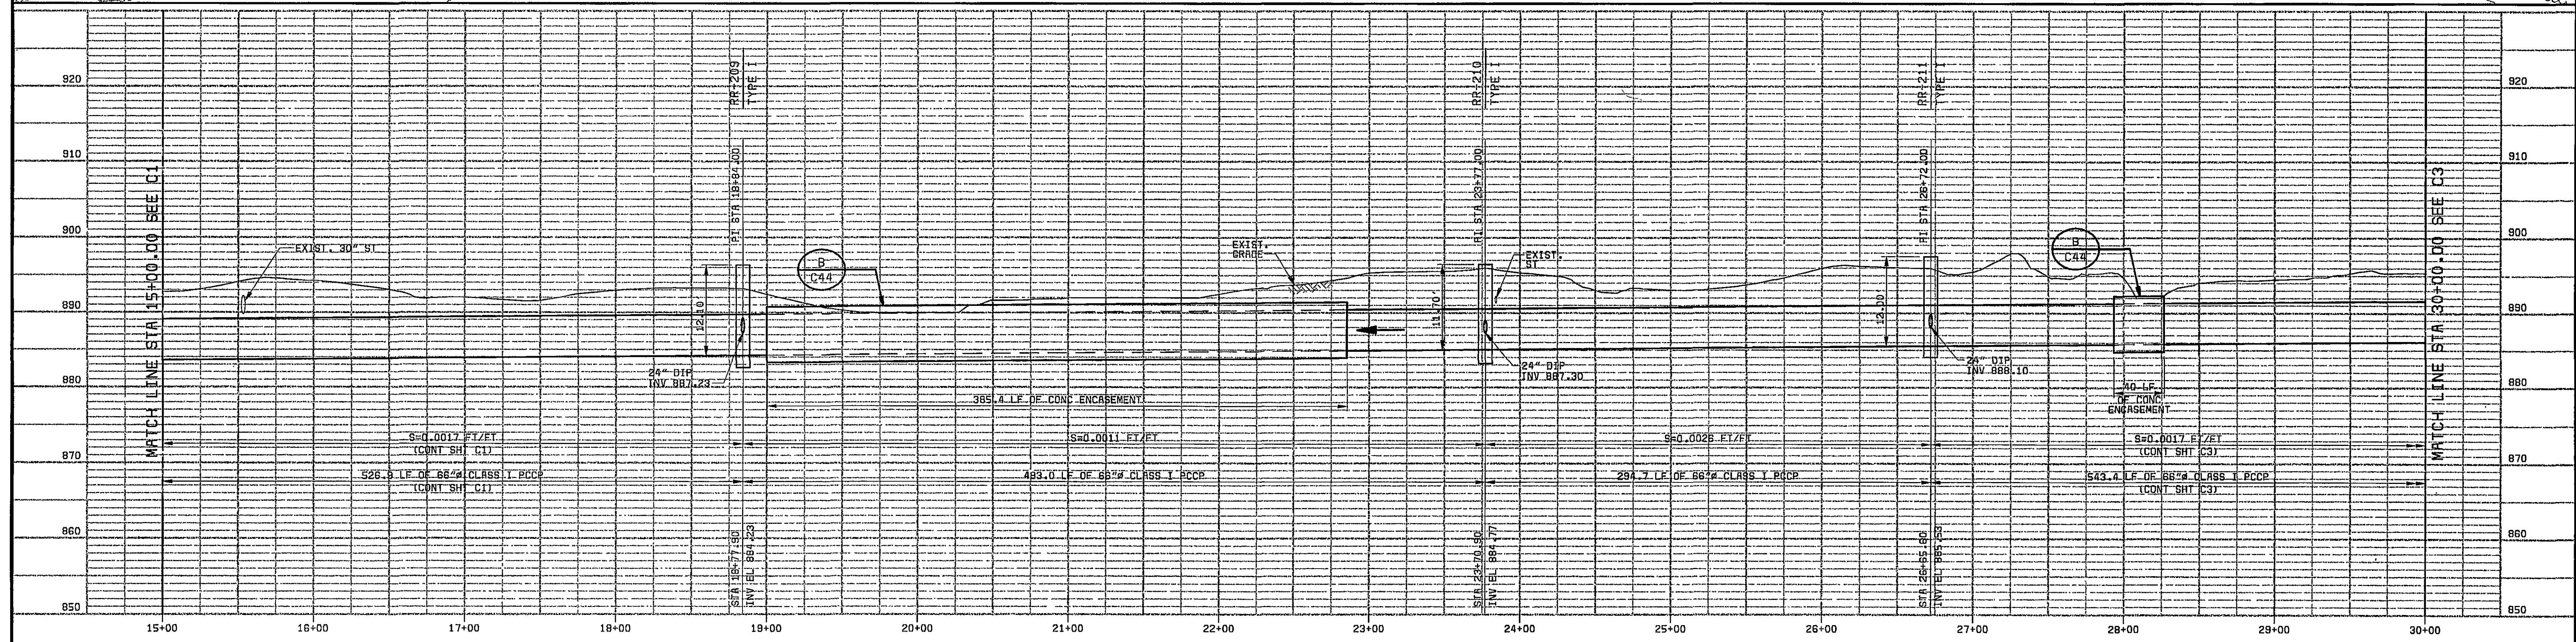


26444-300-WNC3-C-80000011B
G1031
F000000

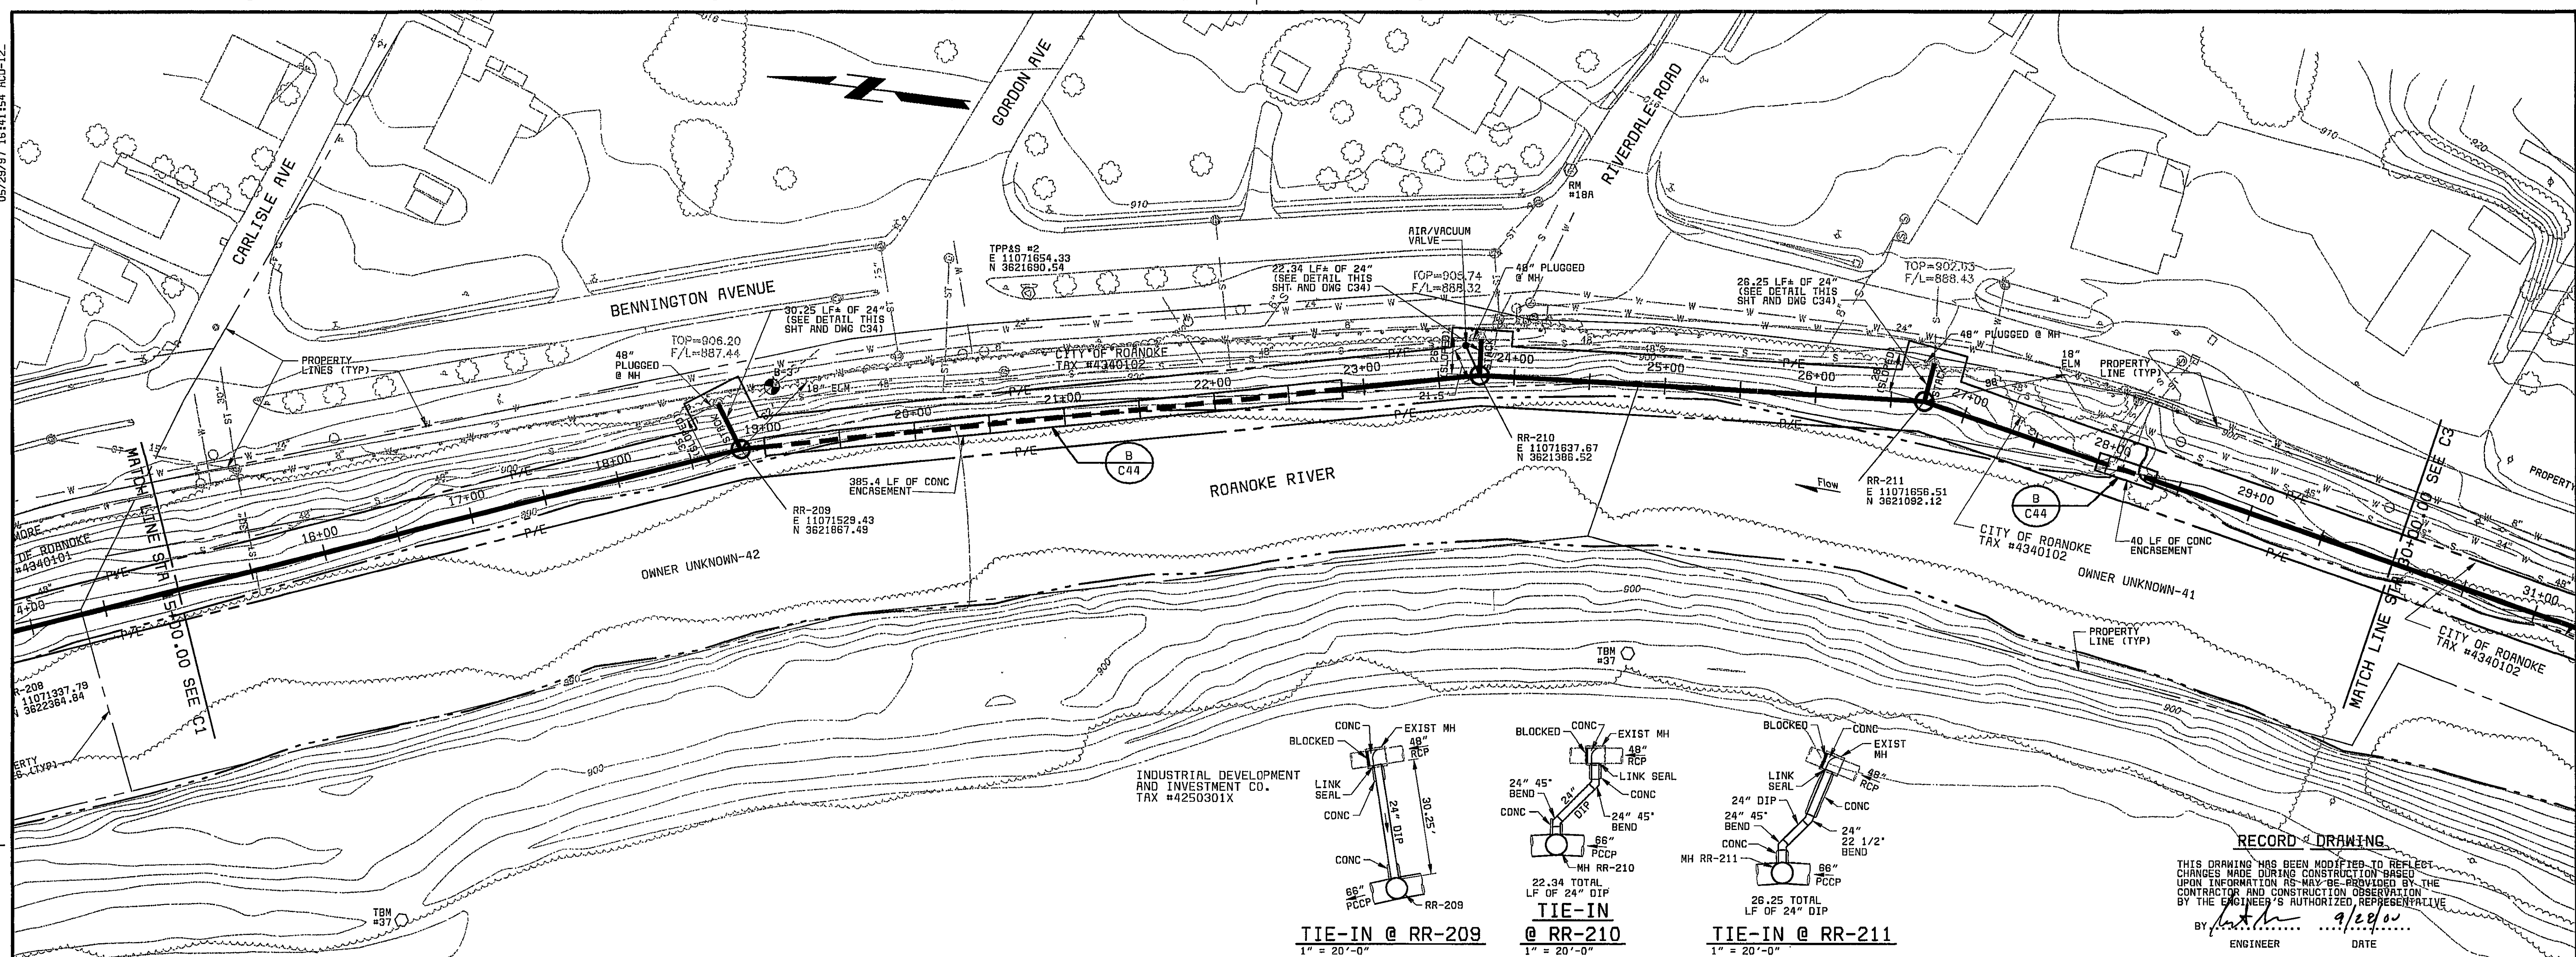

MANHOLE STATIONING AND PIPE LENGTHS:
SEE GENERAL NOTE 16

PCCP PIPE CLASS INFORMATION:
SEE DRAWING C43

SCALE: 1" = 50' HORIZ
1" = 10' VERT

CITY OF ROANOKE, VIRGINIA ROANOKE RIVER INTERCEPTOR		CONTRACT A1 C2 SHEET 5 OF 30
PLAN AND PROFILE STA 15+00 TO STA 30+00		

DESIGNED: JBB, SLF
DETAILED: RLC, ABW
CHECKED: RAF
APPROVED: _____
DATE: _____

Black & Veatch
Charlotte, North Carolina

PROJECT NO.
26444

THIS DOCUMENT
ORIGINALLY ISSUED
AND SEALED BY
BRENT M. REUSS
PROFESSIONAL ENGINEER,
COMMONWEALTH OF VIRGINIA
REGISTRATION NO. 026345
ON 5-30-97